


DATE	
BY	
REVISIONS	
NO.	
DATE	
BY	
DESCRIPTION	
PLANNING	
DESIGN	
CHECKING	
NOTES	
NO.	
DATE	
BY	
DESCRIPTION	

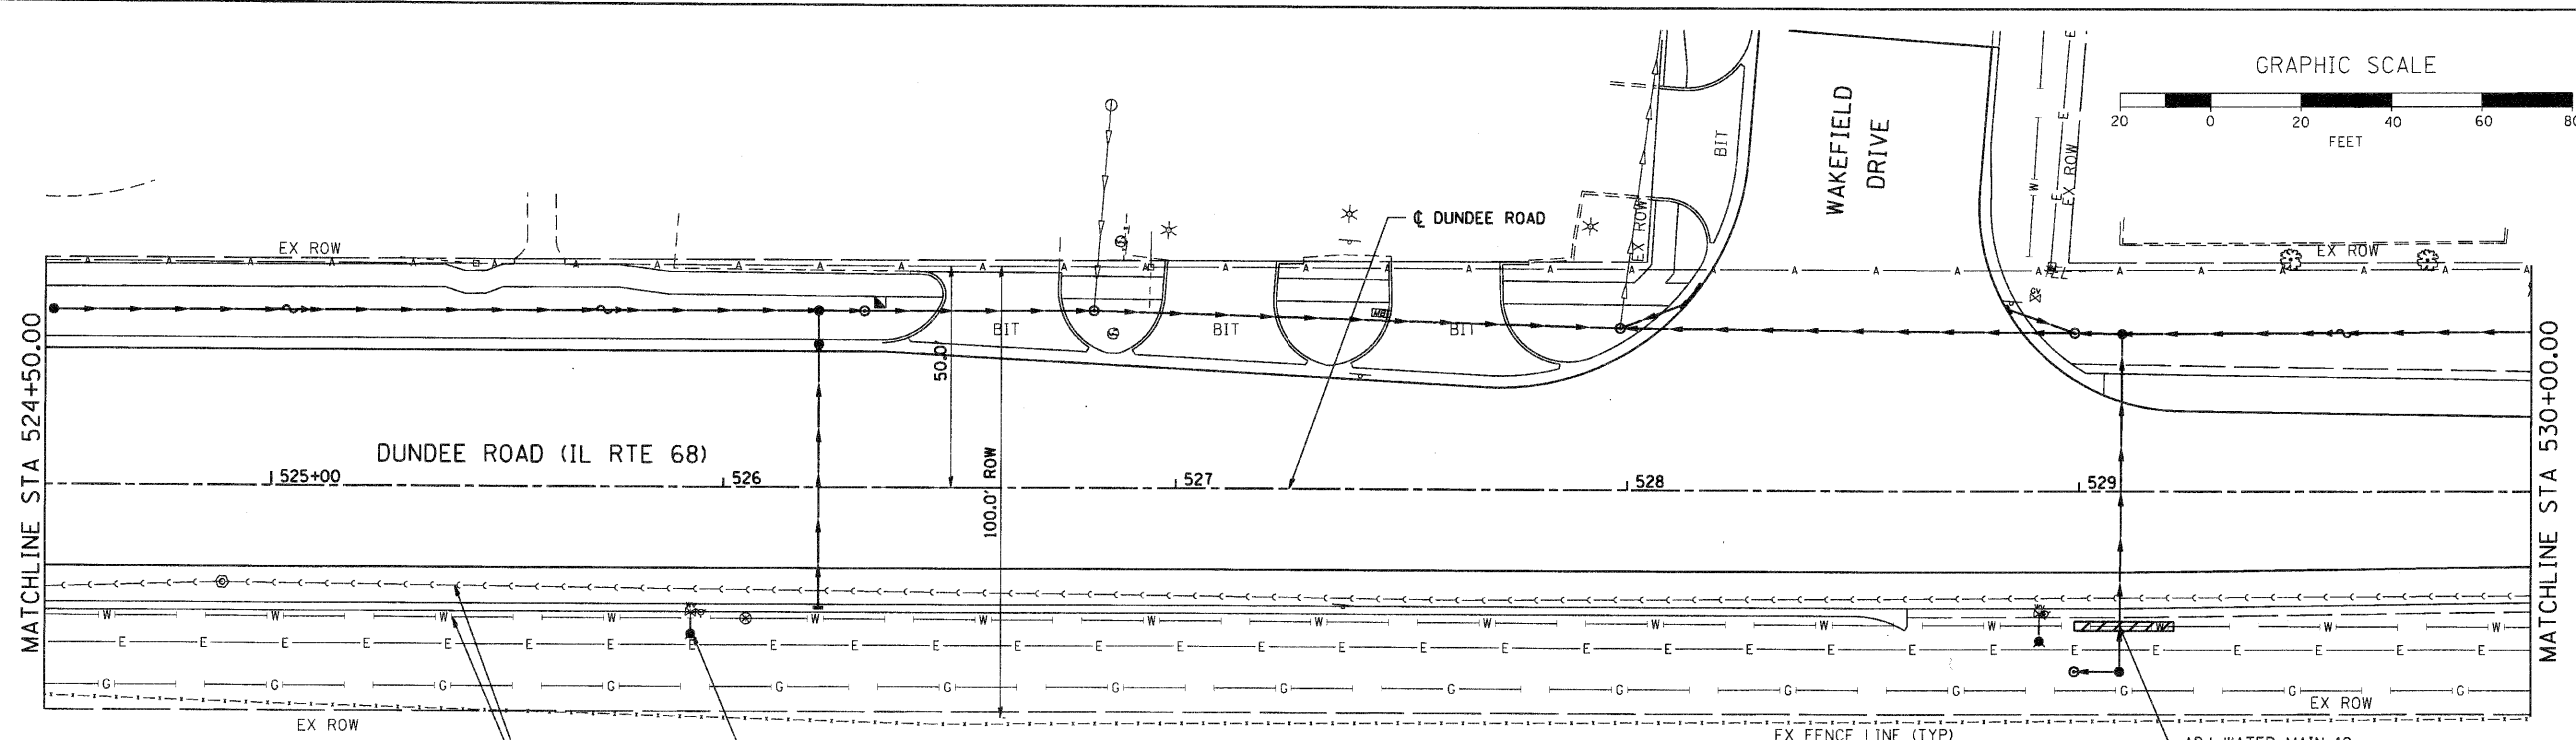


INSULATION MAT
WATER MAIN STA 518+50 TO STA 521+75
AND STA 524+00 TO STA 527+13

FIRE HYDRANTS TO BE MVD (TYP)
(FIRE HYDRANTS TO BE MOVED TO
PROVIDE ADEQUATE HORIZONTAL CLEAR ZONE
FROM THE PAVEMENT.)

LEGEND	
■	LINE STOP
●	VALVE IN VAULT
⊕	VALVE IN BOX
■	BUFFALO BOX
▨	CASING
▼	FIRE HYDRANT
▽	REDUCER
▲	CAP EXIST.
—	WATER MAIN

DATE	
BY	
REVISIONS	
NO.	
DATE	
BY	
DESCRIPTION	
PROFILE	
DESIGN	
CHECKING	
NOTES	
NO.	
DATE	
BY	
DESCRIPTION	

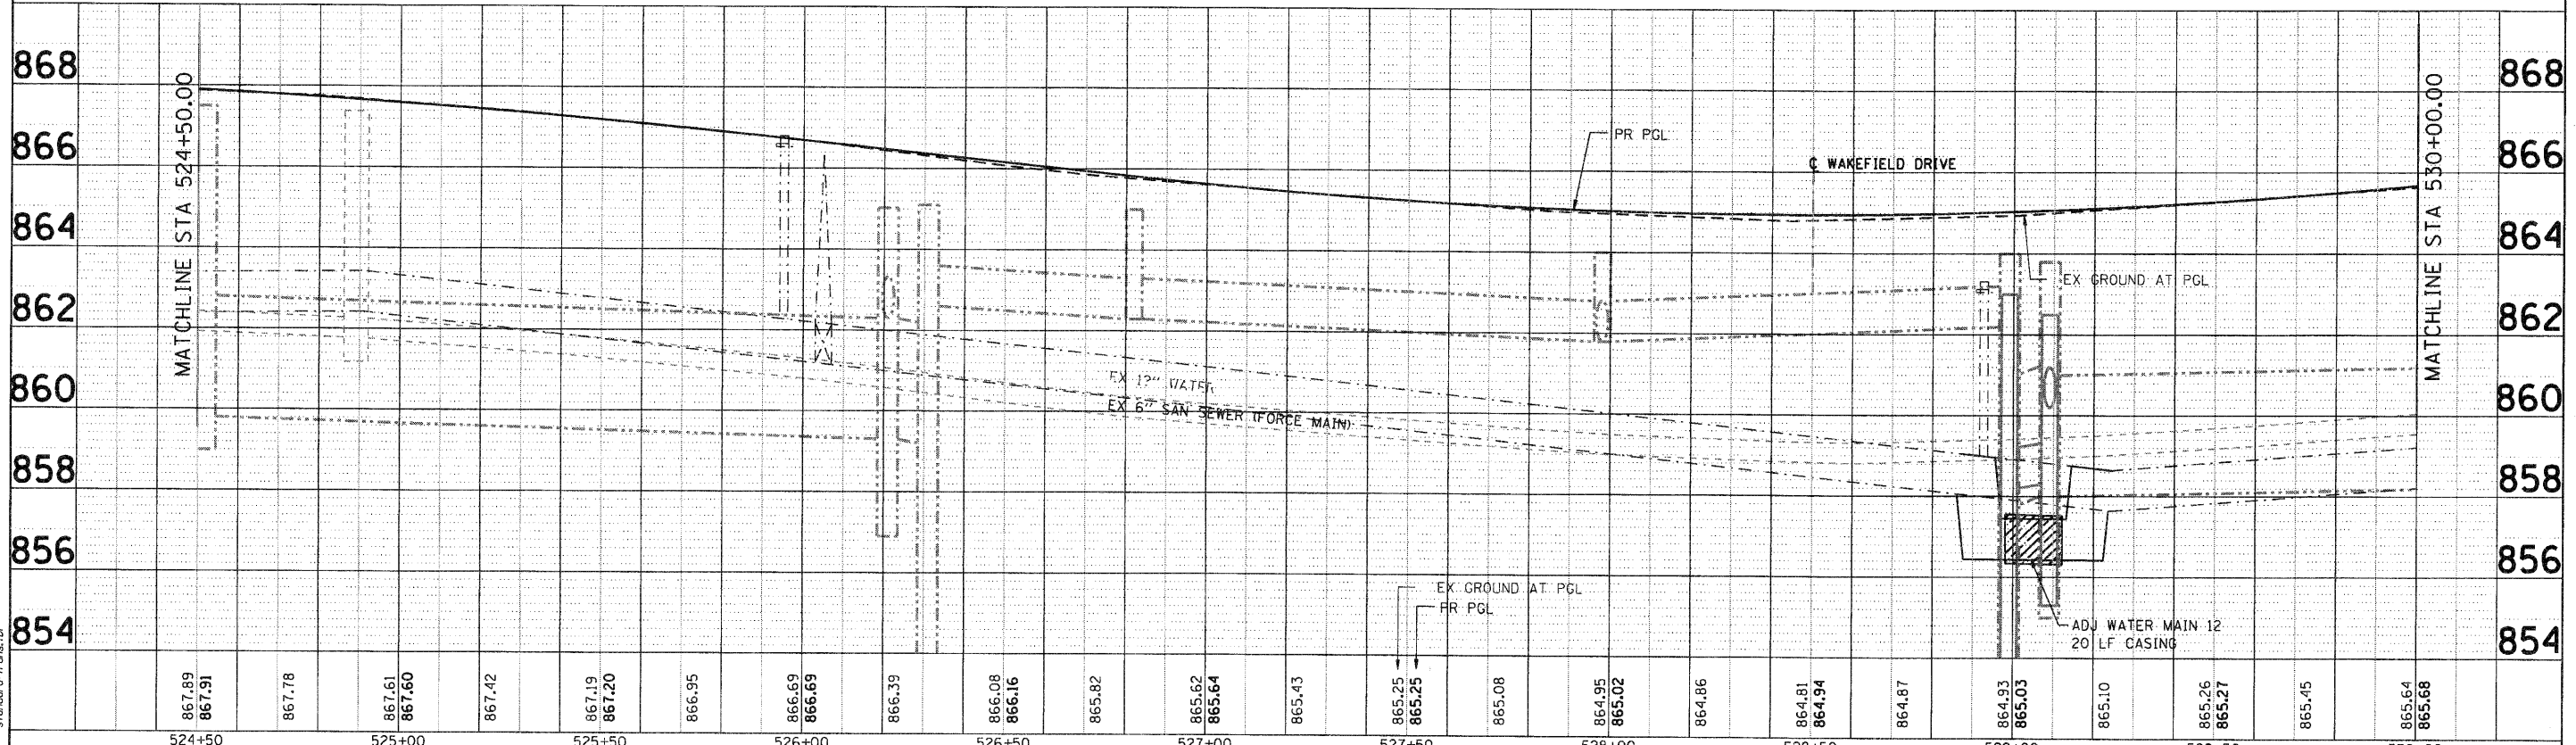

867.89	867.91	867.78	867.61	867.60	867.42	867.19	867.20	866.95	866.69	866.69	866.39	866.08	866.16	865.82	865.62	865.64	865.43	865.25	865.25	865.08	864.95	865.02	864.86	864.81	864.94	864.87	864.93	865.03	865.10	865.26	865.27	865.45	865.64	865.68			
524+50		525+00		525+50		526+00		526+50		527+00		527+50		528+00		528+50		529+00		529+50		530+00															

SEC Group, Inc.
An HR Group Company
420 N. First Street
Methuen, IL 60540-1100
1-815-365-1778 • 1-815-365-1781
www.secgroup.com

USER NAME	- Clarke
DESIGNED	- C. PIEPER
DRAWN	- R. BEST
CHECKED	- T. HAMILTON
DATE	- 10/25/10
REVISIONS	
NO.	
DATE	
BY	
DESCRIPTION	

VILLAGE OF CARPENTERSVILLE

**WATERMAIN AND SANITARY SEWER PLAN AND PROFILE
DUNDEE ROAD (IL ROUTE 68)**

SCALE: 1" = 20' SHEET NO. 19 OF 20 SHEETS STA. 525+00 TO STA. 530+00

F.A. RTE.	SECTION	COUNTY	TOTAL SHEETS	SHEET NO.
	06-00074-00-PP	KANE	211	88
* FAU 2414, FAU 1280, FAP 343			CONTRACT NO. 63504	
FED. ROAD DIST. NO. [ILLINOIS] FED. AID PROJECT				