
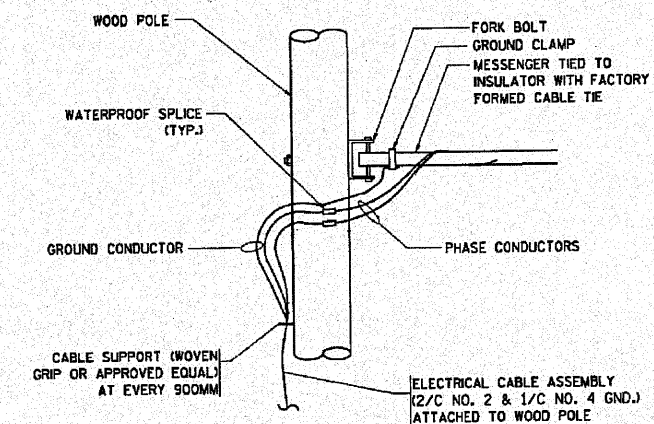


**LEGEND**


- EXISTING LIGHT UNIT TO REMAIN IN PLACE
- REL ○ EXISTING LIGHT UNIT TO BE RELOCATED
- - - EXISTING LIGHTING CIRCUIT
- A - - - TEMPORARY AERIAL CABLE, 2-1/C NO. 4, UNLESS OTHERWISE INDICATED, WITH MESSENGER WIRE
- ⊗ TEMPORARY WOOD POLE, 40 FT., CLASS 4, UNLESS OTHERWISE INDICATED

**NOTES**


1. LIGHTING SHALL BE MAINTAINED DURING CONSTRUCTION BY THE CONTRACTOR. CONTRACTOR SHALL STAGE WORK SUCH THAT THE LIGHTING SYSTEM IS OPERATIONAL AT THE END OF EACH DAY. ANY DAMAGE INCURRED DURING CONSTRUCTION SHALL BE PROMPTLY REPAIRED SO SERVICE IS NOT DISRUPTED. THE CONTRACTOR IS RESPONSIBLE FOR VERIFYING EXISTING CONDITIONS.
2. AERIAL CABLE, 2-1/C OF THE SIZE SPECIFIED WITH MESSENGER WIRE AND WOOD POLES ARE INCLUDED IN THE QUANTITIES FOR MAINTAINING ELECTRICAL CONNECTIONS. THE COST TO PROVIDE TEMPORARY CONNECTIONS TO EXISTING CONTROLLERS AND SPLICING SHALL BE INCLUDED IN THE BID UNIT PRICE FOR AERIAL CABLE.
3. THE COST TO RELOCATE AND RECONNECT AERIAL CABLE INCLUDING WOOD POLES TO MAINTAIN ELECTRICAL CONNECTIONS THROUGHOUT CONSTRUCTION SHALL NOT BE PAID FOR SEPARATELY, BUT SHALL BE INCLUDED IN THE COST FOR AERIAL CABLE OR WOOD POLE.
4. THE LOCATION OF TEMPORARY WOOD POLES SHALL BE APPROVED BY THE ENGINEER PRIOR TO INSTALLATION.
5. TEMPORARY LIGHTING SHALL NOT BE REMOVED UNTIL THE PERMANENT LIGHTING IS INSTALLED AND OPERATIONAL.

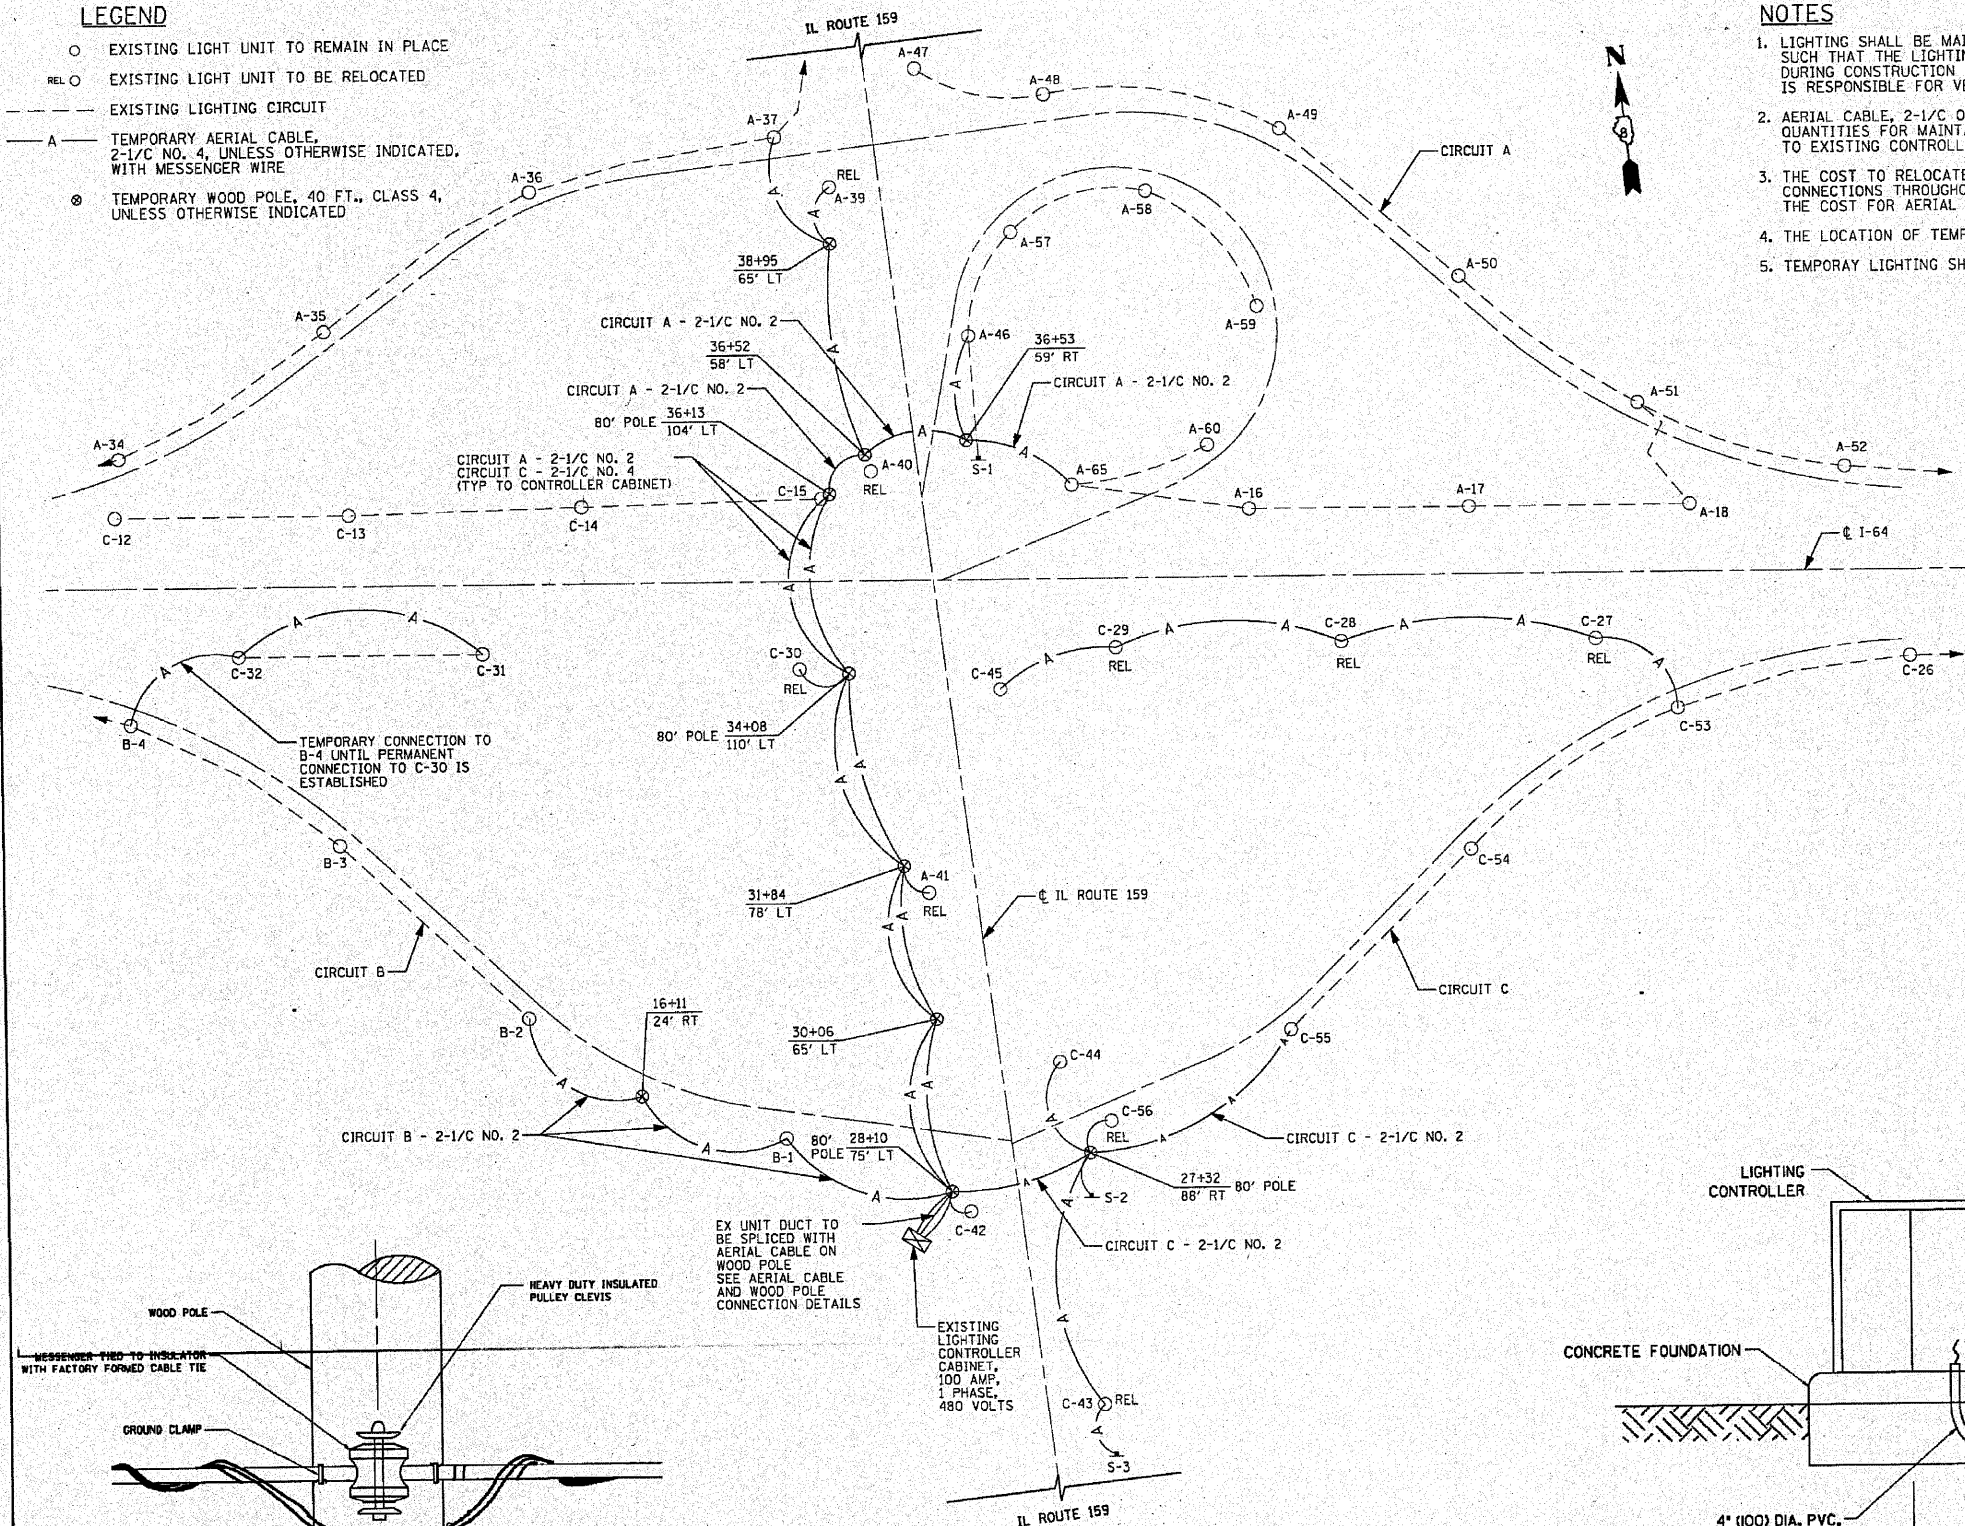

**AERIAL CABLE CONNECTION DETAIL**  
N.T.S.

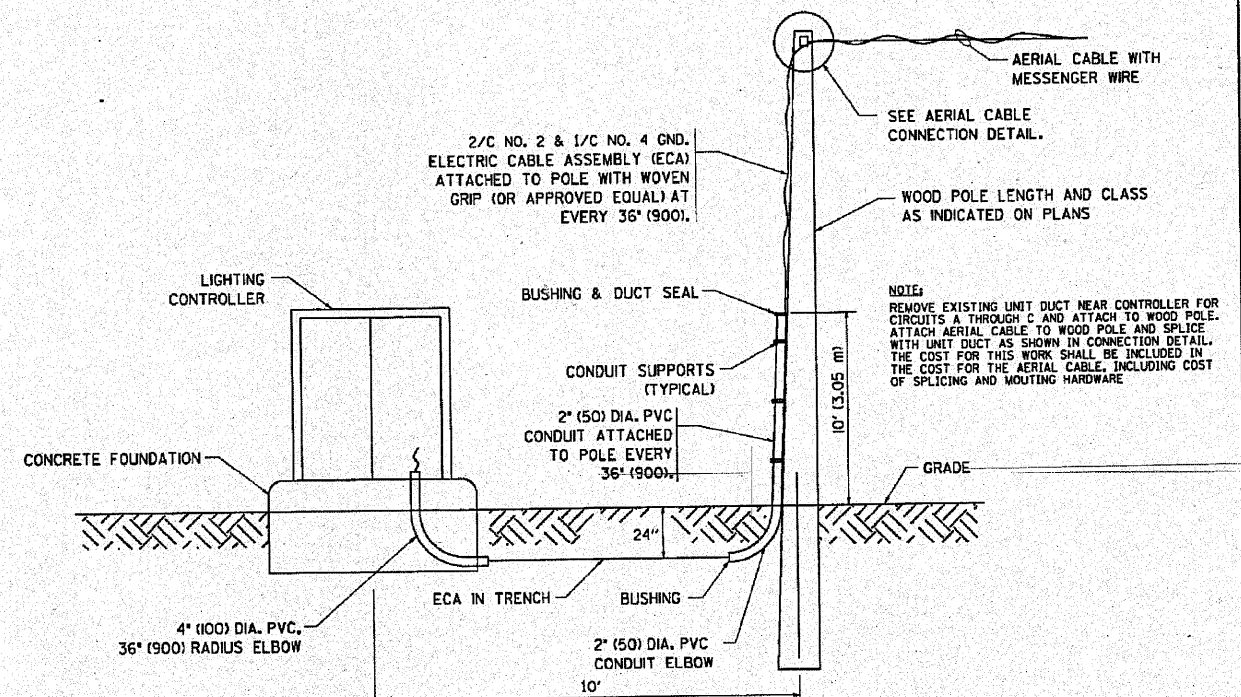

**WOOD POLE TO LIGHTING CONTROLLER WIRING CONNECTION DETAIL**  
N.T.S.

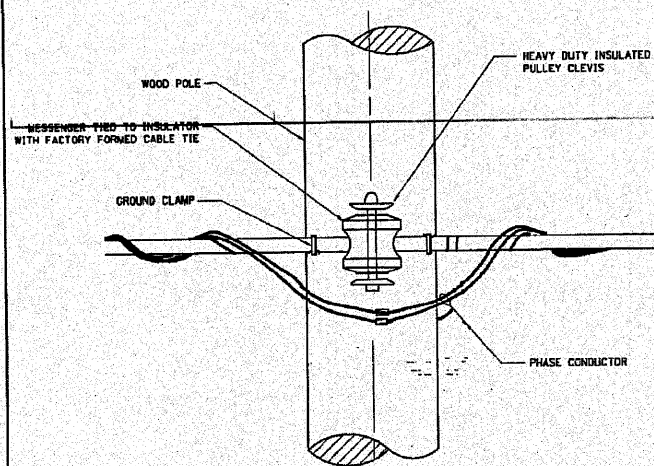

**TEMPORARY LIGHT POLE ATTACHMENT DETAIL**

FILENAME = g:\ch\047\road\c-cu-586.dgn	USER NAME = e.j.pondexter	DESIGNED - KB	REVISED -
PLOT DATE = 12/19/2018 2:30:44 PM	DRAWN - AJP	REVISIONS -	REVISIONS -
CHECKED - SRF	DATE - 5-21-10	REVISIONS -	REVISIONS -

**STATE OF ILLINOIS  
DEPARTMENT OF TRANSPORTATION**

<b>TEMPORARY LIGHTING PLAN</b>			
SCALE: NONE	SHEET NO.	OF SHEETS	STA. TO STA.

F.A.I. RTE.	SECTION	COUNTY	TOTAL SHEETS	SHEET NO.
64	82-5K-2	ST. CLAIR	162	61
JOB NO. D-98-024-10			PTB NO. 153/053	
FED. ROAD DIST. NO. [ILLINOIS] FED. AID PROJECT				