

STATE OF ILLINOIS  
**WINNEBAGO COUNTY HIGHWAY DEPARTMENT**  
 PLANS FOR PROPOSED FEDERAL AID URBAN IMPROVEMENT




**INDEX OF SHEETS**


SHEET NO.	SHEET NAME
1	COVER SHEET
2	STANDARDS & GENERAL NOTES
3 - 4	SUMMARY OF QUANTITIES
5 - 10	TYPICAL SECTIONS
11 - 17	SCHEDULE OF QUANTITIES
18 - 55	PLAN & PROFILE
56 - 60	DETOUR & STAGING PLAN
61 - 66	EROSION CONTROL PLAN
67 - 75	INTERSECTION DETAILS
76 - 77	SIGNAGE DETAILS
78 - 89	PAVEMENT MARKING PLAN
90 - 92	SIGNAL PLAN
93 - 95	HIGHWAY LIGHTING PLAN
96 - 98	BOX CULVERT EXTENSION DETAIL
99 - 106	DETAILS - DISTRICT 2 AND COUNTY STANDARDS
107 - 165	CROSS SECTIONS

**FAU ROUTE 5097**  
**FAS ROUTE 1041**  
**SECTION: 06-00400-00-RS**  
**PROJECT NO.: M-5099 (76)**

RESURFACING ON MERIDIAN ROAD (C.H. 24)  
 JOB NO.: C-92-074-07  
 CONTRACT NO.: 85513

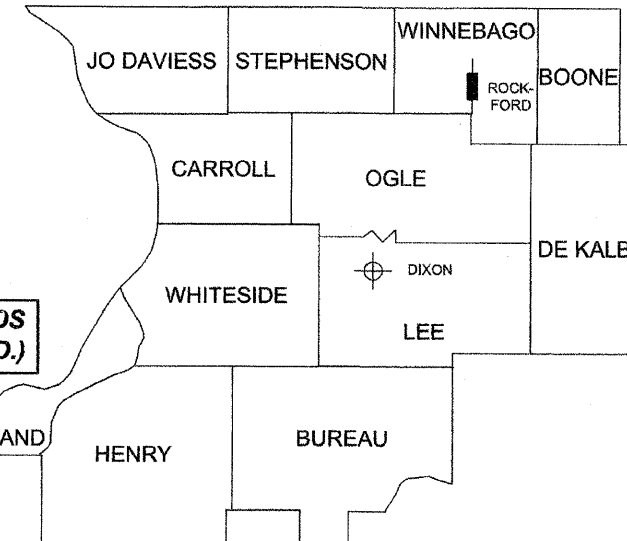

DISTRICT HEADQUARTER    
 PROJECT LOCATION

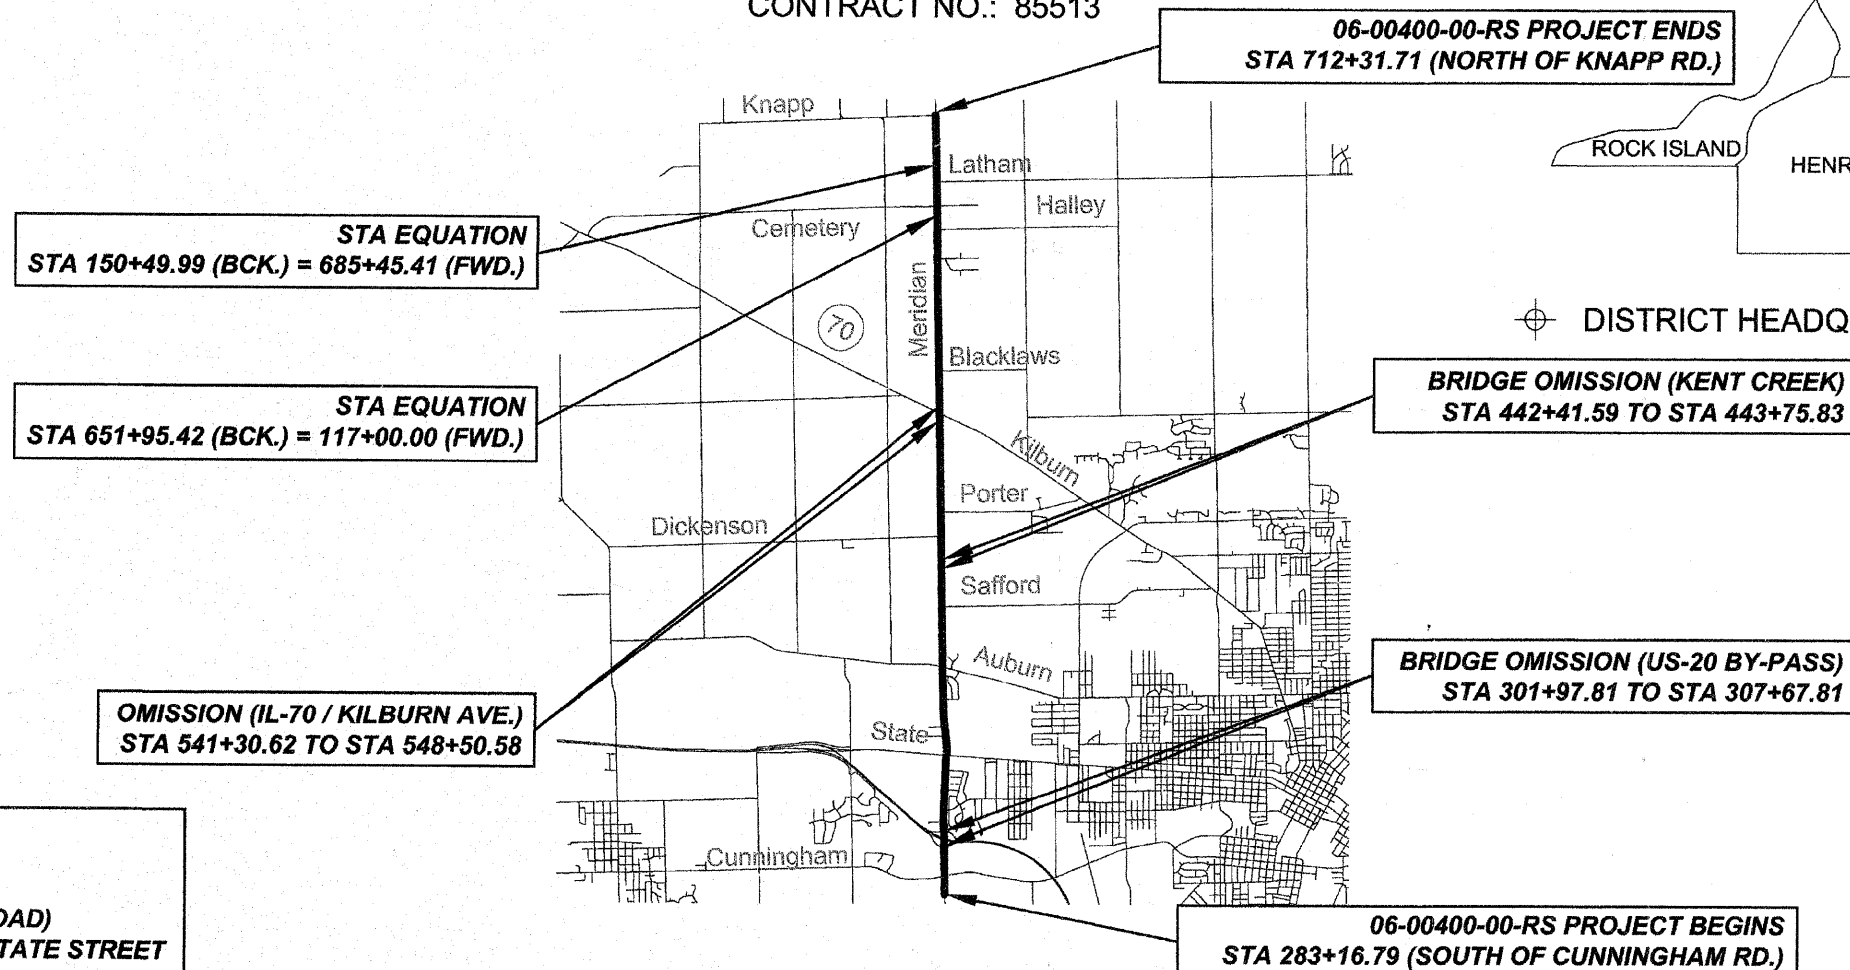

**ADT: 8,250 (2009) 10% TRUCKS**  
**MAJOR COLLECTOR & MINOR ARTERIAL**  
**DESIGN SPEED: 50 MPH**  
**3R POLICY (STATE STREET TO KNAPP ROAD)**  
**LAPP POLICY (CUNNINGHAM ROAD TO STATE STREET)**

SCALES:	
<b>CROSS-SECTIONS</b>	<b>PLAN &amp; PROFILE</b>
<b>FULL SIZE</b>	<b>FULL SIZE</b>
HORIZONTAL: 1" = 20'	HORIZONTAL: 1" = 50'
VERTICAL: 1" = 10'	VERTICAL: 1" = 10'
<b>1/4 SIZE</b>	<b>1/4 SIZE</b>
HORIZONTAL: 1" = 40'	HORIZONTAL: 1" = 100'
VERTICAL: 1" = 20'	VERTICAL: 1" = 20'

MERIDIAN ROAD: 41,560.95 FT = 7.87 MILES  
 SIDE ROAD IMPROVEMENTS: 4,773.34 FT = 0.90 MILES  
 TOTAL LENGTH OF IMPROVEMENTS = 46,334.29 FT = 8.77 MILES

**CALL J.U.L.I.E.**  
**BEFORE YOU DIG**  
 1-800-892-0123

WINNEBAGO TWP (T26N- R11E)  
 SEC. - 13, 12, 1

BURRITT TWP (T27N- R11E)  
 SEC. - 36, 25, 24, 13, 12, 1

ROCKFORD TWP (T44N- R1E)  
 SEC. - 31, 30, 19, 18, 7, 6

OWEN TWP (T45N- R1E)  
 SEC. - 31, 30, 19, 18, 7

4/16/10

**THESE PLANS PREPARED BY:**  
**WINNEBAGO COUNTY HIGHWAY DEPARTMENT**

APPROVED: 4/16/10  
 WINNEBAGO COUNTY ENGINEER

PASSED: \_\_\_\_\_ 20\_\_\_\_\_  
  
 DISTRICT 2 ENGINEER OF LOCAL ROADS & STREETS

RELEASING FOR BID  
 BASED ON LIMITED  
 REVIEW \_\_\_\_\_ 20\_\_\_\_\_  
  
 DEPUTY DIRECTOR OF HIGHWAYS, REGION 2 ENGINEER