



STATE OF ILLINOIS  
DEPARTMENT OF TRANSPORTATION

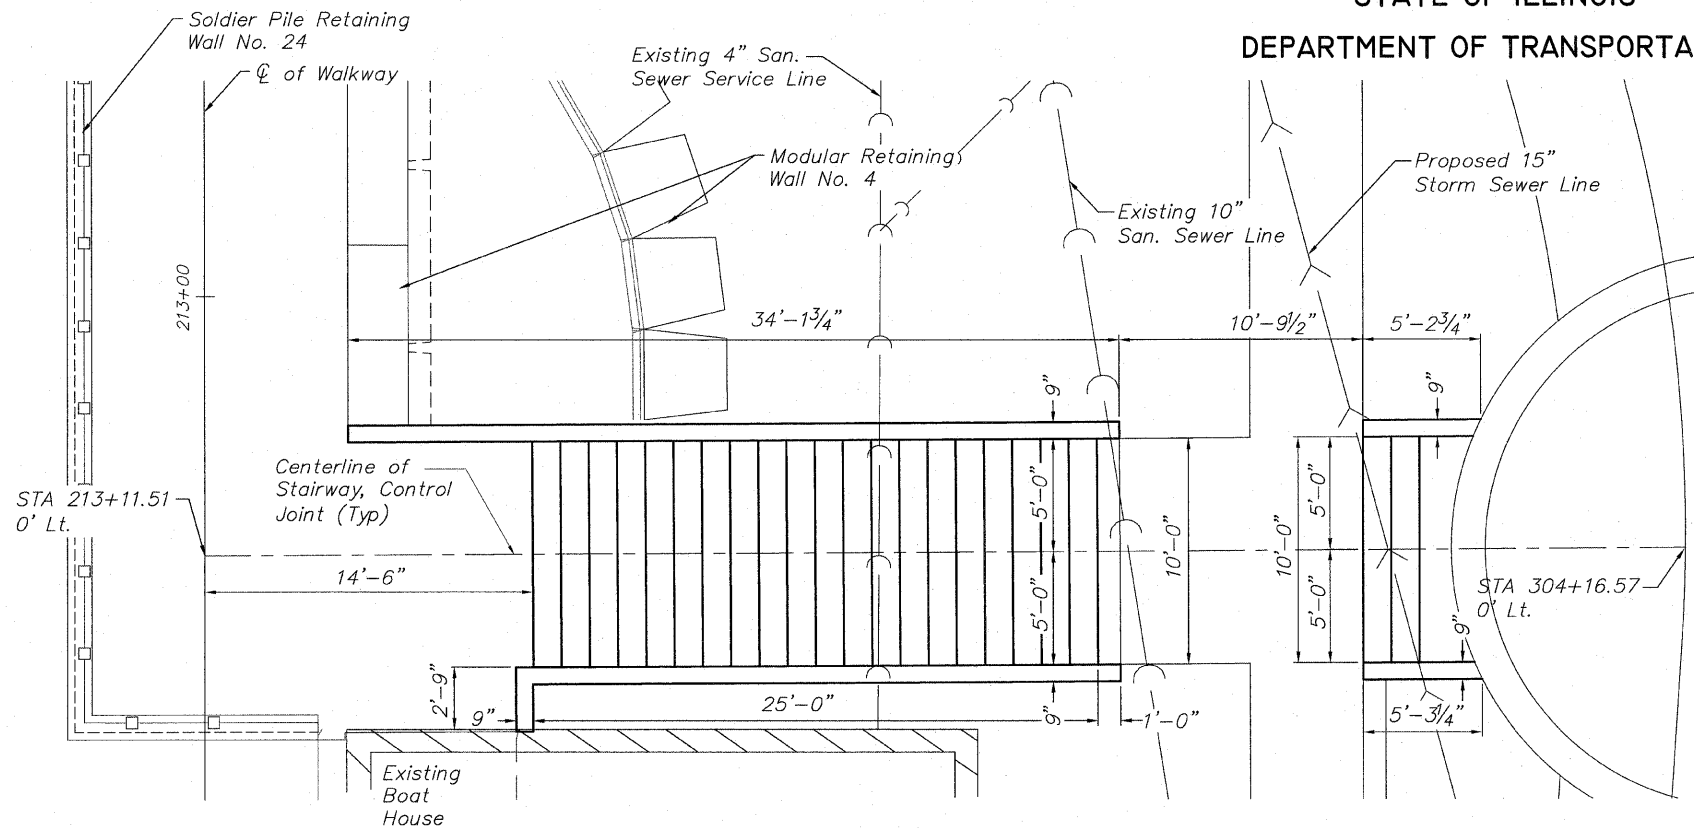


PLAN

NOTES:

1. It shall be the responsibility of the Contractor to verify all dimensions and conditions existing in the field prior to construction and ordering materials.
2. The concrete shall be constructed as shown in accordance with Section 503 of the "Standard Specifications for Road and Bridge Construction".
3. All exposed edges of concrete walls shall have a 3/4" x 45° chamfer, except as shown otherwise. Chamfers on vertical edges shall be continued a minimum of one foot below finished ground level.
4. Stair tread edges shall be protected with Balco, Inc Model P-200 or equal installed according to manufactures instructions.
5. Reinforcement bars shall all be epoxy coated.
6. See Landscape Architect sheet 137 for handrail detail.
7. Refer to Electrical Plan sheet 41 for lighting insets. Provide box-out in sidewalls for flush panels.
8. Stair Tread Nosings shall be installed in two halves to allow for a scored or sawed contraction joint along the centerline of the stairs. The joint shall be sealed with a premium polyurethane sealant in accordance with the Standard Specifications.

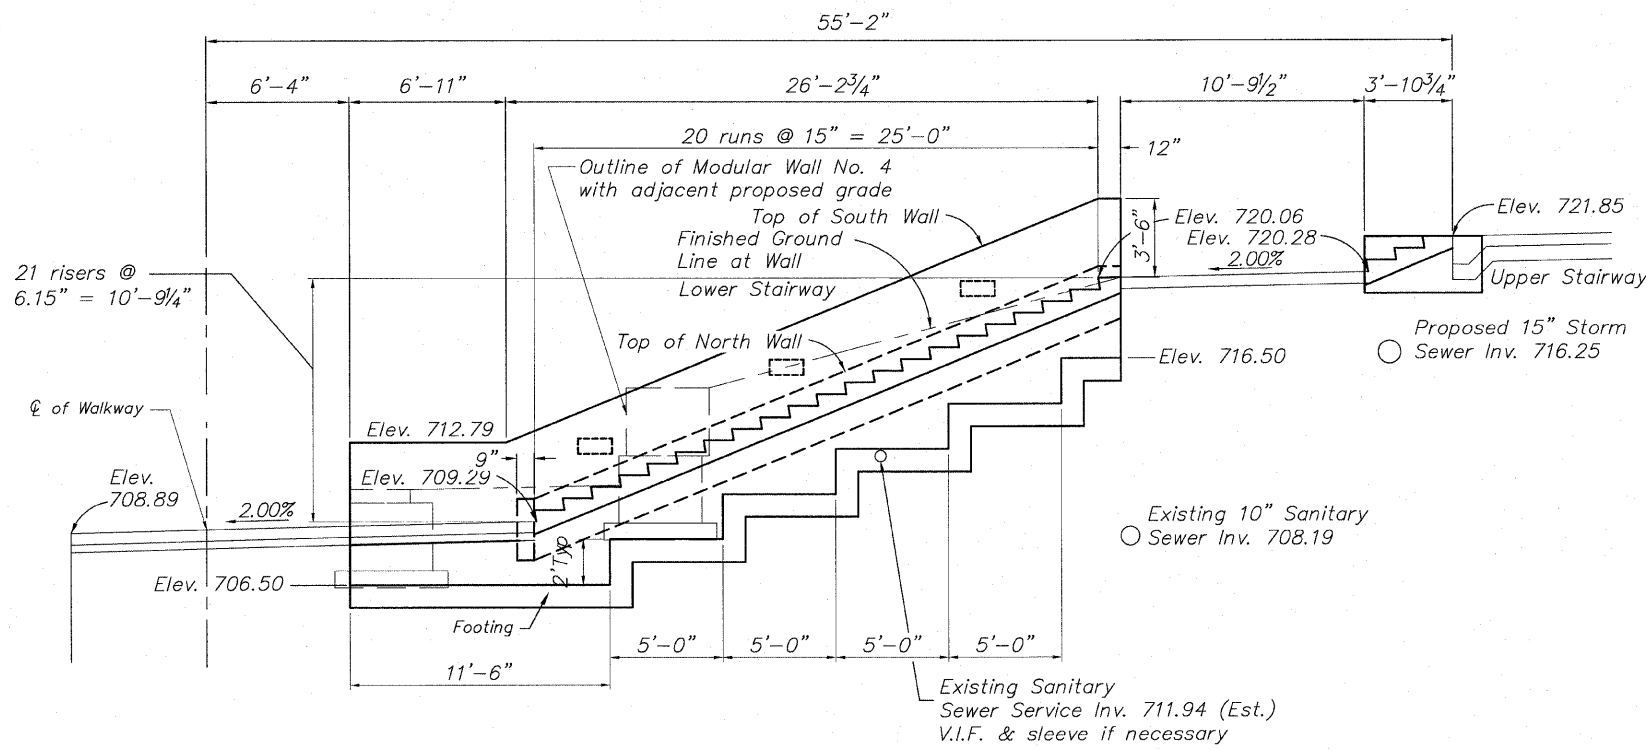

ELEVATION

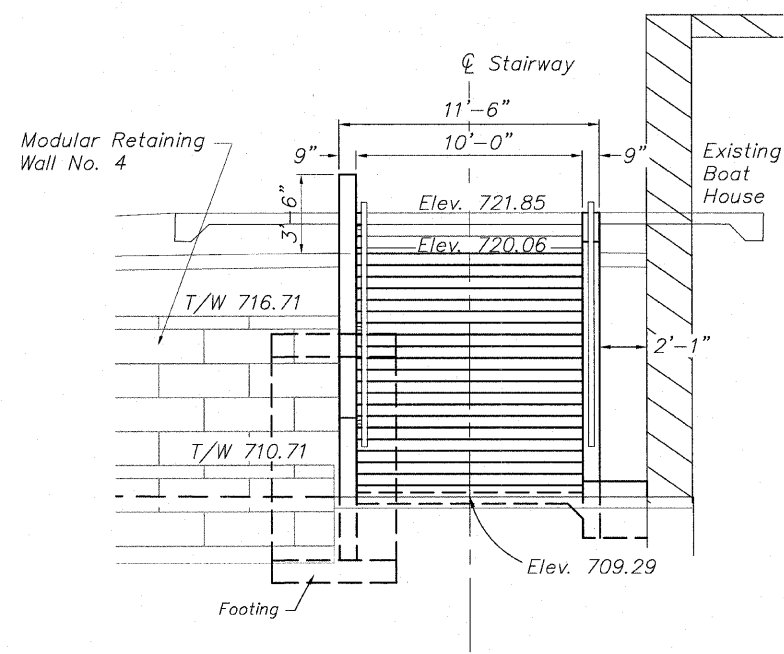

FRONT ELEVATION  
SECTION B-B

**NORTH STAIRS AT BOAT HOUSE  
PLAN AND ELEVATION  
PEDESTRIAN RIVERWALK  
ALONG THE ROCK RIVER  
WINNEBAGO COUNTY  
SECTION NO. 06-00543-00-BT  
STATION 213+11.51**

DESIGNED	CTB
CHECKED	AAG
DRAWN	JAW
CHECKED	JWH

**McClure**  
Engineering Associates, Inc.  
7282 Argus Drive  
(815) 398-2332  
Rockford, Illinois 61107-5837  
Fax (815) 398-2498  
Design Firm License: Illinois #184-000816  
Copyright 2010 By McClure Engineering Associates, Inc.

SHEET NO. 2  
5 SHEETS

F.A. RTE.	SECTION	COUNTY	TOTAL SHEETS	SHEET NO.
	06-00543-00-BT	WINNEBAGO	148	47
FED. ROAD DIST. NO.		ILLINOIS	FED. AID PROJECT	
		CONTRACT NO.		85521

H:\08-006 RIVERWALK MUSEUM\DESIGN\DRAWINGS\STRUCTURAL\GPBE\08-008 STAIRS\GPBE.DWG, GPBE NORTH STAIRS, 10/26/2010 2:02:01 PM, JH