




Hanson Professional Services Inc.

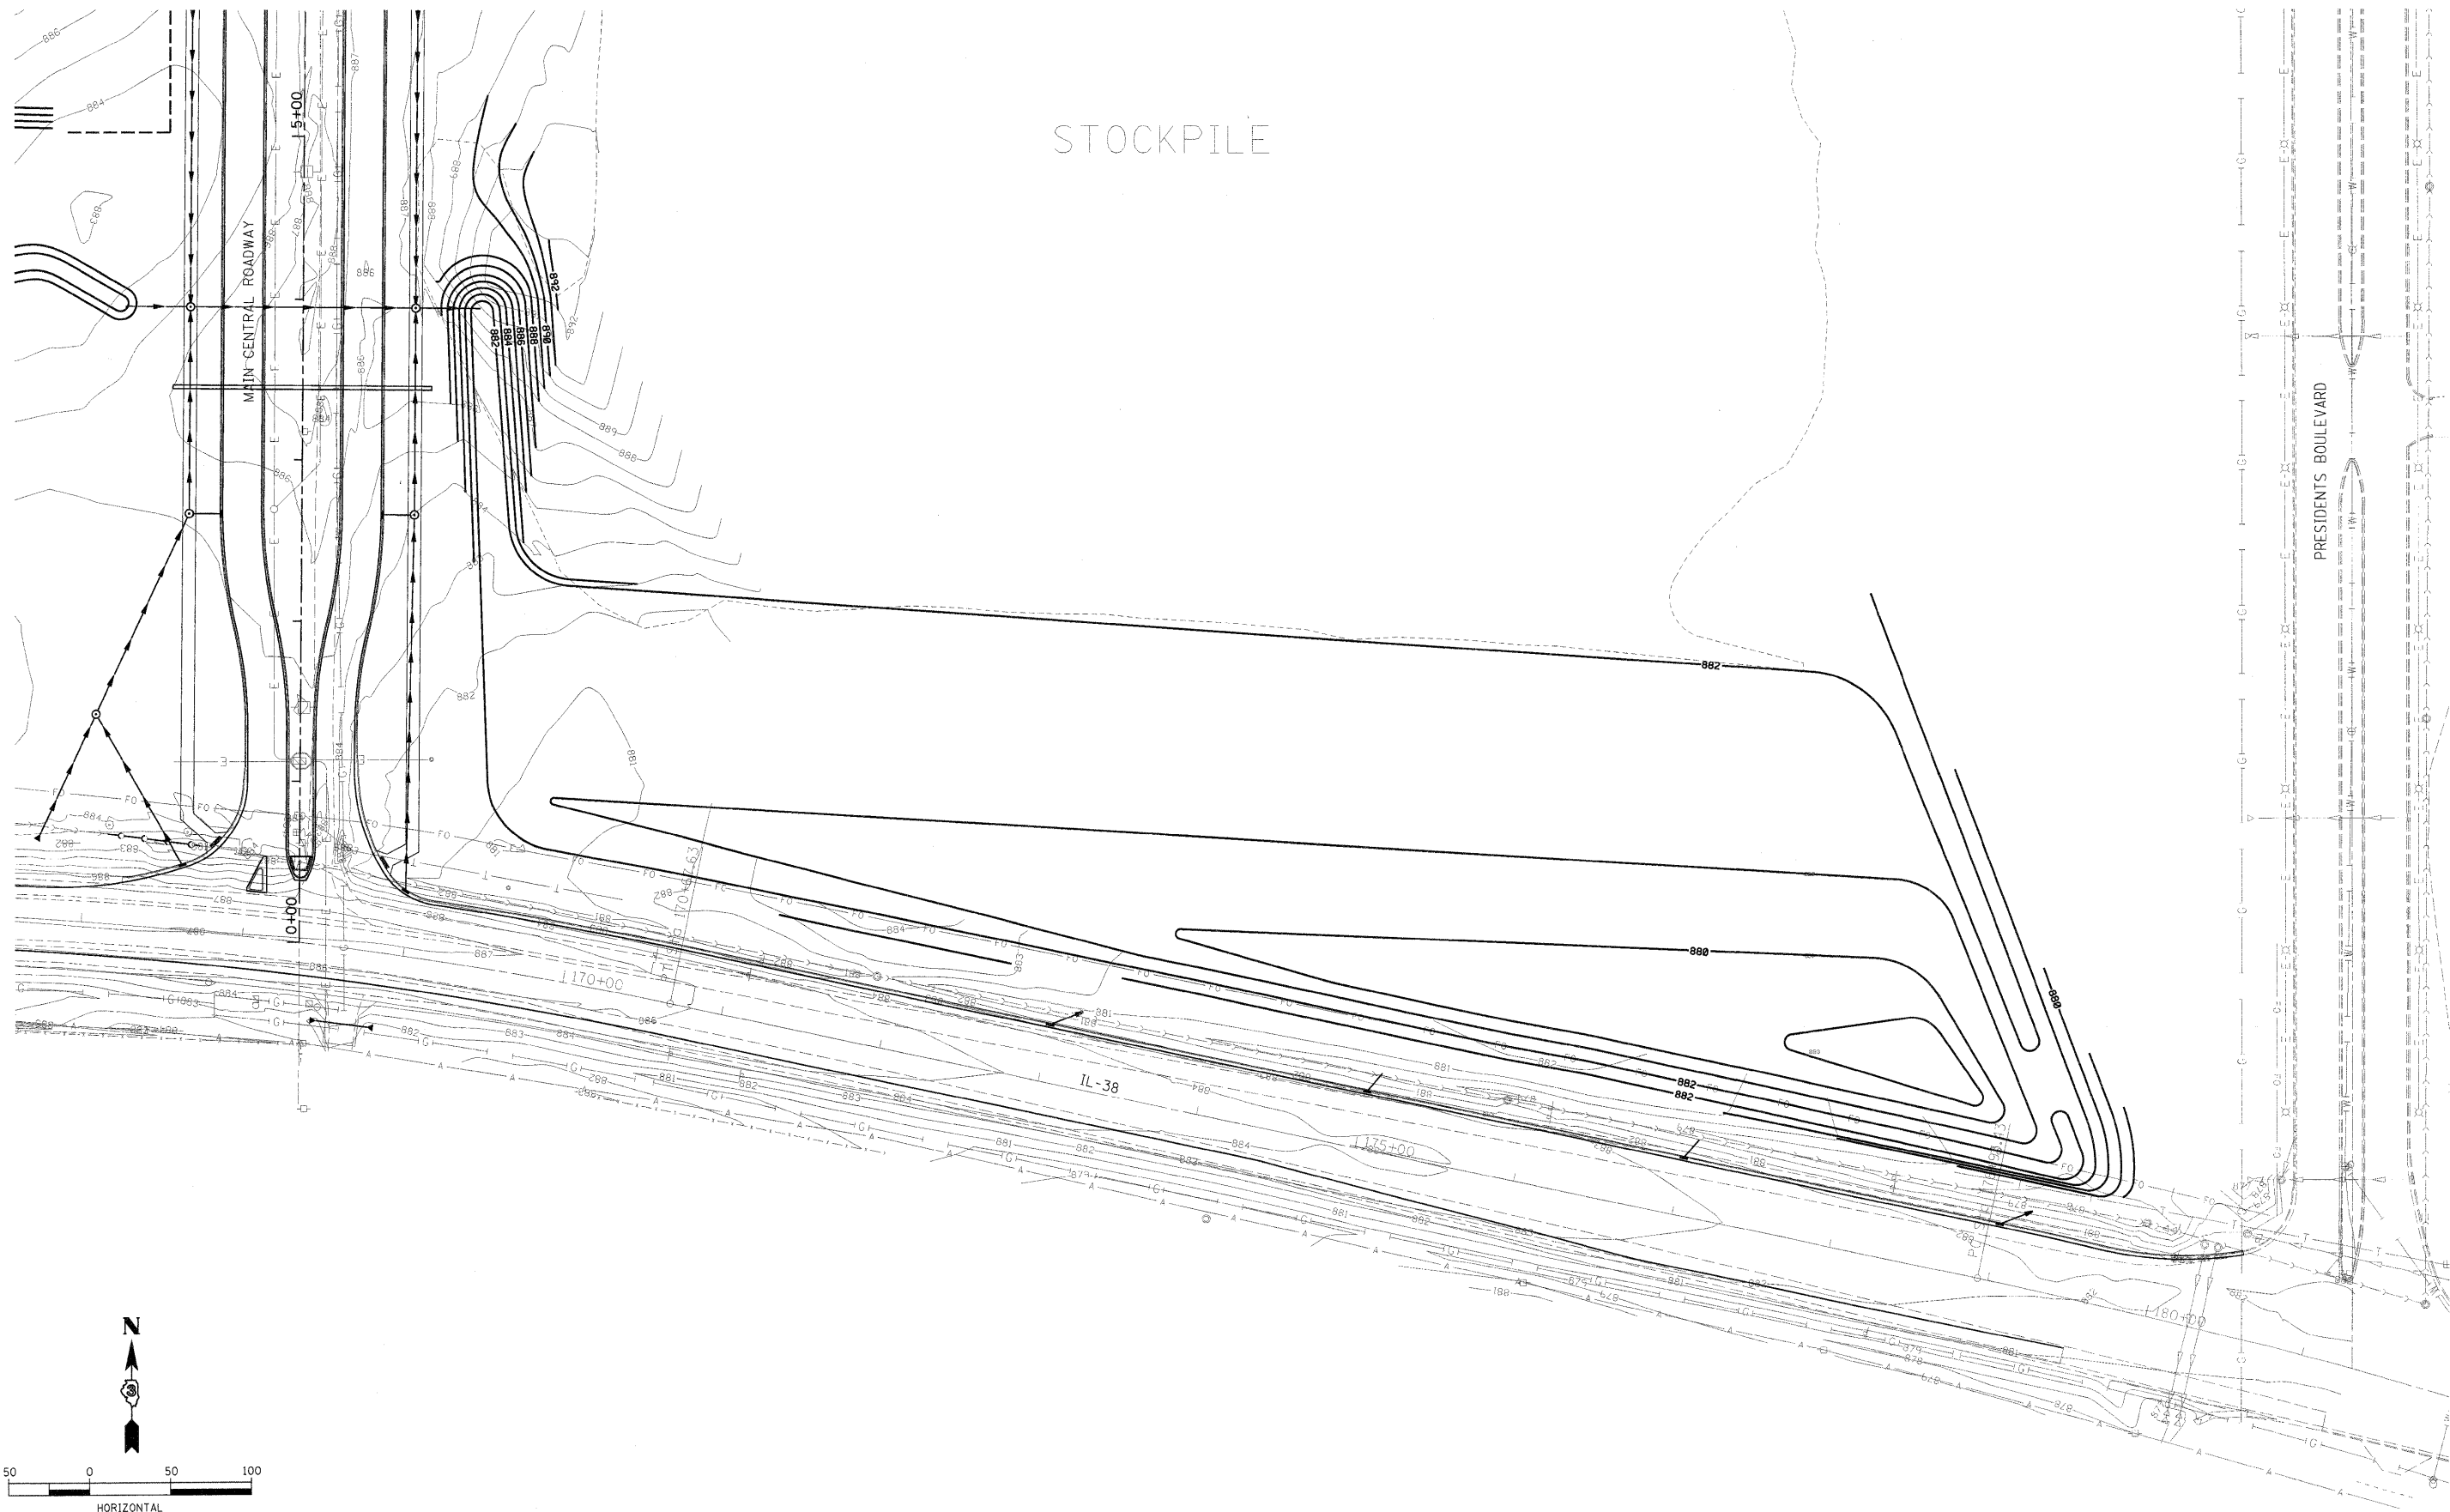

LAYOUT: MWH 09/20/10 Husu00411
 DRAWN: MWH 09/20/10 10/05/2010
 REVIEWED: CRC 10/01/10 I:\06\185\06\185\3\CAD\00\00\1\Sheet\145-GRD.dwg

FILE NAME =
 C:\145\GRD.dwg

USER NAME = Husu00411
 PLOT SCALE = 50.000' / in.
 PLOT DATE = 11/05/2012

DESIGNED - CRC
 DRAWN - MWH
 CHECKED - CRC
 DATE - 11/04/10

REVISED -
 REVISED -
 REVISED -
 REVISED -

**STATE OF ILLINOIS
 DEPARTMENT OF TRANSPORTATION**

**NORTHERN ILLINOIS UNIVERSITY
 FAR WEST CAMPUS EXPANSION
 DETENTION GRADING AND DRAINAGE PLAN**

SCALE: 1" = 50' SHEET NO. OF SHEETS STA. 200+00 TO STA. 207+00

F.A.P. RTE.	SECTION	COUNTY	TOTAL SHEETS	SHEET NO.
567	06-00002-00-PV	DEKALB	148	70
CONTRACT NO. 87476				
ILLINOIS/FED. AID PROJECT				