


**BEGIN IMPROVEMENTS**  
FOURTH STREET  
STA. 24+16.05

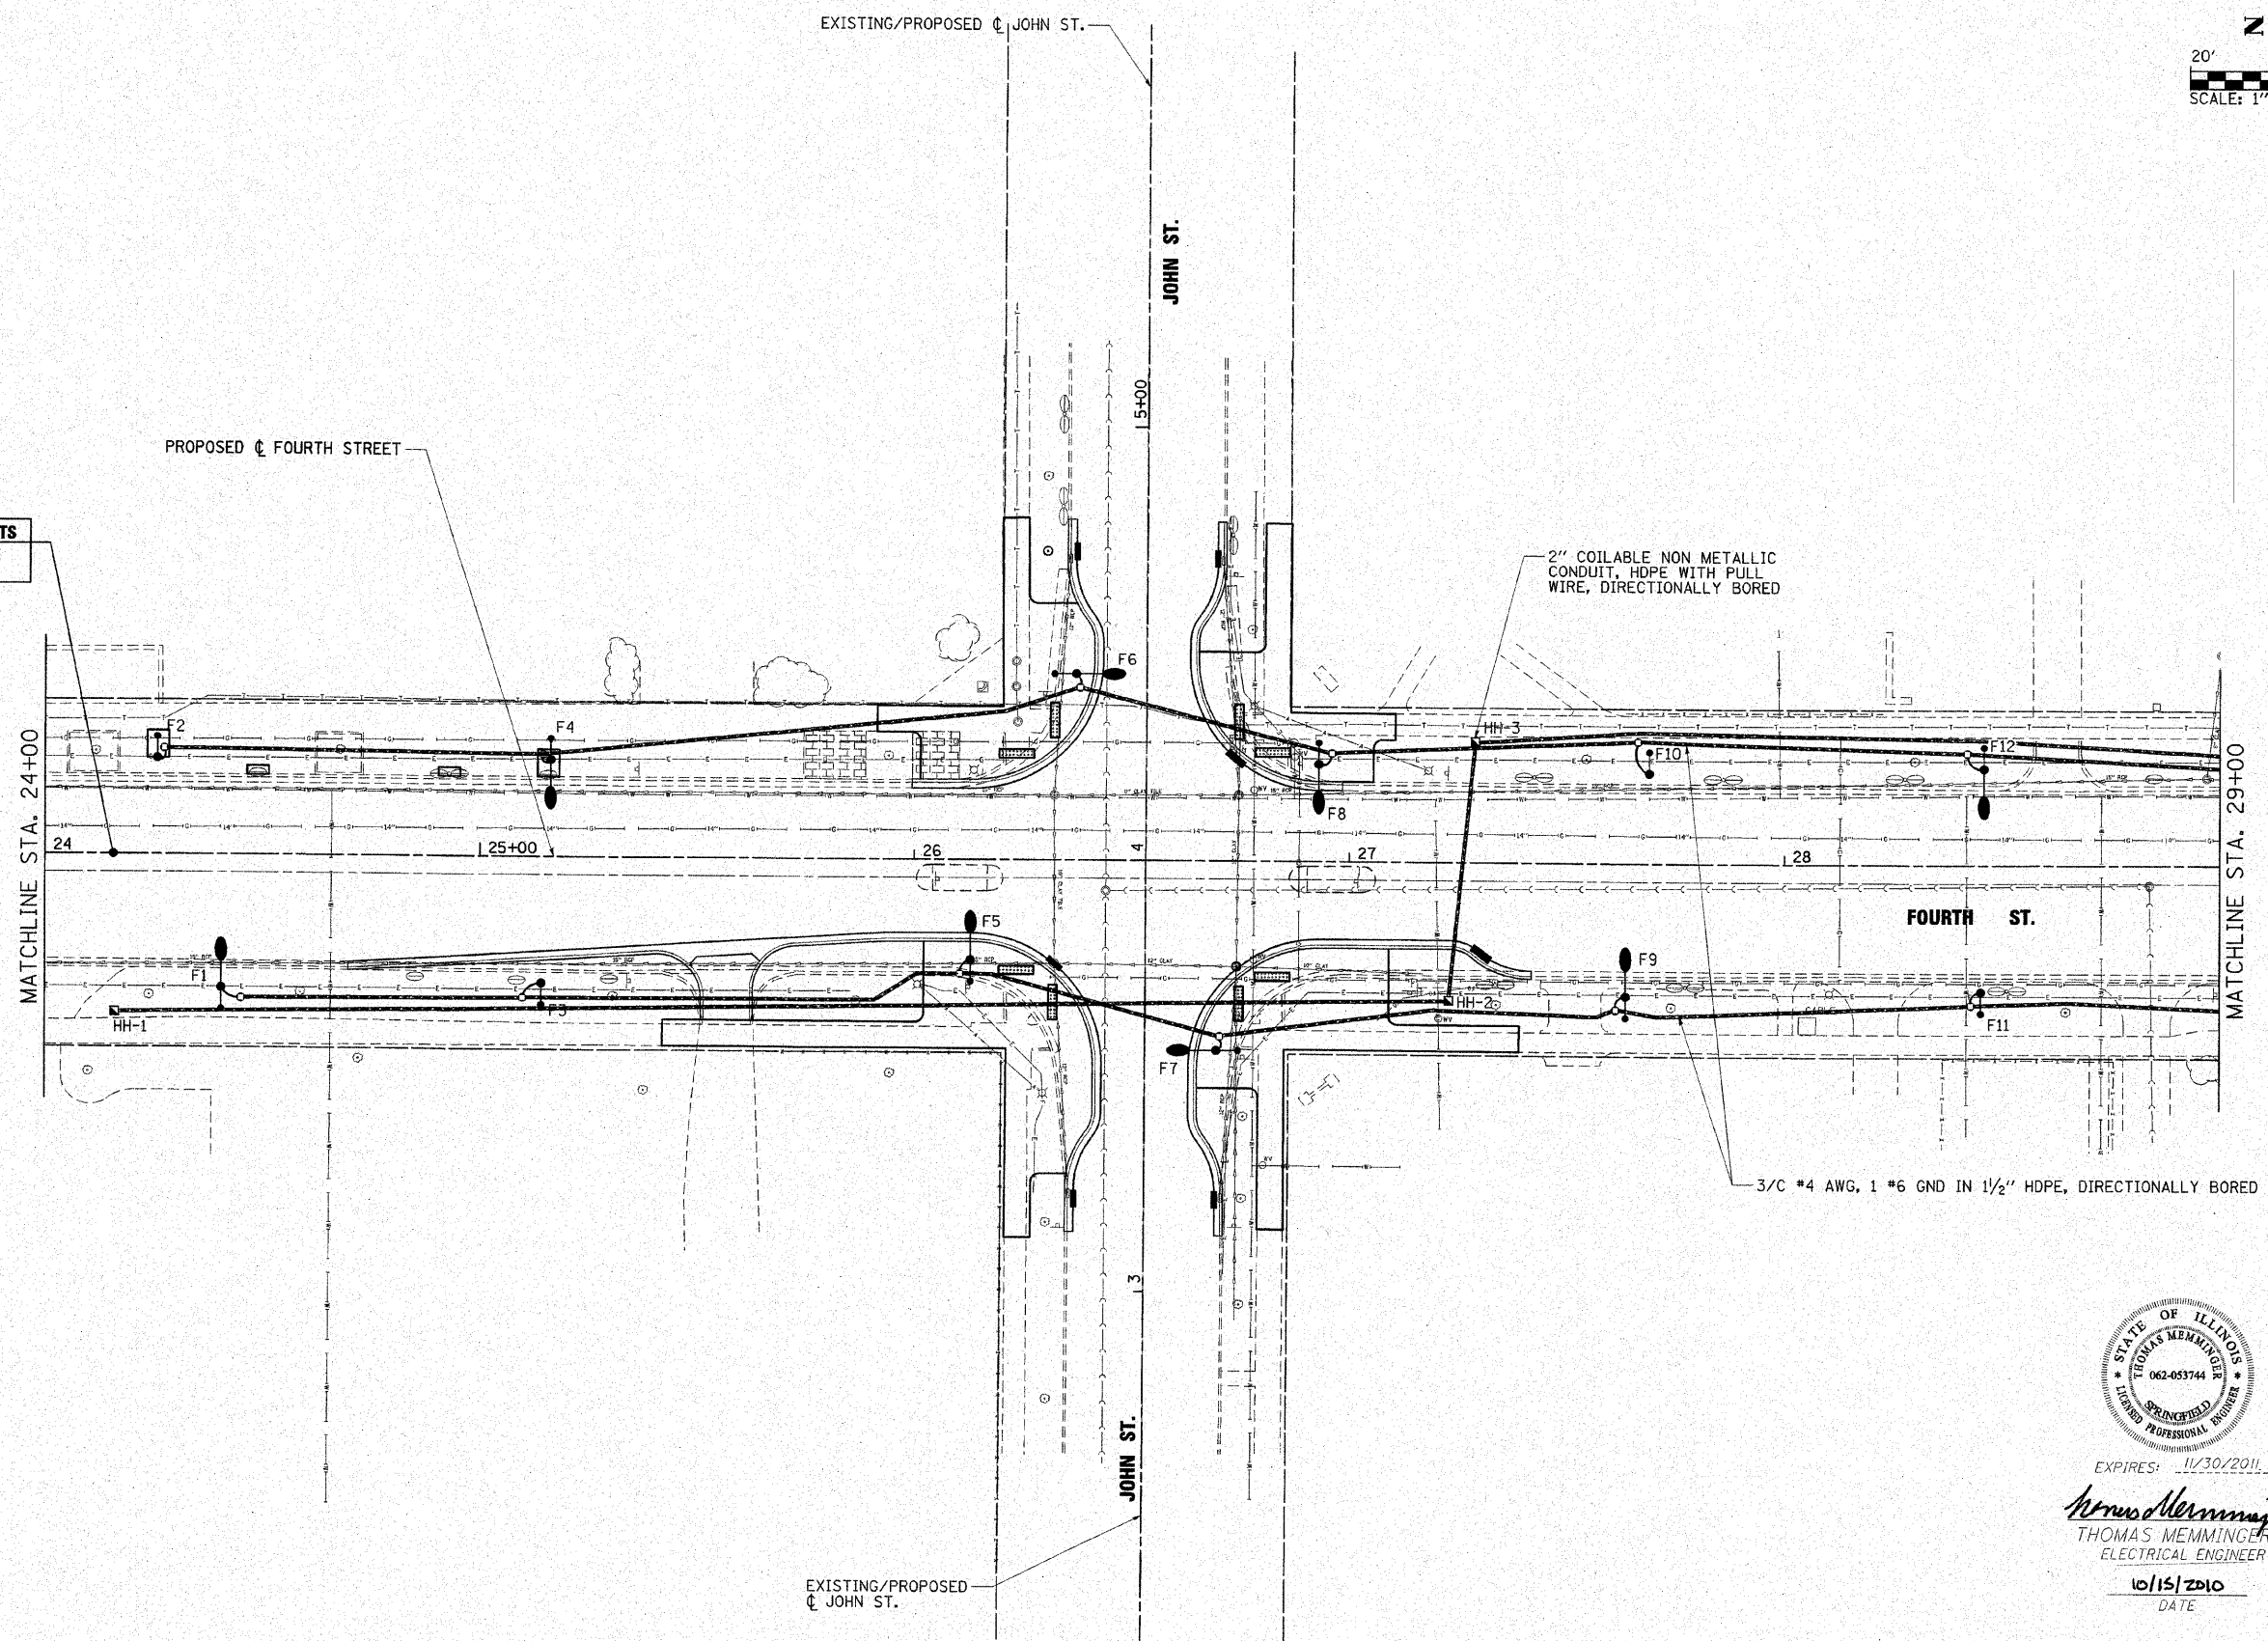

EXPIRES: 11/30/2011  
*Thomas Memminger*  
THOMAS MEMMINGER  
ELECTRICAL ENGINEER  
10/15/2010  
DATE

FILE NAME = I:\champaign\180948100\draw\cadd\sheet5	USER NAME = Jim Michael Lighting_Plans_02.dgn	DESIGNED - TM DRAWN - RAH CHECKED - JMM DATE - 10/15/2010		<p align="center"><b>CITY OF CHAMPAIGN</b> <b>DEPARTMENT OF PUBLIC WORKS</b></p>		<p align="center"><b>ROADWAY LIGHTING PLAN</b> <b>FOURTH STREET IMPROVEMENT</b> <b>CHAMPAIGN, ILLINOIS</b></p>		F.A.U. RTE. 7171	SECTION 10-00285-00-SP	COUNTY CHAMPAIGN	TOTAL SHEETS 55	SHEET NO. 44
SCALE: 1" = 20'								SHEET NO. OF SHEETS STA. 24+00 TO STA. 29+00		CONTRACT NO. 91445 ILLINOIS FED. AID PROJECT		