


SIGN DETAIL

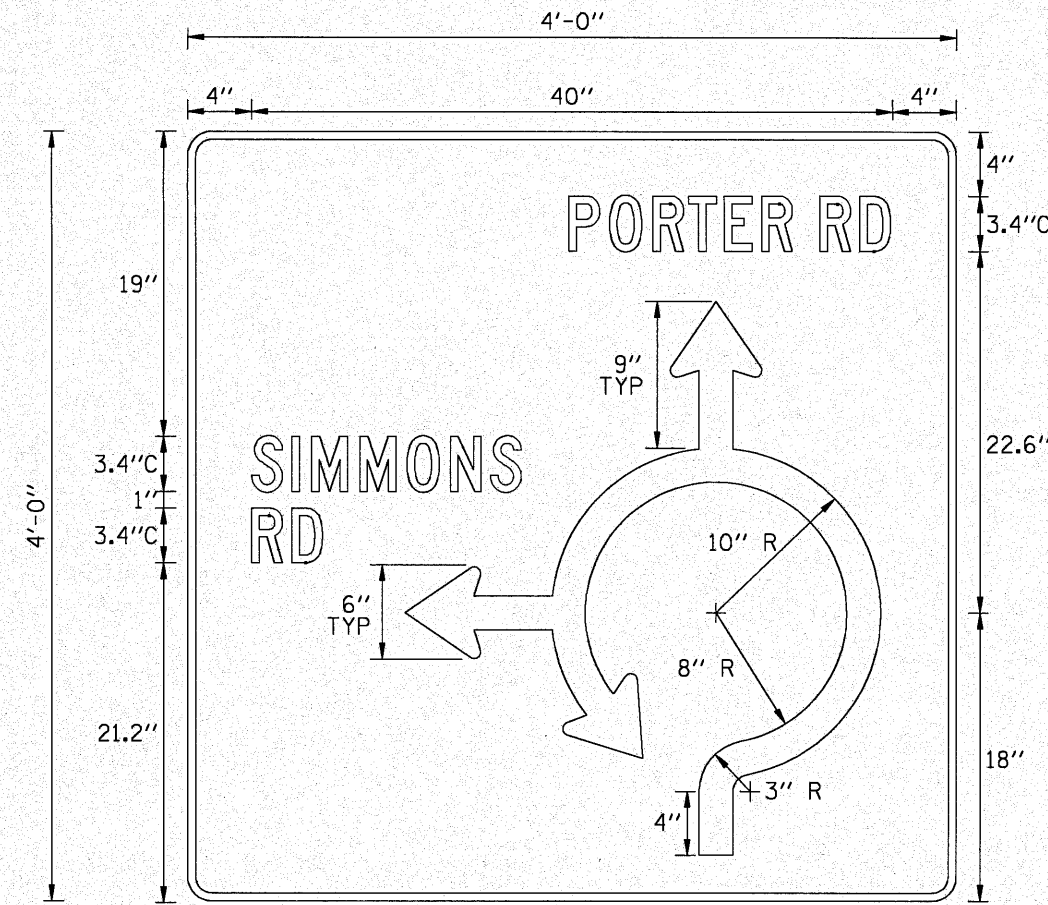

Dimensions are in Inches.tenths

BORDER
R=1.5"
TH=0.5"

Panel Style: Street Name 6-3in.ssi
M.U.T.C.D.: 2003 Edition

Letter locations are panel edge to lower left corner

SIGN NUMBER	PORTER EASTBOUND
WIDTH x HGHT.	4'-0" x 4'-0"
BORDER WIDTH	0.5"
CORNER RADIUS	1.5"
MOUNTING	Metal Posts
SIGN AREA	16.0 Sq.Ft.
BACKGROUND	TYPE: Reflective
	COLOR: Green
LEGEND/BORDER	TYPE: Reflective
	COLOR: White

SYMBOL	X	Y	WID	HT

LETTER POSITIONS (X)

LENGTH SERIES/SIZE

Letter	X	Y	WID	HT	Series/Size						
P	23.8	26.4	29.1	31.3	33.5	35.9	37.8	39.5	42	20.1	C 2000
O	26.4	29.1	31.3	33.5	35.9	37.8	39.5	42			
R	29.1	31.3	33.5	35.9	37.8	39.5	42				
T	31.3	33.5	35.9	37.8	39.5	42					
E	33.5	35.9	37.8	39.5	42						
R	35.9	37.8	39.5	42							
R	37.8	39.5	42								
D	39.5	42									
S	4	6.5	7.7	10.8	13.7	16.4	18.9			16.8	C 2000
I	6.5	7.7	10.8	13.7	16.4	18.9					
M	7.7	10.8	13.7	16.4	18.9						
M	10.8	13.7	16.4	18.9							
O	13.7	16.4	18.9								
N	16.4	18.9									
S	18.9										
R	4	6.5								4.4	C 2000
D	6.5										

LAST SAVED = 12/2/2009
PEN TABLE = VB-Half.tbl
PLOT DRIVER = TR-V8pdf-Black-Half.plt

FILE NAME =	USER NAME = sdonahue	DESIGNED -	REVISED -
\\0812902\cad\1\plans\19_DBXXXXX-Sht-Sign-02.dgn		DRAWN -	REVISED -
PLOT SCALE = 1.0000' / IN.		CHECKED -	REVISED -
PLOT DATE = 11/4/2010 1:19:48 PM		DATE -	REVISED -



SIGNING DETAILS

SCALE: NTS SHEET NO. 2 OF 4 SHEETS STA. TO STA.

F.A.U. 9170
PORTER / SIMMONS ROADS
SECTION 08-0060-00-PV
CONTRACT 97408

TOTAL SHEETS 36 SHEET NO. 24