


SIGN DETAIL

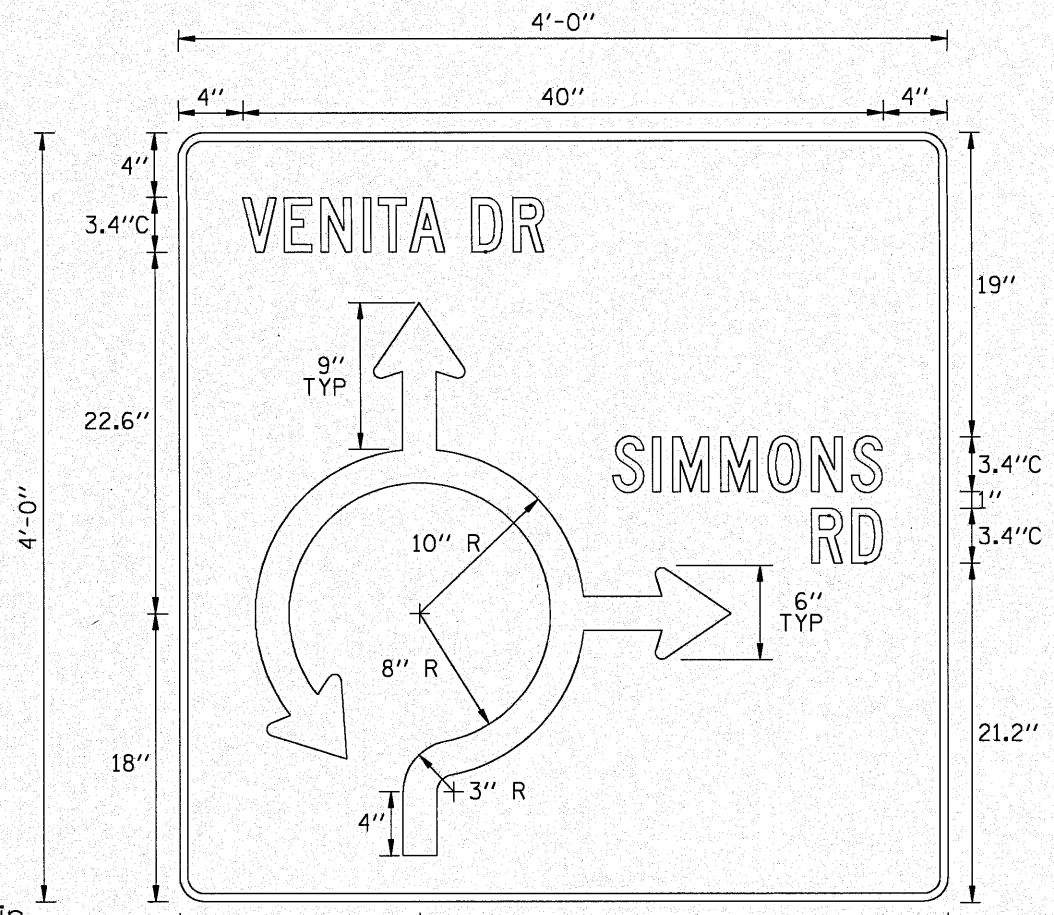

Dimensions are in inches.tenths

BORDER
R=1.5"
TH=0.5"

Panel Style: Street Name 6-3in.ssi
M.U.T.C.D.: 2003 Edition

Letter locations are panel edge to lower left corner

SIGN NUMBER	PORTER WESTBOUND
WIDTH x HGHT.	4'-0" x 4'-0"
BORDER WIDTH	0.5"
CORNER RADIUS	1.5"
MOUNTING	Metal Posts
SIGN AREA	16.0 Sq.Ft.
BACKGROUND	TYPE: Reflective
	COLOR: Green
LEGEND/BORDER	TYPE: Reflective
	COLOR: White

SYMBOL	X	Y	WID	HT

LETTER POSITIONS (X)

LENGTH SERIES/SIZE

Letter	X	Y	WID	HT	Series/Size						
V	4	6.6	8.9	11.5	12.5	14.4	16.6	18.3	20.9	18.8	C 2000
E	6.6	8.9	11.5	12.5	14.4	16.6	18.3	20.9			
N	8.9	11.5	12.5	14.4	16.6	18.3	20.9				
I	11.5	12.5	14.4	16.6	18.3	20.9					
T	12.5	14.4	16.6	18.3	20.9						
A	14.4	16.6	18.3	20.9							
D	16.6	18.3	20.9								
R	18.3	20.9									
S	27.1	29.6	30.8	33.8	36.8	39.5	42			16.8	C 2000
I	29.6	30.8	33.8	36.8	39.5	42					
M	30.8	33.8	36.8	39.5	42						
M	33.8	36.8	39.5	42							
O	36.8	39.5	42								
N	39.5	42									
S	42										
R	39.5	42								4.4	C 2000
D	42										

LAST SAVED = 12/2/2009
PEN TABLE = VB-Half.tbl
PLOT DRIVER = TR-V8.pdf-Black-Half.plt

FILE NAME =	USER NAME = sdonahue	DESIGNED -	REVISED -
11\0812900\oad\1\plans\19_DBXXXXX-Sht-Sign-02.dgn		DRAWN -	REVISED -
PLOT SCALE = 1.0000' / IN.		CHECKED -	REVISED -
PLOT DATE = 11/4/2010 1:19:45 PM		DATE -	REVISED -



SIGNING DETAILS			
SCALE: NTS	SHEET NO. 4 OF 4 SHEETS	STA.	TO STA.

F.A.U. 9170	TOTAL SHEETS
PORTER / SIMMONS ROADS	36
SECTION 08-00060-00-PV	SHEET NO. 26
CONTRACT 97408	