


SIGN DETAIL
1:75

EB-BM-28
STA. 327+50

SIGN NUMBER	name	
WIDTH x HGHT.	16'-0" x 8'-0"	
BORDER WIDTH	2"	
CORNER RADIUS	12"	
MOUNTING	Overhead	
BACKGROUND	TYPE:	Reflective
	COLOR:	Green
LEGEND/BORDER	TYPE:	Reflective
	COLOR:	White/White

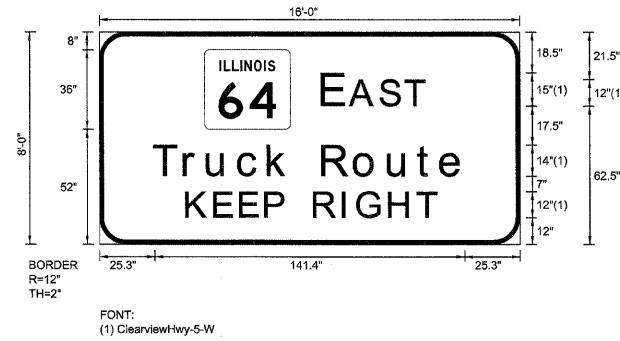

Panel Style: sign_default.ssi
Dimensions are in inches.tenths

Letter locations are panel edge to lower left corner

SYMBOL	ROT	X	Y	WID	HT
MI-100A-2-22-10D	0	48	52	39.3	36

LETTER POSITIONS (X)

																			LENGTH	SERIESIZE
E	A	S	T																	ClearviewHwy-5-W
102.3	115	128.7	140.1																46.5	15,12
T	r	u	c	k		R	o	u	t	e										ClearviewHwy-5-W
25.3	39.4	49.9	64.1	77.6	87.5	102.4	117	132.5	146	156.4									141.4	1411.4
K	E	E	P			R	I	G	H	T										ClearviewHwy-5-W
48.5	59.1	68.9	78.6	85.9	97	108	113.5	125.7	136.3										95	10

FILE NAME =	DESIGNED - SEW	REVISED -
\$FILEL\$	DRAWN - SEW	REVISED -
USER NAME = \$USERS	CHECKED - FML	REVISED -
PLOT DATE = \$DATE\$	DATE - 12/2009	REVISED -



STATE OF ILLINOIS
DEPARTMENT OF TRANSPORTATION

SIGNING DETAILS

SCALE: N.T.S.	SHEET NO. 6 OF 58 SHEETS	STA. TO STA.
---------------	--------------------------	--------------

F.A.I. RTE.	SECTION	COUNTY	TOTAL SHEETS	SHEET NO.
290	2009-099BR	COOK/DUPAGE	394	334
FED. ROAD DIST. NO.			ILLINOIS/FED. AID PROJECT	
			CONTRACT NO. 60157	