


BORDER
R=1.5"
TH=1"
IN=1"

Panel Style: Temp Sign.ssi
M.U.T.C.D.: 2003 Edition

STAGE 2
BLACK LETTERS ON ORANGE BACKGROUND
STA 795+00

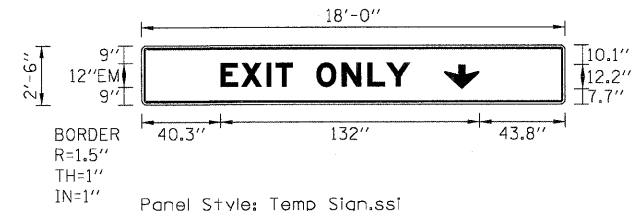

BORDER
R=1.5"
TH=1"
IN=1"

Panel Style: Temp Sign.ssi
M.U.T.C.D.: 2003 Edition

STAGE 2
BLACK LETTERS ON ORANGE BACKGROUND
STA 809+40
STA 836+30

FILE NAME =	DESIGNED - AJP	REVISED -	benesch	STATE OF ILLINOIS DEPARTMENT OF TRANSPORTATION	MAINTENANCE OF TRAFFIC TEMPORARY INFORMATION SIGNING			F.A.I. RTE.	SECTION	COUNTY	TOTAL SHEETS	SHEET NO.
...\\ppin\ABC_C2_TempSignDetails.01.dgn	DRAWN - TMB	REVISED -						290	(3131, ETC., 3435)RS-6	COOK	215	104
USER NAME = jmojewski	CHECKED - JJT	REVISED -						CONTRACT NO. 60K10				
PLOT DATE = 1/25/2010	DATE - 1/25/10	REVISED -						SCALE: N.T.S.	SHEET NO. 50 OF 50 SHEETS	STA.	TO STA.	FED. ROAD DIST. NO.