


SIGN DETAIL
1:75

EB-GM-87
STA. 820+80

SIGN NUMBER	name
WIDTH x HGHT.	25'-6" x 5'-6"
BORDER WIDTH	2"
CORNER RADIUS	9"
MOUNTING	Ground
BACKGROUND	TYPE: Reflective COLOR: Green
LEGEND/BORDER	TYPE: Reflective COLOR: White/White

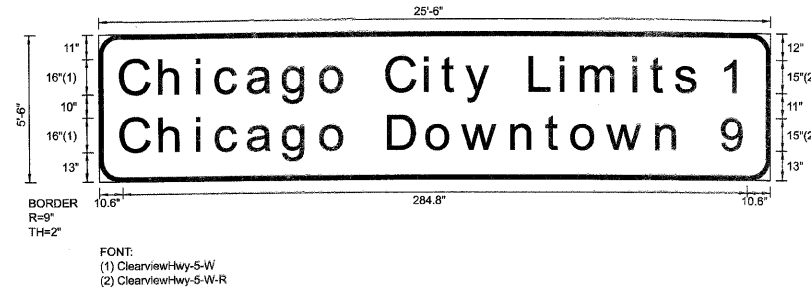

Panel Style: sign_default.ssi
Dimensions are in inches.tenths

Letter locations are panel edge to lower left corner

SYMBOL	ROT	X	Y	WID	HT

LETTER POSITIONS (X)

																							LENGTH	SERIESSIZE
C	h	i	c	a	g	o		C	i	t	y		L	i	m	i	t	s						ClearviewHwy-5-W
10.6	28.4	45.2	54	68.4	84.7	101.8	114.1	131.8	149.2	157.1	167.8	180.3	197.3	211.3	220.7	244.5	252.4	263.7						263.3 1613
1																								ClearviewHwy-5-W-R
283.8																								6.8 15
C	h	i	c	a	g	o		D	o	w	n	t	o	w	n									ClearviewHwy-5-W
10.6	28.4	45.2	54	68.4	84.7	101.8	114.1	132.4	150.2	166.2	188.9	204.4	216.4	232.4	255.2									255.6 1613
9																								ClearviewHwy-5-W-R
284.6																								10.9 15

FILE NAME =	DESIGNED - SEW	REVISED -
FILEL	DRAWN - SEW	REVISED -
USER NAME = *USER*	CHECKED - FML	REVISED -
PLOT DATE = *DATE*	DATE - 1/25/10	REVISED -



STATE OF ILLINOIS
DEPARTMENT OF TRANSPORTATION

SIGNING DETAILS			
SCALE: N.T.S.	SHEET NO. 13 OF 34 SHEETS	STA.	TO STA.

F.A.I. RTE.	SECTION	COUNTY	TOTAL SHEETS	SHEET NO.
290	(3131, ETC., 3435) RS-6	COOK	215	145
FED. ROAD DIST. NO. ILLINOIS FED. AID PROJECT			CONTRACT NO. 60K10	