


SIGN DETAIL
1:75

EB-TR-49
STA. 496+20

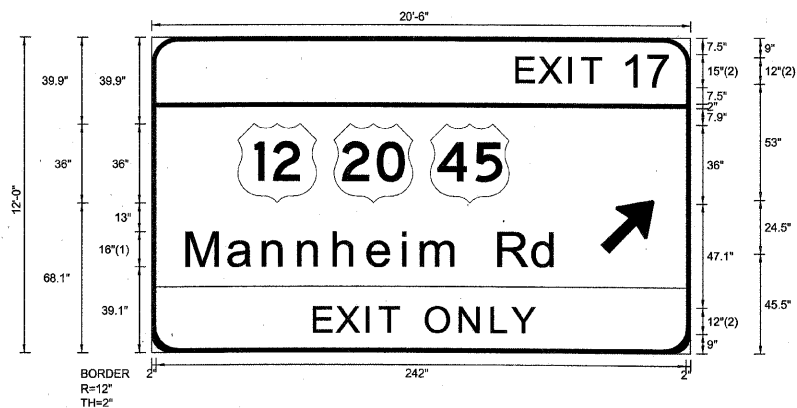

SIGN NUMBER	name
WIDTH x HIGHT.	20'-6" x 12'-0"
BORDER WIDTH	2"
CORNER RADIUS	12"
MOUNTING	Overhead
BACKGROUND	TYPE: Reflective COLOR: Green
LEGEND/BORDER	TYPE: Reflective COLOR: White,Black/White

SYMBOL	ROT	X	Y	WID	HT
M1_4	0	39.3	68.1	36	36
M1_4	0	83.3	68.1	36	36
M1_4	0	127.3	68.1	36	36
ARMED	45	205	45.5	20	31.5

Panel Style: sign_default.ssi
Dimensions are in inches.tenths

FONT:
(1) ClearviewHwy-5-W-R
(2) ClearviewHwy-5-W

Letter locations are panel edge to lower left corner

LETTER POSITIONS (X)

											LENGTH	SERIESSIZE
E	X	I	T	1	7							ClearviewHwy-5-W
167.2	177.4	191.1	197	215.7	226.9						70.3	12,15
M	a	n	n	h	e	i	m	R	d			ClearviewHwy-5-W-R
16.5	35.4	51.4	67.5	83.7	99.2	115.1	123.6	141.6	158.8	174.6	169.7	16/13
E	X	I	T	O	N	L	Y					ClearviewHwy-5-W
74.7	85	98.6	104.6	113.2	125.9	141.3	155.9	165.2			101	12

FILE NAME =	DESIGNED - SEW	REVISED -
#FILEL#	DRAWN - SEW	REVISED -
USER NAME = #USER#	CHECKED - FML	REVISED -
PLOT DATE = #DATE#	DATE - 1/25/10	REVISED -



STATE OF ILLINOIS
DEPARTMENT OF TRANSPORTATION

SIGNING DETAILS

SCALE: N.T.S. SHEET NO. 2 OF 43 SHEETS STA. TO STA.

F.A.I. RTE.	SECTION	COUNTY	TOTAL SHEETS	SHEET NO.
290	(3435, ETC., 3838)RS-5	COOK	264	157
FED. ROAD DIST. NO.			ILLINOIS FED. AID PROJECT	
CONTRACT NO. 60C52				