


SIGN DETAIL
1:75

EB-TR-53
STA. 550+10

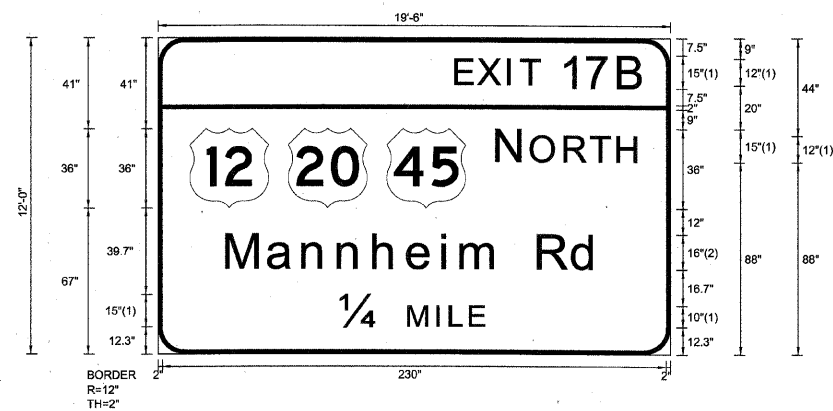

SIGN NUMBER	name
WIDTH x HGHT.	19'-6" x 12'-0"
BORDER WIDTH	2"
CORNER RADIUS	12"
MOUNTING	Overhead
BACKGROUND	TYPE: Reflective COLOR: Green
LEGEND/BORDER	TYPE: Reflective COLOR: WhiteWhite

SYMBOL	ROT	X	Y	WID	HT
M1_4	0	14.4	67	36	36
M1_4	0	59.4	67	36	36
M1_4	0	104.4	67	36	36

Panel Style: sign_default.ssi
Dimensions are in inches.tenths

FONT:
(1) ClearviewHwy-5-W
(2) ClearviewHwy-5-W-R

Letter locations are panel edge to lower left corner

LETTER POSITIONS (X)

											LENGTH	SERIES/SIZE
E	X	I	T	1	7	B						ClearviewHwy-5-W
136.3	146.6	160.2	166.2	184.8	196	211.1					86.1	12,15
N	O	R	T	H								ClearviewHwy-5-W
155.4	170.8	186.3	198.2	210.4							64.1	15,12
M	a	n	n	h	e	i	m	R	d			ClearviewHwy-5-W-R
31.6	50.5	66.5	82.7	98.8	114.4	130.2	138.7	156.8	174	189.7	169.7	16'13
1/4	M	I	L	E								ClearviewHwy-5-W
83.7	114.7	127.9	133.8	142.8							65.5	15,10

FILE NAME =	DESIGNED - SEW	REVISED -
#FILE#	DRAWN - SEW	REVISED -
USER NAME = #USER#	CHECKED - FML	REVISED -
PLOT DATE = #DATE#	DATE - 1/25/10	REVISED -



STATE OF ILLINOIS
DEPARTMENT OF TRANSPORTATION

SIGNING DETAILS

SCALE: N.T.S. SHEET NO. 4 OF 43 SHEETS STA. TO STA.

F.A.I. RTE.	SECTION	COUNTY	TOTAL SHEETS	SHEET NO.
290	(3435, ETC., 3838)RS-5	COOK	264	159
FED. ROAD DIST. NO.			ILLINOIS FED. AID PROJECT	
			CONTRACT NO. 60652	