


SIGN DETAIL
1:75

WB-TR-81
STA. 624+50

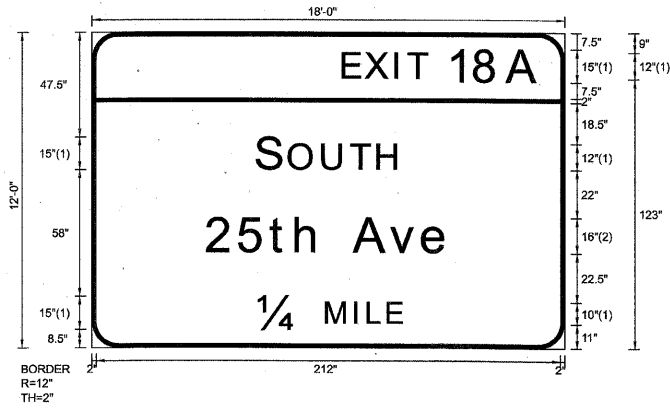

| | |
|---------------|--|
| SIGN NUMBER | name |
| WIDTH x HGHT. | 18'-0" x 12'-0" |
| BORDER WIDTH | 2" |
| CORNER RADIUS | 12" |
| MOUNTING | Overhead |
| BACKGROUND | TYPE: Reflective COLOR: Green |
| LEGEND/BORDER | TYPE: Reflective COLOR: White/White |

Panel Style: sign_default.ssi
Dimensions are in inches.tenths

FONT:
(1) ClearviewHwy-5-W
(2) ClearviewHwy-5-W-R

Letter locations are panel edge to lower left corner

| SYMBOL | ROT | X | Y | WID | HT |
|--------|-----|---|---|-----|----|
| | | | | | |
| | | | | | |
LETTER POSITIONS (X)

| | | | | | | | | | | | | | LENGTH | SERIESIZE |
|-------|-------|-------|-------|-------|-------|-------|-------|--|--|--|--|--|--------|--------------------|
| E | X | I | T | 1 | 8 | A | | | | | | | | ClearviewHwy-5-W |
| 115.1 | 125.3 | 139 | 144.9 | 163.6 | 175.7 | 190.4 | | | | | | | 89.3 | 12,15 |
| S | O | U | T | H | | | | | | | | | | ClearviewHwy-5-W |
| 75.8 | 90.5 | 105.9 | 118.8 | 131 | | | | | | | | | 64.4 | 15,12 |
| 2 | 5 | t | h | | A | v | e | | | | | | | ClearviewHwy-5-W-R |
| 52.8 | 67.8 | 81.8 | 93.6 | 104.7 | 120.2 | 136.7 | 151.4 | | | | | | 110.4 | 16,13 |
| 14 | M | I | L | E | | | | | | | | | | ClearviewHwy-5-W |
| 76.5 | 107.5 | 120.6 | 126.5 | 135.6 | | | | | | | | | 65.5 | 15,10 |

| | | |
|--------------------|----------------|-----------|
| FILE NAME = | DESIGNED - SEW | REVISED - |
| FILE# | DRAWN - SEW | REVISED - |
| USER NAME = #USER# | CHECKED - FML | REVISED - |
| PLOT DATE = #DATE# | DATE - 1/25/10 | REVISED - |



STATE OF ILLINOIS
DEPARTMENT OF TRANSPORTATION

SIGNING DETAILS

SCALE: N.T.S. SHEET NO. 36 OF 43 SHEETS STA. TO STA.

| F.A.I. RTE. | SECTION | COUNTY | TOTAL SHEETS | SHEET NO. |
|---------------------|------------------------|---------------------------|--------------|-----------|
| 290 | (3435, ETC., 3838)RS-5 | COOK | 264 | 191 |
| FED. ROAD DIST. NO. | | ILLINOIS FED. AID PROJECT | | |

CONTRACT NO. 60G52