


SIGN DETAIL  
1:75

EB-BM-101  
STA. 997+70

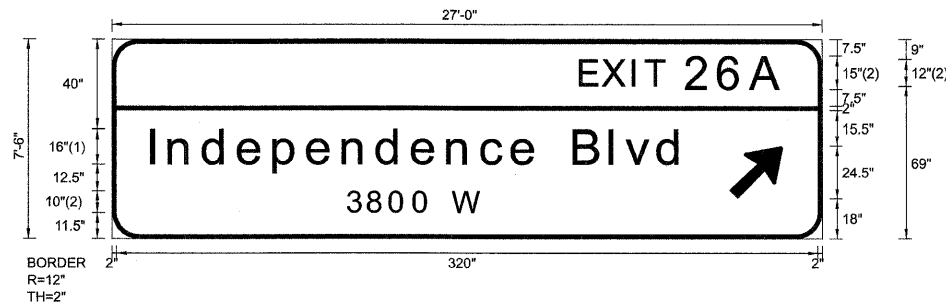

FONT:  
(1) ClearviewHwy-5-W-R  
(2) ClearviewHwy-5-W

Panel Style: sign\_default.ssi  
Dimensions are in inches.tenths

Letter locations are panel edge to lower left corner

|               |  |
|---------------|--|
| SIGN NUMBER   | name                                   |
| WIDTH x HGHT. | 27'-0" x 7'-6"                         |
| BORDER WIDTH  | 2"                                     |
| CORNER RADIUS | 12"                                    |
| MOUNTING      | Overhead                               |
| BACKGROUND    | TYPE: Reflective<br>COLOR: Green       |
| LEGEND/BORDER | TYPE: Reflective<br>COLOR: White/White |

| SYMBOL | ROT | X     | Y  | WID | HT   |
|--------|-----|-------|----|-----|------|
| ARMED  | 45  | 281.5 | 18 | 20  | 31.5 |
|        |     |       |    |     |      |
|        |     |       |    |     |      |
|        |     |       |    |     |      |
|        |     |       |    |     |      |
|        |     |       |    |     |      |

LETTER POSITIONS (X)

|       |       |       |       |       |       |       |       |       |       |     |       |       |       |       |       |       |  |  |  | LENGTH | SERIESSIZE                 |
|-------|-------|-------|-------|-------|-------|-------|-------|-------|-------|-----|-------|-------|-------|-------|-------|-------|--|--|--|--------|----------------------------|
| E     | X     | I     | T     | 2     | 6     | A     |       |       |       |     |       |       |       |       |       |       |  |  |  | 92     | ClearviewHwy-5-W<br>12,15  |
| 214   | 224.3 | 237.9 | 243.8 | 262.5 | 277.6 | 292   |       |       |       |     |       |       |       |       |       |       |  |  |  | 243    | ClearviewHwy-5-W-R<br>1613 |
| I     | n     | d     | e     | p     | e     | n     | d     | e     | n     | c   | e     | B     | I     | v     | d     |       |  |  |  | 61.3   | ClearviewHwy-5-W-R<br>10   |
| 18    | 26.4  | 41.9  | 57.9  | 74.1  | 89.5  | 105.7 | 121.3 | 137.3 | 153.5 | 169 | 182.9 | 194.6 | 211.2 | 227.8 | 234.7 | 249.4 |  |  |  |        |                            |
| 3     | 8     | 0     | 0     |       | W     |       |       |       |       |     |       |       |       |       |       |       |  |  |  |        |                            |
| 107.4 | 116.9 | 126.9 | 137.8 | 146   | 155.5 |       |       |       |       |     |       |       |       |       |       |       |  |  |  |        |                            |

|                    |                |           |
|--------------------|----------------|-----------|
| FILE NAME =        | DESIGNED - SEW | REVISED - |
| *FILEL*            | DRAWN - SEW    | REVISED - |
| USER NAME = *USER* | CHECKED - SEW  | REVISED - |
| PLOT DATE = *DATE* | DATE - 1/25/10 | REVISED - |



STATE OF ILLINOIS  
DEPARTMENT OF TRANSPORTATION

SIGNING DETAILS

SCALE: N.T.S. SHEET NO. 6 OF 34 SHEETS STA. TO STA.

| F.A.I. RTE.                                   | SECTION                | COUNTY | TOTAL SHEETS       | SHEET NO. |
|---|------------------------|--------|--------------------|-----------|
| 290   | (2727, ETC., 3131)RS-7 | COOK   | 216                | 130       |
| FED. ROAD DIST. NO. ILLINOIS FED. AID PROJECT |                        |        | CONTRACT NO. 60G53 |           |