


SIGN DETAIL  
1:75

WB-BM-111  
STA. 931+90

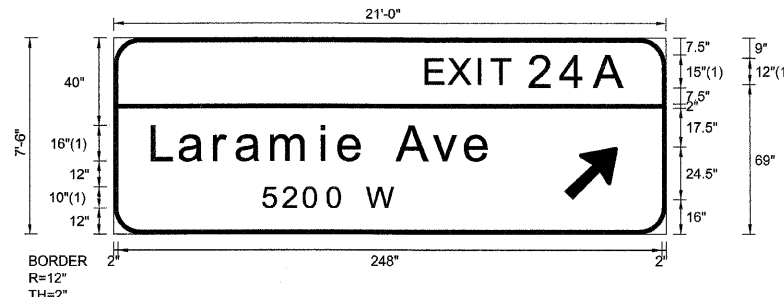

FONT:  
(1) ClearviewHwy-5-W

SIGN NUMBER	name
WIDTH x HGHT.	21'-0" x 7'-6"
BORDER WIDTH	2"
CORNER RADIUS	12"
MOUNTING	Overhead
BACKGROUND	TYPE: Reflective COLOR: Green
LEGEND/BORDER	TYPE: Reflective COLOR: White/White

SYMBOL	ROT	X	Y	WID	HT
ARMED	45	205.5	16	20	31.5

Panel Style: sign\_default.ssi  
Dimensions are in inches.tenths

Letter locations are panel edge to lower left corner

LETTER POSITIONS (X)

															LENGTH	SERIESSIZE
E	X	I	T	2	4	A									91.1	ClearviewHwy-5-W 12,15
142.9	153.2	166.9	172.8	190.4	204.9	220										
L	a	r	a	m	i	e	A	v	e						154.6	ClearviewHwy-5-W-R 16/13
18	30.4	46.4	56.4	72.4	95.2	103	114.8	129.6	146.2	160.9						
5	2	0	0		W										60.4	ClearviewHwy-5-W-R 10
68.4	77.4	87	97.9	106	115.6											

FILE NAME =	DESIGNED - SEW	REVISED -
*FILEL*	DRAWN - SEW	REVISED -
USER NAME = *USER*	CHECKED - SEW	REVISED -
PLOT DATE = *DATE*	DATE - 1/25/10	REVISED -



STATE OF ILLINOIS  
DEPARTMENT OF TRANSPORTATION

SIGNING DETAILS

SCALE: N.T.S. SHEET NO. 20 OF 34 SHEETS STA. TO STA.

F.A.I. RTE.	SECTION	COUNTY	TOTAL SHEETS	SHEET NO.
290	(2727, ETC., 3131)RS-7	COOK	216	144
FED. ROAD DIST. NO. ILLINOIS FED. AID PROJECT			CONTRACT NO. 60G53	