


NOTE:

1. THE EXISTING 310W HPS LUMINAIRE SHALL BE REMOVED AND TEMPORARY 400W HPS TYPE III LUMINAIRE SHALL BE INSTALLED ON EXISTING LIGHTING UNIT. THE CONTRACTOR SHALL REMOVE TEMPORARY 400W LUMINAIRE AND REINSTALL 310W EXISTING LUMINAIRE AFTER COMPLETION OF STAGE 2.
2. THE UNIT DUCT INSTALLED FOR TEMPORARY LIGHTING DURING PRE-STAGE 1 SHALL BE REMOVED AND DISPOSED OF OFF THE SITE DURING WOOD POLE REMOVAL. THE COST OF UNIT DUCT REMOVAL SHALL BE INCLUDED IN TEMPORARY WOOD POLE REMOVAL.

NOTES FOR LIGHTING DURING CONSTRUCTION

A. COMPLETE TEMPORARY LIGHTING SYSTEM INCLUDING, RELOCATION OF EXISTING CONTROLLER, TEMPORARY LIGHTING UNITS, AERIAL CABLES, AND OTHER TEMPORARY LIGHTING ITEMS SHOWN ON THE TEMPORARY LIGHTING PLANS SHALL BE INSTALLED IN APPROVED OPERATION DURING PRE-STAGE 1 CONSTRUCTION PRIOR TO REMOVAL OF EXISTING LIGHTING SYSTEM UNLESS NOTED OTHERWISE.

B. TEMPORARY LIGHTING SYSTEM SHALL BE REMOVED AFTER PROPOSED LIGHTING SYSTEM IS INSTALLED IN APPROVED OPERATION.

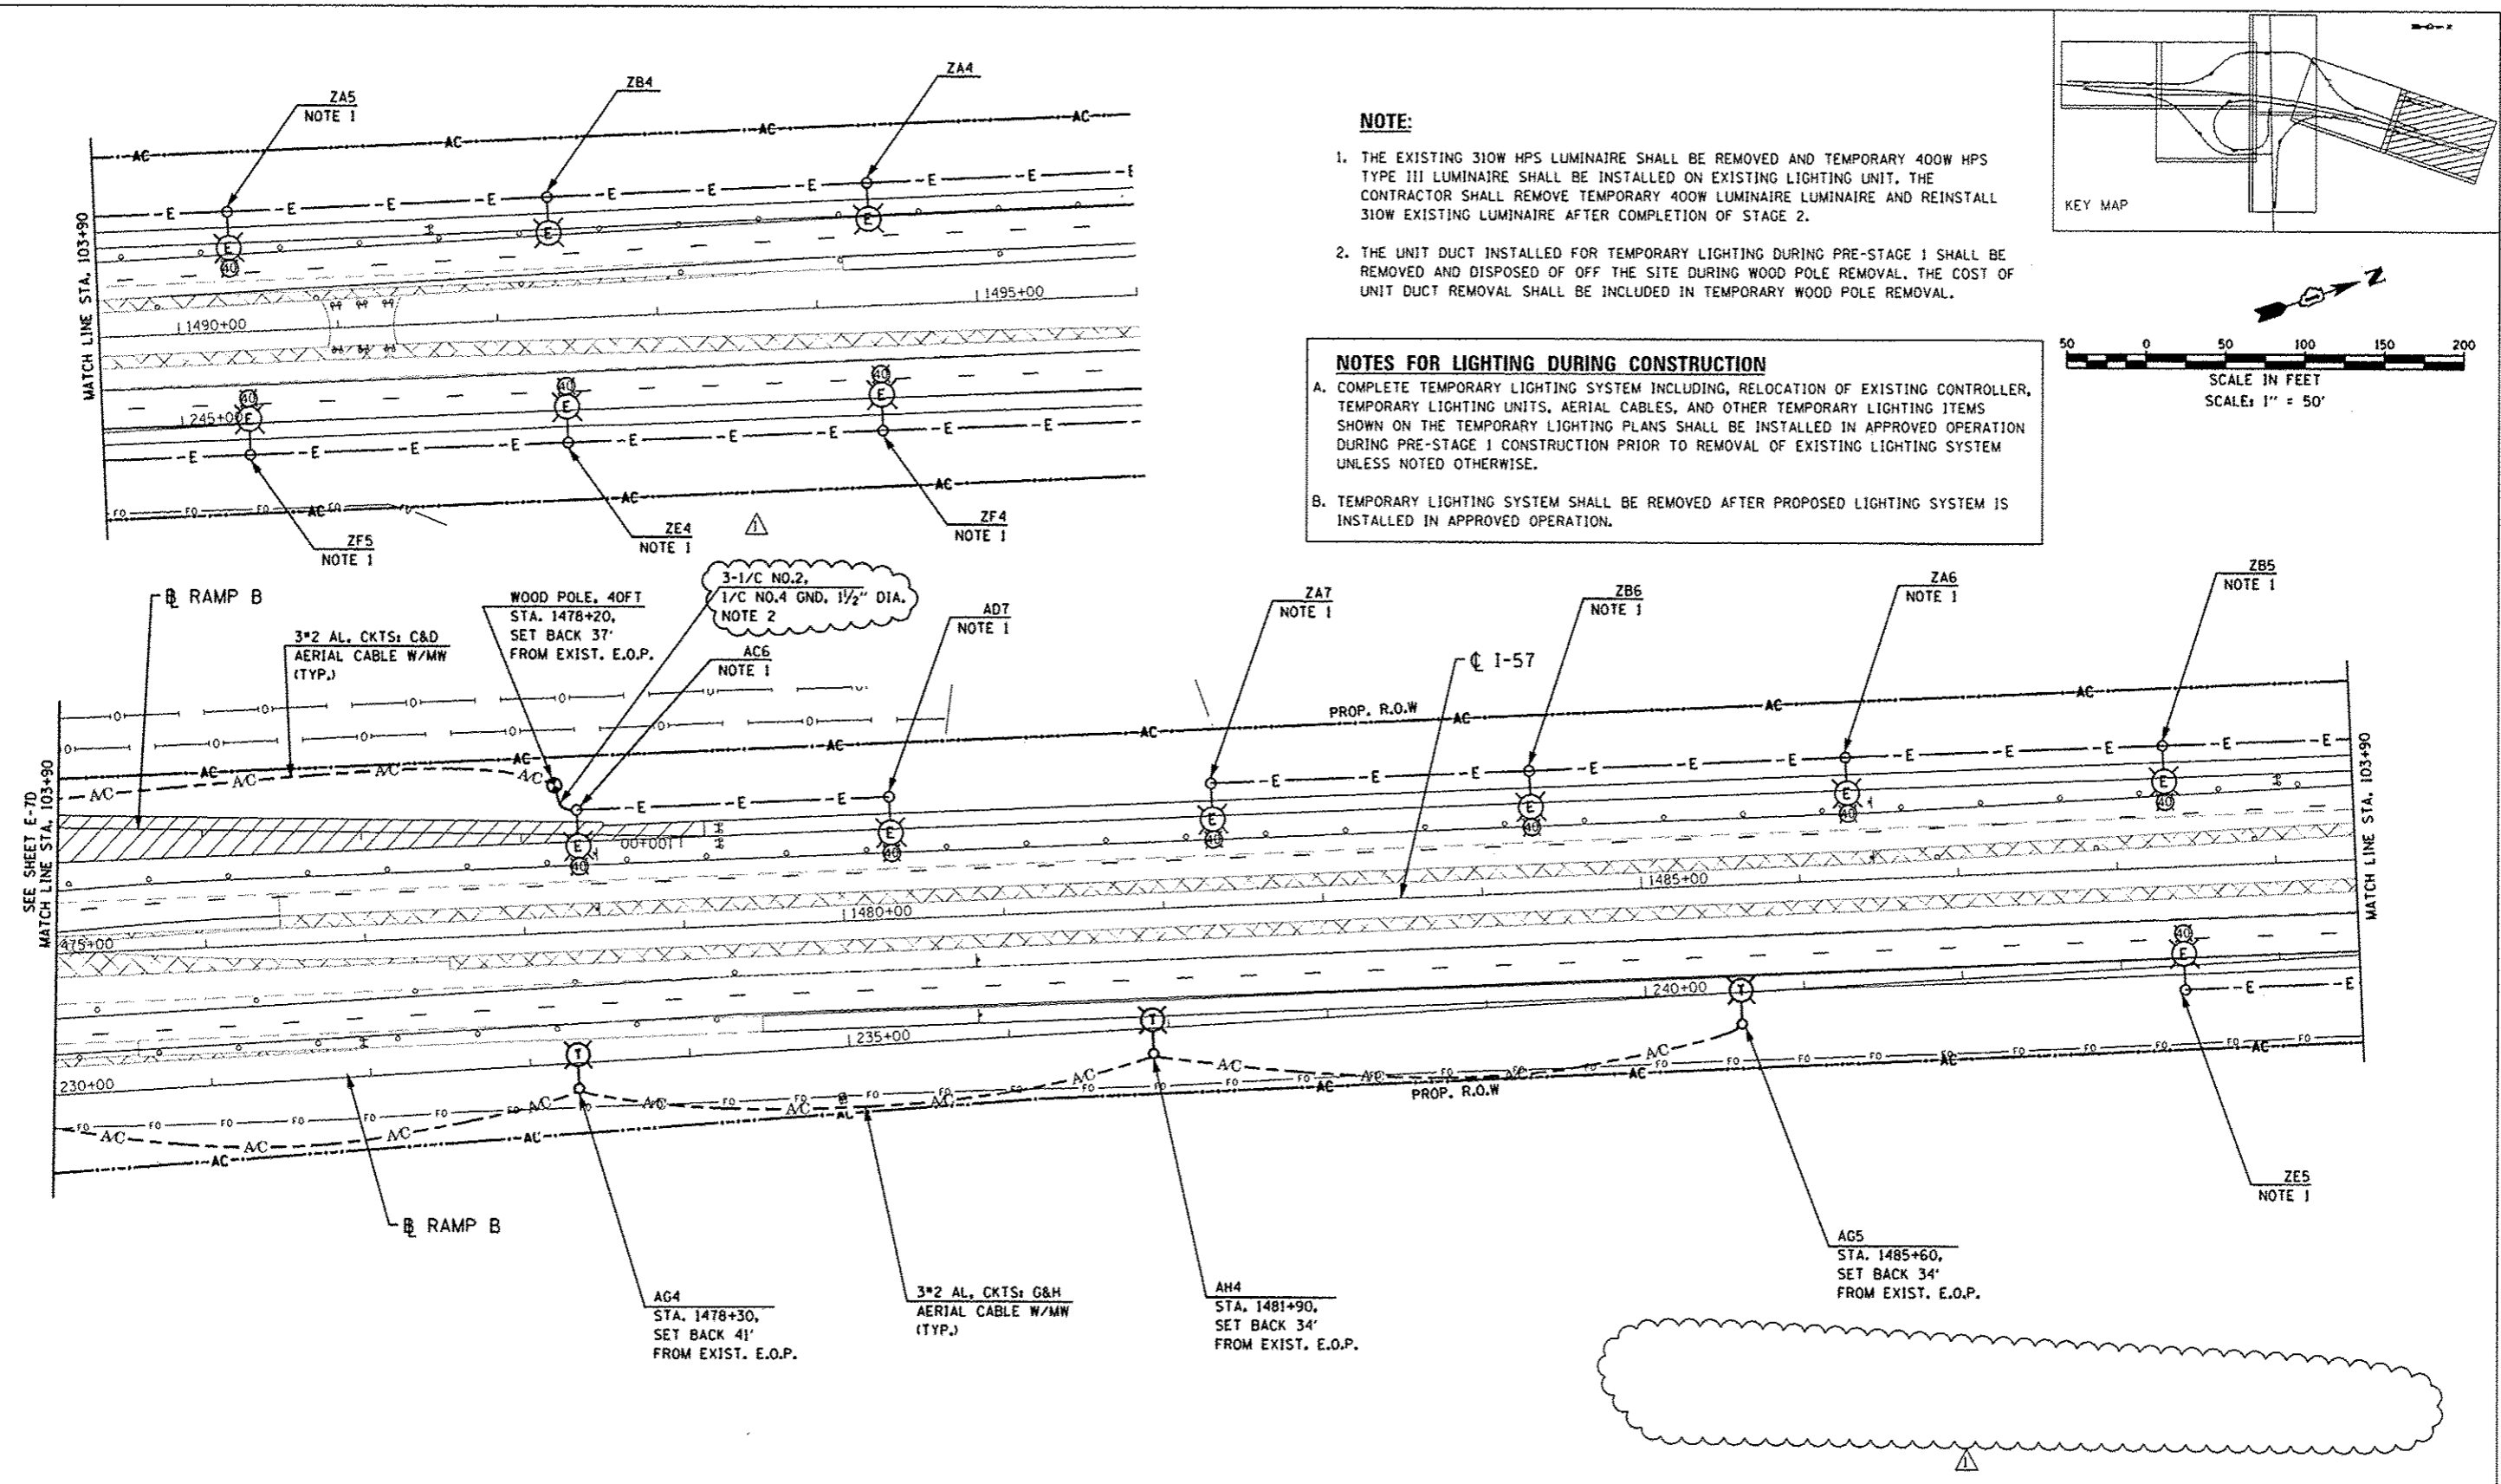

I:\371\DCN\CADD_Sheets\606069-shr-light-07e.dgn
 26-DEC-2013 15:08:15:08



USER NAME	* kprajapati	DESIGNED	- RDP	REVISED	6/18/2013
PLOT SCALE	* 1/8"=100'	DRAWN	- MG/WC	REVISED	8/22/2013
PLOT DATE	* 26-DEC-2013 15:08	CHECKED	- KGP	REVISED	10/18/2013
		DATE	- 8/22/2013	REVISED	12/04/2013

STATE OF ILLINOIS
DEPARTMENT OF TRANSPORTATION

STUENKEL ROAD OVER I-57
TEMPORARY LIGHTING PLANS - STAGE 1&2
SCALE: AS NOTED SHEET NO. 12 OF 24 SHEETS STA. ----- TO STA. -----

F.A.I. RTE.	SECTION	COUNTY	TOTAL SHEETS	SHEET NO.
57	99-1HB-R	WILL	679	330E
CONTRACT NO. 60L69				

E-7E

ADDENDUM 1 1/03/14