


- NOTES:**
1. THE EXISTING LIGHT POLE, METAL FOUNDATION AND BREAKAWAY TRANSFORMER BASE SHALL BE REMOVED. THE METAL FOUNDATION SHALL BE REMOVED AND DISPOSED OF OFF THE PROJECT SITE. REMOVED LIGHT POLE AND BREAKAWAY TRANSFORMER BASE SHALL BE REINSTALLED AS SHOWN ON PROPOSED LIGHTING PLANS. THE REMOVAL, STORAGE DURING CONSTRUCTION AND REINSTALLATION OF REMOVED LIGHT POLE AND BREAKAWAY TRANSFORMER BASE SHALL BE PART OF THE PAY ITEM "RELOCATE EXISTING LIGHTING UNIT"
  2. THE EXISTING LIGHT POLE SHALL BE REMOVED, METAL FOUNDATION AND BREAKAWAY TRANSFORMER BASE SHALL REMAIN IN PLACE. THE REMOVAL, STORAGE DURING CONSTRUCTION AND REINSTALLATION OF REMOVED LIGHT POLE SHALL BE PART OF THE PAY ITEM "RELOCATE EXISTING LIGHTING UNIT"
  3. THE EXISTING 310W HPS LUMINAIRE SHALL BE REMOVED AND TEMPORARY 400W HPS TYPE III LUMINAIRE SHALL BE INSTALLED ON EXISTING LIGHTING UNIT. THE CONTRACTOR SHALL STORE THE EXISTING 310W HPS LUMINAIRE AND REINSTALL WITH NEW LAMP AFTER COMPLETION OF STAGE 2 CONSTRUCTION.
  4. THE EXISTING LIGHTING SYSTEM SHALL BE REMOVED AFTER TEMPORARY LIGHTING SYSTEM IS INSTALLED AND MADE OPERATIONAL.

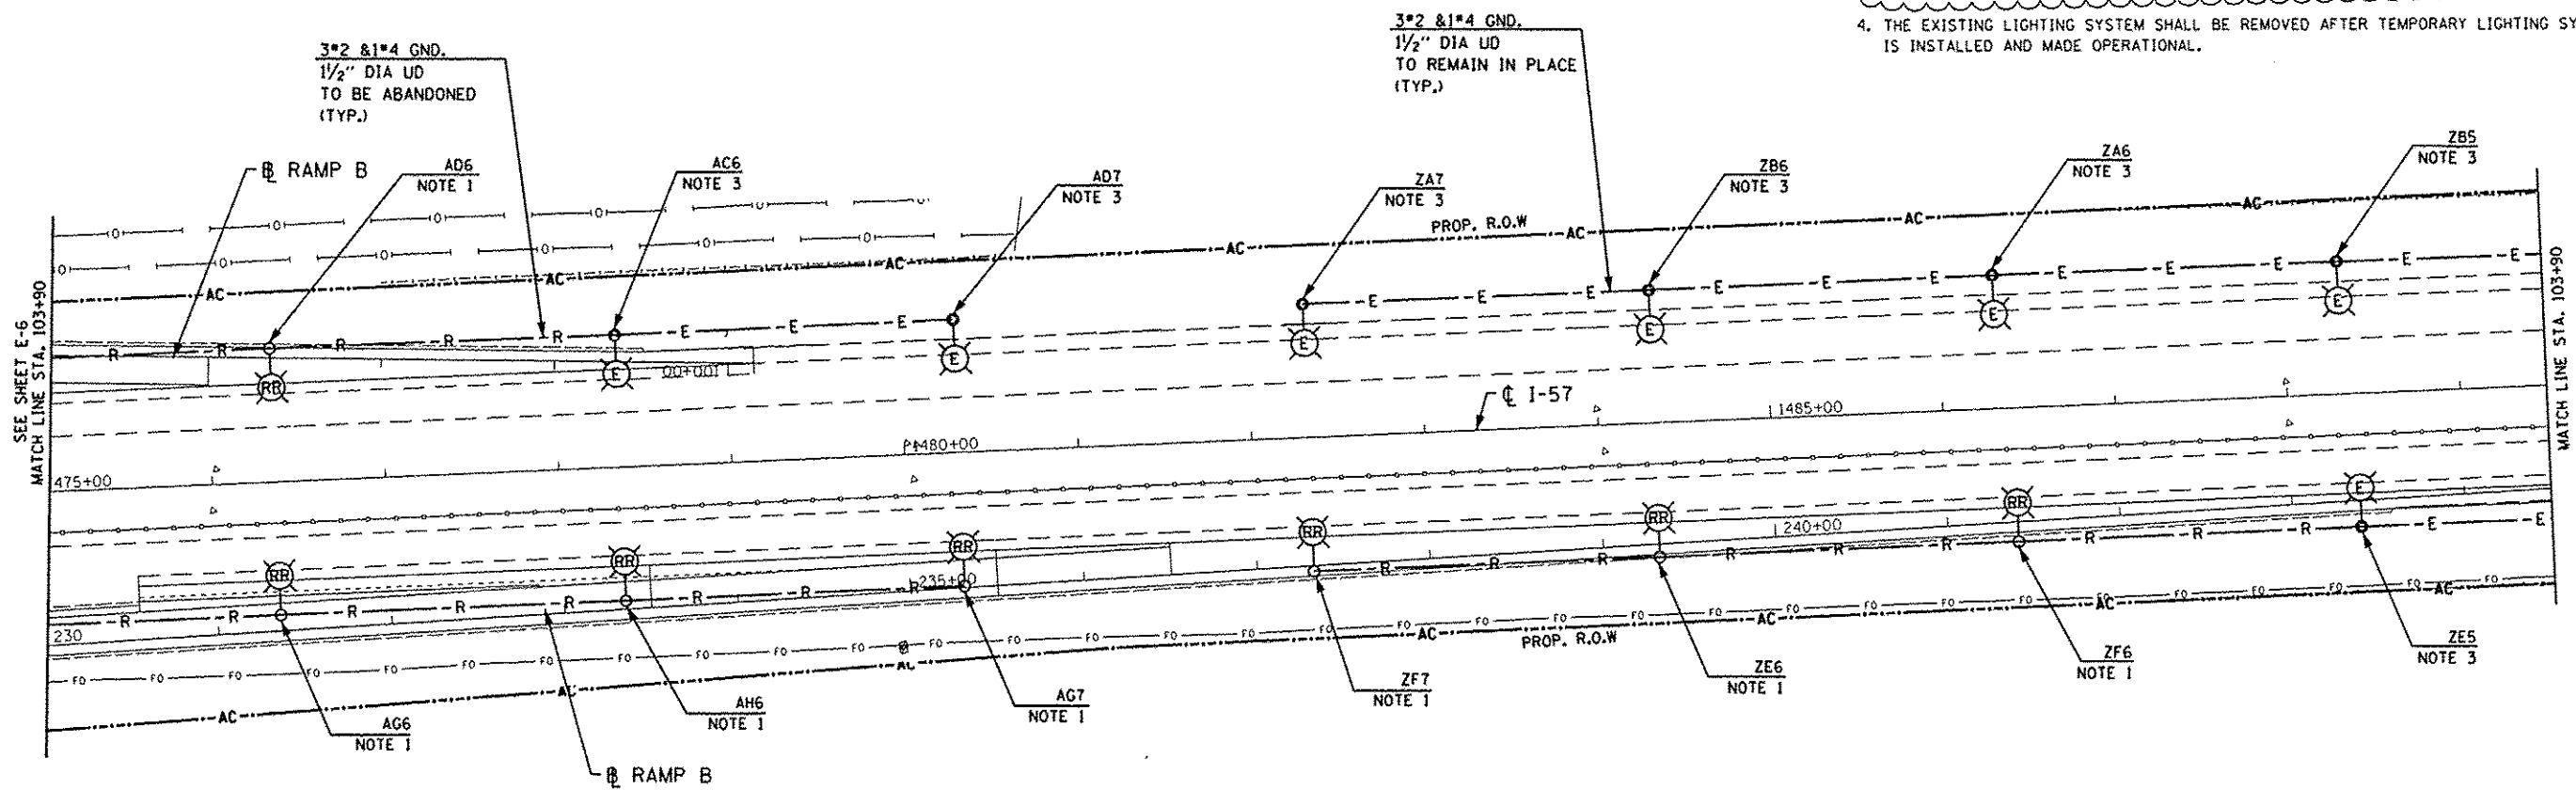

J:\327\00\KVC400\_Sheets\60L69-sh1-light-07.dgn  
 26-DEC-2013 15:01:15

<b>SINGH</b> SINGH ASSOCIATES, INC. CONSULTING ENGINEERS	USER NAME: kprojeppati PLOT SCALE: 1/80,000,000 PLOT DATE: 26-DEC-2013 15:01	DESIGNED: RDP DRAWN: MG/WC CHECKED: KGP DATE: 8/22/2013	REVISED: 6/18/2013 REVISED: 8/22/2013 REVISED: 10/18/2013 REVISED: 12/04/2013	STATE OF ILLINOIS DEPARTMENT OF TRANSPORTATION	STUENKEL ROAD OVER I-57 EXISTING LIGHTING REMOVAL PLANS	F.A.I. RTE.: 57 SECTION: 99-1HB-R COUNTY: WILL CONTRACT NO.: 60L69	TOTAL SHEETS: 330 SHEET NO.: 330
	SCALE: AS NOTED   SHEET NO. 7 OF 24 SHEETS   STA. ----- TO STA. -----				ILLINOIS FED. AID PROJECT		