
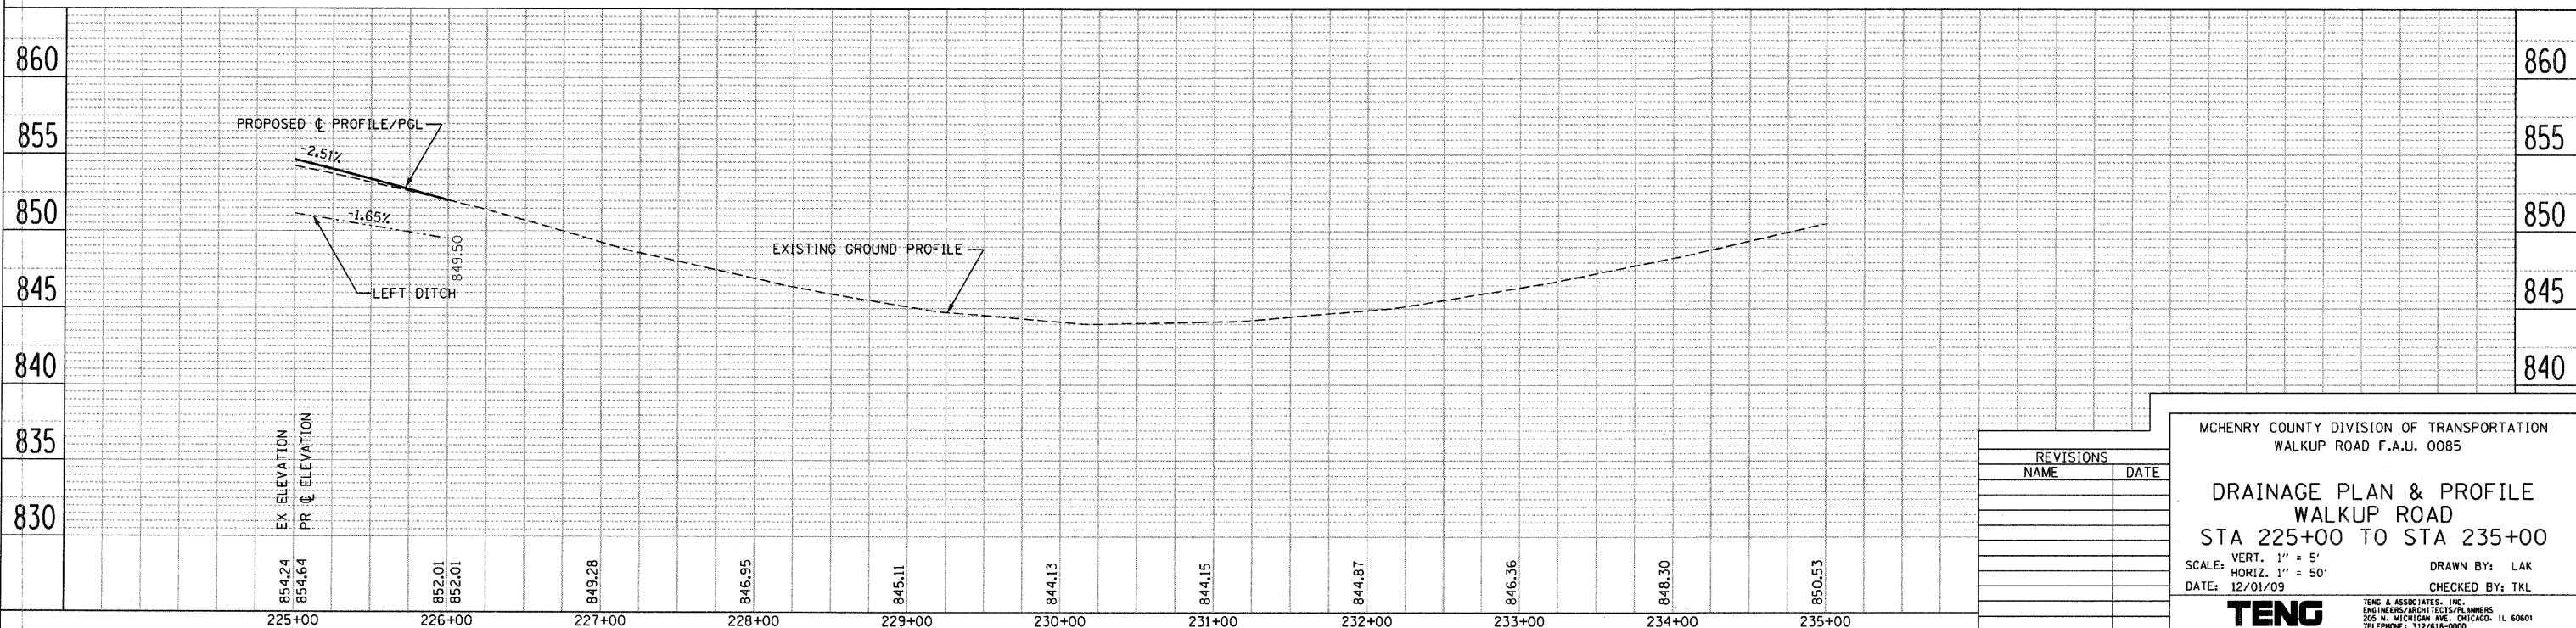
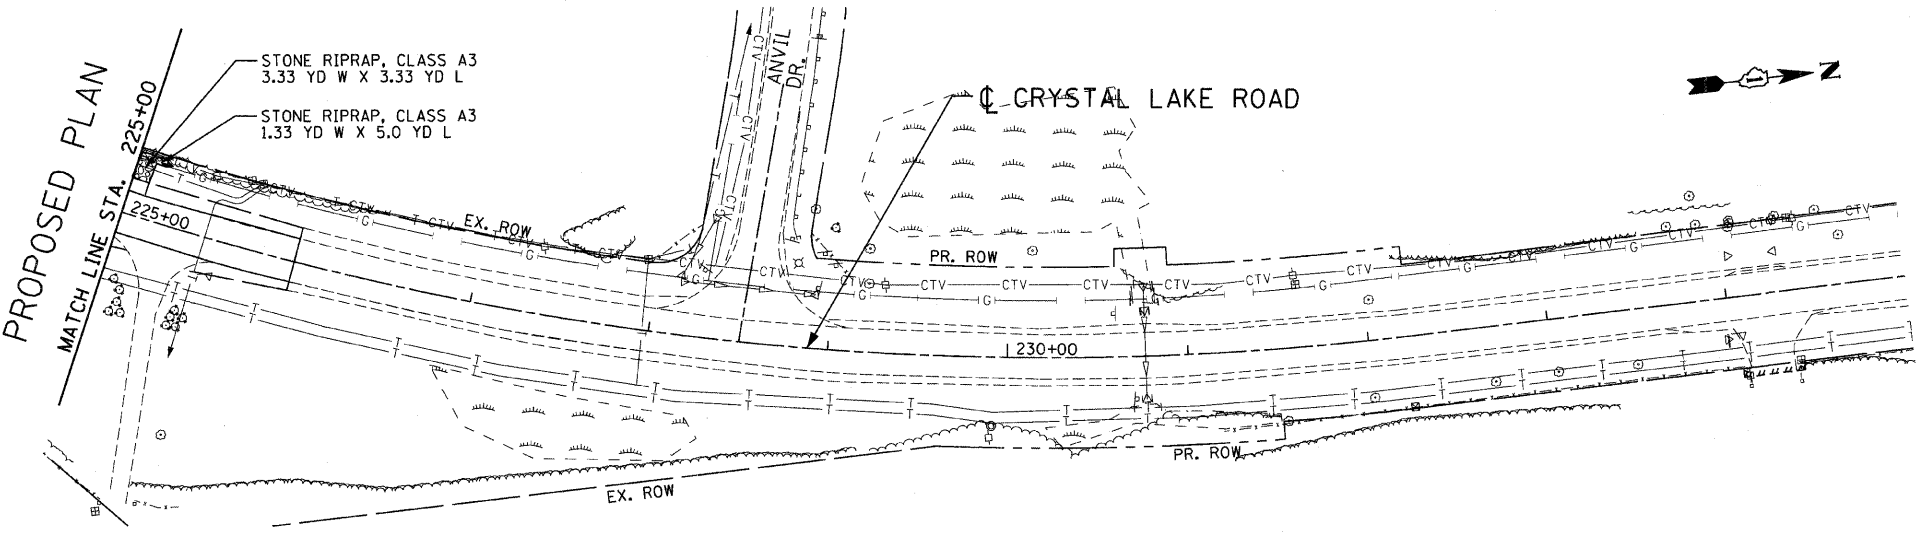


F.A.U. RTE.	SECTION	COUNTY	TOTAL SHEETS	SHEET NO.
0085	00-00246-01-FP	MCHENRY	236	85
STA.	TO STA.			
FED. ROAD DIST. NO. 1		ILLINOIS	FED. AID PROJECT	
CONTRACT NO: 63266				

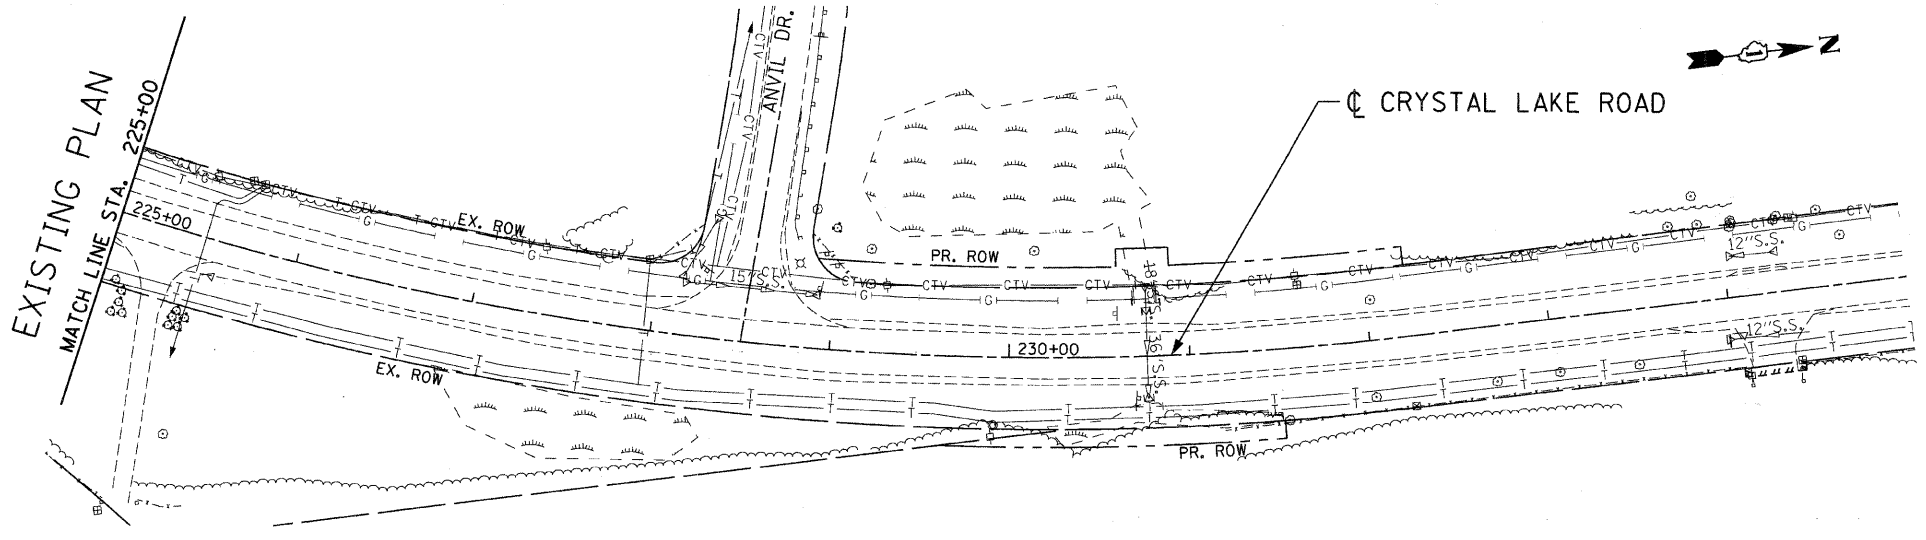

REVISIONS	
NAME	DATE

MCHENRY COUNTY DIVISION OF TRANSPORTATION
WALKUP ROAD F.A.U. 0085

DRAINAGE PLAN & PROFILE
WALKUP ROAD
STA 225+00 TO STA 235+00

SCALE: VERT. 1" = 5'
HORIZ. 1" = 50'

DATE: 12/01/09

DRAWN BY: LAK
CHECKED BY: TKL

TENG

TENG & ASSOCIATES, INC.
ENGINEERS/ARCHITECTS/PLANNERS
205 N. MICHIGAN AVE., CHICAGO, IL 60601
TELEPHONE: 312/616-0000

PLAN: SURVEYED, PLOTTED, CHECKED, BY, DATE, NO. 1, CAD FILE NAME

PROFILE: SURVEYED, PLOTTED, CHECKED, BY, DATE, NO. 1, STRUCTURE, NOTATION, CHKD

\\ALTO004\ADON... \VTBODY\VDON... \ROWWOOD\BRADON... \NUTLOR\BRADON... \DRA000\BRADON... \P0000\BRADON... \STANKRU...
11-30-2005 9:24:51
I:\23456789 0 1 12 13 14 15 16 17 18 19 20 21 22 23 24 25 26 27 28 29 30 31 32 33 34 35 36 37 38 39 40 41 42 43 44 45 46 47 48 49 50 51 52 53 54 55 56 57 58 59 60 61 62 63