


- NOTES:**
1. CONTRACTOR WILL BE RESPONSIBLE FOR CONTACTING PUBLIC UTILITY COMPANY TO ADJUST THEIR STRUCTURES IN THE PUBLIC ROW.
 2. CONTRACTOR WILL BE RESPONSIBLE FOR CONFIRMING ANY LIVE SEWER LINES AND LET ENGINEER KNOW BEFORE ABANDONING OR REMOVING STRUCTURES.
 3. ALL ABANDONED SEWERS SHALL BE PLUGGED AT BOTH ENDS WITH A MINIMUM OF TWO (2) FEET LONG NON-SHRINK CONCRETE OR MORTAR PLUGS.
 4. RESILIENT CONNECTORS (ASTM C-923) SHALL BE PROVIDED BETWEEN STRUCTURES AND PIPES FOR ALL PROPOSED PIPES CONNECTING TO EXISTING AND PROPOSED STRUCTURES AND ALL PROPOSED STRUCTURES CONNECTING TO EXISTING AND PROPOSED PIPES.

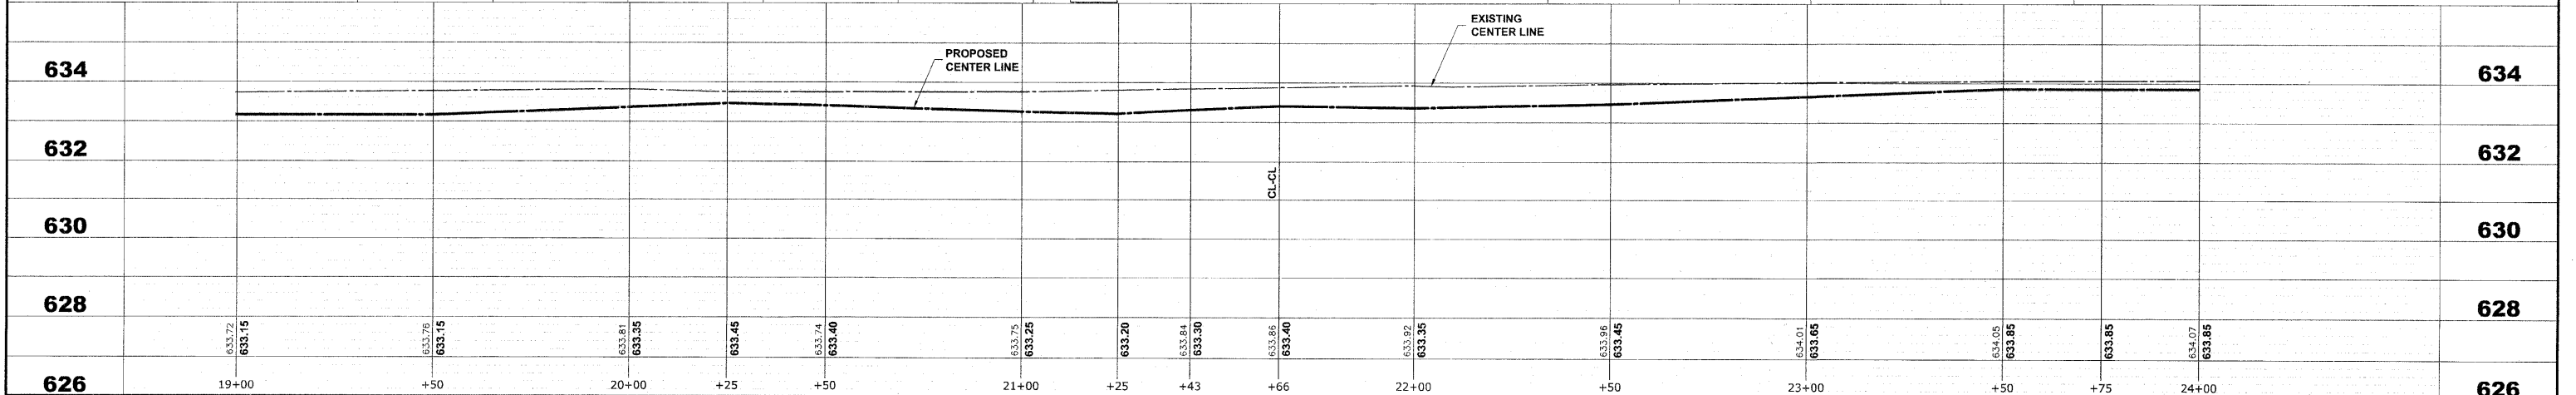

<p>1911 Belmont Road Waukegan, Illinois 60094-2700 Phone: 815-491-4100 Fax: 815-491-4101</p>	USER NAME -	DESIGNED - MK/SBC	REVISED -	STATE OF ILLINOIS DEPARTMENT OF TRANSPORTATION	ST. CHARLES ROAD UTILITIES PLAN AND PROFILE	F.A.U. R.T.E. 1397	SECTION 09-00129-00-PV	COUNTY COOK	TOTAL SHEETS 103	SHEET NO. 39		
	PLOT SCALE -	CHECKED - SBC/JG/MV	REVISED -			SCALE: 1"=20'H./2'V.	SHEET NO. 4 OF 11 SHEETS	STA. 19+00	TO STA. 24+00	CONTRACT NO. 63428		
	PLOT DATE -	DATE - 11-30-09	REVISED -				FED. ROAD DIST. NO. 1 ILLINOIS			FED. AID PROJECT M-9003 (267)	(BOOK NOS. 1579, 1583, 1589) E.H.E PROJECT NO. 565-08-29001	

Drawing file: R:\Projects\66502900 - St. Charles Rd\St. Charles Rd\St. Charles Rd.dwg Dec 07, 2009 5:42pm