



NOTES:

- 1) THE LIGHTING SYSTEM SHALL BE CONSTRUCTED IN PHASES. LIGHTING SHALL BE MAINTAINED OPERATIONAL ON ONE SIDE OF THE ROAD AS THE OPPOSITE SIDE IS BEING CONSTRUCTED.
- 2) EXISTING ALUMINUM LIGHTING UNITS REMOVED SHALL BE SALVAGED AND DELIVERED TO FACILITY DESIGNATED BY VILLAGE OF SKOKIE.

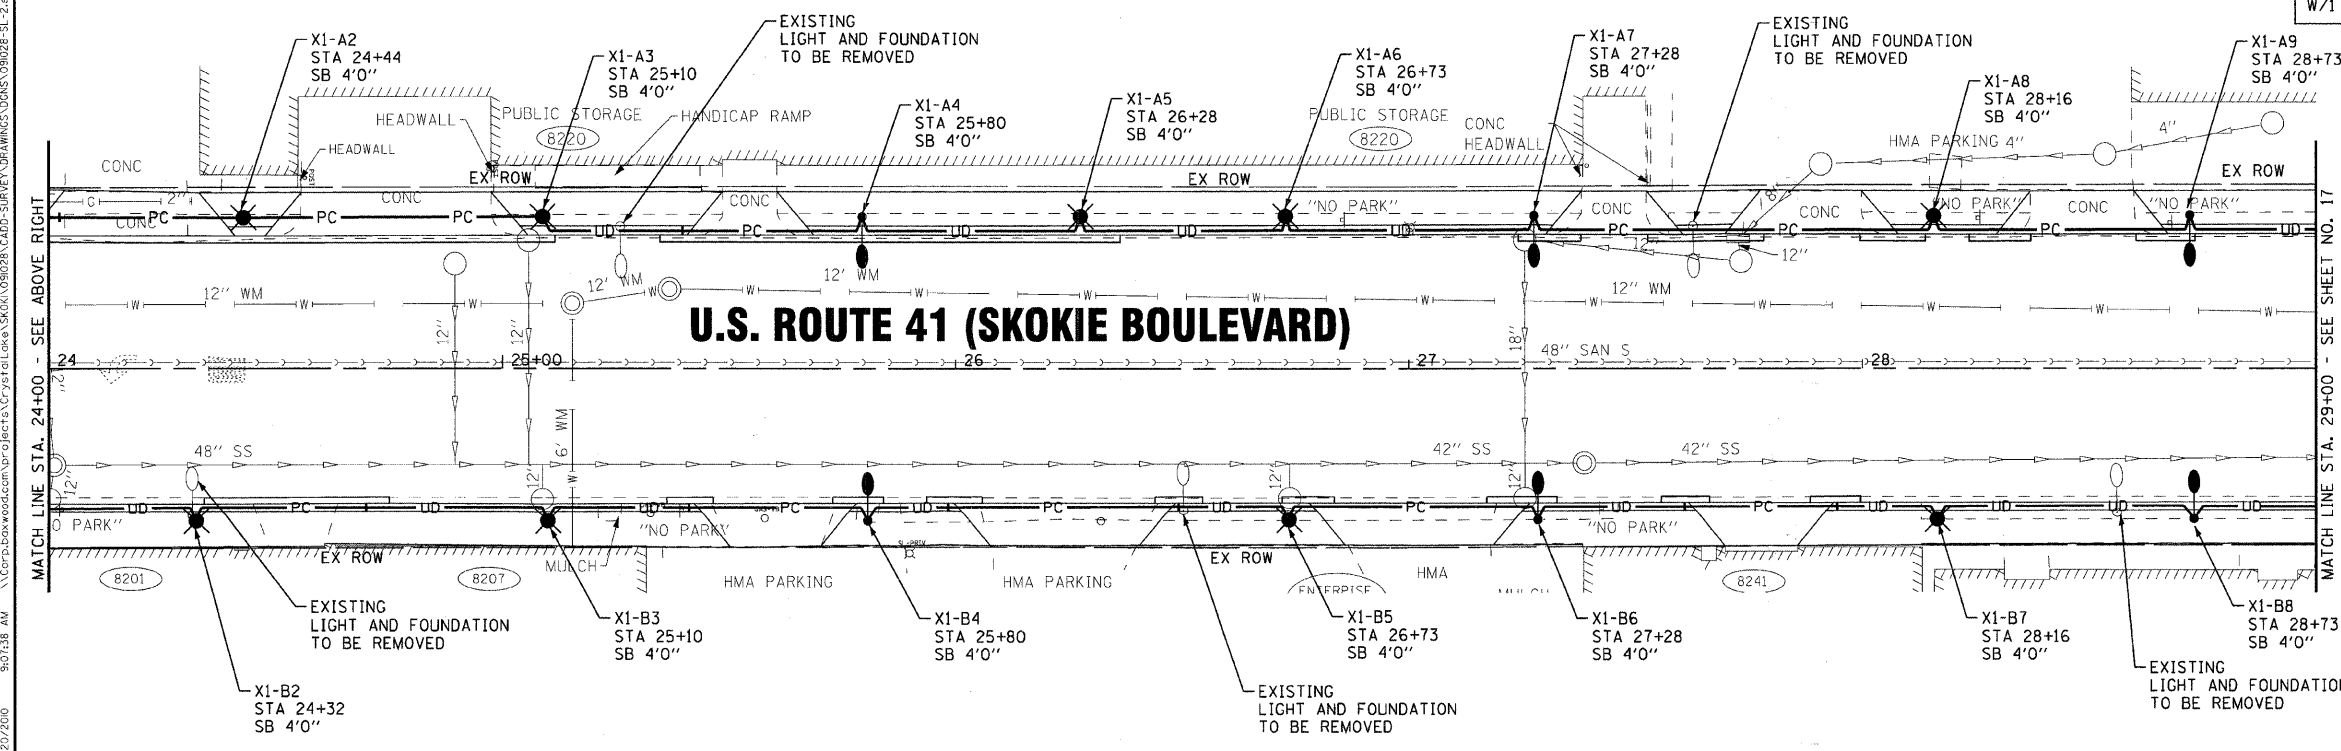

COPYRIGHT © 2009 BY BAXTER & WOODMAN, INC.
 STATE OF ILLINOIS - PROFESSIONAL DESIGN FIRM
 LICENSE NO. 0184-00181 - EXPRESS 4/20/2011
 1/22/2010 10:50:18 AM \\G:\P\B\woodman\projects\Crystal Lake\Skokie\091028-LS-2.sht

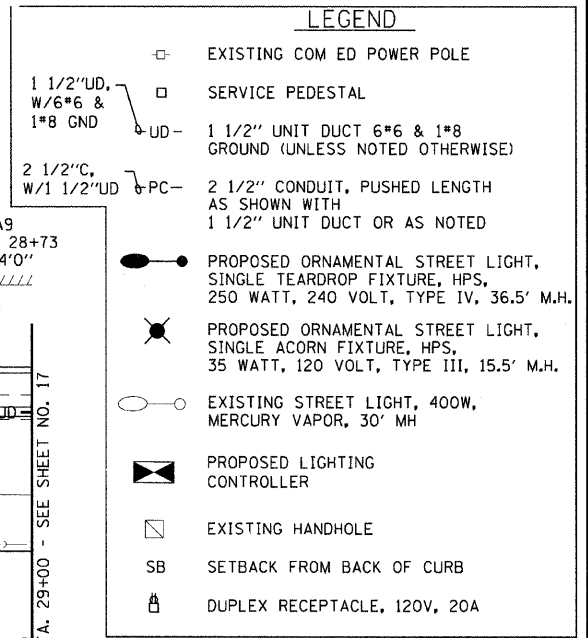

DESIGNED - OKA	REVISED - IDOT REVIEW 11/23/09
DRAWN - MAC	REVISED - IDOT REVIEW 01/19/10
CHECKED - OKA	REVISED -
DATE - 10-16-2009	FILE - 091028-LS-2.sht

VILLAGE OF SKOKIE, ILLINOIS
U.S. ROUTE 41 (SKOKIE BOULEVARD)
STREETSCAPE IMPROVEMENTS

STREET LIGHTING PLAN
U.S. ROUTE 41 (SKOKIE BOULEVARD)

SCALE: 1" = 20' STA. 18+00 TO STA. 29+00

F.A.P. RTE.	SECTION	COUNTY	TOTAL SHEETS	SHEET NO.
350	09-00283-00-LS	COOK	27	16
C-91-285-10		CONTRACT NO. 63430		
FED. ROAD DIST. NO. 1 ILLINOIS FED. AID PROJECT ARA-9003547				

