



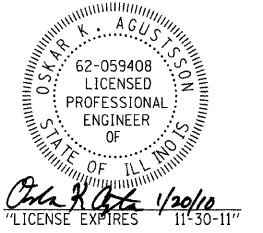


**LEGEND**

- EXISTING COM ED POWER POLE
- SERVICE PEDESTAL
- UD - 1 1/2" UNIT DUCT 6\*6 & 1\*8 GND (UNLESS NOTED OTHERWISE)
- PC - 2 1/2" CONDUIT, PUSHED LENGTH AS SHOWN WITH 1 1/2" UNIT DUCT OR AS NOTED
- PROPOSED ORNAMENTAL STREET LIGHT, SINGLE TEARDROP FIXTURE, HPS, 250 WATT, 240 VOLT, TYPE IV, 36.5' M.H.
- ⊙ PROPOSED ORNAMENTAL STREET LIGHT, SINGLE ACORN FIXTURE, HPS, 35 WATT, 120 VOLT, TYPE III, 15.5' M.H.
- EXISTING STREET LIGHT, 400W, MERCURY VAPOR, 30' MH
- ▣ PROPOSED LIGHTING CONTROLLER
- ▣ EXISTING HANDHOLE
- SB SETBACK FROM BACK OF CURB
- ⌚ DUPLEX RECEPTACLE, 120V, 20A

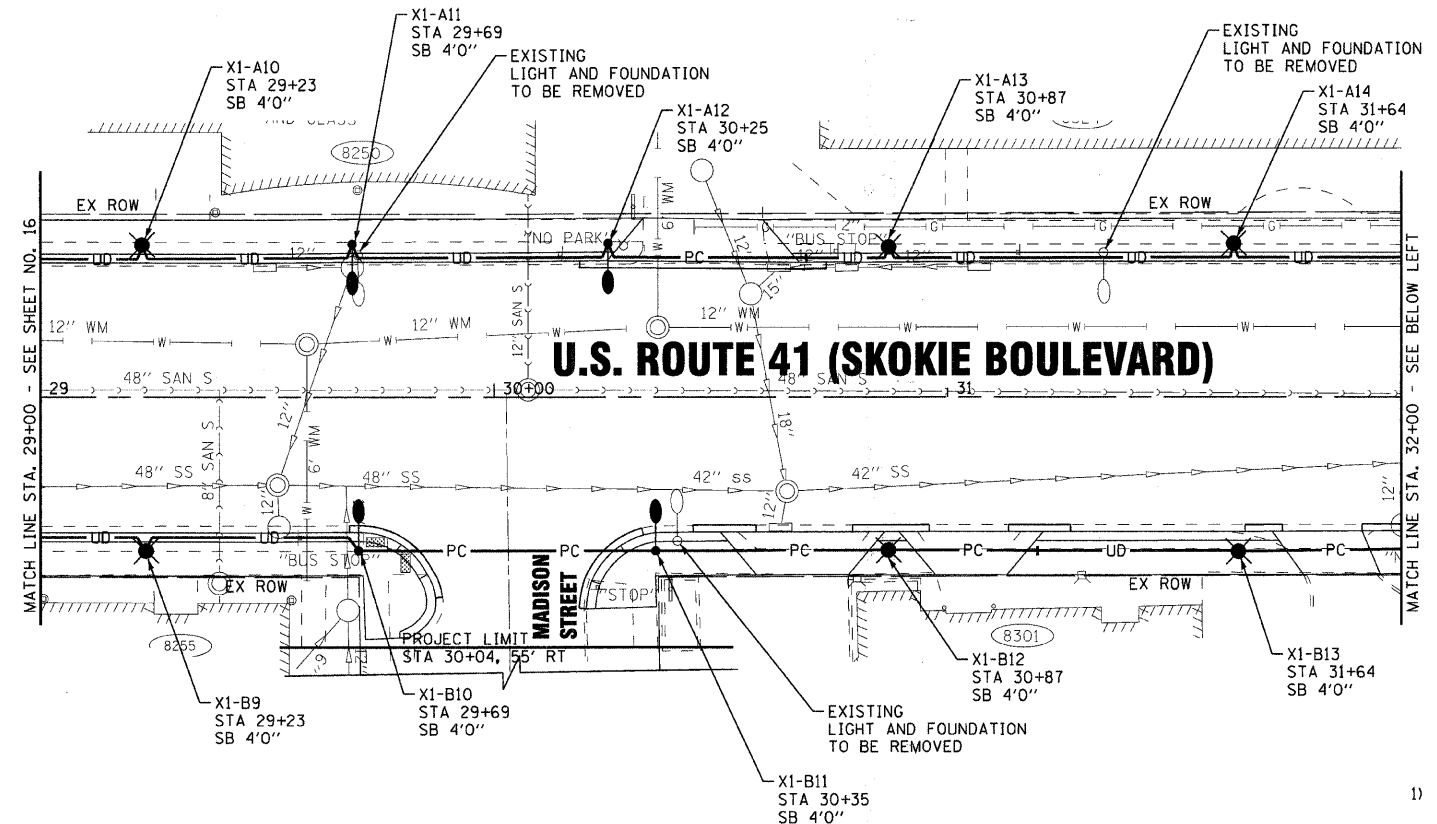

- NOTES:**
- 1) THE LIGHTING SYSTEM SHALL BE CONSTRUCTED IN PHASES. LIGHTING SHALL BE MAINTAINED OPERATIONAL ON ONE SIDE OF THE ROAD AS THE OPPOSITE SIDE IS BEING CONSTRUCTED.
  - 2) EXISTING ALUMINUM LIGHTING UNITS REMOVED SHALL BE SALVAGED AND DELIVERED TO FACILITY DESIGNATED BY VILLAGE OF SKOKIE.

DESIGNED BY: BAXTER & WOODMAN, INC. STATE OF ILLINOIS PROFESSIONAL ENGINEERING DESIGN FIRM LICENSE NO. 184-00181 - EXPIRES 4/30/2011  
 DRAWN BY: MAC  
 CHECKED BY: OKA  
 DATE: 10-16-2009  
 FILE: 091028-SL-3.sht

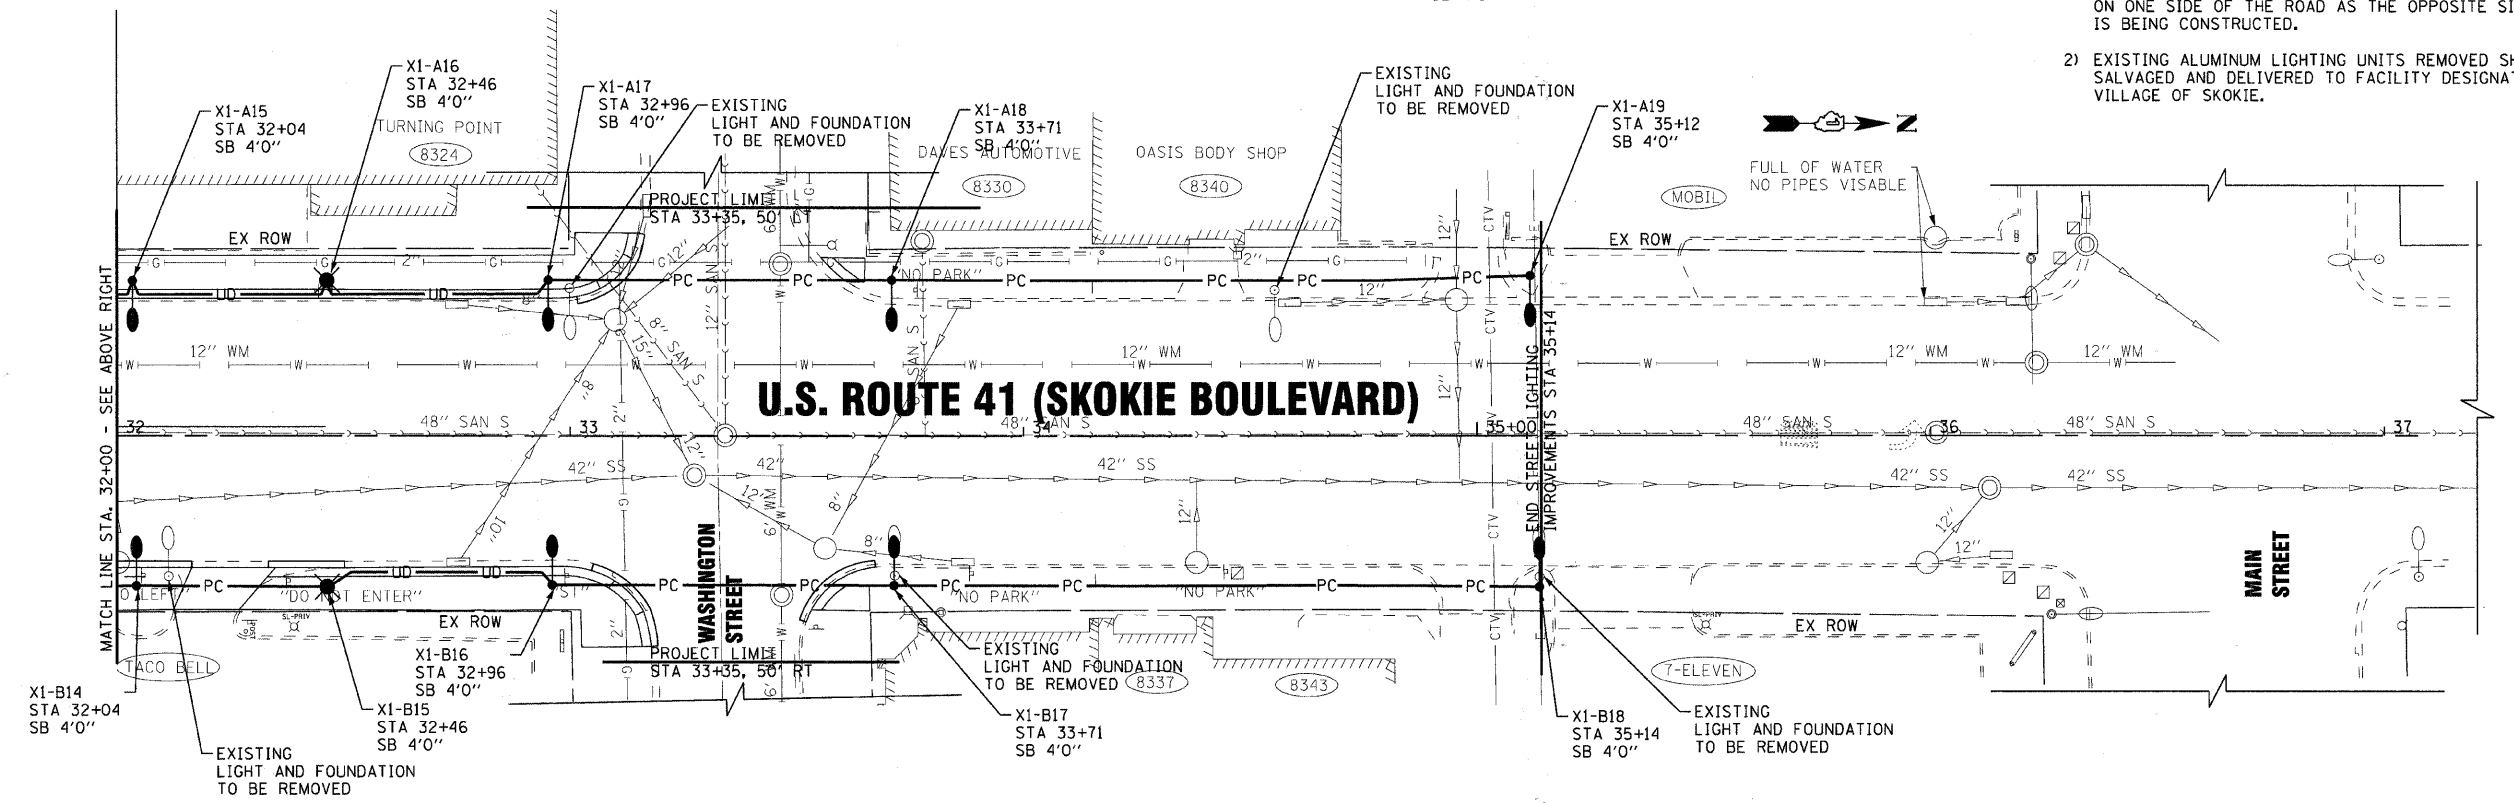

	DESIGNED - OKA	REVISED - IDOT REVIEW 11/23/09	<b>VILLAGE OF SKOKIE, ILLINOIS</b> <b>U.S. ROUTE 41 (SKOKIE BOULEVARD)</b> <b>STREETSCAPE IMPROVEMENTS</b>		<b>STREET LIGHTING PLAN</b> <b>U.S. ROUTE 41 (SKOKIE BOULEVARD)</b>		F.A.P. RTE.	SECTION	COUNTY	TOTAL SHEETS	SHEET NO.
	DRAWN - MAC	REVISED - IDOT REVIEW 01/19/10			350	09-00283-00-LS	COOK	27	17		
	CHECKED - OKA	REVISED -					C-91-285-10		CONTRACT NO. 63430		
	DATE - 10-16-2009	FILE - 091028-SL-3.sht			SCALE: 1" = 20'		STA. 29+00 TO STA. 36+00		FED. ROAD DIST. NO. 1 ILLINOIS FED. AID PROJECT ARA-9003647		