

 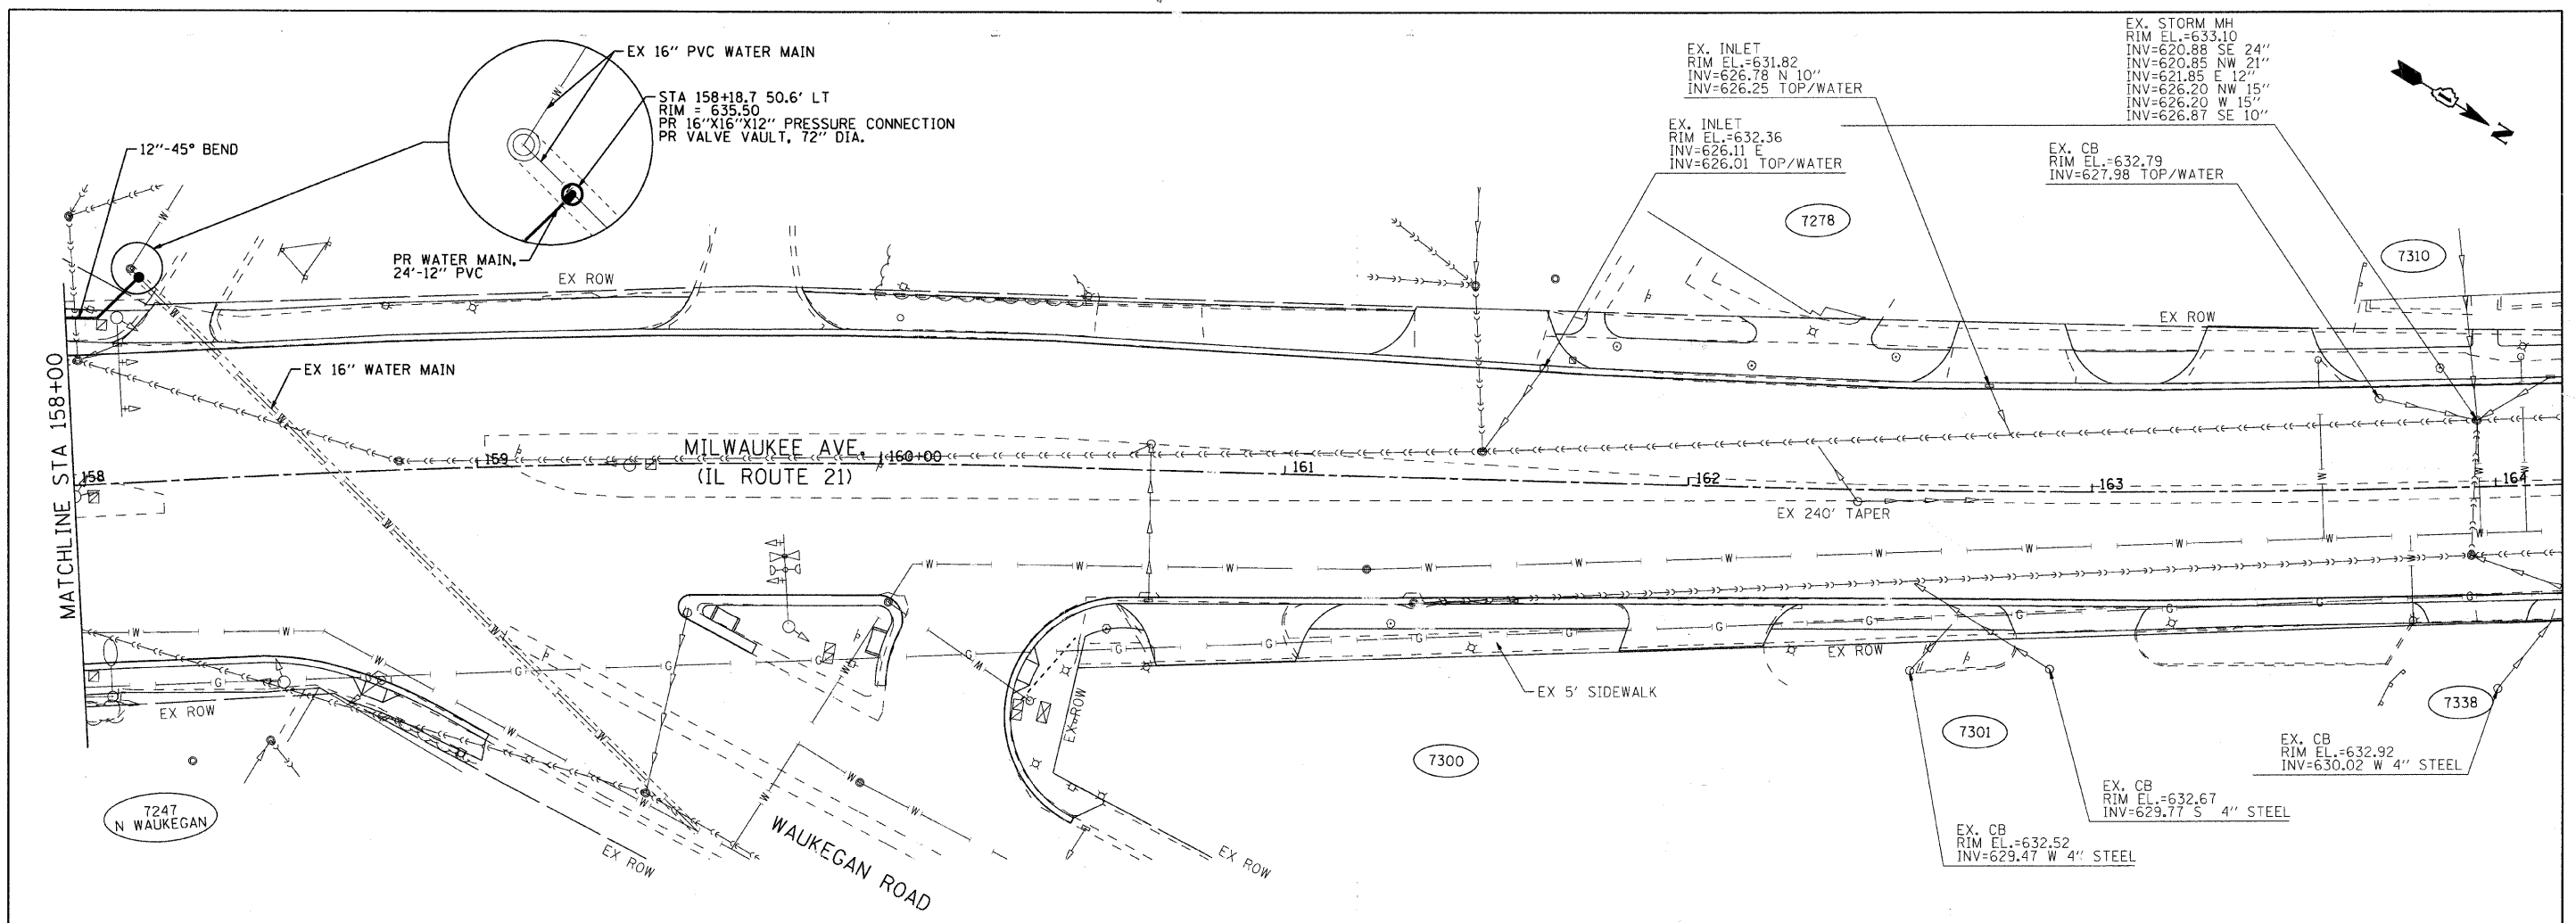


DATE	
BY	
SURVEYED	
ALIGNED	
CHECKED	
NO. OF WAY CHECKED	
DATE FILE NAME	

DATE	
BY	
SURVEYED	
PROPOSED	
CHECKED	
S.M. NOTED	
STRUCTURE NOTATIONS	
NO.	

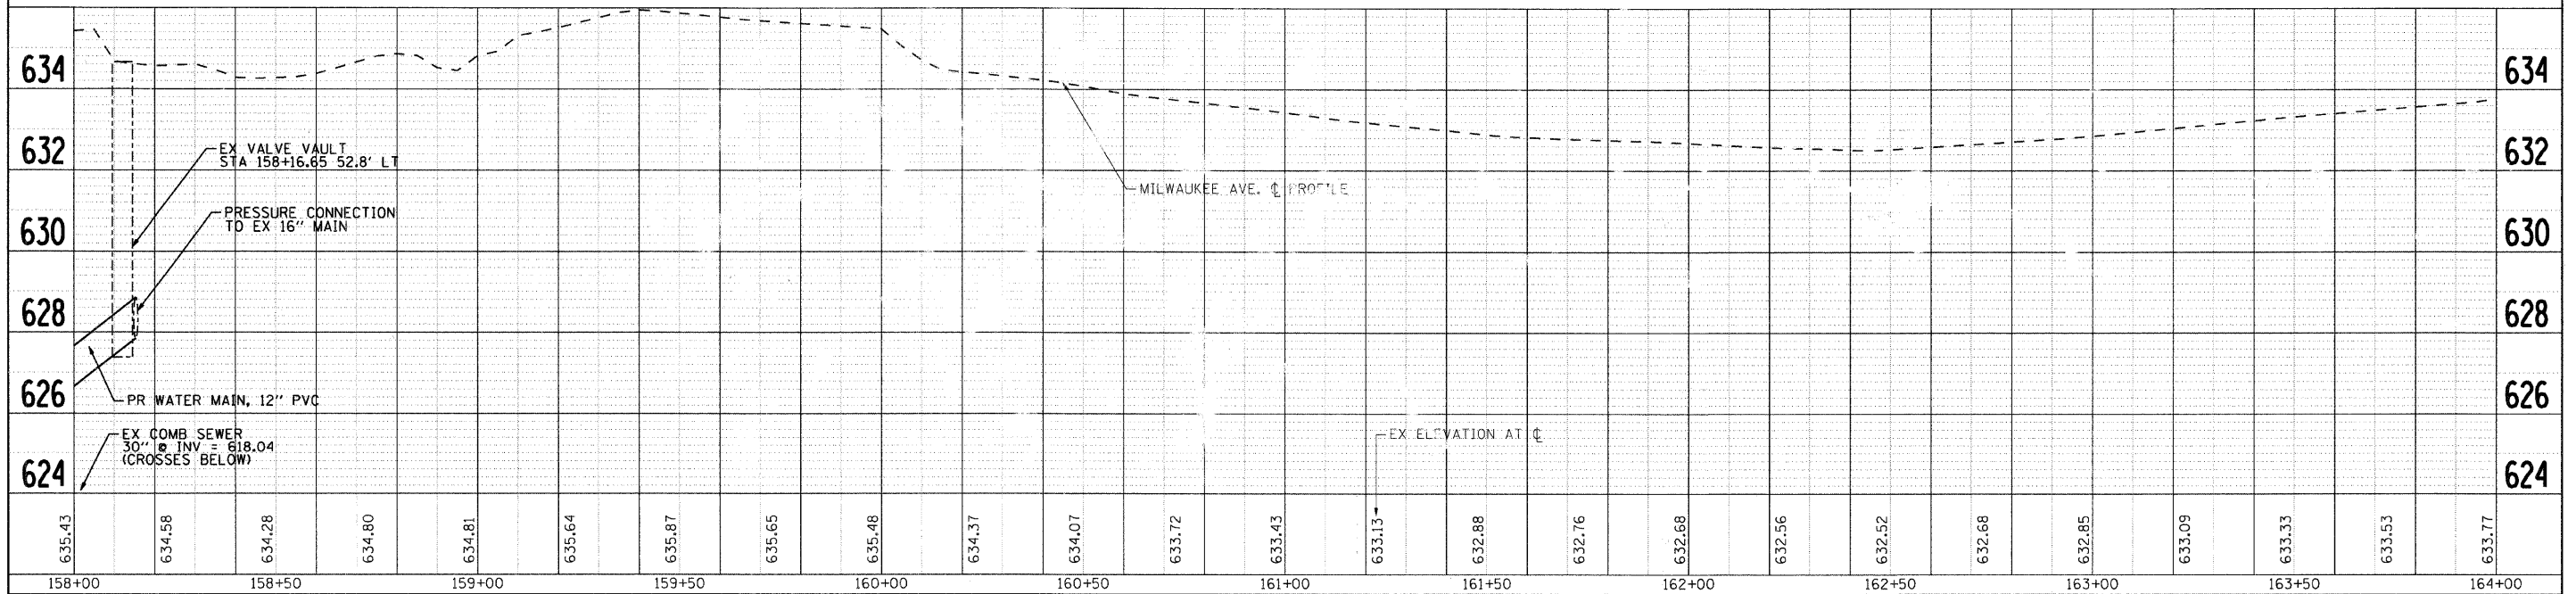

NOTE:
 SIZE AND LOCATION OF EXISTING WATER SERVICE LINES ARE TO BE VERIFIED PRIOR TO INSTALLATION OF NEW SERVICE.



635.43	634.58	634.28	634.80	634.81	635.64	635.87	635.65	635.48	634.37	634.07	633.72	633.43	633.13	632.88	632.76	632.68	632.56	632.52	632.68	632.85	633.09	633.33	633.53	633.77
158+00		158+50		159+00		159+50		160+00		160+50		161+00		161+50		162+00		162+50		163+00		163+50		164+00

SEC Group, Inc.
 Engineering
 Surveying
 Planning
 Landscaping
 Illinois • Texas • Georgia
 www.secgroupinc.com

USER NAME = char-ke	DESIGNED - JPA	REVISED -
	DRAWN - CMH	REVISED -
PLOT SCALE = 1" = 20'	CHECKED - JLP	REVISED -
PLOT DATE = 1/16/2009	DATE - 12/16/08	REVISED -

VILLAGE OF NILES

PROPOSED WATER MAIN PLAN AND PROFILE
 SCALE: 1" = 20' SHEET NO. 10 OF 10 SHEETS STA. 158+00.00 TO STA. END

F.A. RTE. 3513	SECTION 08-00107-01-PV	COUNTY COOK	TOTAL SHEETS 169	SHEET NO. 47
CONTRACT NO.		FED. ROAD DIST. NO. ILLINOIS FED. AID PROJECT M-8003(723)		