



F.A.U. ROUTE NO.	SECTION	COUNTY	TOTAL SHEETS	SHEET NO.
4011	06-00071-00-PV	McHENRY	31	10
ILLINOIS PROJECT				
CONTRACT NO. 63001				

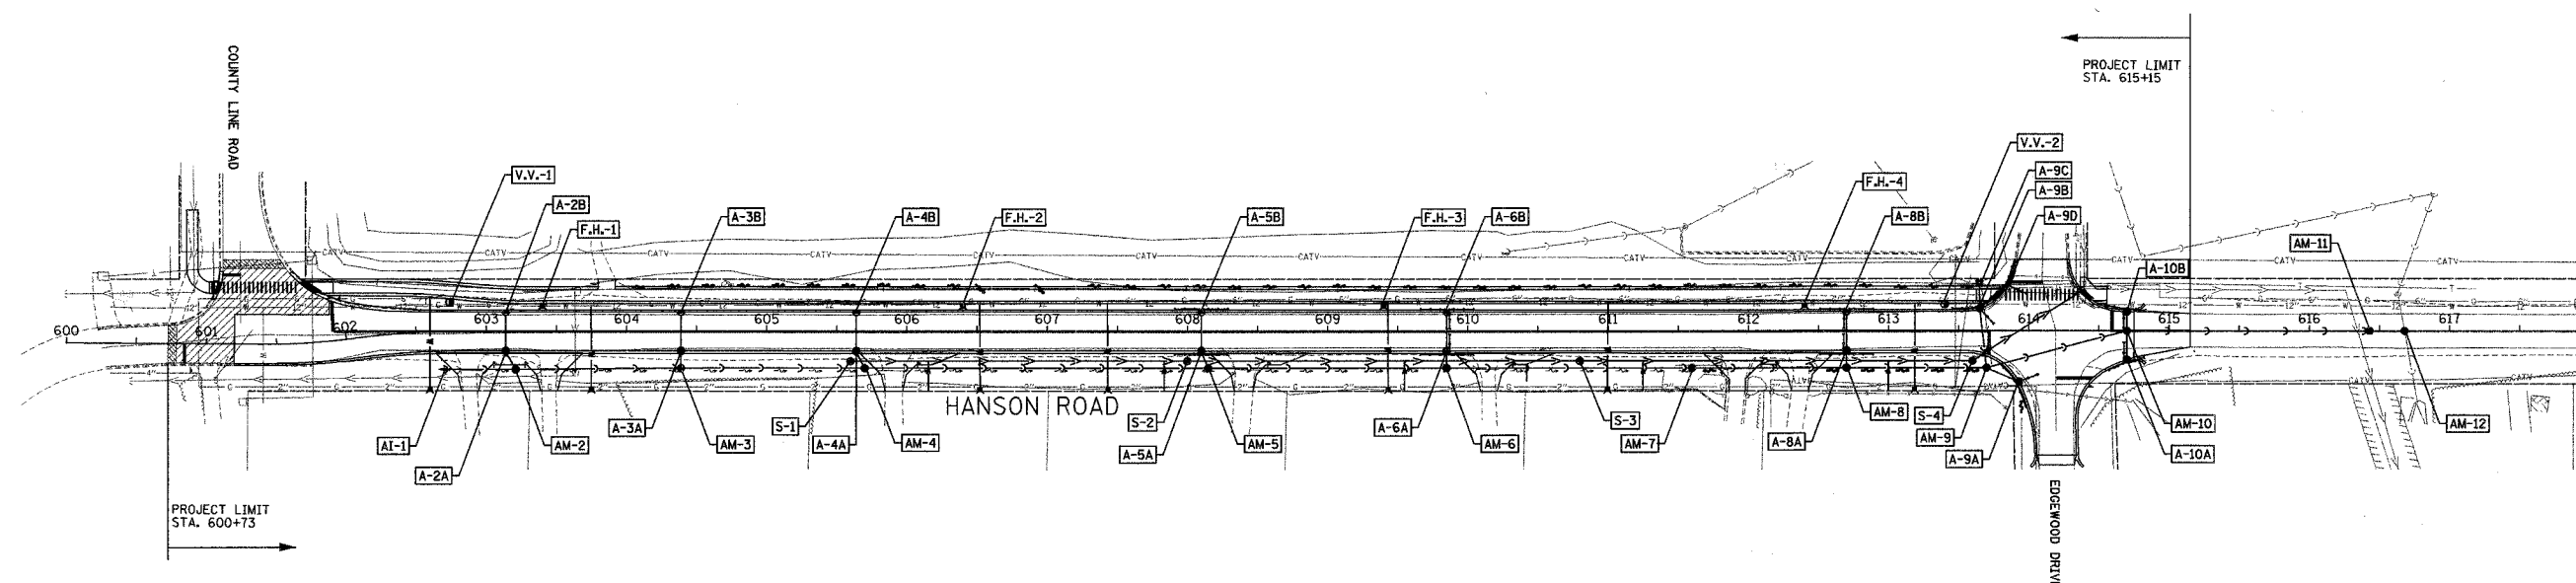

NOTE: GENERAL LOCATIONS OF ALL UTILITY WORK ARE SHOWN ABOVE. FOR DETAILED UTILITY LOCATIONS SEE PLAN SHEETS 11-16.

LEGEND

- — — — — EXISTING SANITARY SEWER
- — — — — EXISTING WATER MAIN
- — — — — EXISTING STORM SEWER
- — — — — EXISTING GAS MAIN
- — — — — EXISTING OVERHEAD
- — — — — EXISTING CABLE T.V.
- — — — — PROPOSED INLET
- — — — — — PROPOSED CATCH BASIN
- — — — — — PROPOSED MANHOLE
- ▲ — — — — — PROPOSED FIRE HYDRANT
- — — — — — PROPOSED VALVE VAULT
- — — — — PROPOSED STORM SEWER
- — — — — PROPOSED SANITARY SEWER
- DM-8 — — — — — PROPOSED STORM SEWER STRUCTURE NUMBER

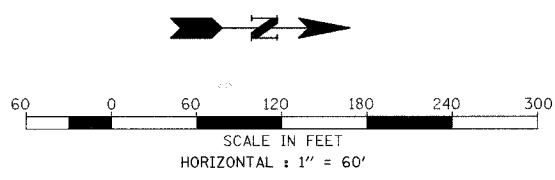

REVISIONS	
NAME	DATE

HANSON ROAD IMPROVEMENTS
COUNTY LINE ROAD TO EDGEWOOD DRIVE
OVERALL UTILITY PLAN

DATE: 12-18-07 DRAWN BY: AJR
CHECKED BY: MAY

GRAEF, ANHALT, SCHLOEMER & ASSOCIATES, INC.
CHICAGO, ILLINOIS