

STATE OF ILLINOIS  
DEPARTMENT OF TRANSPORTATION  
DIVISION OF HIGHWAYS

FALL PKT.	SECTION	COUNTY	TOTAL SHEETS	SHEET NO.
*	06-00132-00-PK	WILL	15	1
STA.		TO STA.		
ILLINOIS		*		

CONTRACT NUMBER 83974

**INDEX OF SHEETS**

SHEET NO.	DESCRIPTIONS
1	TITLE SHEET
2	GENERAL NOTES
3	SUMMARY OF QUANTITIES
4	EXISTING CONDITIONS AND DEMOLITION PLAN
5	EROSION CONTROL PLAN
6	SITE LAYOUT PLAN
7	SITE GRADING AND UTILITY PLAN
8	SITE LIGHTING PLAN
9-10	LIGHTING DETAILS
11-15	CONSTRUCTION DETAILS
15	TC-10 STANDARD

# PLANS FOR PROPOSED FEDERAL AID PROJECT


95TH STREET PARK AND RIDE  
91ST STREET AND 250TH AVENUE  
SECTION 06-00132-00-PK  
PARKING LOT IMPROVEMENTS  
PROJECT NO: M-8003(689)  
CITY OF NAPERVILLE  
WILL COUNTY  
JOB NO: C-91-014-07

**IDOT STANDARDS REFERENCED**


STANDARD NO.	DESCRIPTIONS
000001-05	STANDARDS SYMBOLS, ABBREVIATIONS, & PATTERNS
701901	TRAFFIC CONTROL DEVICES
780001-01	TYPICAL PAVEMENT MARKINGS

**CITY OF NAPERVILLE STANDARDS**

STANDARD NO.	DESCRIPTIONS
MISC 4	TEMPORARY EROSION CONTROL SYSTEMS
MISC 5	TEMPORARY EROSION CONTROL SYSTEMS
MISC 6	TYPICAL SILT FENCE CONSTRUCTION
MISC 11	ACCESSIBLE PARKING SPACE MARKINGS
MISC 12	CROSSWALK
PVMT 3	SIDEWALK
PVMT 4	CURB RAMPS ACCESSIBLE TO THE DISABLED
PVMT 5	SIDEWALK CONSTRUCTION
PVMT 7	TYPICAL PAVEMENT DETAILS
PVMT 10	TYPICAL COMMERCIAL DRIVEWAY DETAILS
PVMT 11	CURB & GUTTER
PVMT 12	CURB & GUTTER
PVMT 13	STORM SEWER CASTING DETAIL
STORM 1	INLET TYPE A
STORM 2	MANHOLE TYPE A
STORM 3	FLAT SLAB TOP PRECAST REINFORCED CONCRETE
STORM 4	CATCHBASIN TYPE A
STORM 5	CATCHBASIN TYPE C
STORM 6	CASTING ADJUSTMENTS FOR STRUCTURES IN PAVED AREAS
STORM 7	CASTING ADJUSTMENTS FOR STRUCTURES WITHIN THE CURB LINE
STORM 12	STANDARD FRAME AND GRATE FOR (B6-12) CURB AND GUTTER
STORM 13	FRAME & GRATE FOR B-6.12 (B-15.30) CURB & GUTTER (DEPRESSED CURB)
STORM 15	FRAME & LID TYPE 1
STORM 17	GRATING FOR CONCRETE FLARED END SECTION
STORM 18	CAST IRON STEPS

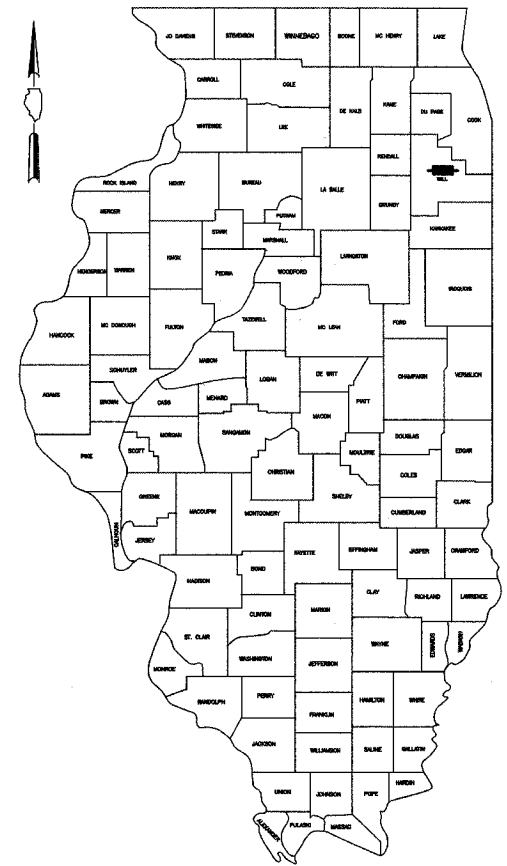

LOCATION OF SECTION INDICATED THUS: - - ■ - -

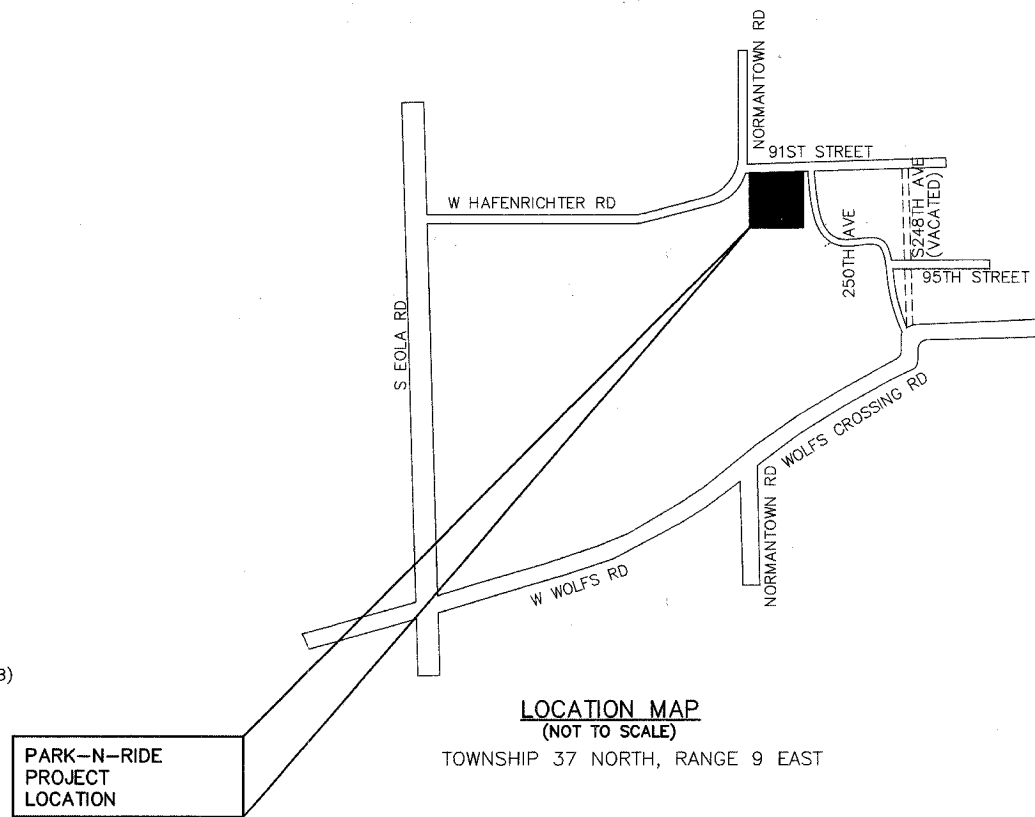

LOCATION MAP  
(NOT TO SCALE)

TOWNSHIP 37 NORTH, RANGE 9 EAST



HORIZ: 1"=40' 40 0 40

FULL SIZE PLANS HAVE BEEN PREPARED USING STANDARD ENGINEERING SCALES. REDUCED SIZED PLANS WILL NOT CONFORM TO STANDARD SCALES. IN MAKING MEASUREMENTS ON REDUCED PLANS, THE ABOVE SCALES MAY BE USED.

**CONTRACT NO. 83974**

STATE OF ILLINOIS DEPARTMENT OF TRANSPORTATION DIVISION OF HIGHWAYS	
APPROVED	<i>November 21 2007</i> <i>Diane O'Keefe</i> CITY OF NAPERVILLE/ CITY ENGINEER
PASSED	<i>DECEMBER 17 2007</i> <i>Christina Hill</i> DISTRICT ONE ENGINEER OF LOCAL ROADS & STREETS
RELEASING FOR BID BASED ON LIMITED REVIEW	<i>December 17 2007</i> <i>Diane O'Keefe</i> DEPUTY DIRECTOR OF HIGHWAYS, REGION ONE ENGINEER

FOR UNDERGROUND  
UTILITY LOCATIONS



(800) 892-0123

CITY OF NAPERVILLE  
ENGINEERING DEPARTMENT  
(630) 420-6113



CORPORATE SEAL  
PLANS PREPARED BY:



450 E Devon Ave, Suite 300 - Itasca, Illinois 60143  
Tel: 630.773.3900 - Fax: 630.773.3975  
www.civiltechinc.com

P.E. SIGNATURE: *Reid T. Magner*  
P.E. NAME: REID T. MAGNER  
DATE: 11/26/2007  
IL LICENSE NO.: 062-056273  
LICENSE EXPIRATION: 11/30/2009

CONSULTANT ENGINEER: REID T. MAGNER, P.E. CIVILTECH ENGINEERING, INC.  
FIELD ENGINEER: MARILINDA SOLOMON, P.E. (847) 705-4407