


FALL NO.	SECTION	COUNTY	TOTAL SHEETS	SHEET NO.
1380	00-00084-00-PV	DUPAGE	93	55
STA. 203+50		TO STA.	209+00	
		ALLOWS	SURFACE TRANSPORTATION FUNDING	

CONTRACT NUMBER 83993

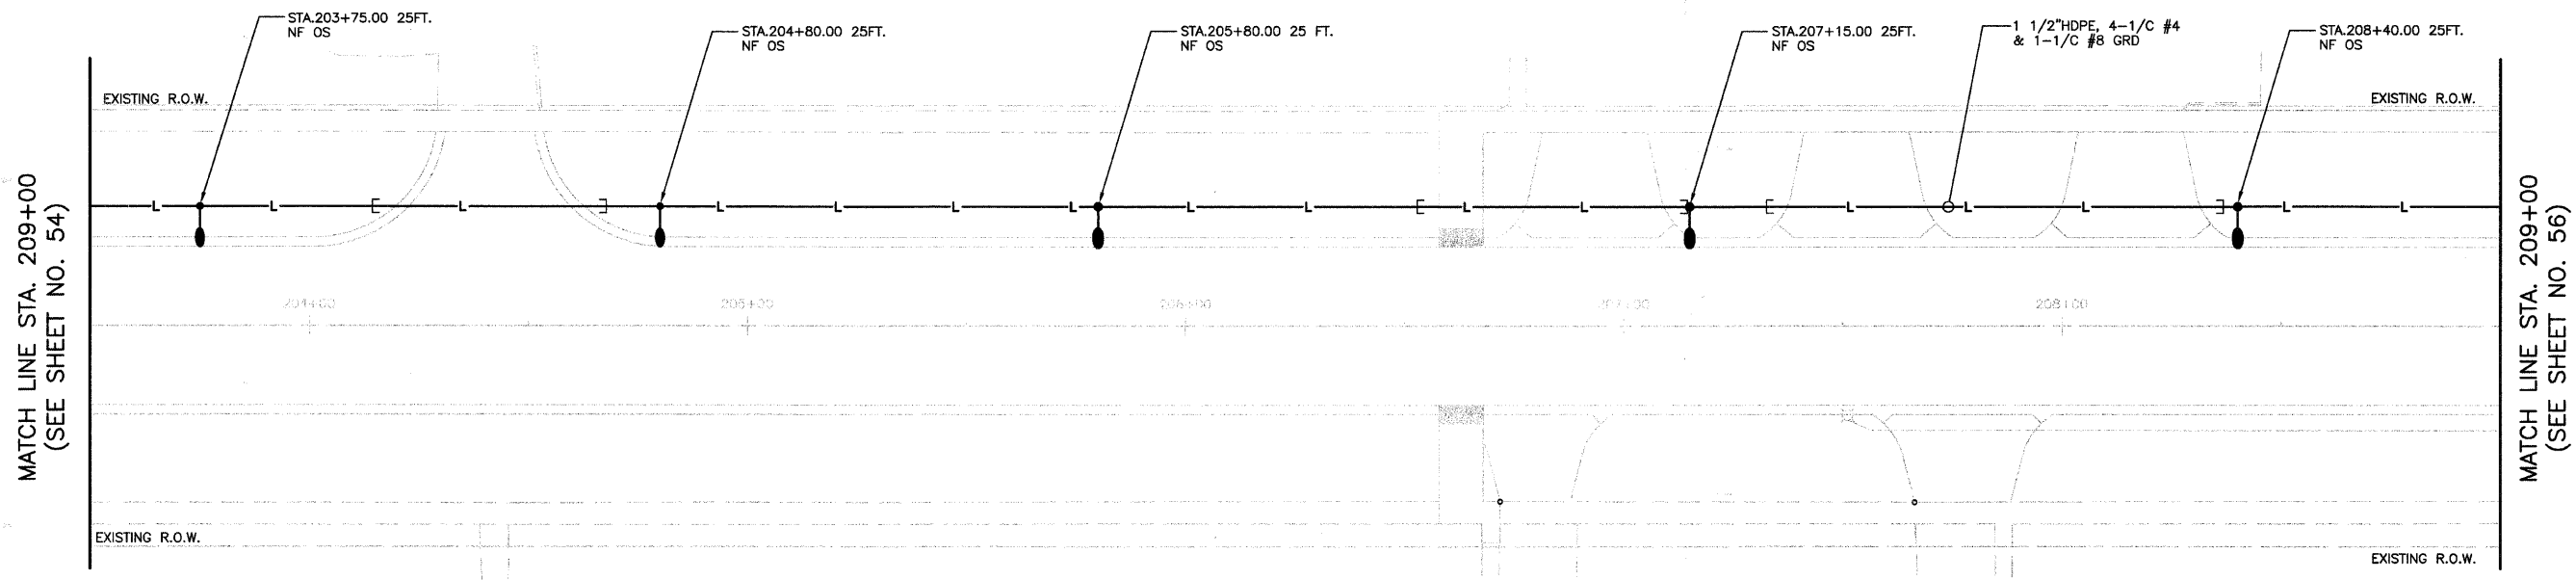

NOTE: ALL POLES MARKED "NF" REQUIRE NON-FRANGIBLE MOUNTING.
ALL POLES MARKED AS "OS" REQUIRE OFFSET FOUNDATION.

REVISIONS	
NAME	DATE

VILLAGE OF ADDISON

LIGHTING PLAN

FULLERTON AVENUE

STA. 203+50 TO 209+00

DATE: 11/26/2007
DESIGNED BY: FEJ
TECHNICIAN: FEJ
CHECKED BY: DEM

20 0 20 HORIZ.
5 5 VERT.
SCALE IN FEET