


F.A.U. RTE.	SECTION	COUNTY	TOTAL SHEETS	SHEET NO.
2588	06-00056-00-PP	DUPAGE	26	11

CONTRACT NO. 83995

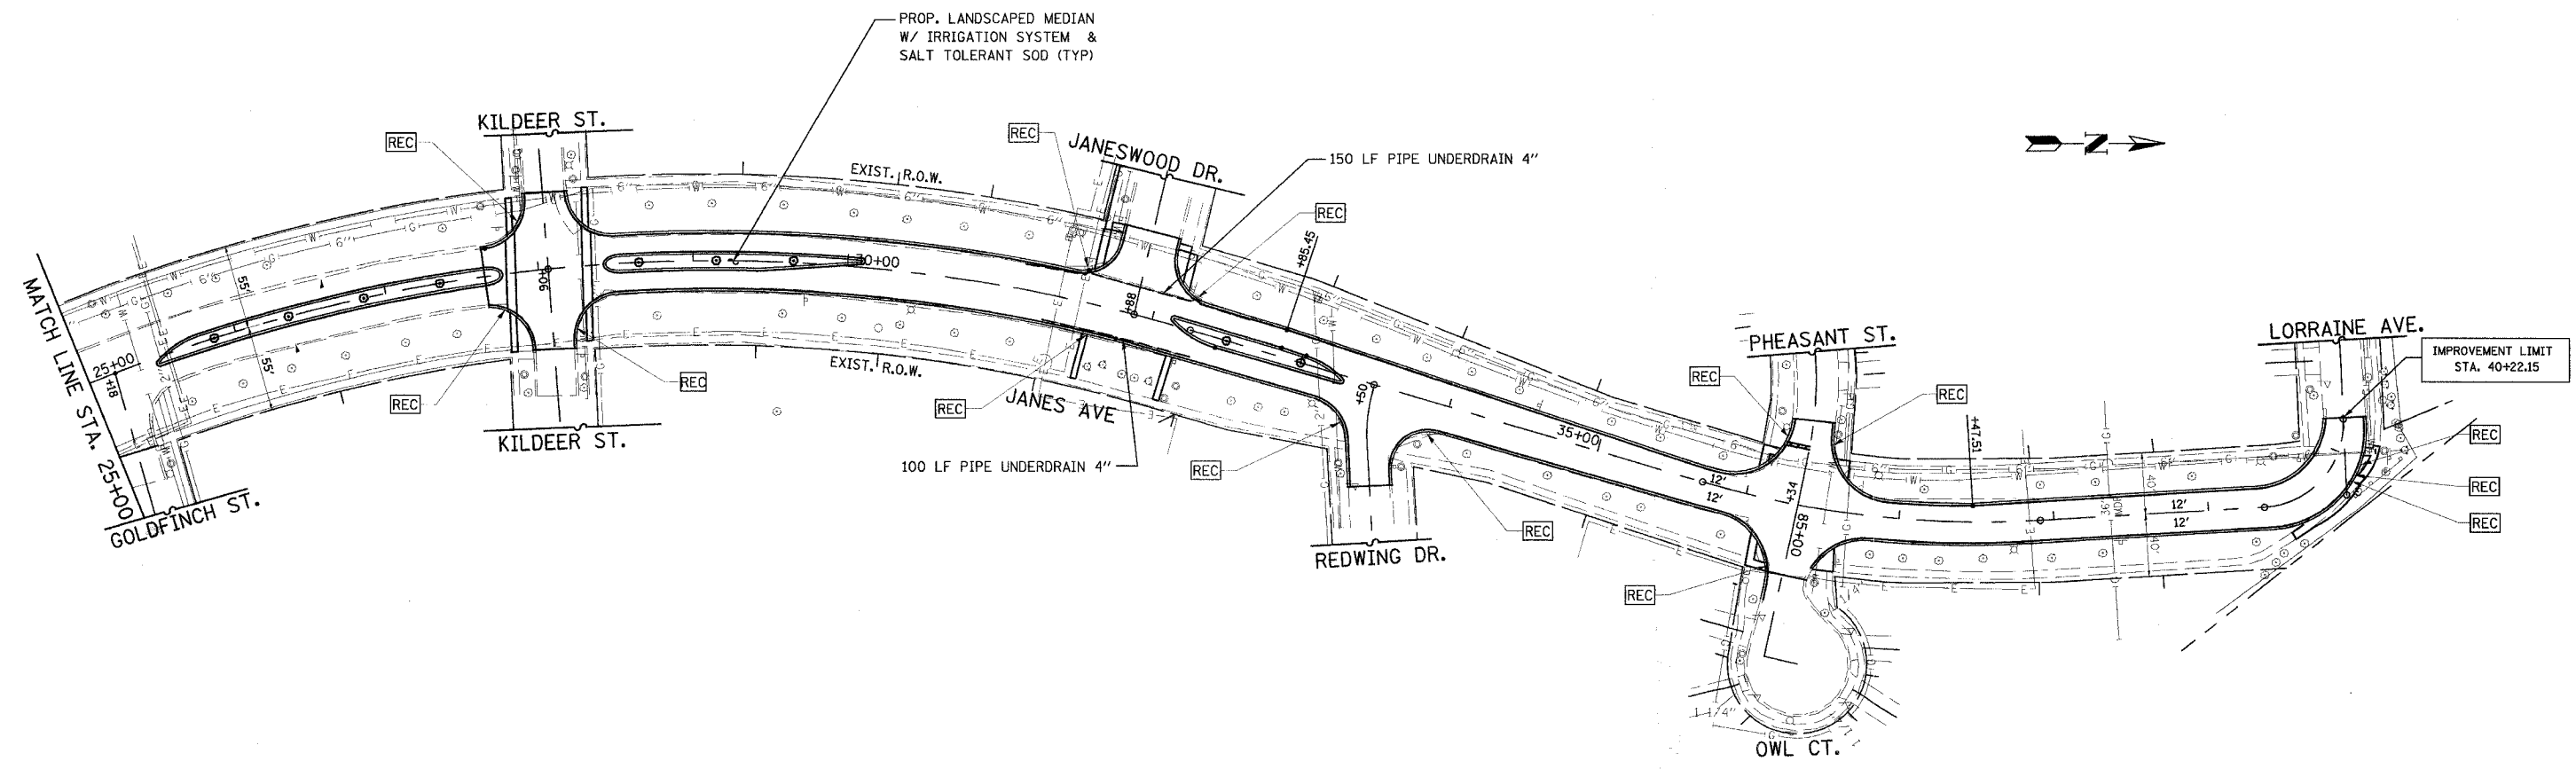

LEGEND

- [R] STRUCTURE REMOVAL
- [REC] STRUCTURE TO BE RECONSTRUCTED
- [ADJ] STRUCTURE TO BE ADJUSTED
- ✕ LIGHT POLE TO BE RELOCATED/REPLACED
- EXIST. UNDERGROUND SEWER
- - - EXIST. SANITARY SEWER
- PROP. 12" RCP

NOTE:
CONTRACTOR SHALL AUGER CONDUIT & PIPING FOR
SPRINKLER SYSTEM UNDER PAVEMENT TO REMAIN.

URS 100 S. WACKER DR., SUITE 500 TEL: (312) 939-1000
CHICAGO IL, 60606 FAX: (312) 939-4198

VILLAGE OF WOODRIDGE
JANES AVENUE
71ST STREET TO LORRAINE AVENUE
REHABILITATION AND RESURFACING
DRAINAGE AND UTILITY PLAN
STA. 25+00 TO STA. 40+22.15

SCALE: 1" = 50' DRAWN BY: VAP
DATE: 11/30/2007 CHECKED BY: DDL

REVISIONS	
NAME	DATE

