




| F.A. RTE.           | SECTION        | COUNTY           | TOTAL SHEETS | SHEET NO. |
|---------------------|----------------|------------------|--------------|-----------|
| 2588                | 06-00056-00-PP | DUPAGE           | 26           | 20        |
| STA.                |                | TO STA.          |              |           |
| FED. ROAD DIST. NO. | ILLINOIS       | FED. AID PROJECT |              |           |

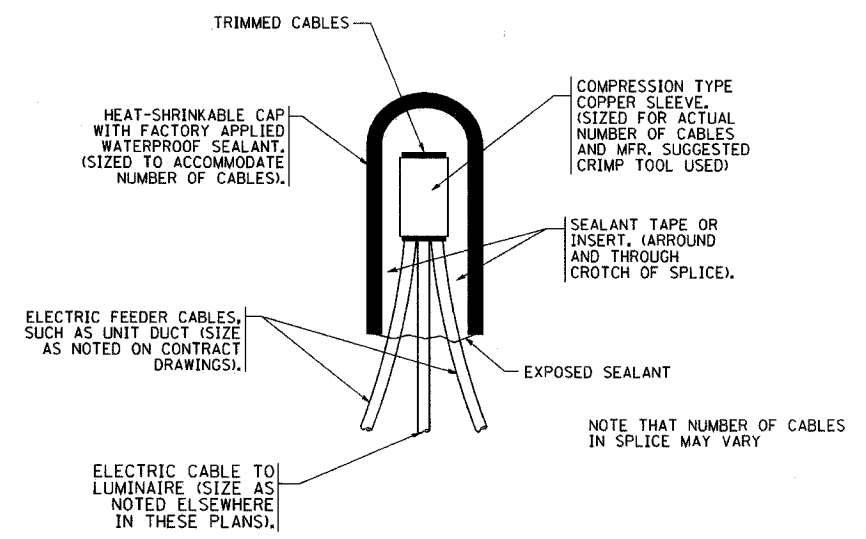

TYPICAL SPLICE DETAIL  
N.T.S.

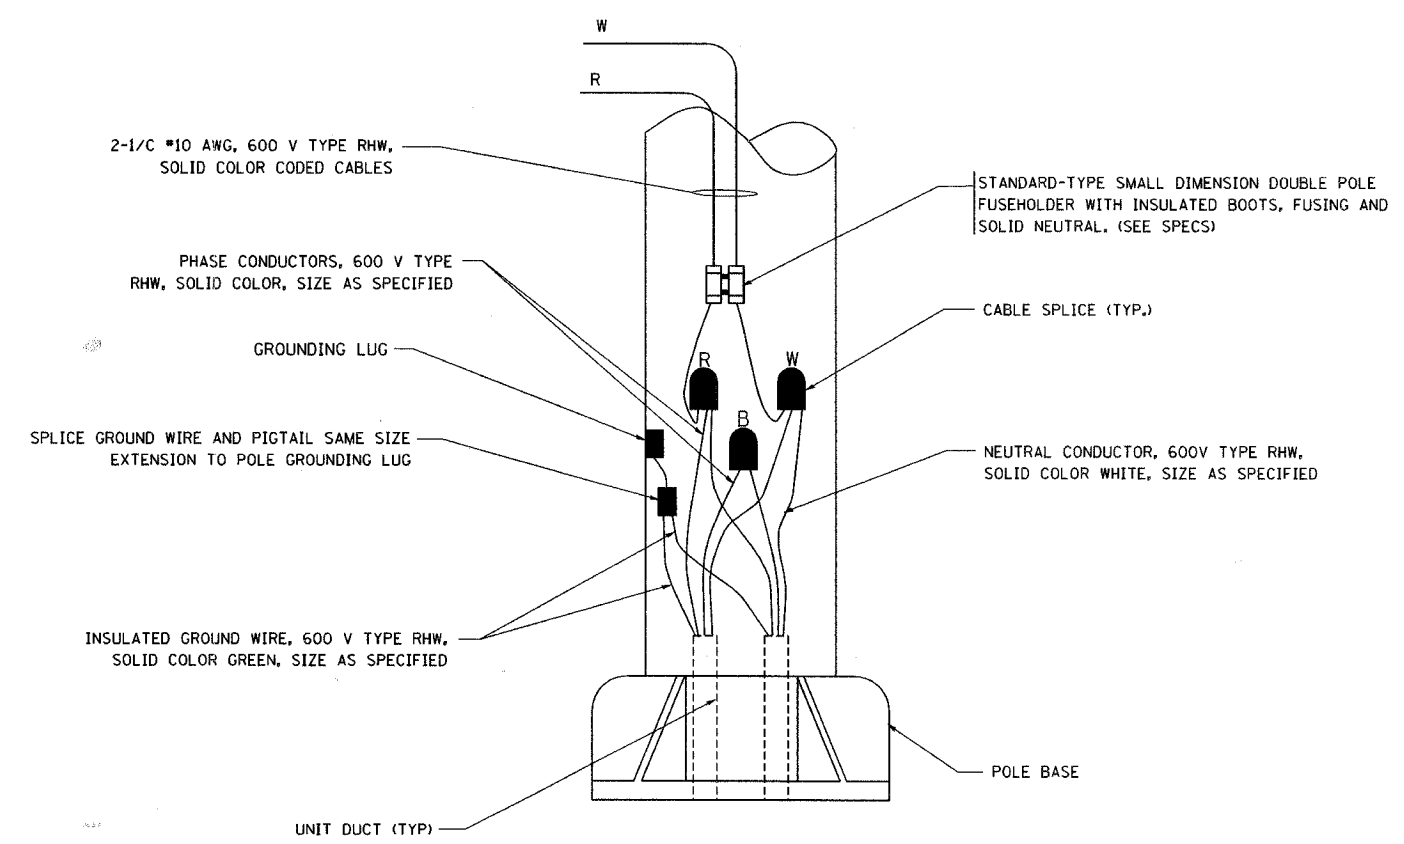

POLE WIRING DETAIL  
N.T.S.

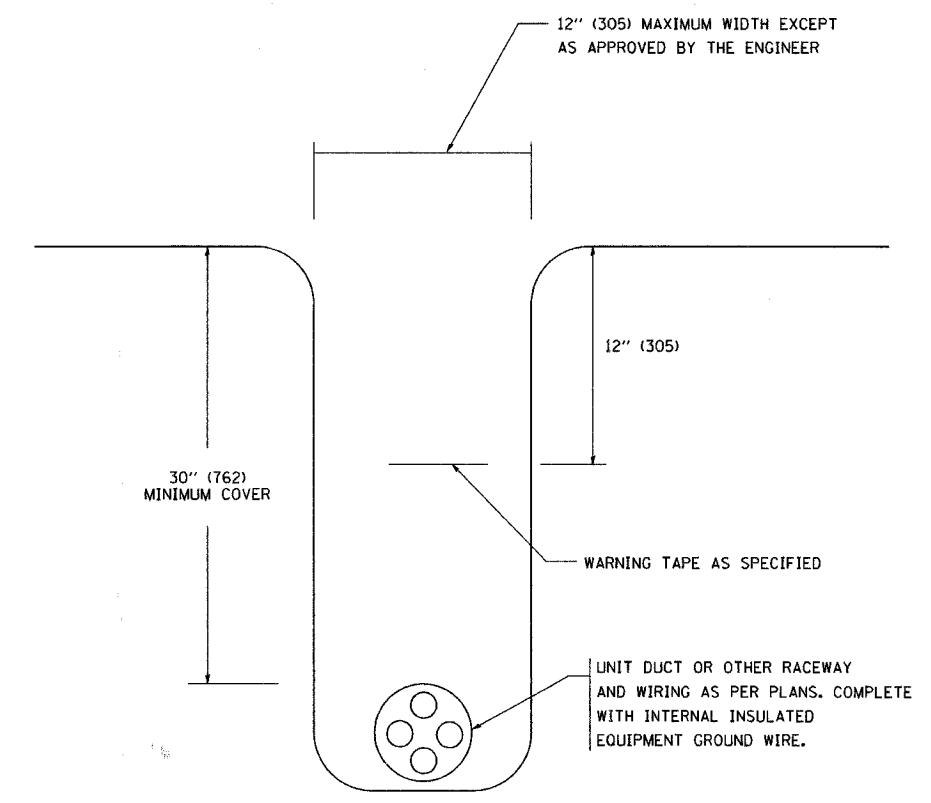

TYPICAL WIRING IN TRENCH DETAIL  
N.T.S.

PLOT DATE = 4/16/2007  
FILE NAME = K:\projects\06-00056-00-PP\762.dgn  
PLOT SCALE = 1/8" = 1'-0"  
USER NAME = bward

| REVISIONS |          |
|-----------|----------|
| NAME      | DATE     |
|           | 08/08/03 |
|           |          |
|           |          |
|           |          |
|           |          |
|           |          |
|           |          |
|           |          |
|           |          |

ILLINOIS DEPARTMENT OF TRANSPORTATION  
MISC. ELECTRICAL DETAILS  
SHEET A  
SCALE: VERT. NONE  
HORIZ.  
DRAWN BY  
CHECKED BY  
BE-702