

| F.A. RTE. | SECTION | COUNTY | TOTAL SHEETS | SHEET NO. |
|-----------|----------------|---------|--------------|-----------|
| | 03-00026-00-PK | MADISON | 51 | 40 |
| | 06-00026-01-MS | 97331 | | |

FEDERAL AID PROJECT

211 N. Broadway
 Suite 1900
 St. Louis, MO 63102
 (314) 241-8188
 FAX (314) 241-0125

KAI

LEWIS AND CLARK MEMORIAL TOWER
VILLAGE OF HARTFORD, ILLINOIS
 HARTFORD, ILLINOIS 62049

SHEET TITLE:
PLAZA LIGHTING PLAN

| REV. NO. | REMARKS | DATE |
|----------|---------|------|
| | | |
| | | |
| | | |

KENNEDY PROJECT NO
 KAI# 10-02048

ISSUE DATE
 12-JULY-05


SHEET NO

E2-02

© 2005 KENNEDY ASSOCIATES INCORPORATED

KEYED NOTES

- 1 QUARTZITE TYPE BOX INSTALLED IN PAVED AREA. SEE DETAIL A, SHEET E6-01.
- 2 (2) 1" EMPTY CONDUITS WITH PULLWIRE FOR POWER SUPPLY WIRING TO FUTURE FOUNTAIN PUMP AND FUTURE WATER WALL PUMP.
- 3 JUNCTION BOXES FOR CONNECTION OF EMERGENCY POWER SUPPLY. SEE DETAILS D AND E ON SHEET E6-03.
- 4 EXTEND AND CONNECT TO PANEL VIA RELAY PANEL OR CONTACTOR.

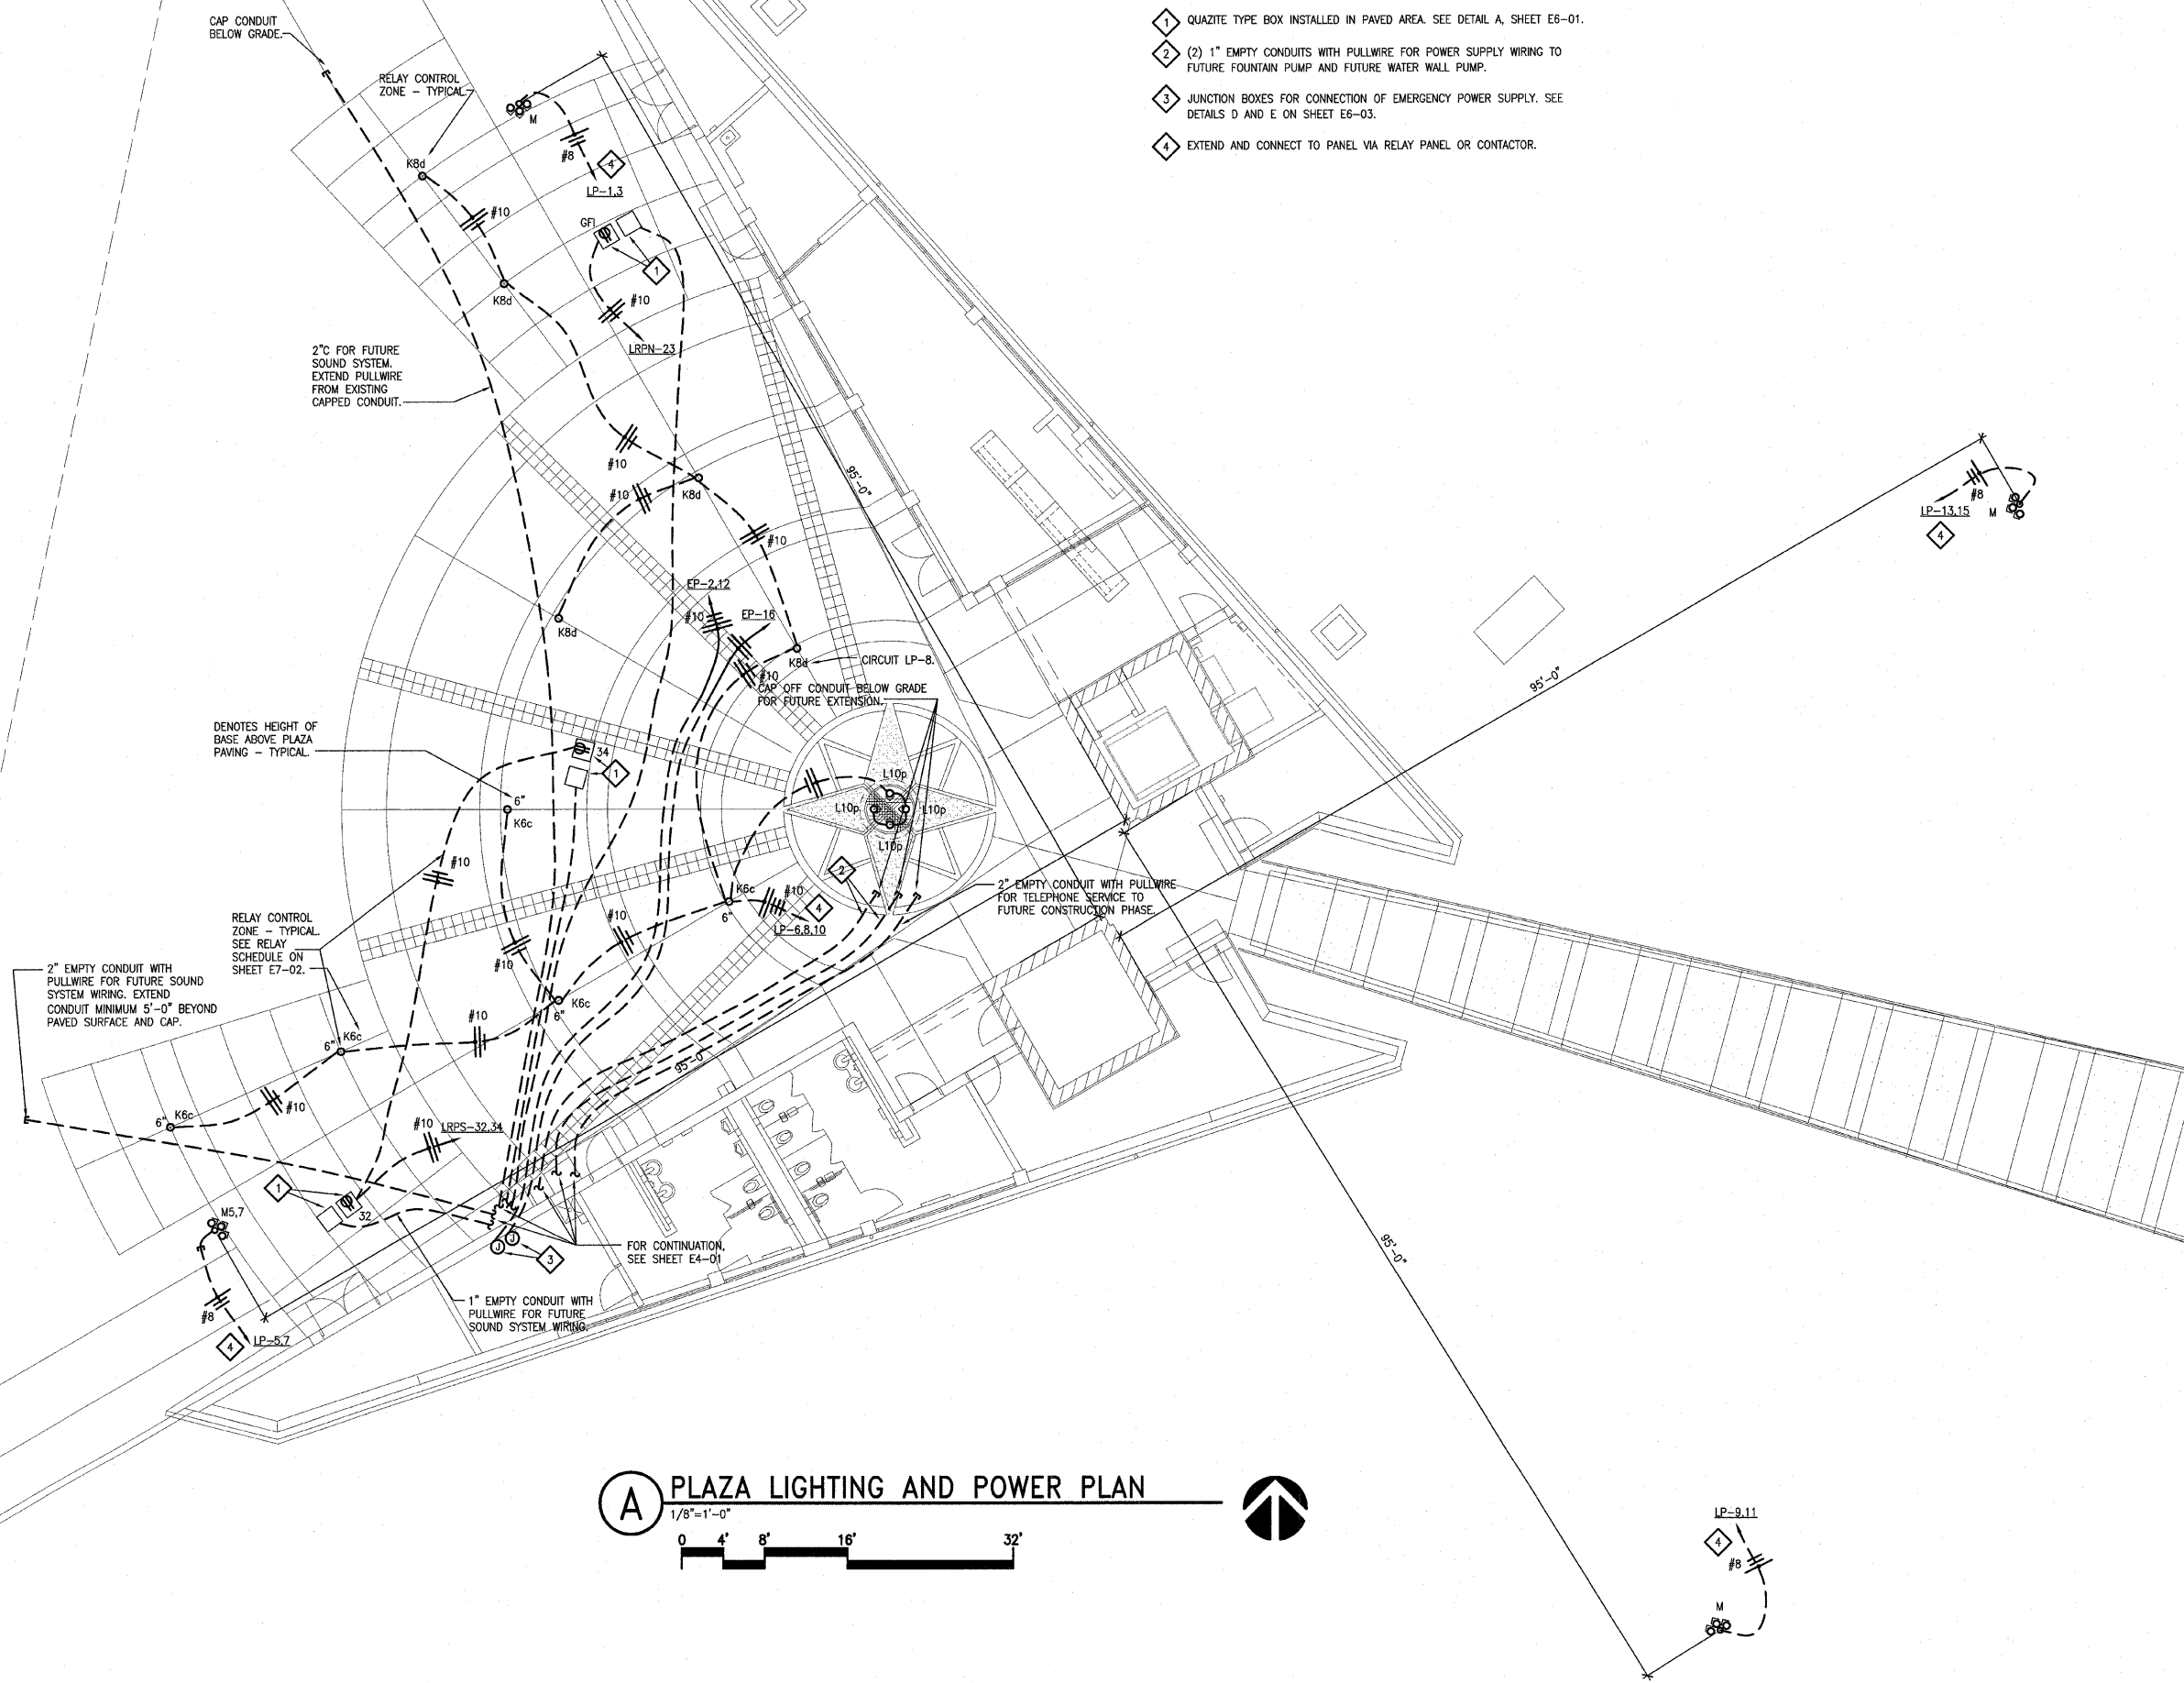

A PLAZA LIGHTING AND POWER PLAN
 1/8"=1'-0"

