
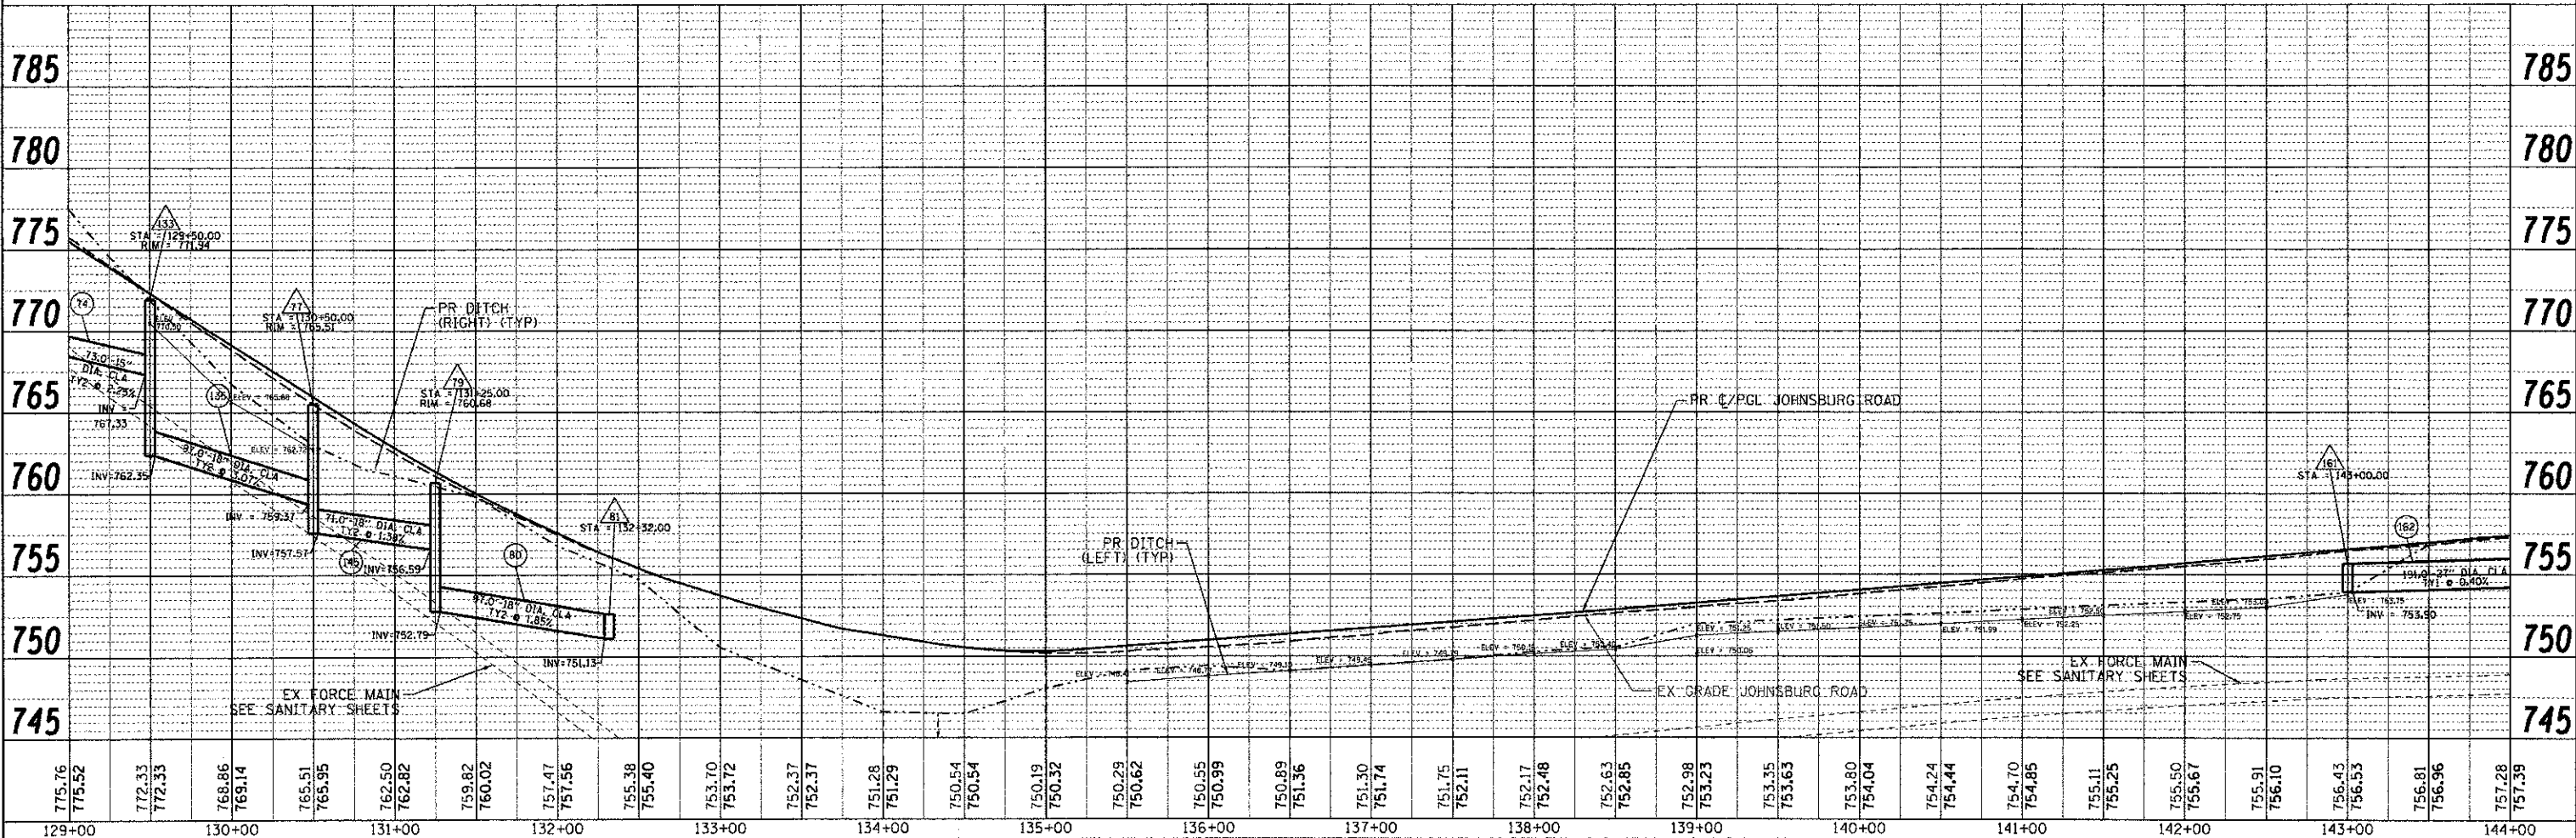


PLAN	SURVEYED	DATE
	PLOTTED	
	GRADES CHECKED	
	STRUCTURE NOTATIONS OK'D	
	NO. OF WAY CHECKED	
	CADD FILE NAME	

PROFILE	SURVEYED	DATE
	PLOTTED	
	GRADES CHECKED	
	STRUCTURE NOTATIONS OK'D	
	NO. OF WAY CHECKED	
	CADD FILE NAME	

COMPANY NAME: HRGreen.com
 PROJECT CONTACT: J. Jettana
 CLIENT: MCHENRY COUNTY
 DATE PLOTTED: 12/19/2012 2:31:08 PM
 FILE NAME: 090622-00p-03.dgn
 PLOT SCALE: 1" = 50'
 PEN TABLE: Standard (PenTable.dwg)

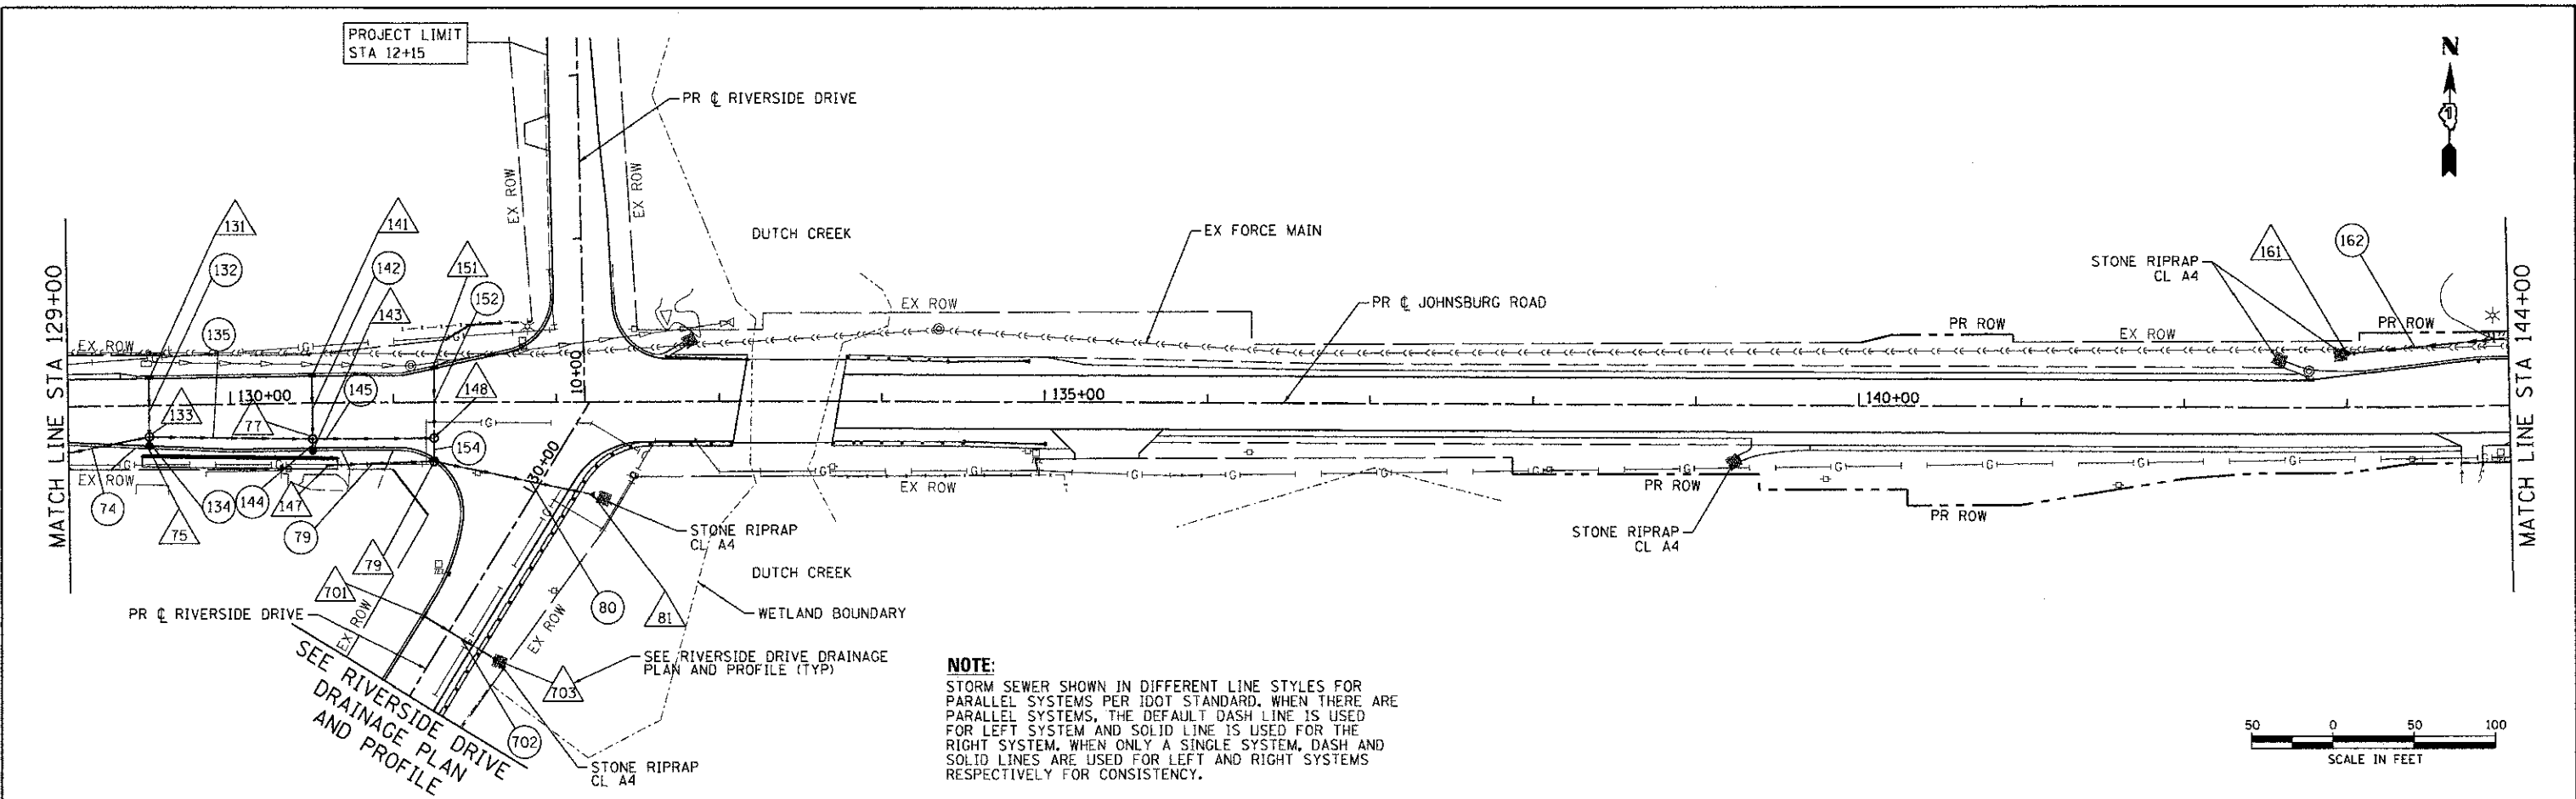

HRGreen.com Illinois Professional Design Firm #184-001322		USER NAME = jettana FILE NAME = 090622-00p-03.dgn PLOT SCALE = 1" = 50' PLOT DATE = 12/19/2012	DESIGNED - JRM DRAWN - JPA CHECKED - TH DATE - 12/19/12	REVISED - REVISED - REVISED - REVISED -	MCHENRY COUNTY DIVISION OF TRANSPORTATION		DRAINAGE AND UTILITY PLAN JOHNSBURG ROAD		F.A.U. RTE. = 168 SECTION = 05-00314-00-WR COUNTY = MCHENRY FEDERAL AID PROJECT	TOTAL SHEETS = 187 SHEET NO. = 52 CONTRACT NO. = 63515
---	--	---	--	--	---	--	--	--	--	--