
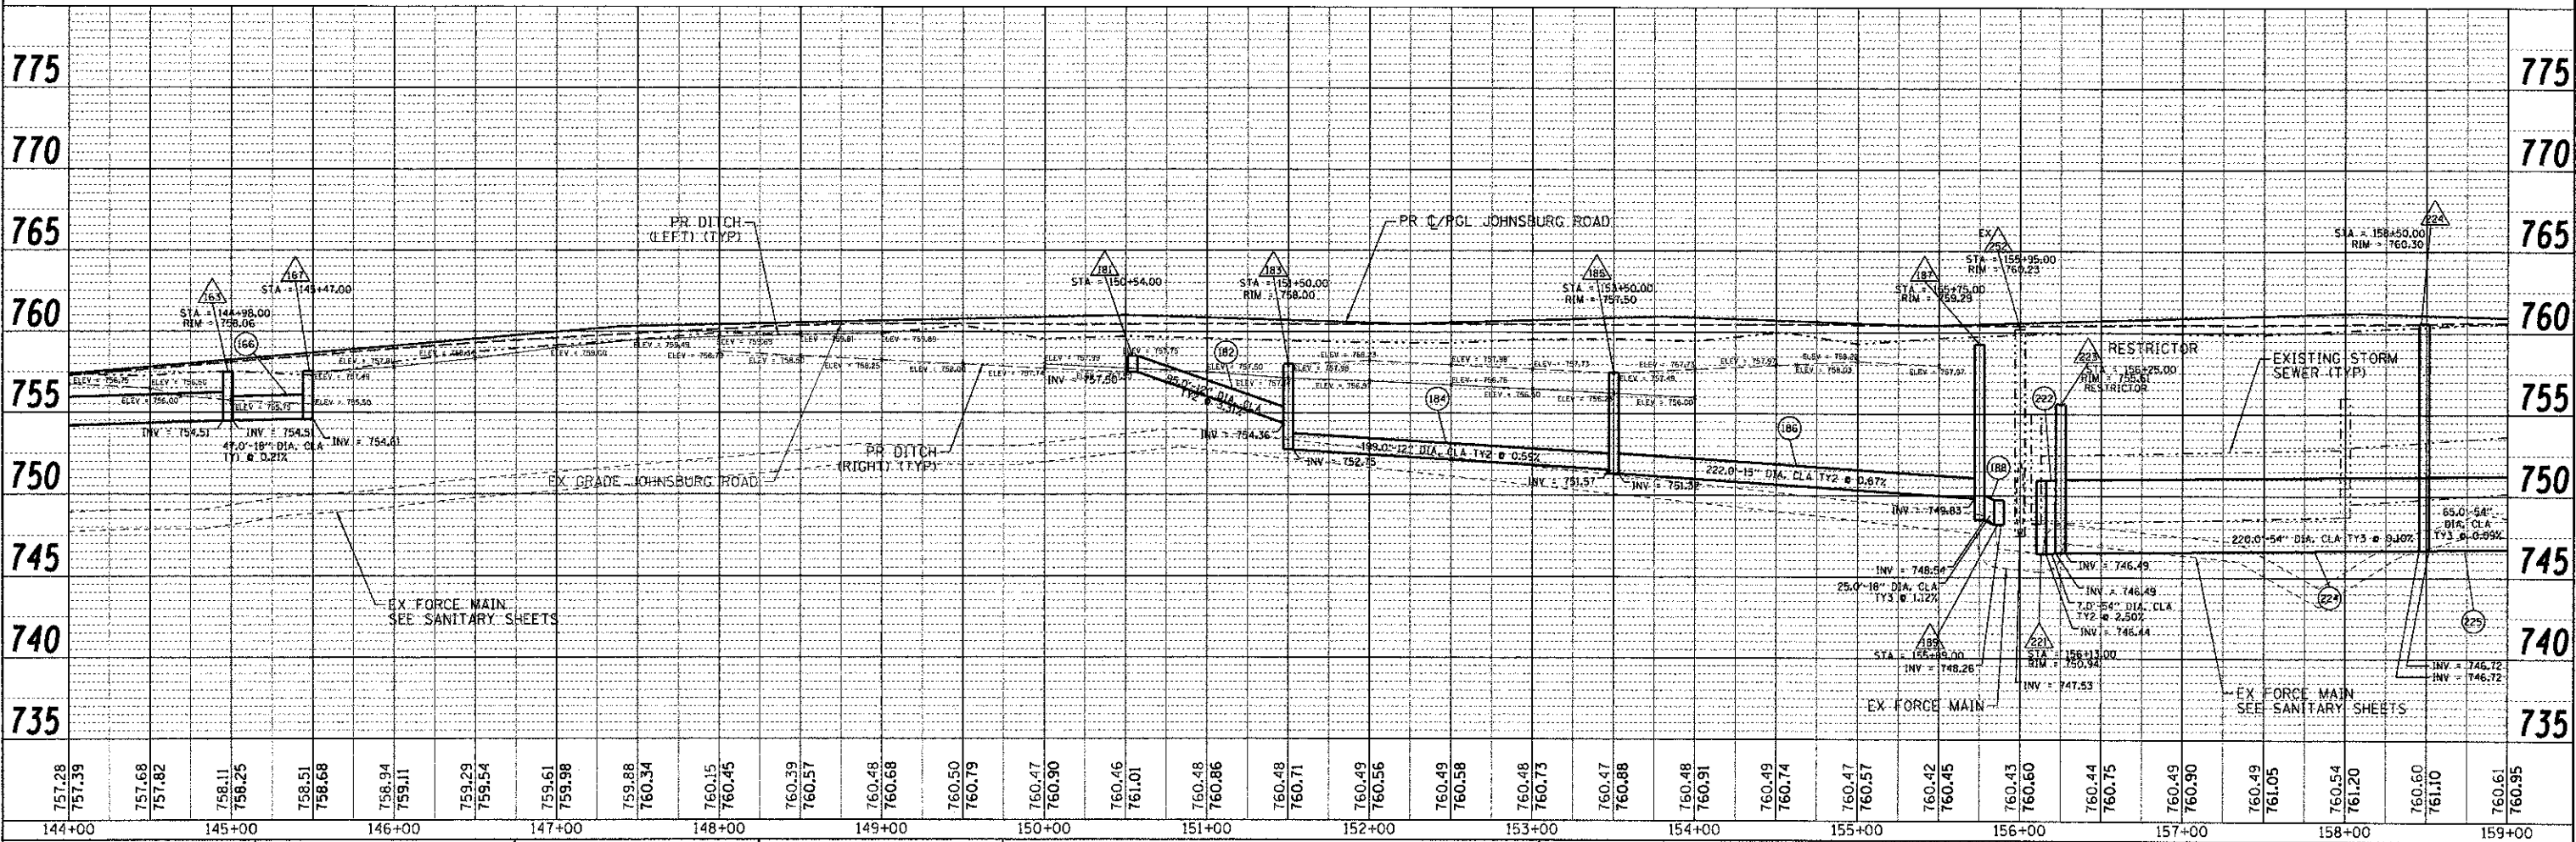


PLAN	REVISIONS	DATE
NOTE BOOK	ALIGNED	CHECKED
NO.	PAID FILE NAME	

PROFILE	REVISIONS	DATE
NOTE BOOK	CHANGS CHECKED	
NO.	STRUCTURE NOTATION	

COMPANY NAME: HRGreen
 PROJECT CONTACT: Jettara
 CLIENT: MCHENRY COUNTY
 DATE PLOTTED: 12/19/2012 3:17 PM
 FILE NAME: 08622-00-04.dgn
 PLOT DRIVER: plot_driver.exe
 PLOT TABLE: 08622-00-04.tbl

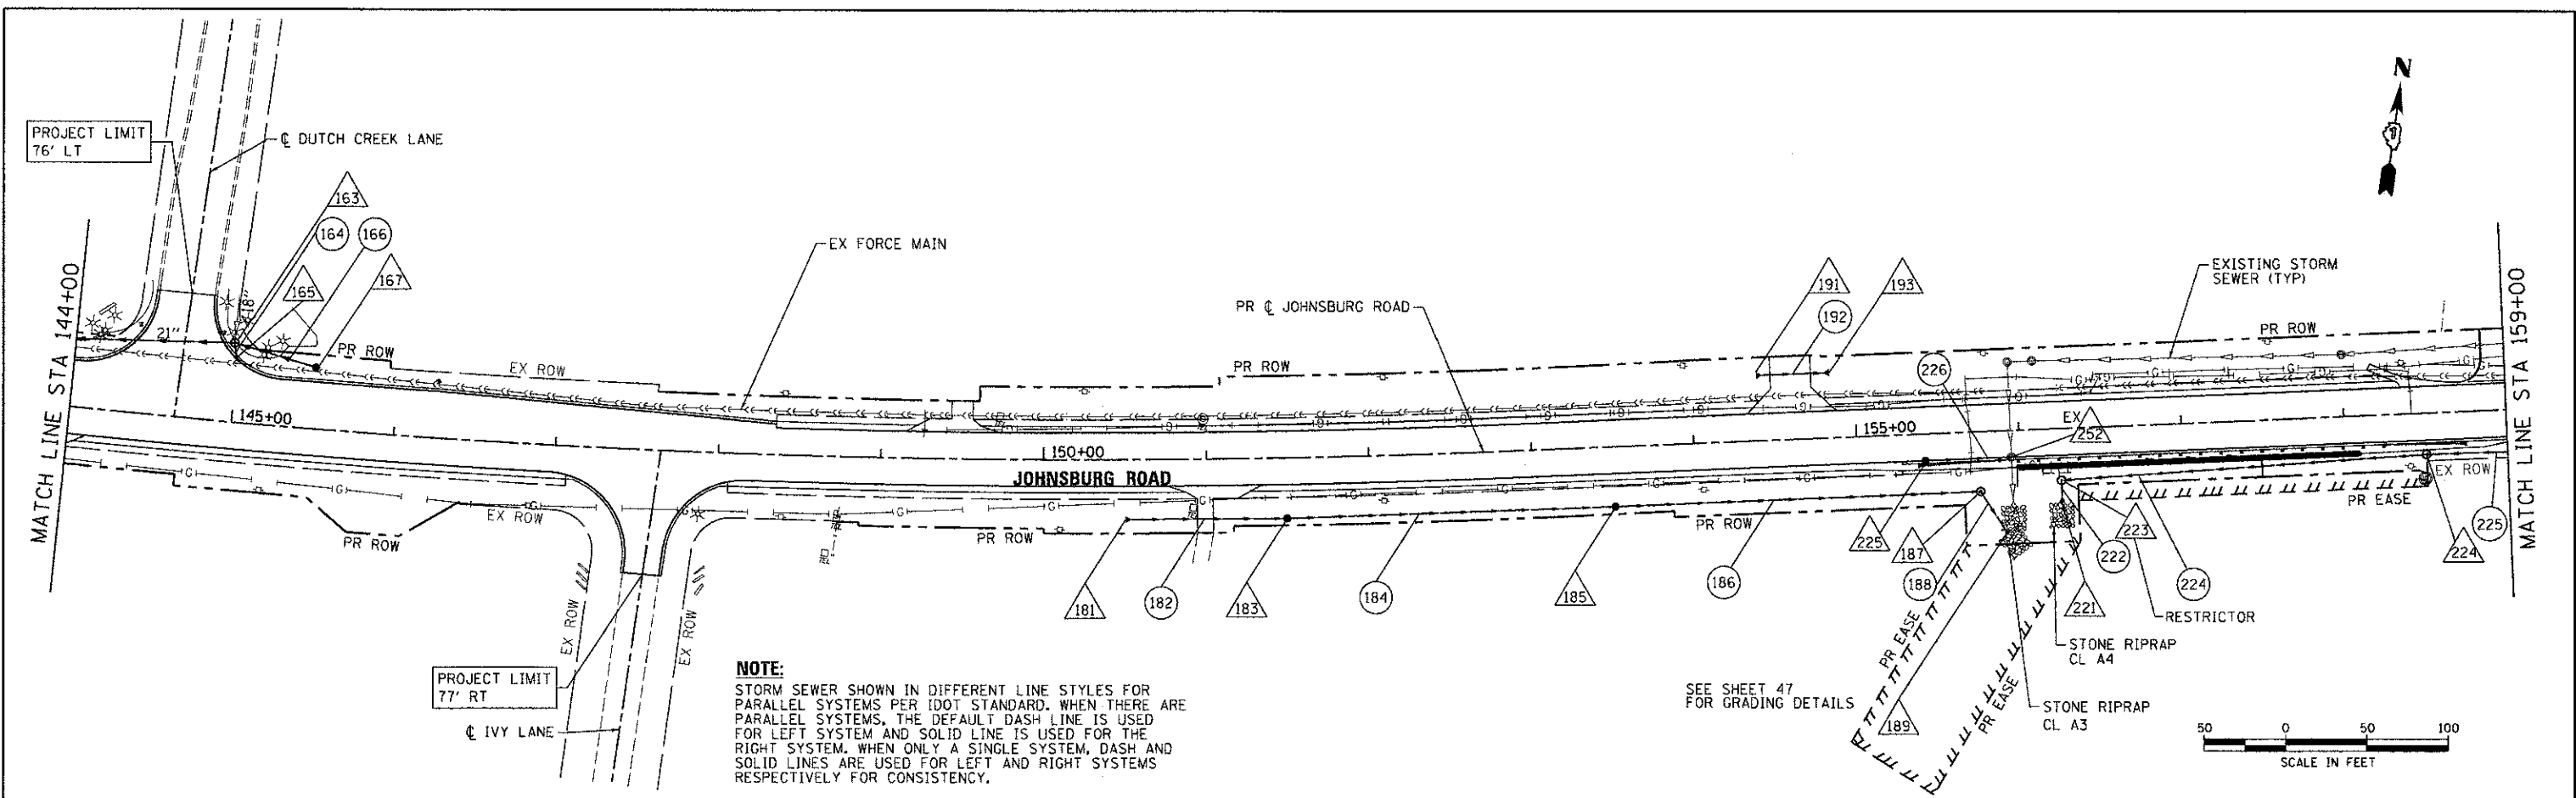

144+00	145+00	146+00	147+00	148+00	149+00	150+00	151+00	152+00	153+00	154+00	155+00	156+00	157+00	158+00	159+00																																								
757.28	757.39	757.68	757.82	758.11	758.25	758.51	758.68	758.94	759.11	759.29	759.54	759.61	759.98	759.88	760.34	760.15	760.45	760.39	760.57	760.46	761.01	760.48	760.86	760.48	760.71	760.49	760.56	760.49	760.58	760.48	760.73	760.47	760.88	760.48	760.91	760.49	760.74	760.47	760.57	760.42	760.45	760.43	760.60	760.44	760.75	760.49	760.90	760.49	761.05	760.54	761.20	760.60	761.10	760.61	760.95

HRGreen
 HRGreen.com
 White Professional Design Firm
 #184-001322

USER NAME	= jettara	DESIGNED	= JRM	REVISED	=
FILE NAME	= 08622-00-04.dgn	DRAWN	= JPA	REVISED	=
PLOT SCALE	= 1" = 50'	CHECKED	= TH	REVISED	=
PLOT DATE	= 12/19/2012	DATE	= 12/19/12	REVISED	=

**MCHENRY COUNTY
 DIVISION OF TRANSPORTATION**

**DRAINAGE AND UTILITY PLAN
 JOHNSBURG ROAD**

SCALE: 1" = 50' SHEET NO. 4 OF 7 SHEETS STA. TO STA.

F.A.U. RTE.	SECTION	COUNTY	TOTAL SHEETS	SHEET NO.
168	05-00314-00-WR	MCHENRY	187	53
FED. ROAD DIST. NO.			ILLINOIS FED. AID PROJECT	
CONTRACT NO.			63515	