


PLANTER ARM INSTALLATION

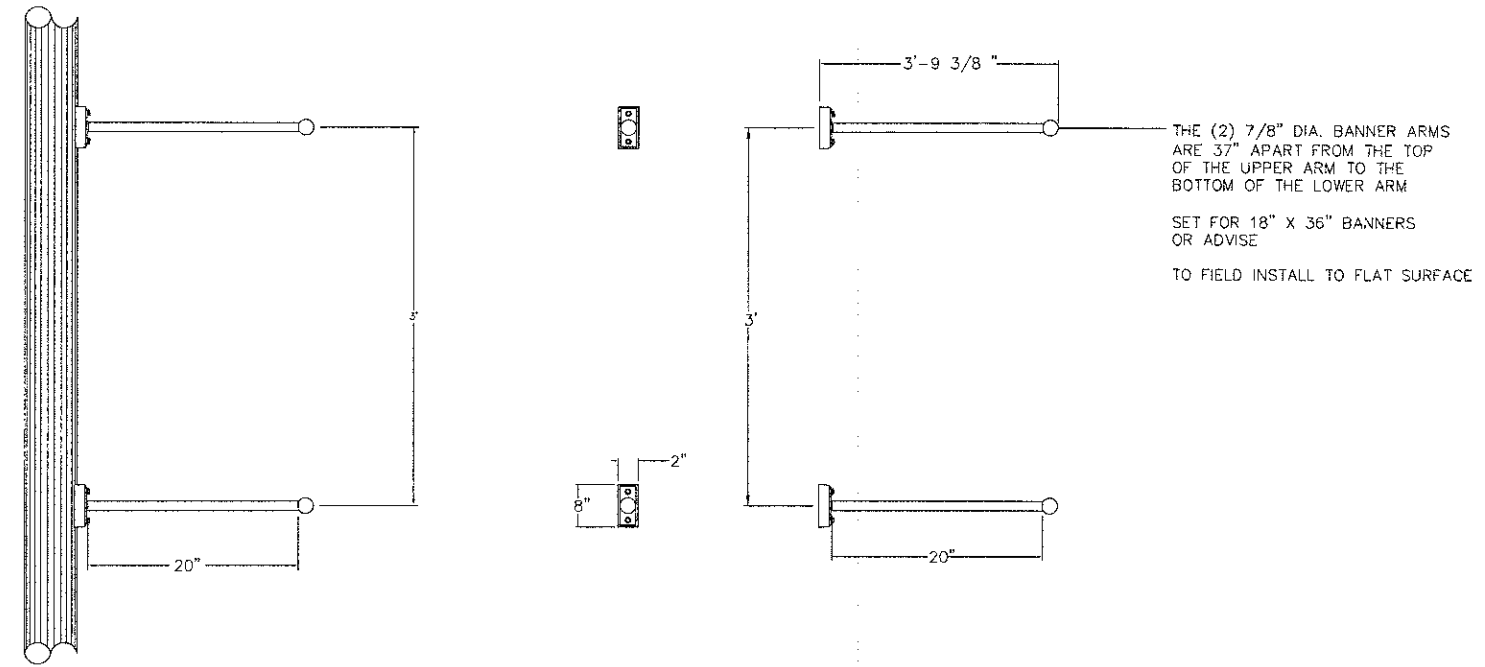

BANNER ARM INSTALLATION

NOTES:
 1. BANNER AND PLANTER ARMS SHALL MEET AASHTO DESIGN CRITERIA (LOADING AND CALCULATION REQUIREMENTS) 90 MPH-3 SEC WIND SPEEDS.

COMPANY NAME: HRGreen.com
 PROJECT CONTACT: HRGreen.com
 DATE PLOTTED: 12/19/2012 3:06:55 PM
 FILE NAME: RLP-13.dgn
 PLOT SCALE: 1" = 10'-0"



USER NAME	: jettone	DESIGNED	-	REVISED	-
FILE NAME	: RLP-13.dgn	DRAWN	-	REVISED	-
PLOT SCALE	:	CHECKED	-	REVISED	-
PLOT DATE	: 12/19/2012	DATE	: 12/19/12	REVISED	-

MCHENRY COUNTY
 DIVISION OF TRANSPORTATION

LIGHTING PLAN
 LIGHTING DETAILS

SCALE: SHEET NO. 11 OF 13 SHEETS STA. TO STA.

F.A.U. RTE.	SECTION	COUNTY	TOTAL SHEETS	SHEET NO.
168	05-00314-00-WR	MCHENRY	187	119
FED. ROAD DIST. NO.			ILLINOIS FED. AID PROJECT	
			CONTRACT NO. 63515	

RLP-13