



ORNAMENTAL LIGHT UNIT WITH BANNER, COMPLETE

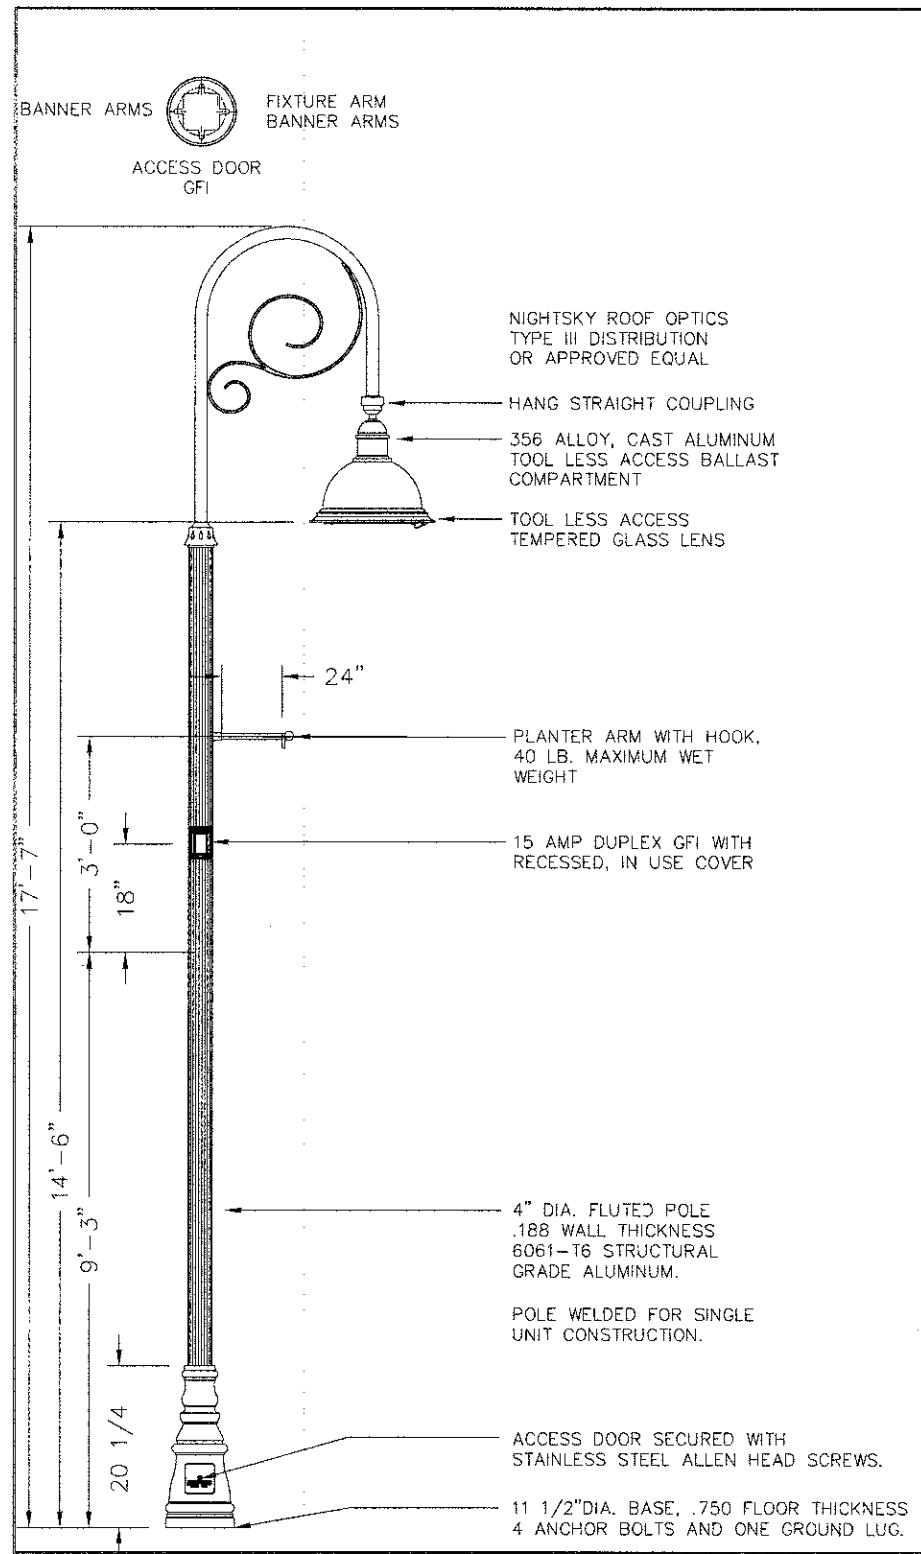

ORNAMENTAL LIGHT UNIT WITH PLANTER, COMPLETE

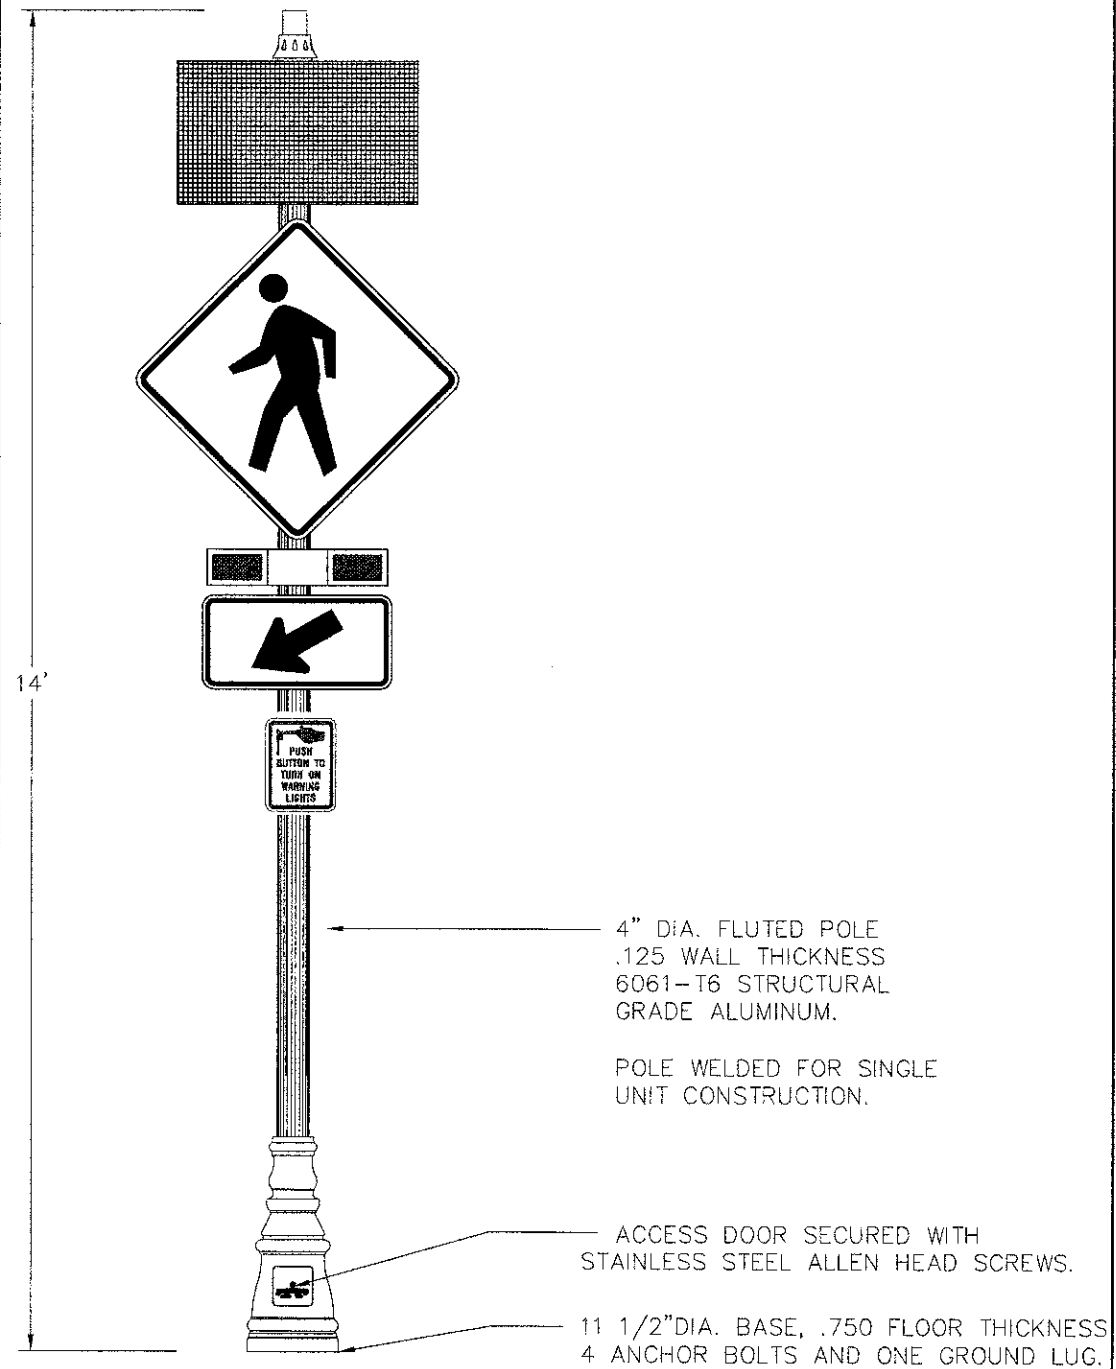

11 1/2" DIA. BASE, .750 FLOOR THICKNESS 4 ANCHOR BOLTS AND ONE GROUND LUG.

COMPANY NAME: HRGreen.com  
 PROJECT CONTACT: HRGreen.com  
 DATE PLOTTED: 12/19/2012 9:17:47 AM  
 FILE NAME: 080622-lighting-detail-08.dwg  
 PLOT DRIVER: pldrvr.exe  
 PEN TABLE: s:\standard-trans.tbl



USER NAME = jettano	DESIGNED -	REVISED -
FILE NAME = 080622-lighting-detail-08.dwg	DRAWN -	REVISED -
PLOT SCALE =	CHECKED -	REVISED -
PLOT DATE = 12/19/2012	DATE = 12/19/12	REVISED -

MCHENRY COUNTY  
 DIVISION OF TRANSPORTATION

LIGHTING PLAN  
 ORNAMENTAL LIGHTING UNITS

SCALE: SHEET NO. 13 OF 13 SHEETS STA. TO STA.

F.A.U. RTE.	SECTION	COUNTY	TOTAL SHEETS	SHEET NO.
168	05-00314-00-WR	MCHENRY	187	121
FED. ROAD DIST. NO. ILLINOIS FED. AID PROJECT			CONTRACT NO. 63515	