 



PLAN	DESIGNED	BY	DATE
	NOTED		
	CHECKED		
	DATE		
	NO.		
	FILE NAME		

PROFILE	SURVEYED	BY	DATE
	PLOTTED		
	DATE		
	NO.		
	FILE NAME		

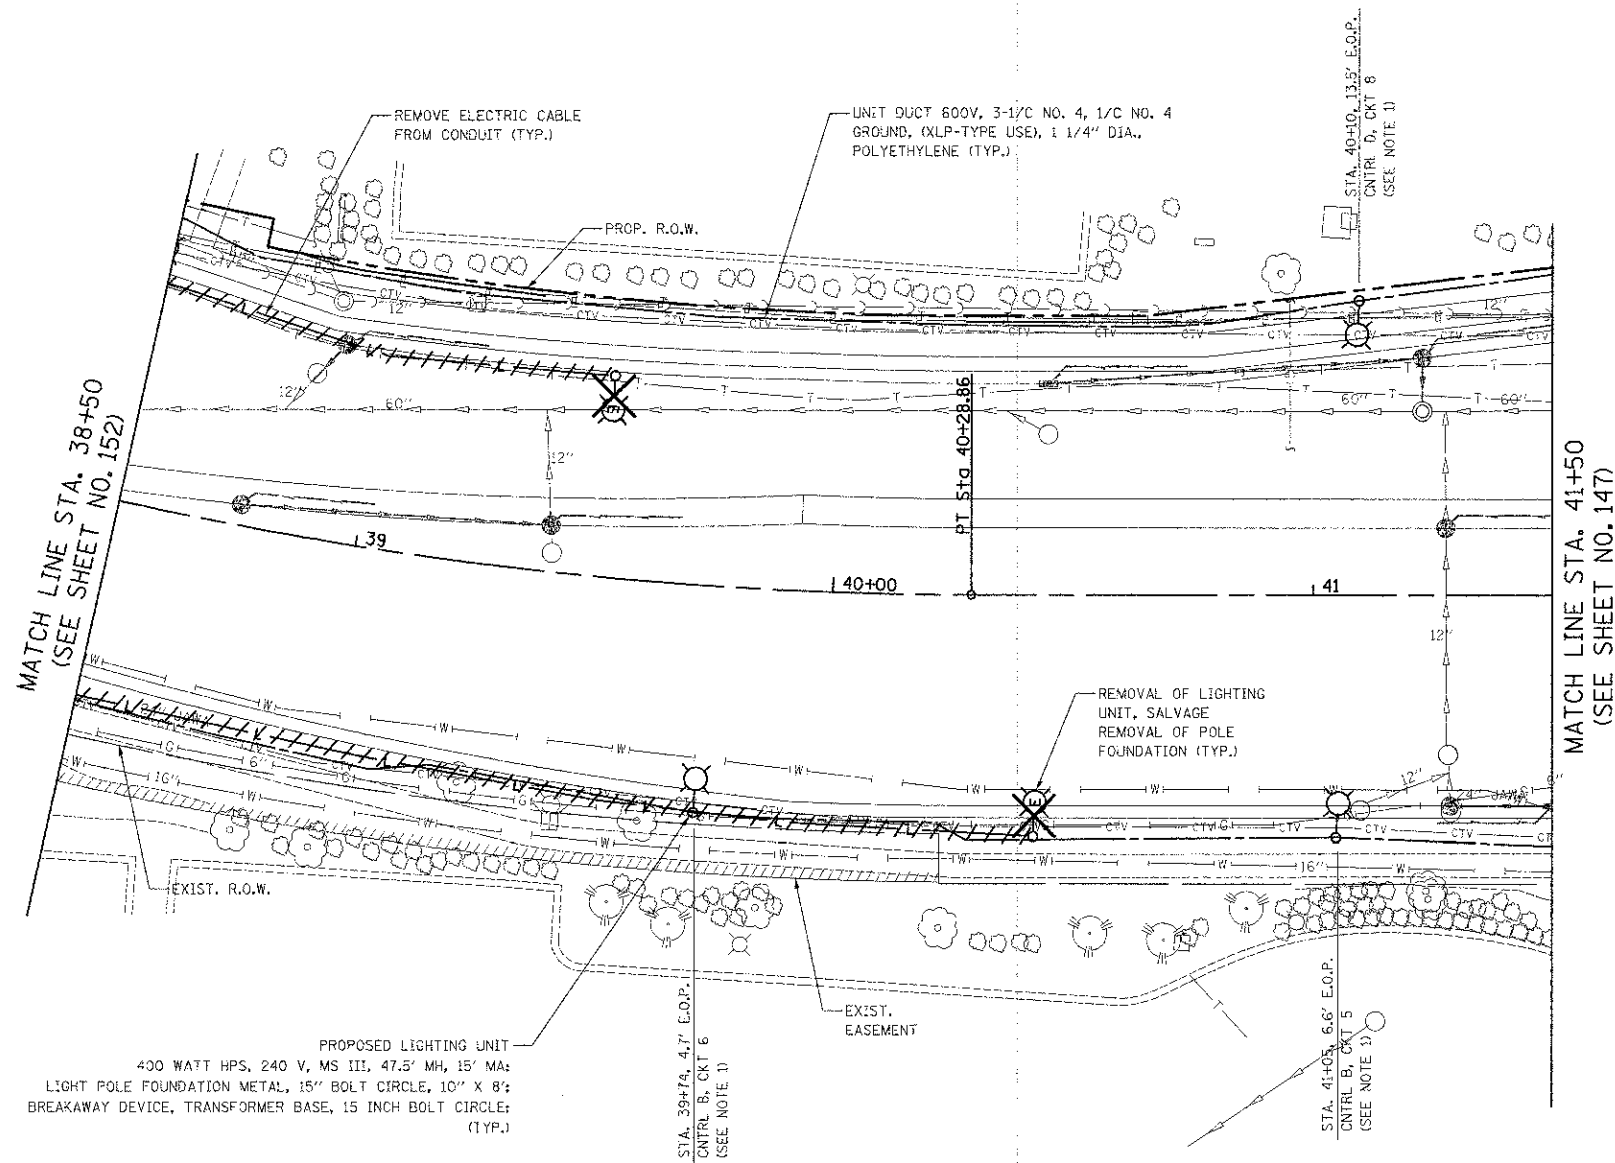

SCHAUMBURG ROAD

- NOTE:
1. THE LIGHT POLE, MAST ARM AND LUMINAIRE SHALL BE POWDER COATED BLACK FINISH.

FILE NAME = ...\\ond\ahoe\1329\11011\_08.dgn

USER NAME = djk  
 PLOT SCALE = 20.0000' / in.  
 PLOT DATE = 8/16/2012

DESIGNED - SJC  
 DRAWN - SJC  
 CHECKED - DNM  
 DATE - 8-20-12

REVISED -  
 REVISED -  
 REVISED -  
 REVISED -

STATE OF ILLINOIS  
 DEPARTMENT OF TRANSPORTATION

SCHAUMBURG ROAD  
 LIGHTING PLANS

SCALE: 1" = 20' SHEET NO. 9 OF 12 SHEETS STA. 38+50 TO STA. 41+50

F.A.U. RTE.	SECTION	COUNTY	TOTAL SHEETS	SHEET NO.
1322	01-00074-00-CH	COOK	245	153
CONTRACT NO. 63629				
FED. ROAD DIST. NO. 1 ILLINOIS FED. AID PROJECT M-CM-800305D				