 
 



PLAN	DATE
BY	
REVISIONS	
NO.	

PROFILE	DATE
BY	
REVISIONS	
NO.	

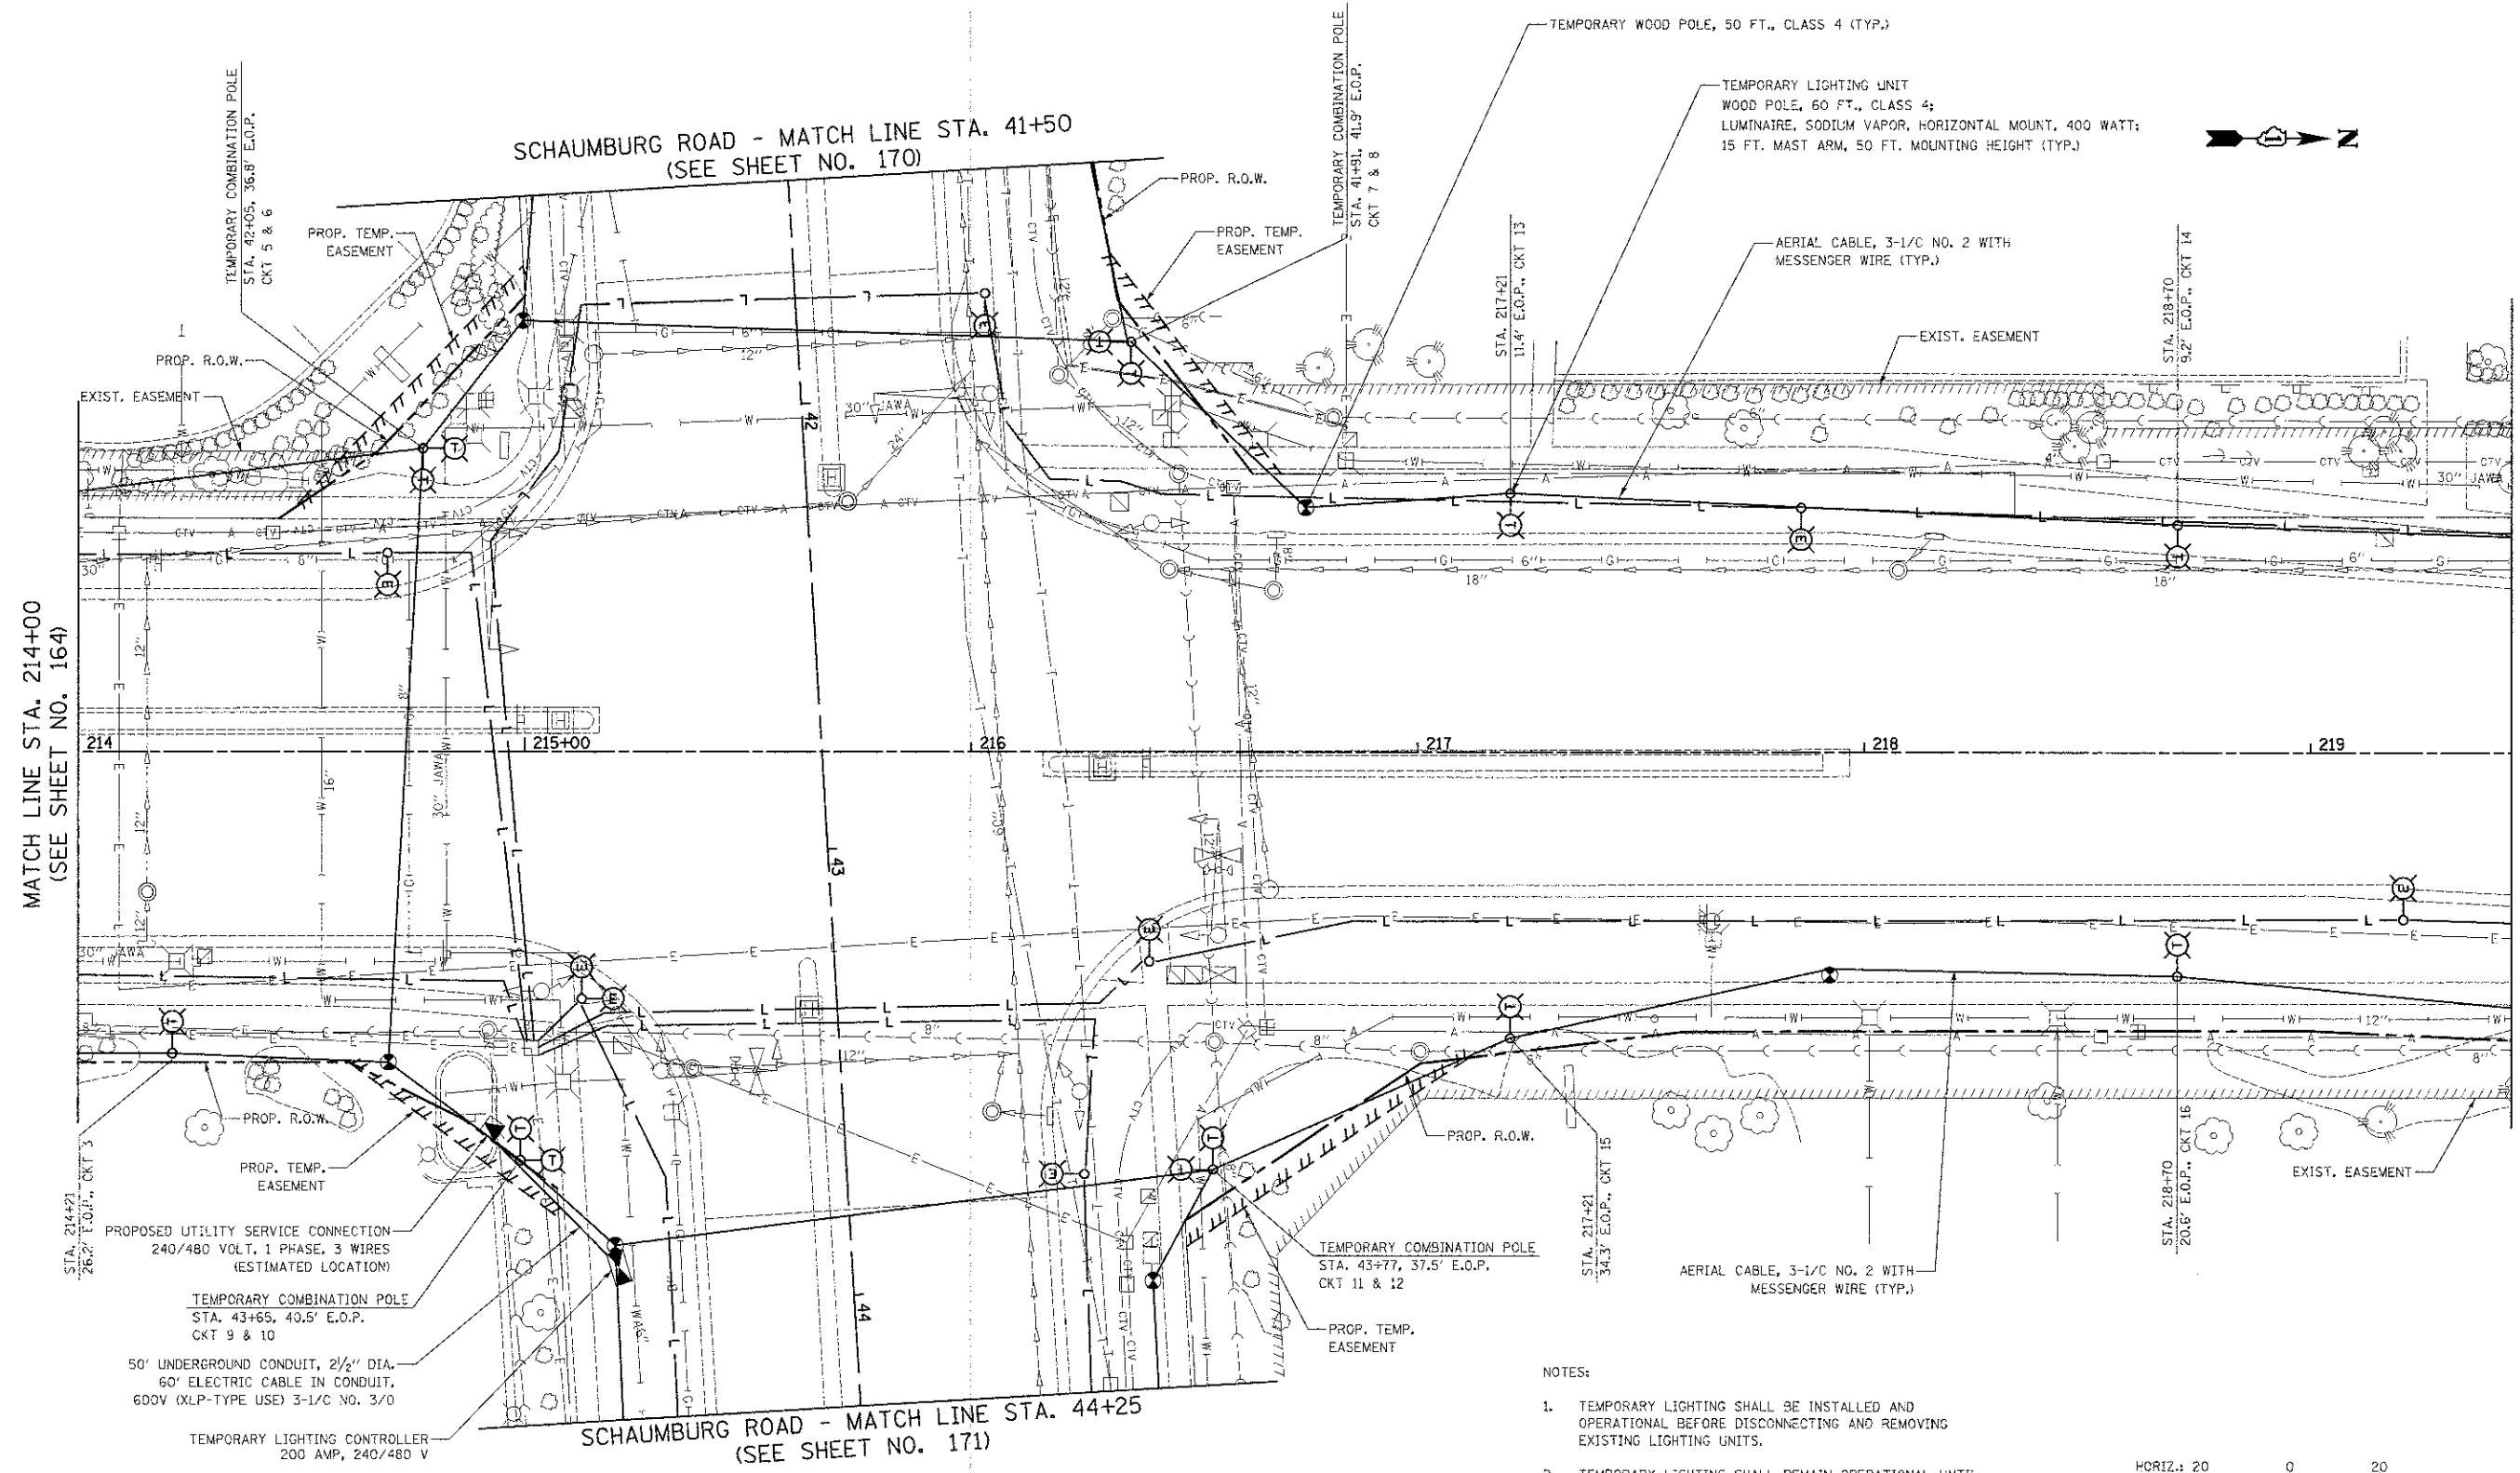

- NOTES:
1. TEMPORARY LIGHTING SHALL BE INSTALLED AND OPERATIONAL BEFORE DISCONNECTING AND REMOVING EXISTING LIGHTING UNITS.
 2. TEMPORARY LIGHTING SHALL REMAIN OPERATIONAL UNTIL THE PROPOSED LIGHTING SYSTEM IS INSTALLED AND IS OPERATIONAL.
 3. REMOVAL OF COMBINATION POLE SHALL BE PART OF TRAFFIC SIGNAL SYSTEM BUT REMOVAL OF TEMPORARY LUMINAIRES AND MAST ARMS ON THOSE POLES ARE REMOVED AND PAID FOR AS PART OF "REMOVAL OF TEMPORARY LIGHTING UNIT".

BARRINGTON ROAD

FILE NAME = sheet\2329_TEMP_LIGHT_03.dgn

USER NAME = djr
 DESIGNED - SJC
 DRAWN - SJC
 PLOT SCALE = 20.0000' / in.
 CHECKED - DNM
 PLOT DATE = 6/5/2012

REVISIONS:
 REVISED -
 REVISED -
 REVISED -
 REVISED -
 DATE - 8-20-12

STATE OF ILLINOIS
 DEPARTMENT OF TRANSPORTATION

BARRINGTON ROAD
 TEMPORARY LIGHTING PLANS

SCALE: 1" = 20' SHEET NO. 3 OF 11 SHEETS STA. 214+00 TO STA. 219+45

F.A.U. RTE.	SECTION	COUNTY	TOTAL SHEETS	SHEET NO.
1322	01-00074-00-CH	COOK	245	165
CONTRACT NO. 63629				
FED. ROAD DIST. NO. 1 ILLINOIS FED. AID PROJECT M-600(065)				