



FOR STATION 7+80L TO STATION 12+50L - THE GENERAL CONTRACTOR IS REQUIRED TO HIRE AN ENVIRONMENTAL FIRM WITH AT LEAST FIVE (5) DOCUMENTED LEAKING UNDERGROUND STORAGE TANK CLEANUPS OR THAT IS PRE-QUALIFIED IN HAZARDOUS WASTE BY THE DEPARTMENT TO REMEDIATE THE SOIL CONTAMINATION AND MONITOR FOR WORKER PROTECTION.

PLAN	SURVEYED	DATE	BY
	PLOTTED		
	ALIGNED		
	CHECKED		
	NO.		

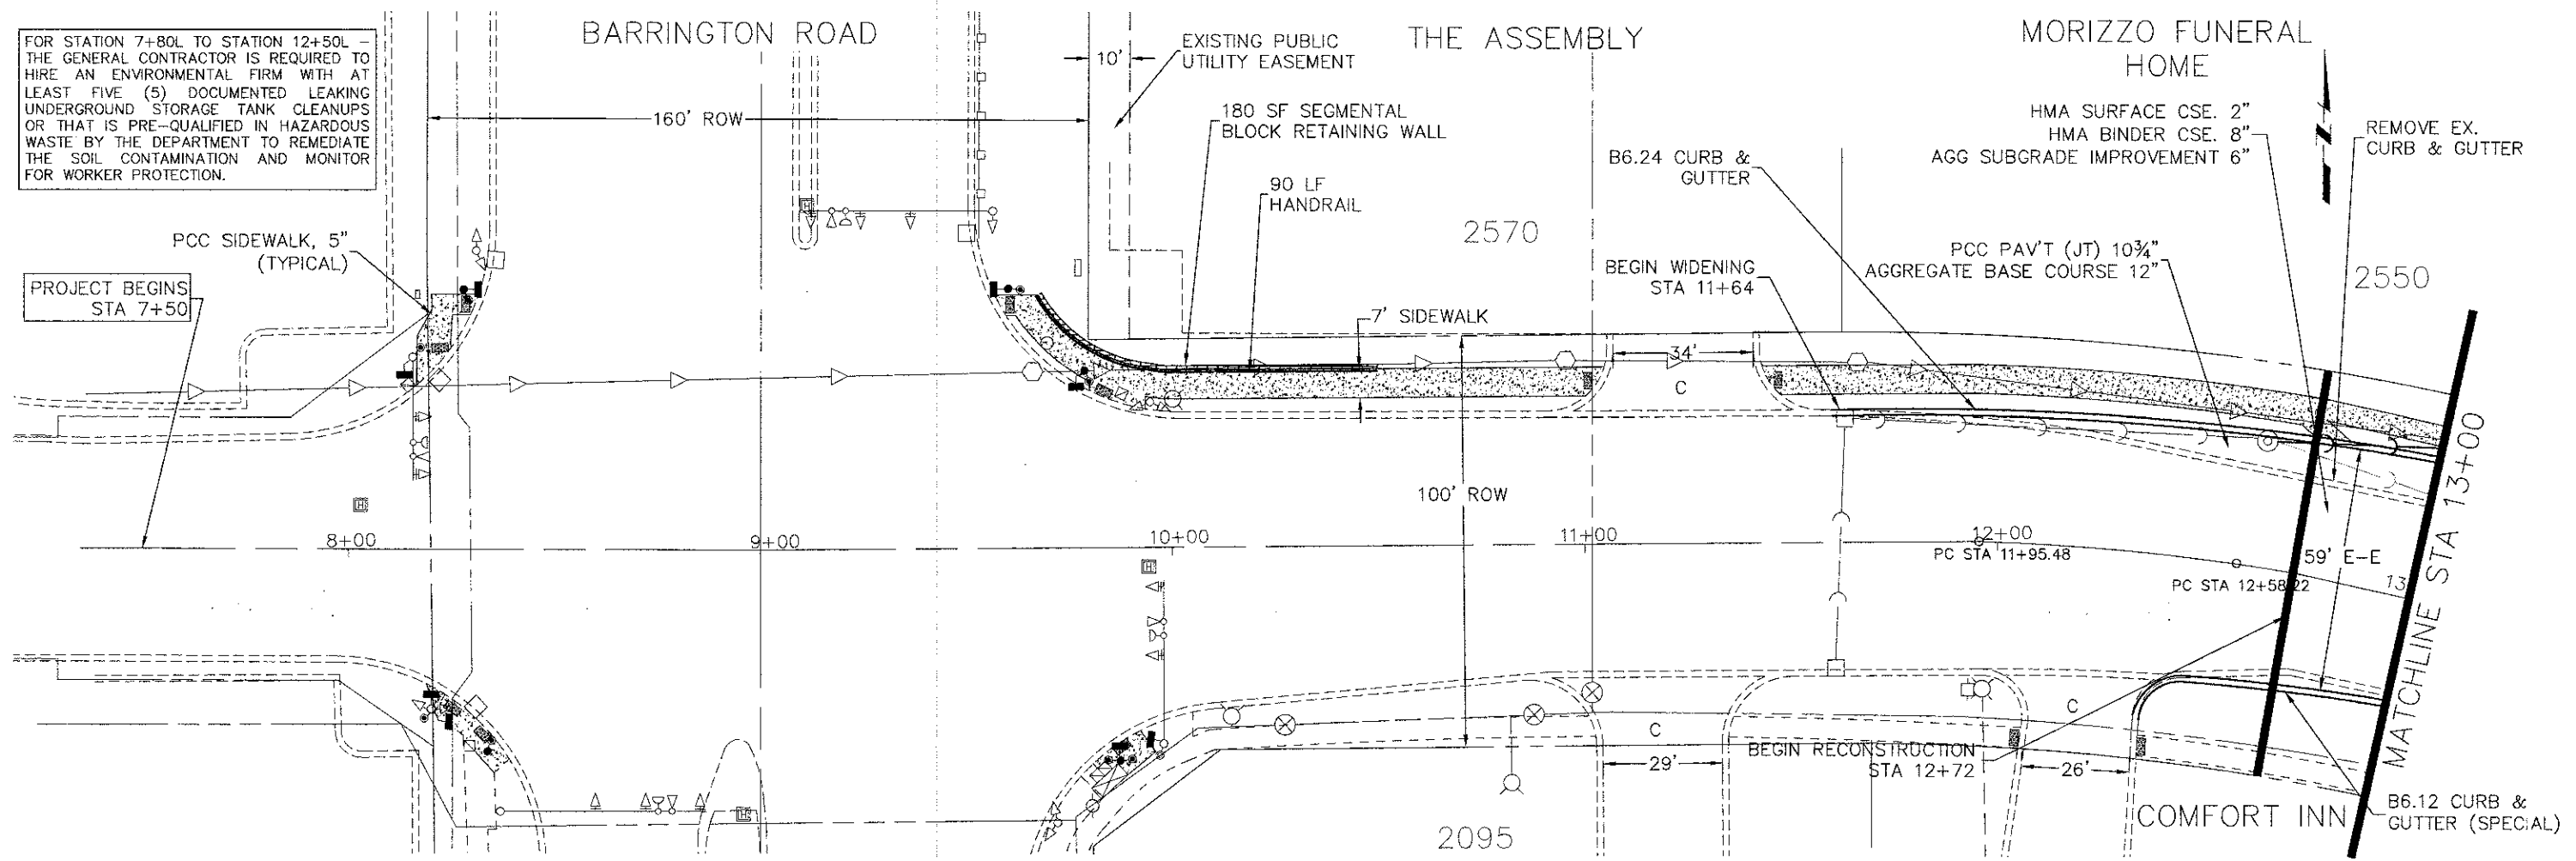

PROFILE	SURVEYED	DATE	BY
	PLOTTED		
	GRADES		
	CHECKED		
	NO.		

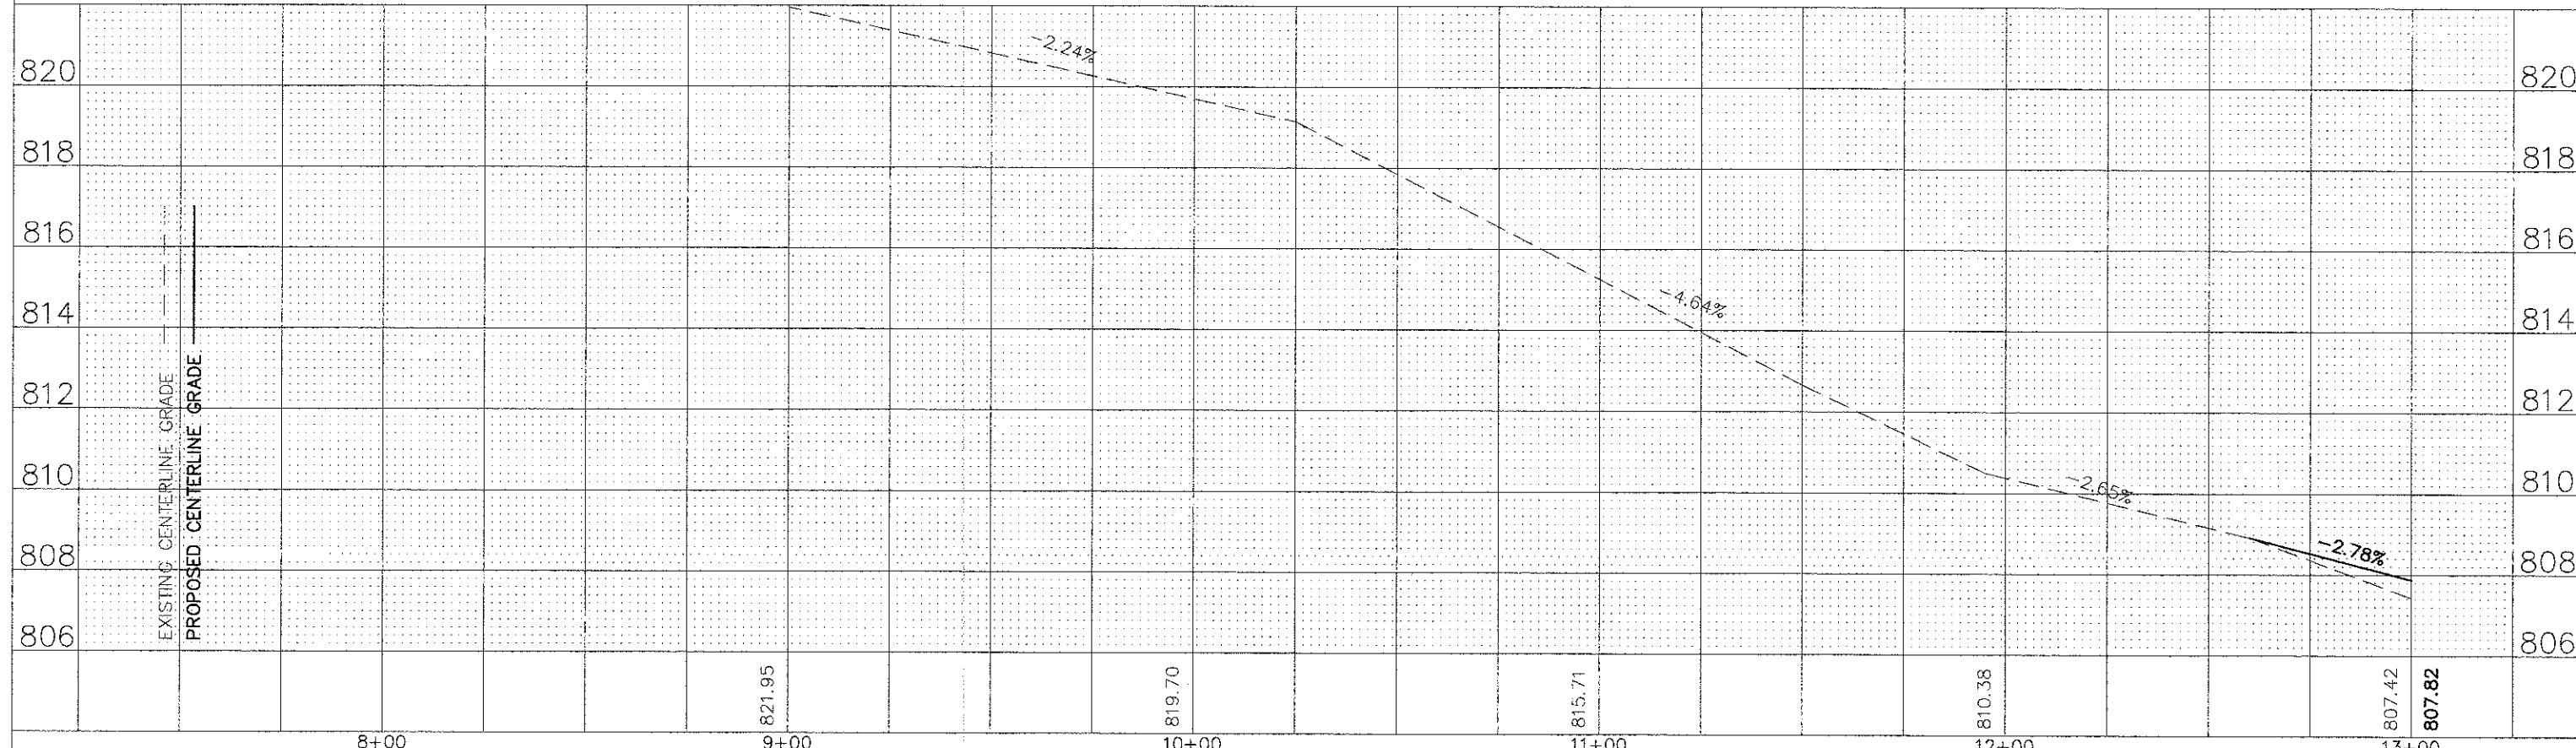

FILE NAME = Hassell Plan-Profile.dwg	DESIGNED -	REVISÉ -	STATE OF ILLINOIS DEPARTMENT OF TRANSPORTATION	Hassell Road STP Project		F.A.U. RTE.	SECTION	COUNTY	TOTAL SHEET SHEETS
	DRAWN -	REVISÉ -		Plan and Profile		1100	11-00087-00-FP	Cook	164 15
	CHECKED -	REVISÉ -		SCALE: 1" = 20'		SHEET NO. 1 OF 16 SHEETS		CONTRACT NO. 63770	
	DATE -	REVISÉ -		STA. 8+00 TO STA 13+00		ILLINOIS FED. AID PROJECT CMM 9003(757)			