



PLAN	SURVEYED	DATE
	PLOTTED	BY
	NOTE BOOK	
	NO.	

PROFILE	SURVEYED	DATE
	PLOTTED	BY
	NOTE BOOK	
	NO.	

McDonough Associates Inc.
 Engineers/Architects
 130 East Randolph Street Chicago, Illinois 60601

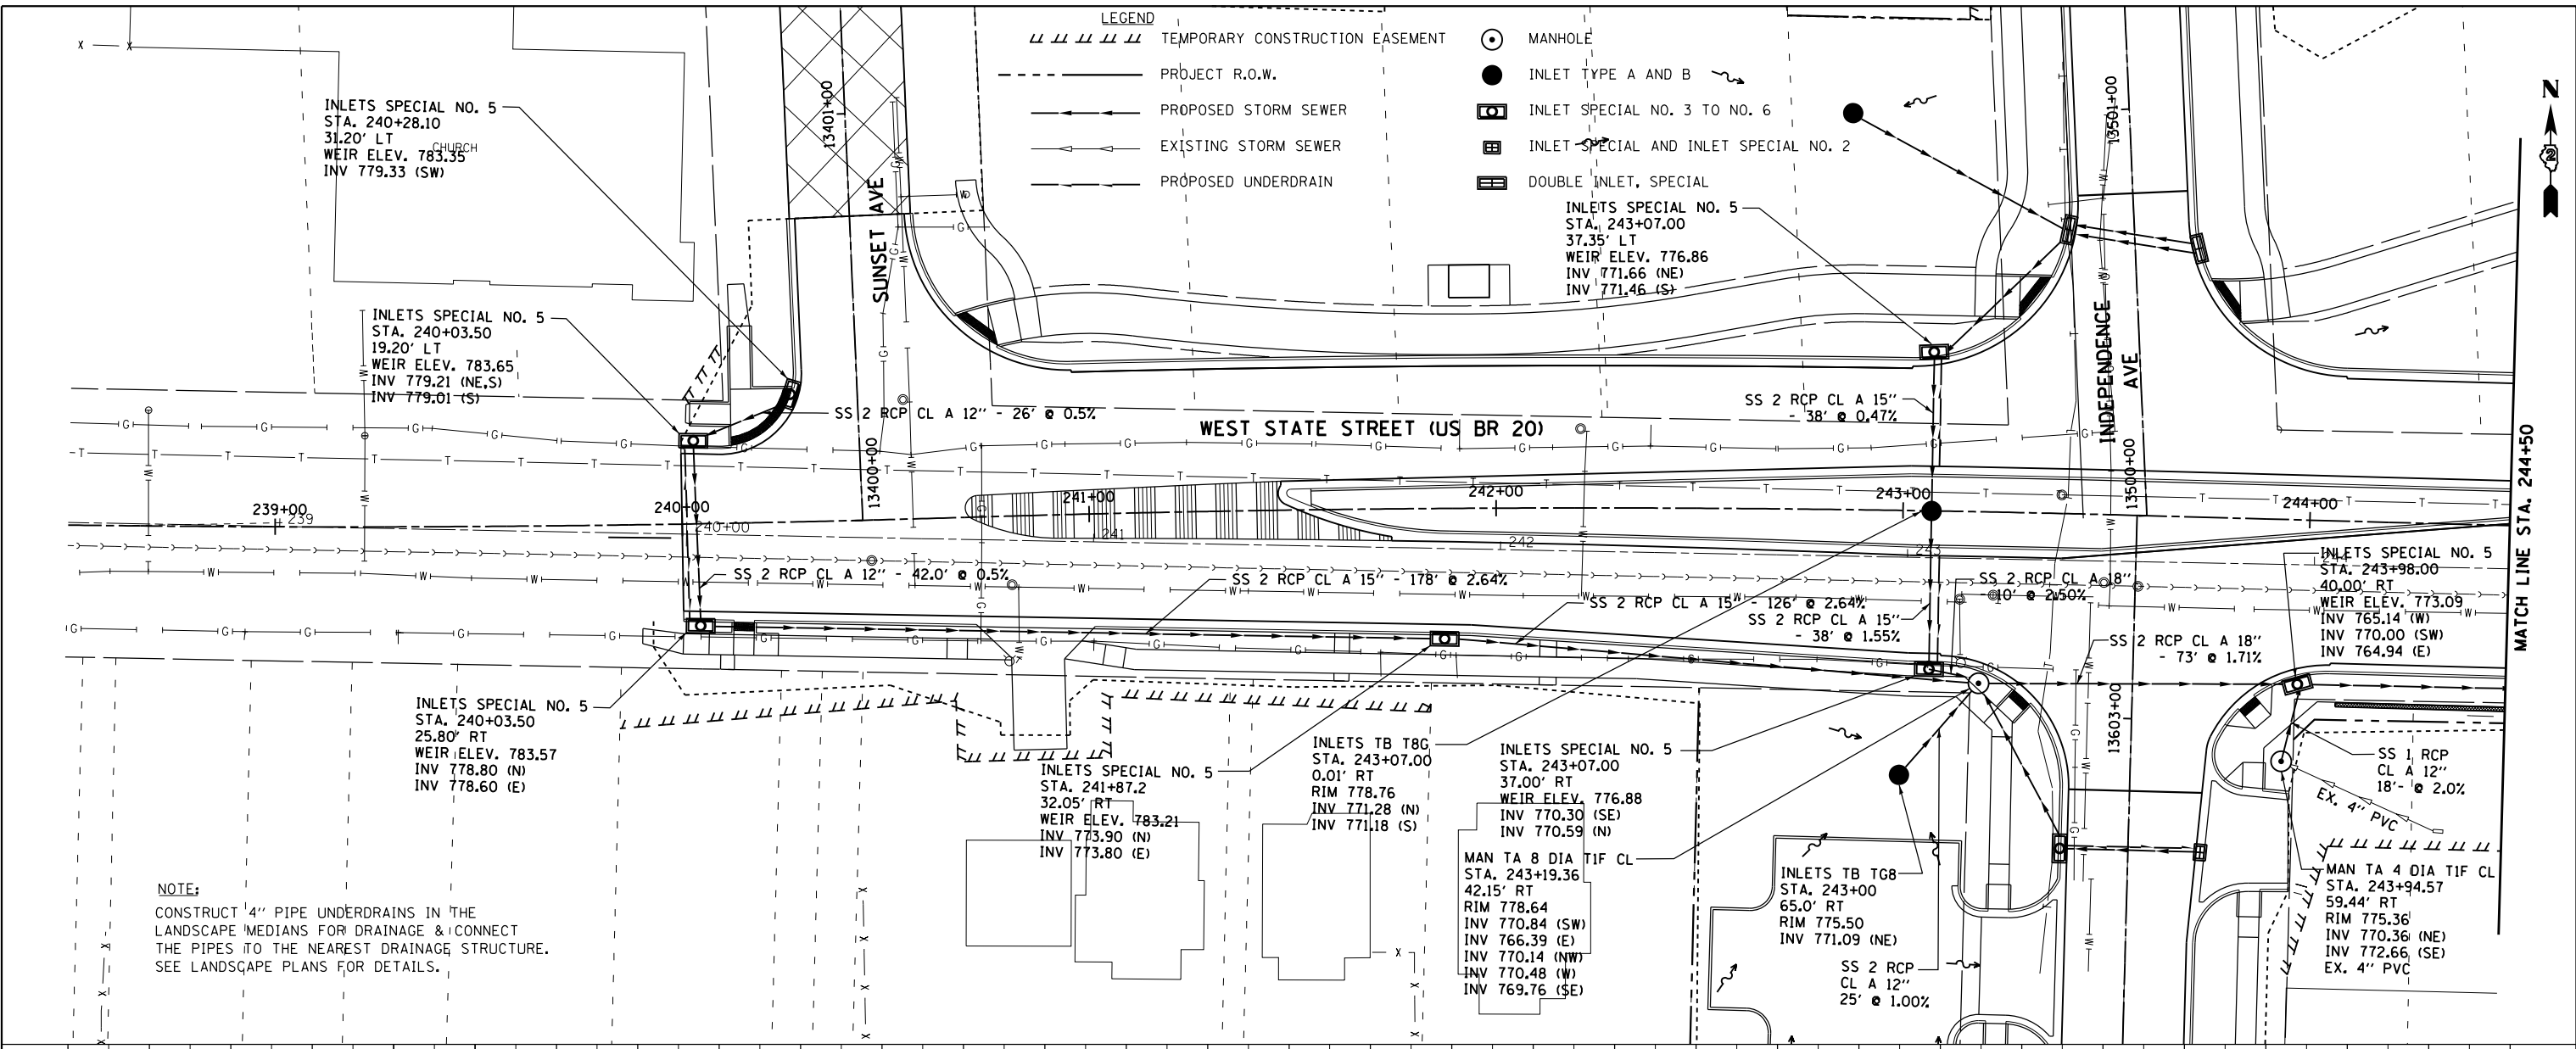

NOTE:
 CONSTRUCT 4" PIPE UNDERDRAINS IN THE
 LANDSCAPE MEDIANS FOR DRAINAGE & CONNECT
 THE PIPES TO THE NEAREST DRAINAGE STRUCTURE.
 SEE LANDSCAPE PLANS FOR DETAILS.

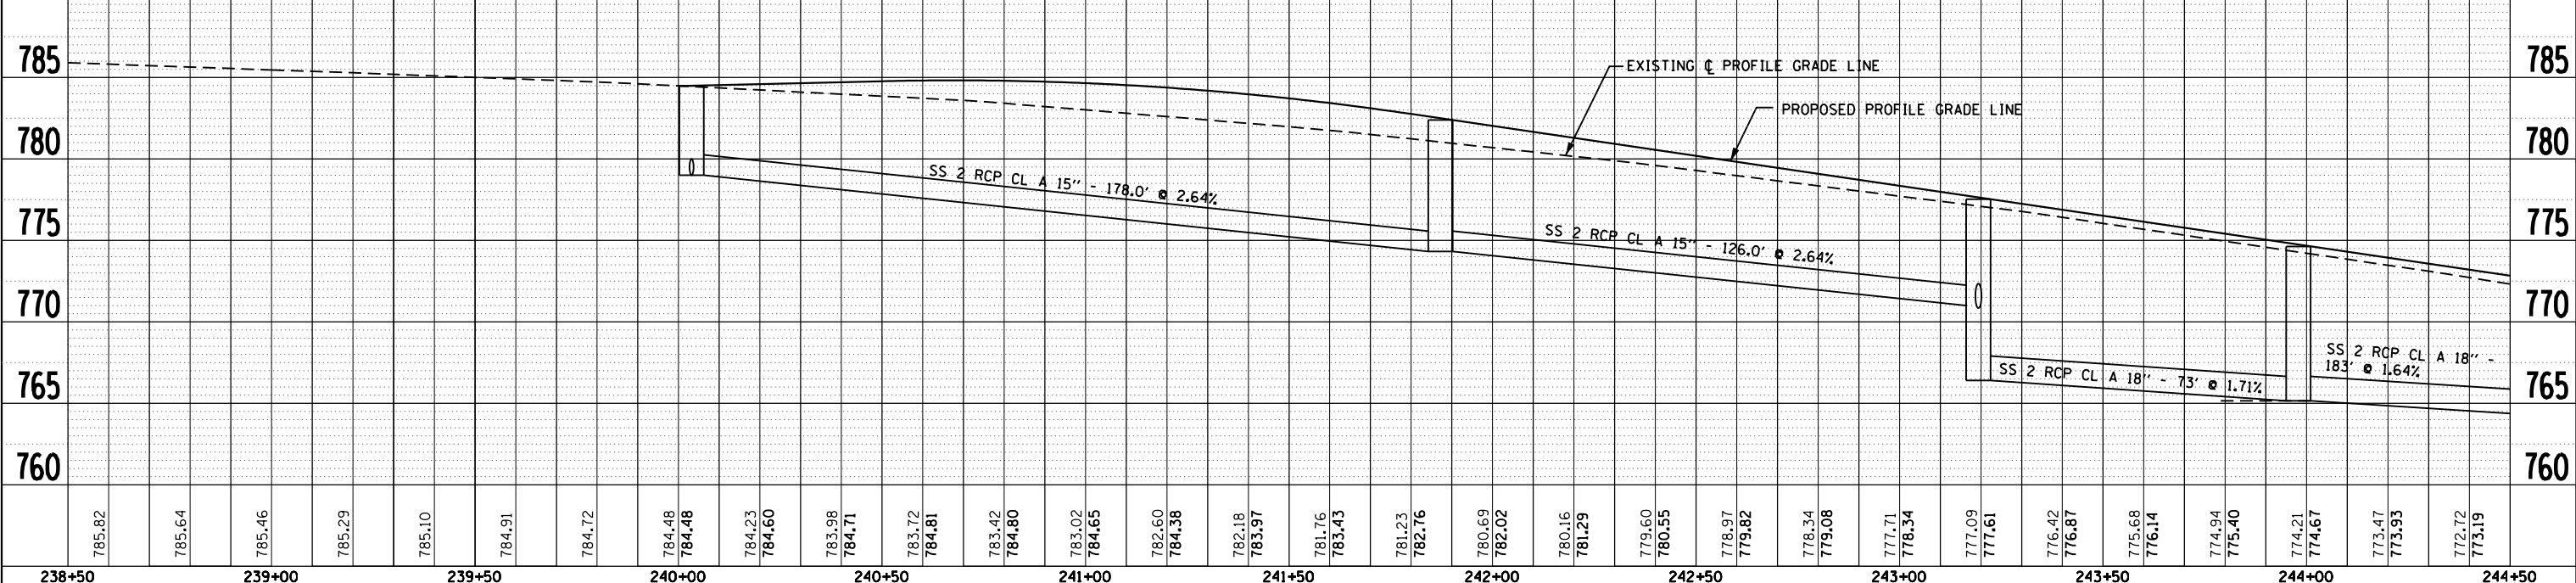

FILE NAME =	USER NAME = dssdd	DESIGNED - EJD	REVISED -	STATE OF ILLINOIS DEPARTMENT OF TRANSPORTATION	PROPOSED DRAINAGE PLAN AND PROFILE WEST STATE ST (US BUS 20)	F.A.P. RTE.	SECTION	COUNTY	TOTAL SHEETS	SHEET NO.
ct:\pwork\pwork\dssdd\0317619\0264750	sh-t-drain-145.dgn	DRAWN - EJD	REVISED -			303	41R	WINNEBAGO	327	145
PLOT SCALE = 40.0000' / in.	CHECKED - RCH	REVISED -	REVISED -			CONTRACT NO. 64750				
PLOT DATE = Mon Dec 17 14:48:43 2012	DATE - \$SUBDATE\$	REVISED -	REVISED -			FED. ROAD DIST. NO. 2 ILLINOIS FED. AID PROJECT				