



PLAN	SURVEYED	DATE
	PLOTTED	
	GRADES CHECKED	
	STRUCTURE NOTATIONS OK'D	
	NOTE BOOK NO.	
	CARD FILE NAME	

PROFILE	SURVEYED	DATE
	PLOTTED	
	GRADES CHECKED	
	STRUCTURE NOTATIONS OK'D	
	NOTE BOOK NO.	
	CARD FILE NAME	

McDonough Associates Inc.
 Engineers/Architects
 130 East Randolph Street Chicago, Illinois 60601

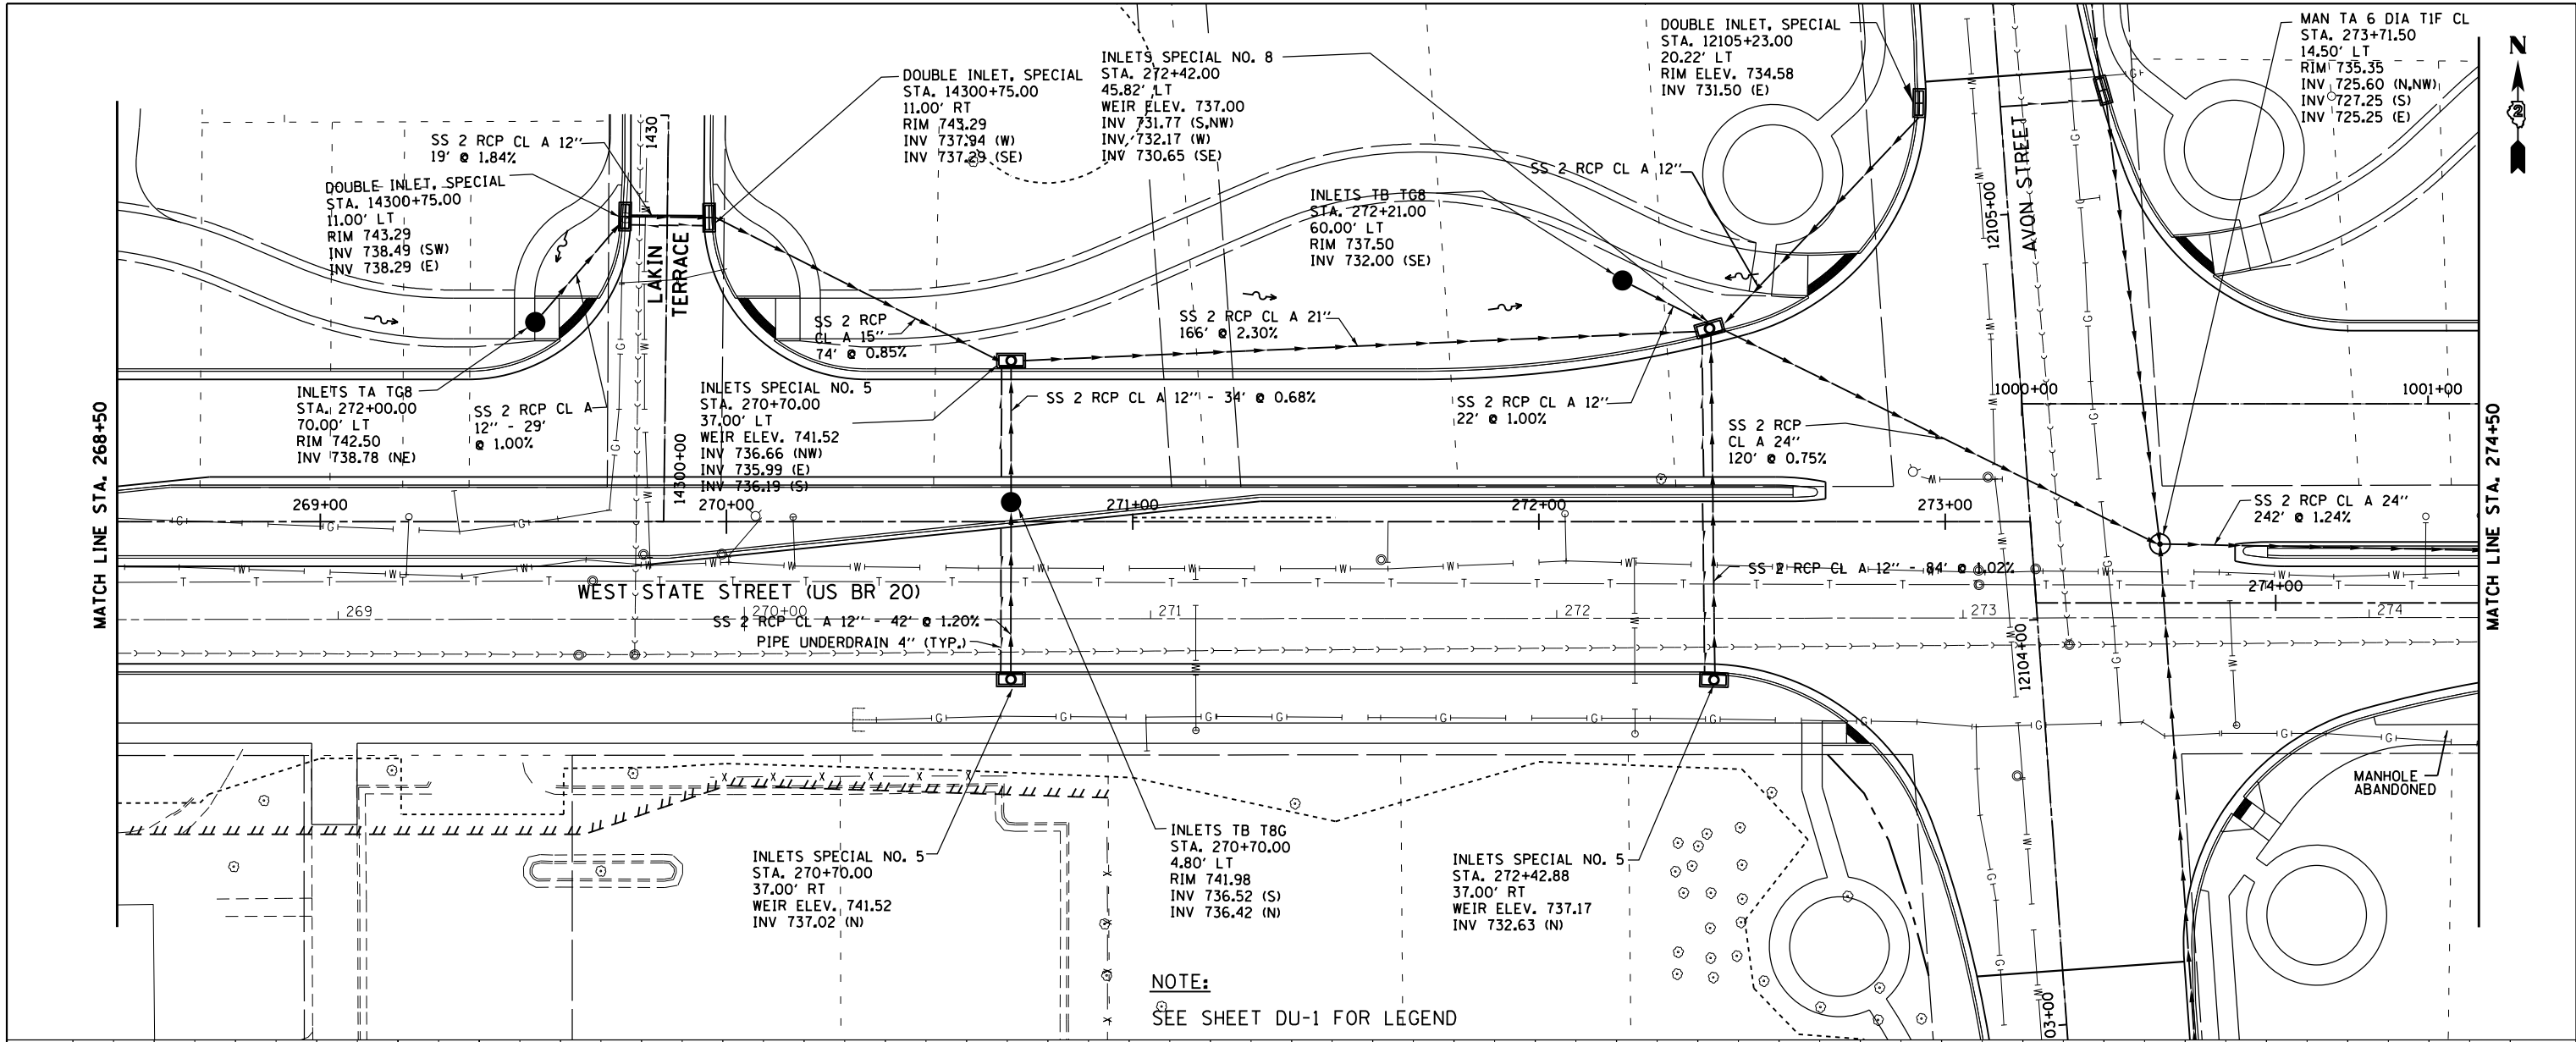

NOTE:
 SEE SHEET DU-1 FOR LEGEND

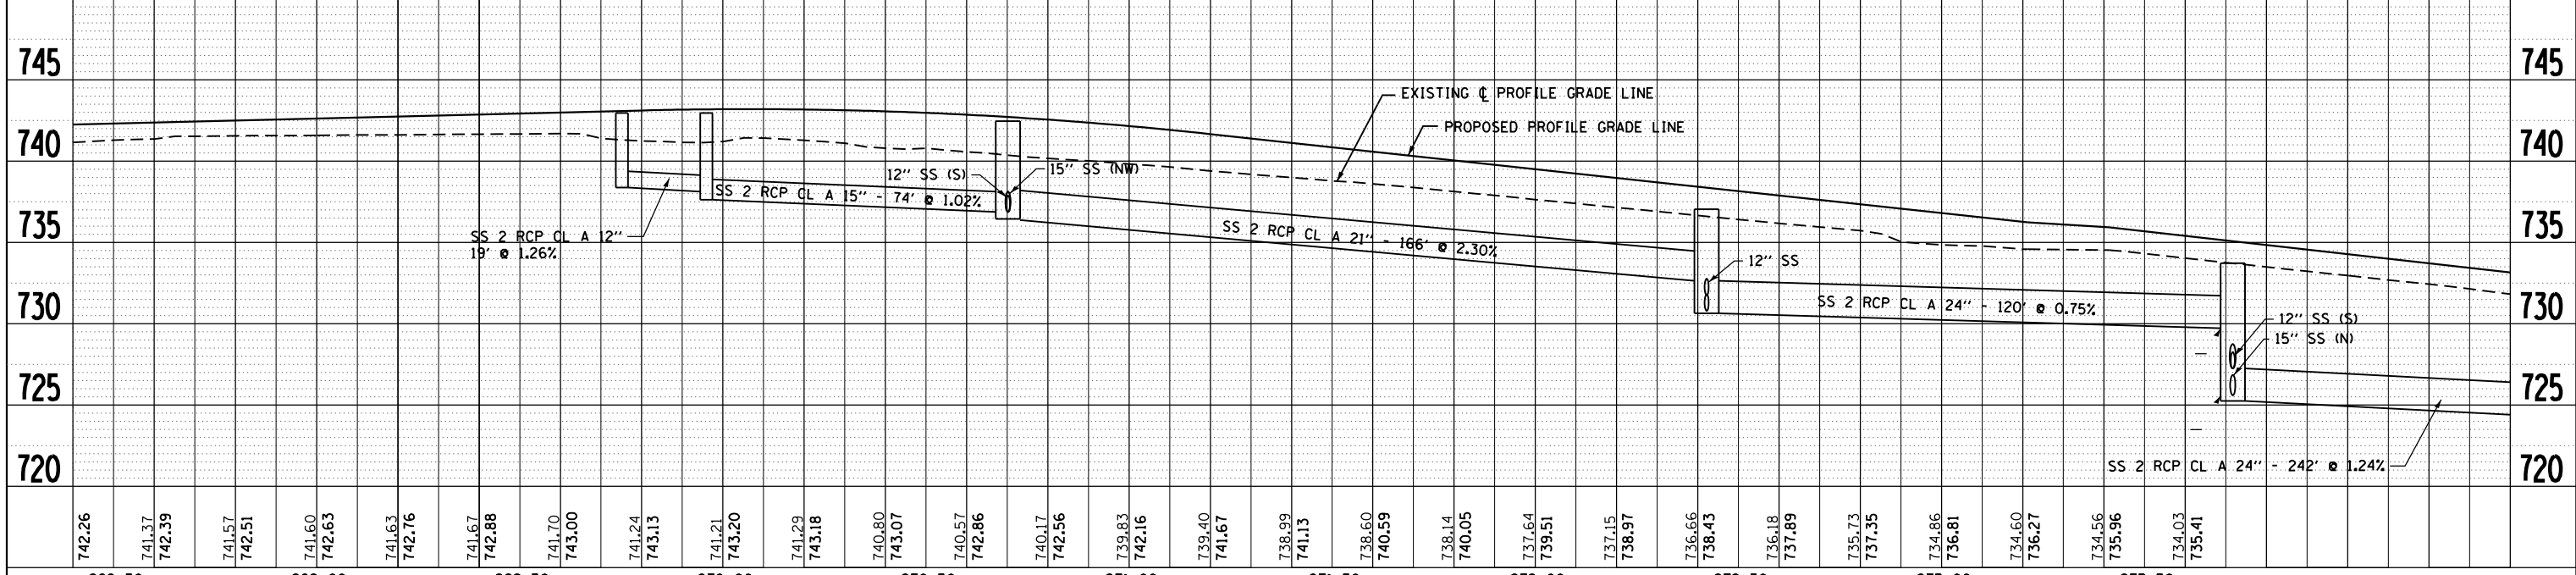

FILE NAME =	USER NAME = dossed	DESIGNED - EJD	REVISED -	STATE OF ILLINOIS DEPARTMENT OF TRANSPORTATION	PROPOSED DRAINAGE PLAN AND PROFILE WEST STATE ST (US BUS 20)	F.A.P. RTE.	SECTION	COUNTY	TOTAL SHEETS	SHEET NO.	
c:\pwork\pwork\dossed\0317619\0264750	shd-drain-150.dgn	DRAWN - EJD	REVISED -			303	41R	WINNEBAGO	327	150	
		CHECKED - RCH	REVISED -			SCALE:		SHEET NO. 6 OF 21 SHEETS		STA.	TO STA.
		PLOT DATE = Mon Dec 17 14:51:37 2012	DATE - \$SUBDATE\$			REVISED -	CONTRACT NO. 64750		FED. ROAD DIST. NO. 2 ILLINOIS FED. AID PROJECT		