



PLAN	SURVEYED	BY	DATE
	PLOTTED		
	NOTE BOOK		
	NO.		
	ALIGNED		
	CHECKED		
	FILE NAME		

PROFILE	SURVEYED	BY	DATE
	PLOTTED		
	NOTE BOOK		
	NO.		
	GRADES CHECKED		
	STRUCTURE		
	NOTATIONS		
	CPAD		

McDonough Associates Inc.
Engineers / Architects
130 East Randolph Street Chicago, Illinois 60601

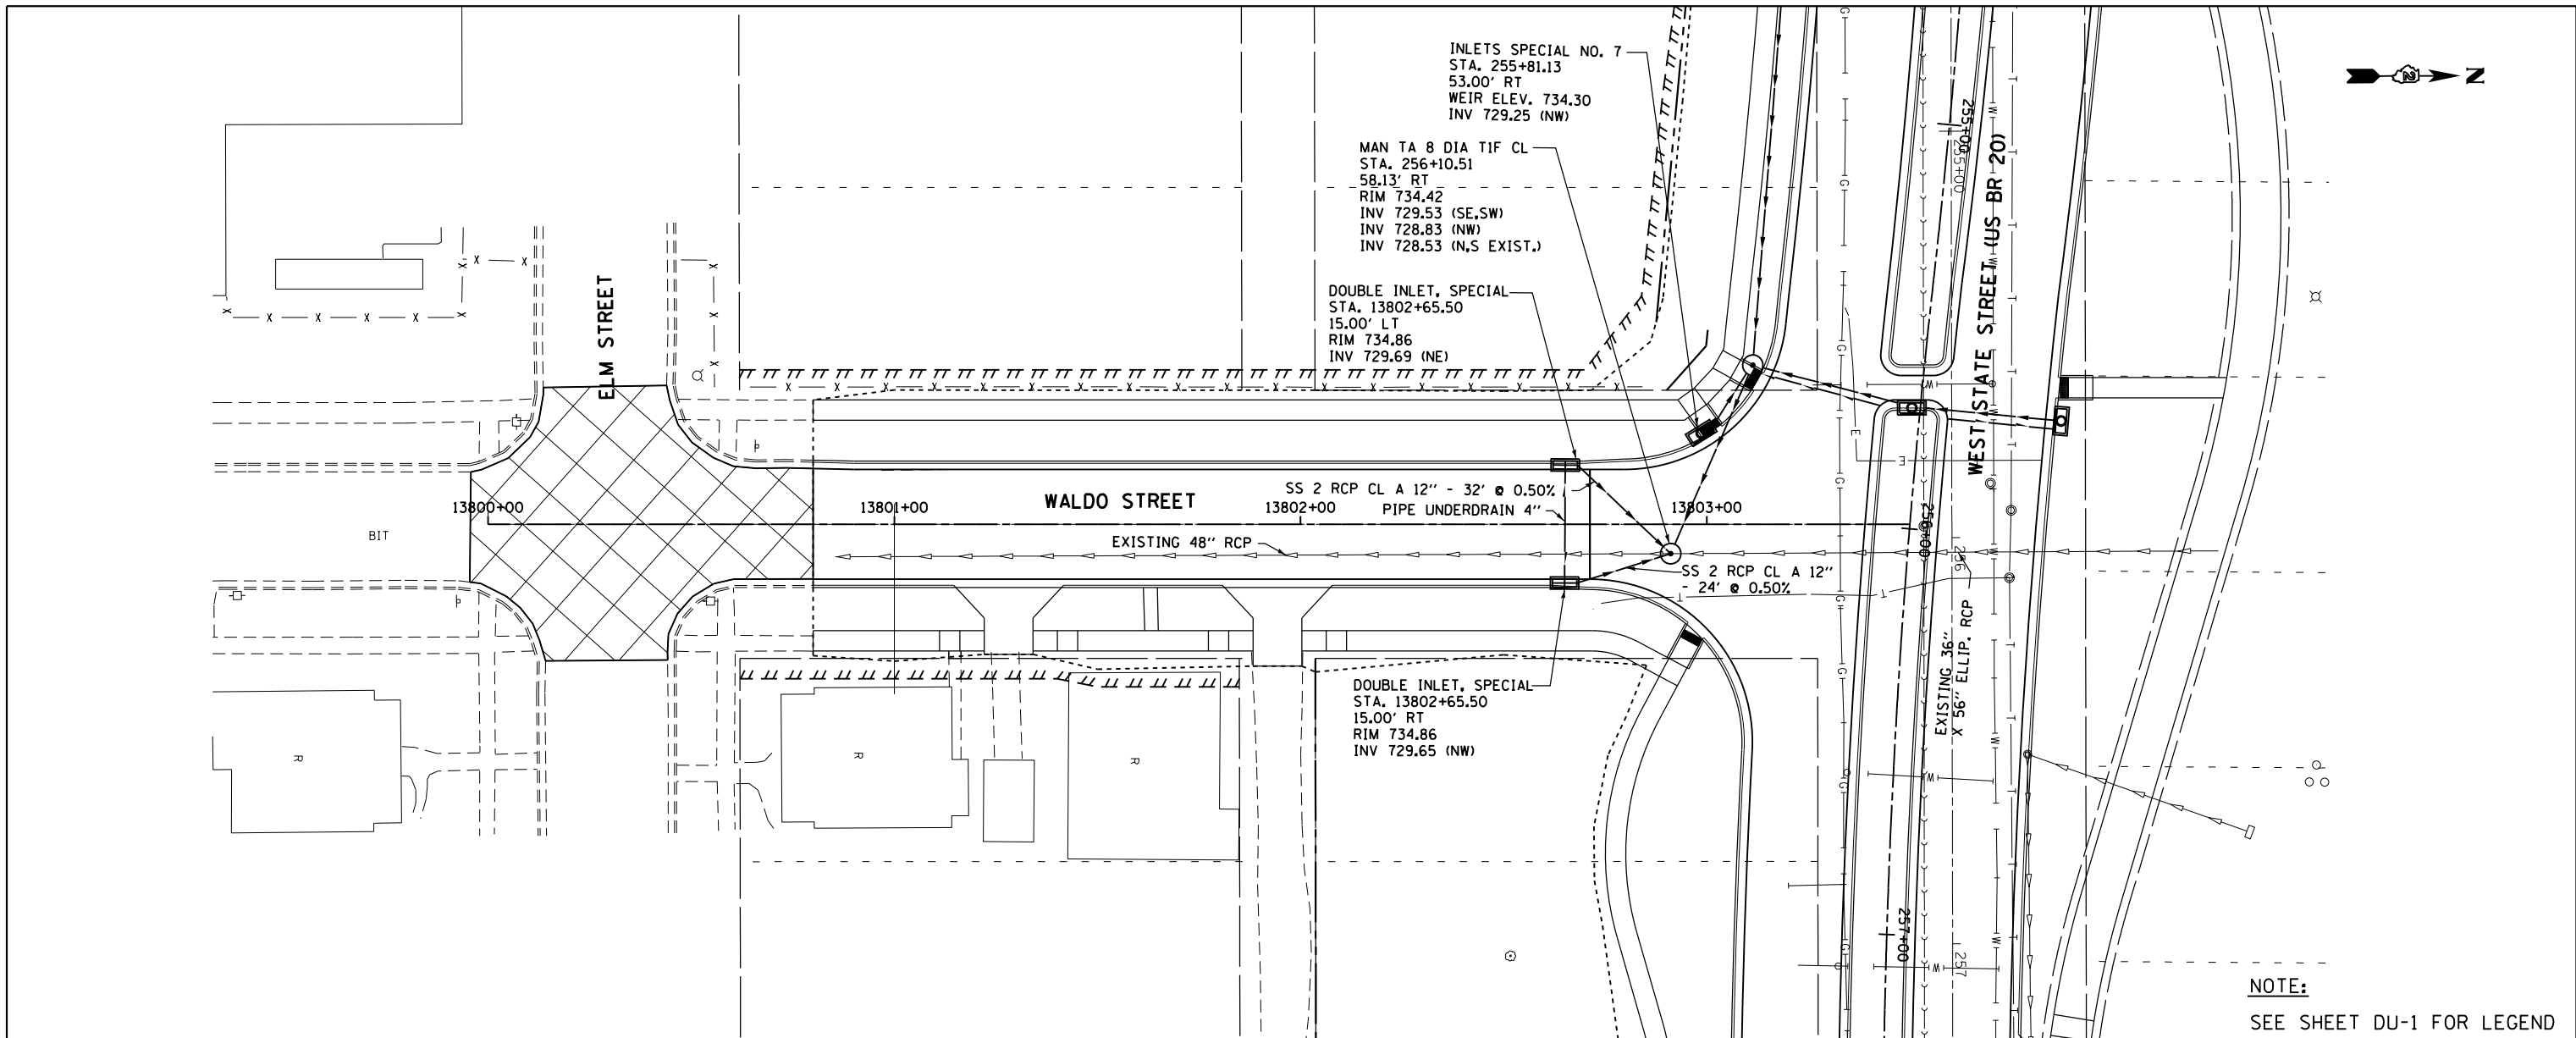

NOTE:
SEE SHEET DU-1 FOR LEGEND

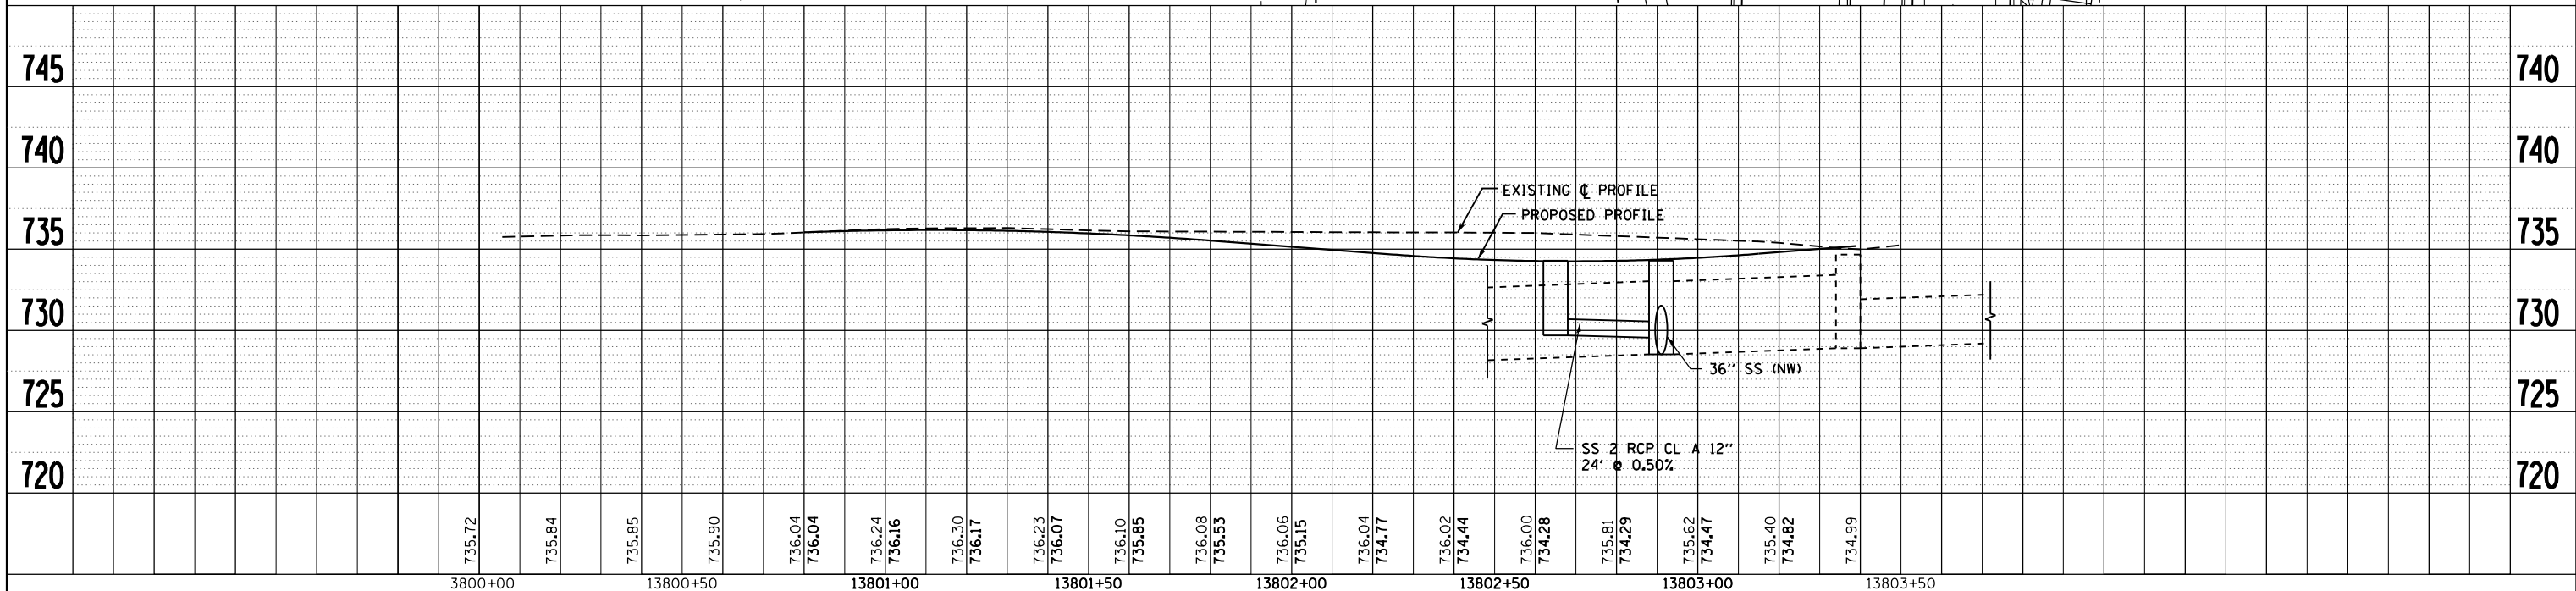

FILE NAME =	USER NAME = dssdd	DESIGNED - EJD	REVISED -	STATE OF ILLINOIS DEPARTMENT OF TRANSPORTATION	PROPOSED DRAINAGE PLAN AND PROFILE WALDO STREET		F.A.P. RTE. 303	SECTION 41R	COUNTY WINNEBAGO	TOTAL SHEETS 327	SHEET NO. 156
c:\pwork\pwork\dssdd\0317619\0264750	sh-t-drain-156.dgn	DRAWN - EJD	REVISED -		SCALE:	SHEET NO. 12 OF 21 SHEETS	STA. TO STA.	FED. ROAD DIST. NO. 2 ILLINOIS FED. AID PROJECT		CONTRACT NO. 64750	
		CHECKED - RCH	REVISED -								
		DATE - *SUBDATE*	REVISED -								