



PLAN	SURVEYED	BY	DATE
	PLOTTED		
	NOTE BOOK		
	NO.		
	NO.		
	NO.		

PROFILE	SURVEYED	BY	DATE
	PLOTTED		
	GRADES CHECKED		
	STRUCTURE		
	NO.		
	NO.		
	NO.		

McDonough Associates Inc.
 Engineers / Architects
 130 East Randolph Street Chicago, Illinois 60601

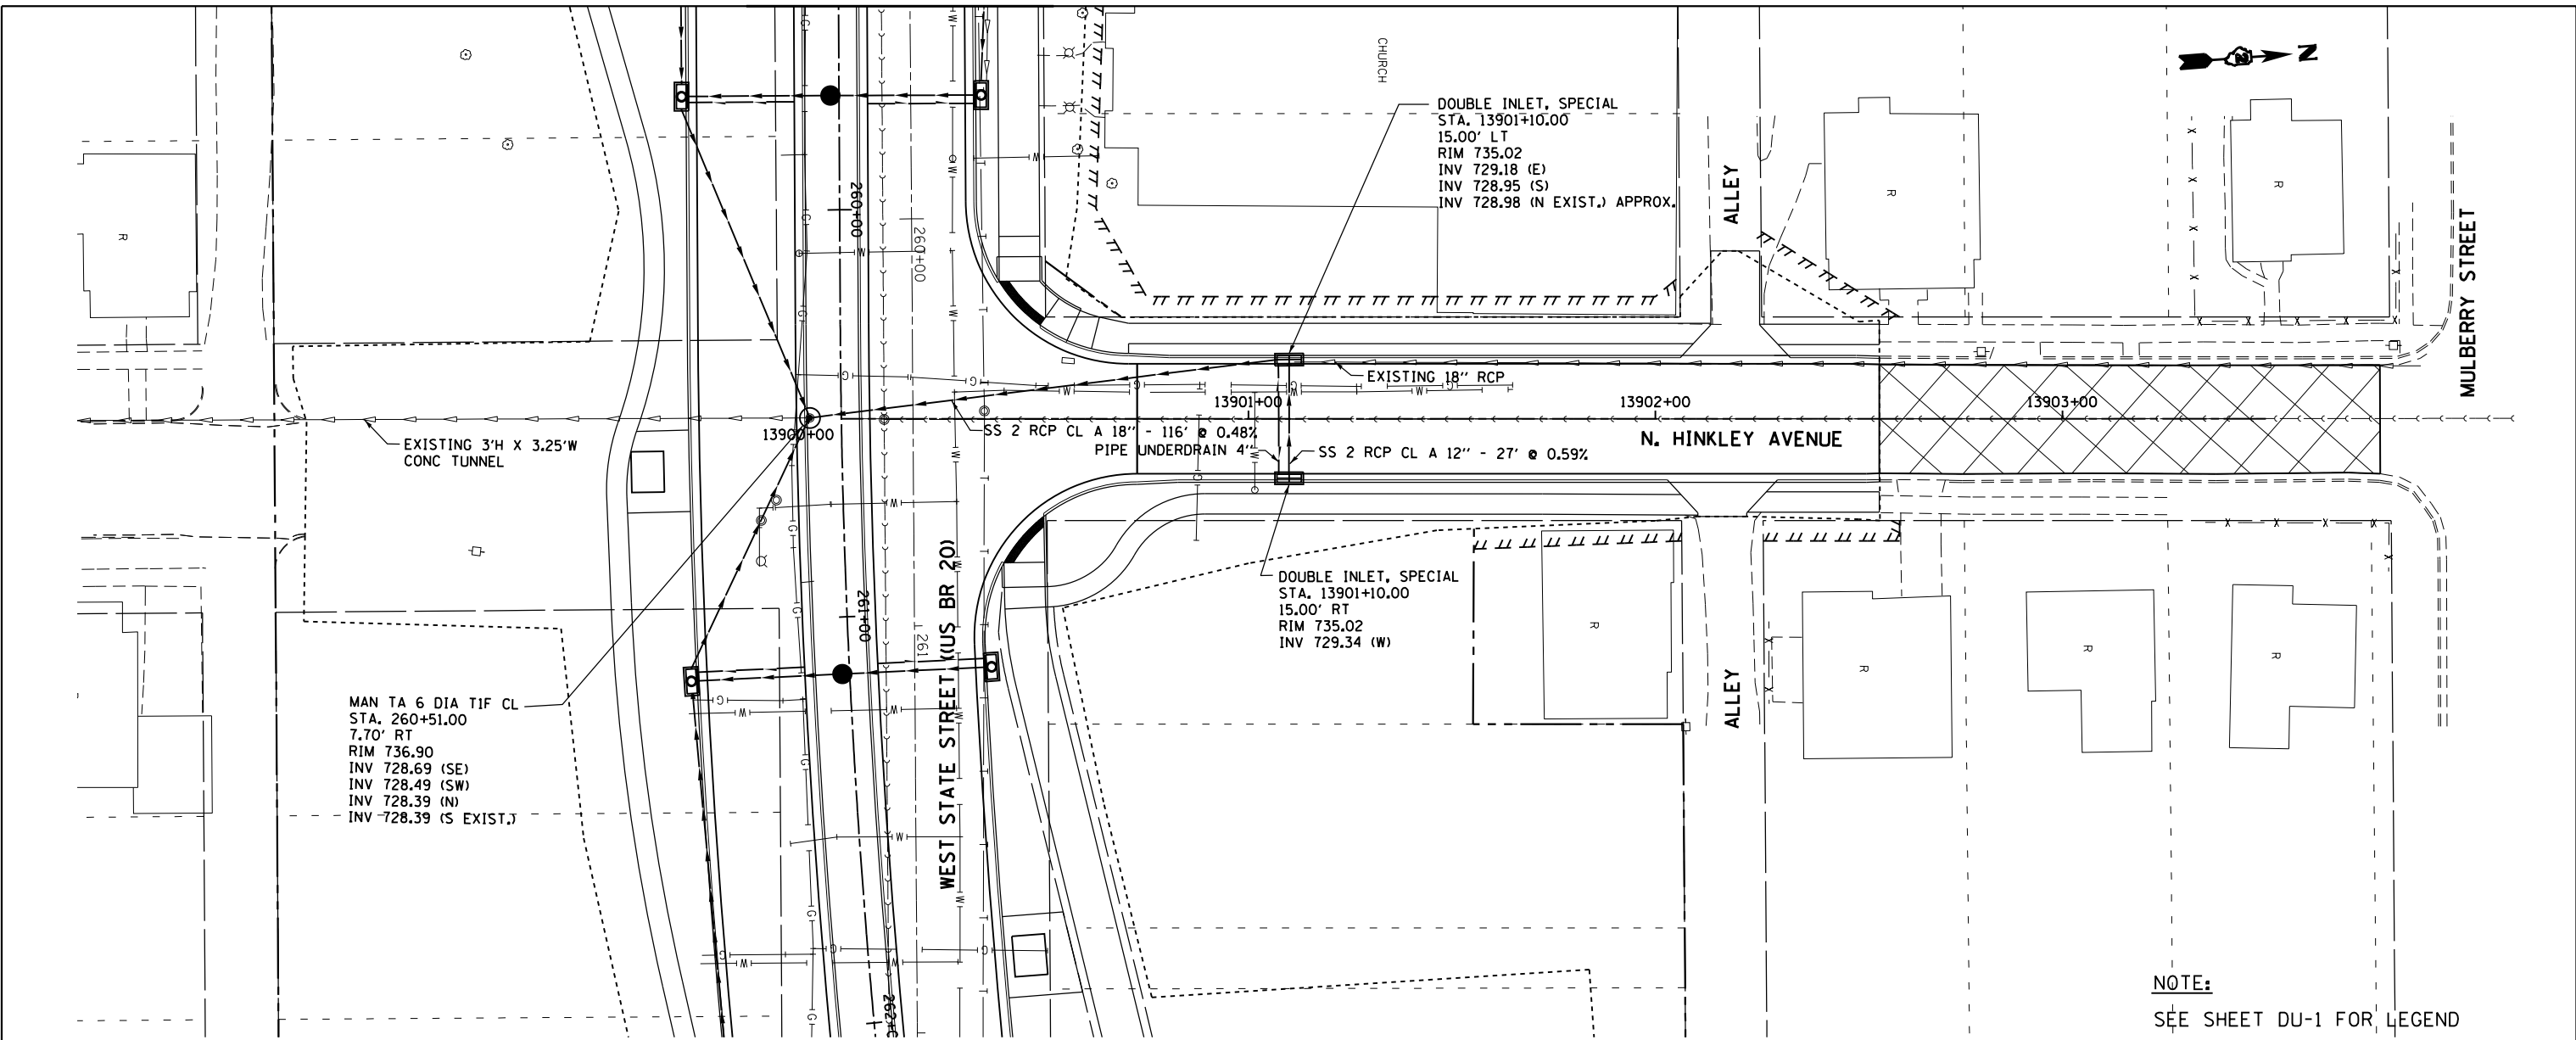

NOTE:
 SEE SHEET DU-1 FOR LEGEND

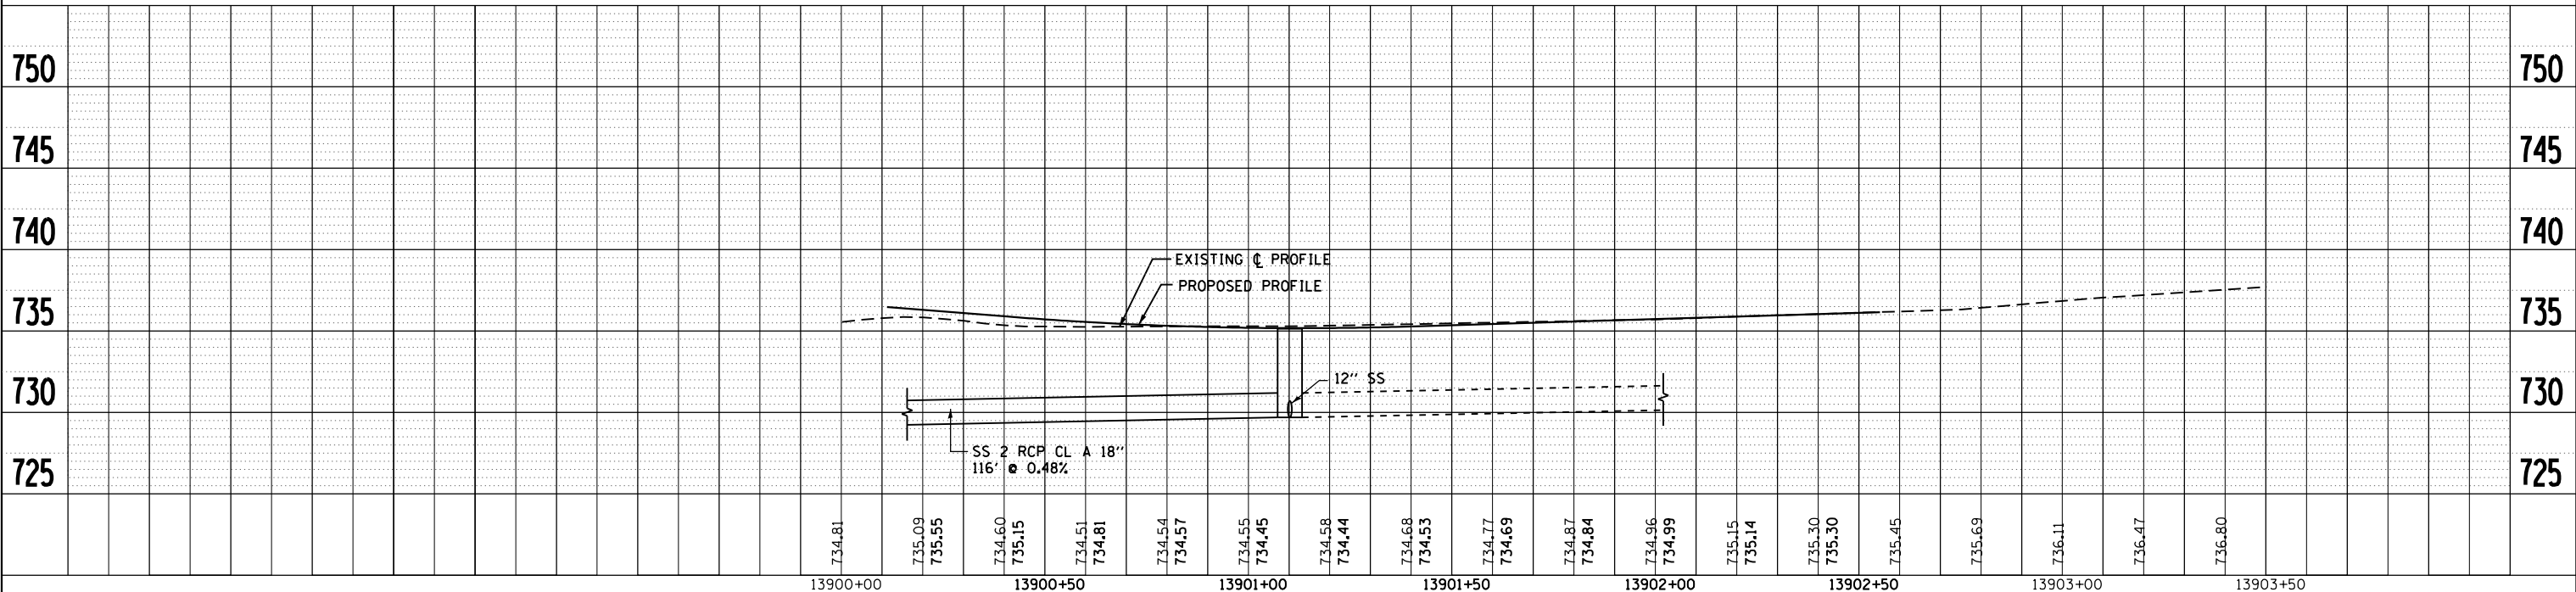

FILE NAME =	USER NAME =	DESIGNED -	REVISED -	STATE OF ILLINOIS DEPARTMENT OF TRANSPORTATION	PROPOSED DRAINAGE PLAN AND PROFILE HINKLEY STREET		F.A.P. RTE.	SECTION	COUNTY	TOTAL SHEETS	SHEET NO.
c:\pwork\pwork\dot\dosdd\0317619\0264750	sh-t-drain-157.dgn	DRAWN -	REVISED -		303	41R	WINNEBAGO	327	157	CONTRACT NO. 64750	
		CHECKED -	REVISED -		SCALE:	SHEET NO. 13 OF 21 SHEETS	STA.	TO STA.		FED. ROAD DIST. NO. 2 ILLINOIS FED. AID PROJECT	
		DATE -	REVISED -								