


NOTE:
SEE SHEET DU-1 FOR LEGEND

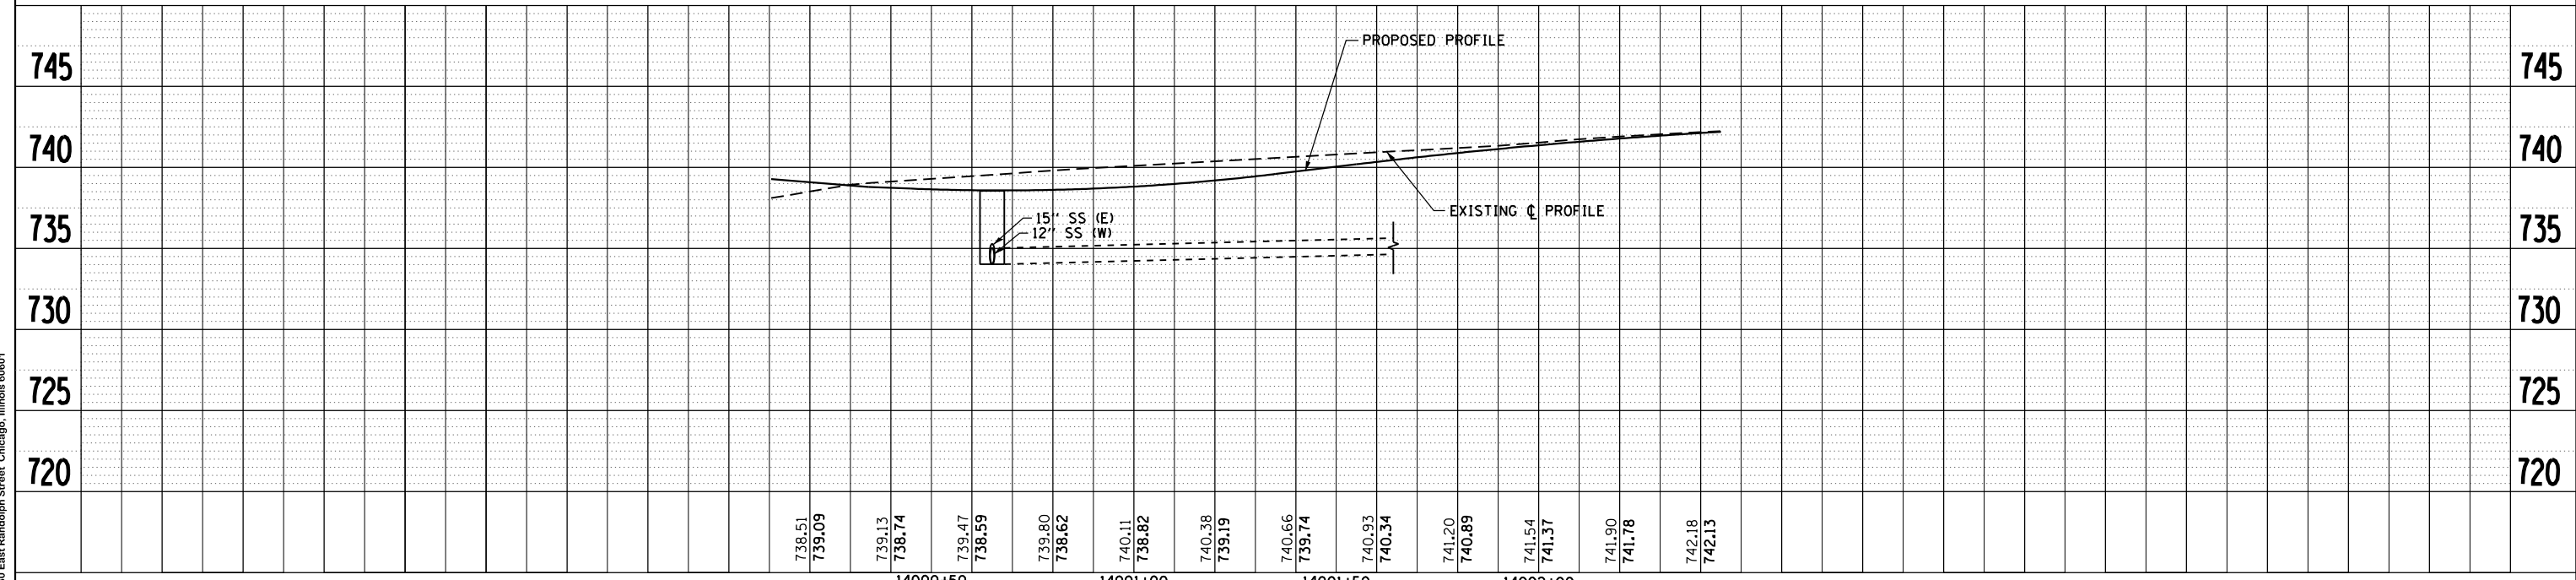

PLAN	SURVEYED	DATE
	PLOTTED	
	ALIGNED	
	CHECKED	
	FILED	
	NO.	

PROFILE	SURVEYED	DATE
	PLOTTED	
	GRADES CHECKED	
	STRUCTURE NOTATIONS CHECKED	
	NO.	

McDonough Associates Inc.
Engineers / Architects
130 East Randolph Street Chicago, Illinois 60601

FILE NAME = c:\pwork\pwork\dot\dossdd\0317619\0264750	USER NAME = dossdd	DESIGNED - EJD	REVISED -	STATE OF ILLINOIS DEPARTMENT OF TRANSPORTATION	PROPOSED DRAINAGE PLAN AND PROFILE FOREST AVENUE	F.A.P. RTE. 303	SECTION 41R	COUNTY WINNEBAGO	TOTAL SHEETS 327	SHEET NO. 158	
PLOT SCALE = 40.0000' / in.	CHECKED - RCH	REVISED -	SCALE:			SHEET NO. 14 OF 21 SHEETS	STA. TO STA.	CONTRACT NO. 64750		FED. ROAD DIST. NO. 2	ILLINOIS FED. AID PROJECT
PLOT DATE = Mon Dec 17 15:33:07 2012	DATE - \$SUBDATE\$	REVISED -									