

CONSTRUCTION PLANS - ISSUED JANUARY 11, 2019

EAST AIRCRAFT PARKING RAMP EXPANSION & REHABILITATE PARTIAL PARALLEL TAXIWAY TO RUNWAY 9/27

**BOARD OF EDGAR COUNTY
EDGAR COUNTY AIRPORT (PRG)
PARIS, EDGAR COUNTY, ILLINOIS**

**IDA PROJECT NO. PRG-4558
SBG PROJECT NO. 3-17-SBGP-139/144**


SCOPE OF WORK:

THIS PROJECT CONSISTS OF EXPANSION OF THE AIRCRAFT APRON PAVEMENT TO THE EAST, AND A REHABILITATION OF THE EXISTING PARALLEL TAXIWAY PAVEMENT. THE EXPANSION WILL INVOLVE EARTHWORK GRADING, CONSTRUCTION OF A BITUMINOUS PAVEMENT SECTION AND EROSION CONTROL ITEMS. THE REHABILITATION WILL INVOLVE PAVEMENT MILLING, CRACK REPAIRS, BITUMINOUS OVERLAY, PAVEMENT MARKINGS, GUIDANCE SIGN REPLACEMENT AND MINOR ITEMS.


NOTICE TO CONTRACTORS AND BIDDERS

THESE CONSTRUCTION PLANS RELY UPON THE SPECIAL PROVISIONS AND THE SPECIFICATIONS TO PROVIDE FOR A COMPLETE DESCRIPTION OF THE WORK AND CONSTRUCTION REQUIREMENTS. THE PLANS SHALL ONLY BE USED IN COMBINATION WITH ALL CONTRACT DOCUMENTS.

VICINITY MAP

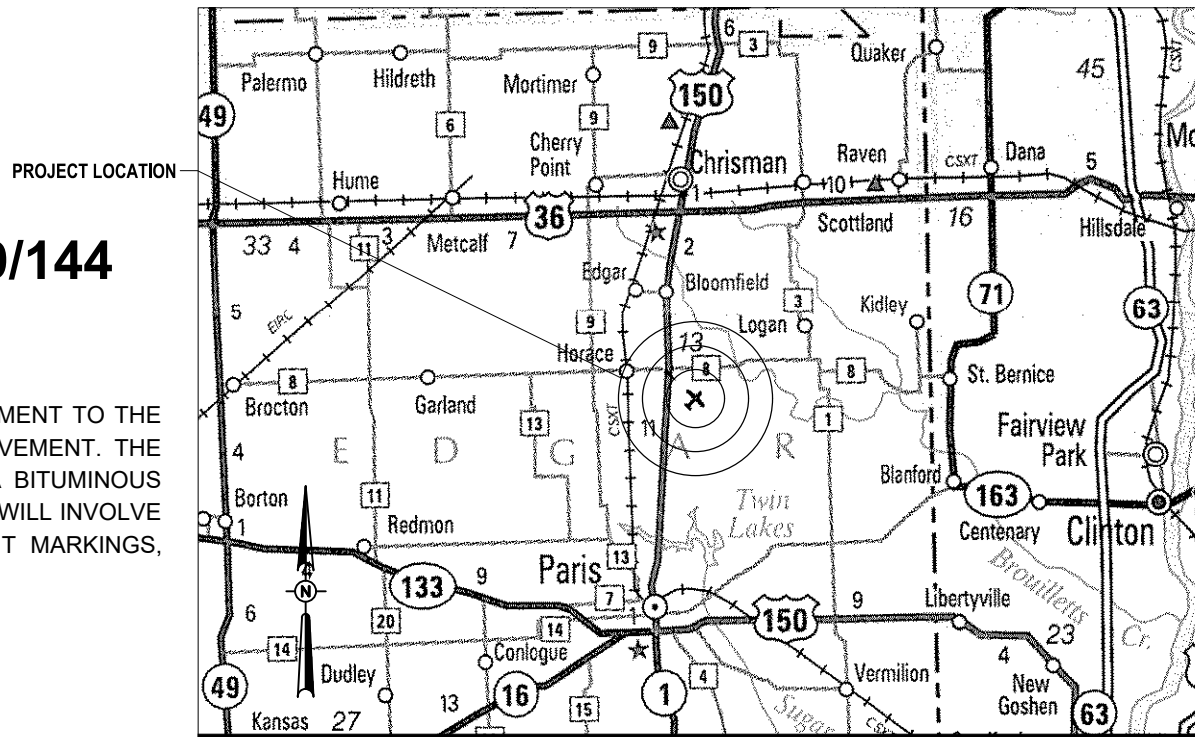

LOCATION MAP

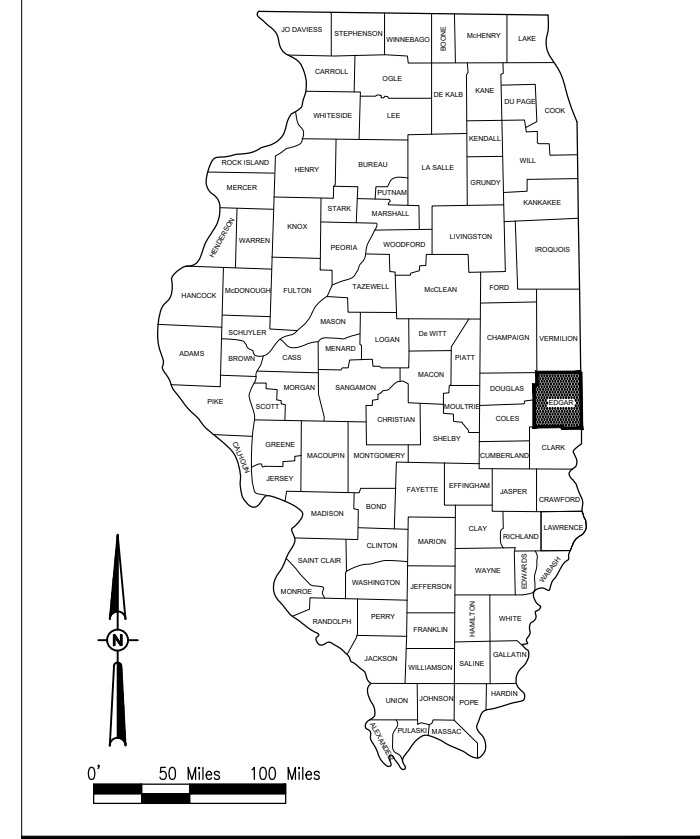

No.	Issue/Description	Sheets Changed	Date	By

COVERING ELECTRICAL DESIGN

Kevin N. Lightfoot
Kevin N. Lightfoot, P.E.
Electrical Engineer

KEVIN N. LIGHTFOOT
062-047643
LICENSED PROFESSIONAL ENGINEER
STATE OF ILLINOIS

EXPIRES 11-30-2019
1-7-2019

Date

HANSON
HANSON PROFESSIONAL SERVICES INC.
1525 S 6th St.
Springfield, Illinois 62703
Telephone: 217-788-2450
Fax: 217-788-2503


Barry S. Stolz
Barry S. Stolz, P.E.
Project Manager/Civil Engineer

EXP 11-30-19
STATE OF ILLINOIS
BARRY S. STOLZ
062-057281
LICENSED PROFESSIONAL ENGINEER

1/11/19 Date

Edgar County Airport
Board of Edgar County
15551 Airport Rd.
Paris, IL 61944-8474
Telephone: 217.465.4151

Dan Long
Date 01/09/19

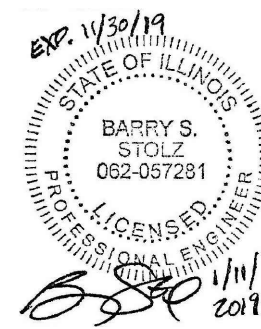

EAST AIRCRAFT
PARKING RAMP
EXPANSION &
REHABILITATE PARTIAL
PARALLEL TAXIWAY TO
RUNWAY 9/27

IDA No: PRG-4558

Contract No. ED019

NO.	DATE	DESCRIPTION		
		LAY	DWN	REV

ISSUE: JANUARY 11, 2019
PROJECT NO: 17A0016D
CAD FILE: G-002-FLP.DWG
LAYOUT BY: JRH 11/21/2018
DRAWN BY: JRH 11/21/2018
REVIEWED BY: BSS 01/11/2019

SHEET TITLE

SUMMARY OF
QUANTITIES AND
INDEX TO SHEETS

SUMMARY OF QUANTITIES				
ITEM NO.	DESCRIPTION	TOTAL QUANTITY	UNIT	AS-BUILT QUANTITY
AR108158	1/C #8 5 KV UG CABLE IN UD	500	L.F.	
AR125445	TAXI GUIDANCE SIGN, 5 CHARACTER	1	EA.	
AR125446	TAXI GUIDANCE SIGN, 6 CHARACTER	1	EA.	
AR125904	REMOVE TAXI GUIDANCE SIGN	2	EA.	
AR150510	ENGINEER'S FIELD OFFICE	1	L.S.	
AR150520	MOBILIZATION	1	L.S.	
AR150540	HAUL ROUTE	1	L.S.	
AR152410	UNCLASSIFIED EXCAVATION	218	C.Y.	
AR155540	BY-PRODUCT LIME	47	TON	
AR155616	SOIL PROCESSING-16"	1,284	S.Y.	
AR156510	SILT FENCE	302	L.F.	
AR156530	TEMPORARY SEEDING	0.13	ACRE	
AR201661	CLEAN & SEAL BITUMINOUS CRACKS	2,000	L.F.	
AR209510	CRUSHED AGGREGATE BASE COURSE	519	TON	
AR401613	BIT, SURF. CSE.-METHOD I, SUPERPAVE	1,590	TON	
AR401900	REMOVE BITUMINOUS PAVEMENT	41	S.Y.	
AR401901	REMOVE BITUMINOUS SURFACE COURSE	6,288	S.Y.	
AR403613	BIT. BASE CSE.-METHOD I, SUPERPAVE	216	TON	
AR602510	BITUMINOUS PRIME COAT	439	GAL.	
AR603510	BITUMINOUS TACK COAT	2,074	GAL.	
AR620520	PAVEMENT MARKING-WATERBORNE	2,022	S.F.	
AR620525	PAVEMENT MARKING-BLACK BORDER	2,318	S.F.	
AR620900	PAVEMENT MARKING REMOVAL	320	S.F.	
AR901510	SEEDING	0.13	ACRE	
AR908510	MULCHING	0.13	ACRE	

EARTHWORK QUANTITY SUMMARY				
WORK AREA	CUT (CY)	FILL (CY)	FILL + 20% (CY)	NET (CY)
EAST APRON	177	182	218	41 (BORROW)
TOTAL	177	182	218**	41 (BORROW)

** USED TO CALCULATE AR152410 PAY ITEM QUANTITY

NOTES:

- EARTHWORK QUANTITIES (CUT/FILL VOLUMES) SHOWN ABOVE WERE CALCULATED UTILIZING AUTODESK CIVIL3D 2018 SOFTWARE THROUGH AUTOCAD. THE CALCULATION METHOD WAS BY A COMPARISON OF SURFACE MODELS CREATED WITH EXISTING SURVEY DATA AND PROPOSED DESIGN GRADES. THE VOLUMES WERE CALCULATED IN TWO PARTS: THE CUT/FILL VOLUME REQUIRED TO CORE OUT AND FILL FOR THE PROPOSED PAVEMENT SECTION AS COMPARED TO THE EXISTING SUBGRADE DATUM, AND THE CUT/FILL VOLUMES REQUIRED FOR PROPOSED GRADING WORK OUTSIDE OF THE PROPOSED PAVEMENT LIMITS AS COMPARED TO THE EXISTING GROUND SURFACE. THE NUMBERS IN THE SUMMARY TABLES ABOVE REPRESENT A TOTAL OF THESE TWO PARTS ADDED TOGETHER FOR CLARITY.

INDEX TO SHEETS	
SHEET NUMBER	SHEET TITLE
1	COVER SHEET
2	SUMMARY OF QUANTITIES AND INDEX TO SHEETS
3	SCOPE OF WORK
4	PROPOSED SAFETY PLAN - WORK AREA 1
5	PROPOSED SAFETY PLAN - WORK AREA 2
6	PROPOSED SAFETY PLAN - WORK AREA 3
7	CONSTRUCTION SAFETY DETAILS AND NOTES
8	PROPOSED TYPICAL SECTIONS
9	PROPOSED CONSTRUCTION PLAN - EAST APRON
10	PROPOSED CONSTRUCTION PLAN - PARALLEL TAXIWAY
11	PROPOSED STAKING & SWPP PLAN - EAST APRON
12	PROPOSED PLAN AND PROFILE - PARALLEL TAXIWAY (WEST)
13	PROPOSED PLAN AND PROFILE - PARALLEL TAXIWAY (EAST)
14	PROPOSED MARKING PLAN
15	PROPOSED ELECTRICAL PLAN
16	AIRFIELD LIGHTING NOTES
17	TAXIWAY LIGHT DETAILS (FOR REFERENCE)
18	TAXI GUIDANCE SIGN DETAILS
19	AIRFIELD LIGHTING CABLE SPLICE DETAILS
20	CONDUIT TRENCH DETAILS
21	ELECTRICAL NOTES SHEET 1
22	ELECTRICAL NOTES SHEET 2
23	GROUNDING DETAILS
24	GROUNDING NOTES
25	GROUND RESISTANCE TESTING DETAILS
26	ELECTRICAL LEGEND AND ABBREVIATIONS
27	EXISTING ELECTRICAL ONE-LINE DIAGRAM - VAULT & AIRFIELD
28	EXISTING ELECTRICAL ONE-LINE DIAGRAM - VAULT & AIRFIELD (CONT.)
29	HIGH VOLTAGE WIRING SCHEMATIC
30	CROSS SECTIONS STA. 400+48 TO STA. 405+50 - LINE B
31	CROSS SECTIONS STA. 406+00 TO STA. 412+50 - LINE B
32	CROSS SECTIONS STA. 413+00 TO STA. 415+50 - LINE B
33	CROSS SECTIONS STA. 300+00 TO STA. 303+02 - LINE B1
34	CROSS SECTIONS STA. 0+00 TO STA. 1+25 - LINE EA

GENERAL NOTES:

QUANTITIES

PAYMENT WILL BE MADE UNDER THE ITEM NUMBERS, DESCRIPTIONS AND UNITS NOTED IN THE ABOVE TABLE IN ACCORDANCE WITH THE BASIS OF PAYMENT FOR EACH RESPECTIVE WORK ITEM COMPLETED AND ACCEPTED BY THE ENGINEER.

CERTIFIED PAYROLLS

THE RESIDENT ENGINEER/TECHNICIAN CANNOT FORWARD CONSTRUCTION REPORTS TO THE ILLINOIS DIVISION OF AERONAUTICS FOR PROCESSING UNTIL ALL CERTIFIED PAYROLLS FOR THE PERIOD HAVE BEEN RECEIVED.

MATERIAL CERTIFICATIONS

MATERIALS TO BE INCORPORATED INTO THE PROJECT CANNOT BE USED WITHOUT PRIOR APPROVAL. ALL MATERIALS TO BE USED IN THE PROJECT MUST BE SUBMITTED TO THE RESIDENT ENGINEER FOR APPROVAL. USE OF MATERIALS WITHOUT PRIOR APPROVAL AND ULTIMATELY DETERMINED TO BE UNACCEPTABLE BY THE ILLINOIS DIVISION OF AERONAUTICS ARE SUBJECT TO REMOVAL AND/OR NON-PAYMENT.

GENERAL NOTES

1. THE SCOPE OF WORK SHEET IS INTENDED ONLY AS A GENERAL DESCRIPTION OF WORK ITEMS AND THEIR APPROXIMATE LOCATIONS AND LIMITS, FOR THE PURPOSE OF UNDERSTANDING THE SCOPE OF THE PROJECT. THIS SHEET SHALL NOT BE USED AS A CONSTRUCTION PLAN. REFER TO THE FOLLOWING PLAN SHEETS FOR DETAILED CONSTRUCTION REQUIREMENTS, LOCATIONS, AND ITEMS OF WORK.
2. THIS PROJECT CONSISTS OF EXPANSION OF THE AIRCRAFT APRON PAVEMENT TO THE EAST, AND A REHABILITATION OF THE EXISTING PARALLEL TAXIWAY PAVEMENT. THE EXPANSION WILL INVOLVE EARTHWORK GRADING AND CONSTRUCTION OF A BITUMINOUS PAVEMENT SECTION, TIE DOWNS, PAVEMENT MARKINGS AND EROSION CONTROL ITEMS. THE REHABILITATION WILL INVOLVE PAVEMENT MILLING, CRACK REPAIRS, BITUMINOUS OVERLAY, PAVEMENT MARKINGS AND MINOR ITEMS.
3. THE CONTRACTOR SHALL FURNISH ALL LABOR, MATERIAL, EQUIPMENT, AND TRANSPORTATION NECESSARY TO CONSTRUCT ALL ELEMENTS OF THE PROJECT AS DESCRIBED IN THE CONSTRUCTION PLANS AND SPECIFICATIONS.
4. THE RULES, REGULATIONS, AND SPECIFICATIONS ENUMERATED HEREIN SHALL BE CONSIDERED AS MINIMUM REQUIREMENTS. THEY SHALL NOT PROHIBIT THE CONTRACTOR FROM FURNISHING AND INSTALLING HIGHER GRADES OF MATERIAL THAN ARE SPECIFIED HEREIN.
5. THE CONTRACTOR IS NOT PERMITTED TO USE THE AIRPORT AUTO PARKING LOT FOR MATERIAL AND EQUIPMENT STORAGE. THE CONSTRUCTION ENTRANCE AS SHOWN ON THE PROPOSED SAFETY AND PHASING PLAN WILL BE THE PRIMARY ACCESS TO THE PROPOSED CONSTRUCTION SITE. ALL HAULING OF MATERIALS AND EQUIPMENT SHALL BE RESTRICTED TO THE DESIGNATED CONSTRUCTION ENTRANCE.
6. IT SHALL BE THE RESPONSIBILITY OF THE CONTRACTOR TO PROTECT, PRESERVE AND REPAIR THE EXISTING AIRFIELD AND ROADWAY PAVEMENTS AT ALL TIMES. THE CONTRACTOR SHALL REPAIR ANY DAMAGE TO EXISTING ELECTRICAL, DRAINAGE, AND PAVEMENT STRUCTURES AT NO ADDITIONAL COST TO THE CONTRACT. ANY DAMAGE TO FAA CABLES, ACCESS ROADS OR TO FAA FACILITIES DURING CONSTRUCTION WILL REQUIRE THE CONTRACTOR TO REPLACE THE DAMAGED CABLES, ACCESS ROAD OR FAA FACILITIES TO FAA REQUIREMENTS AT THE CONTRACTOR'S EXPENSE. SPLICING OF CABLES IS NOT AN ACCEPTABLE FORM OF REPAIR.
7. NO EQUIPMENT SHALL BE PERMITTED TO CROSS OR USE ANY EXISTING PAVEMENT OUTSIDE THE CONSTRUCTION LIMITS, GENERAL PROJECT AREA OR HAUL ROUTE.
8. CONTRACTOR IS REQUIRED TO PROVIDE THEIR OWN RESTROOM FACILITIES.
9. UNLESS OTHERWISE NOTED, ALL DISTURBED AREAS OUTSIDE OF THE PROPOSED CONSTRUCTION LIMITS SHALL BE GRADED, SEEDED AND/OR HYDROMULCH SEEDED AT NO ADDITIONAL COST TO THE CONTRACT.
10. ALL WASTE MATERIAL SHALL BE HAULED FROM THE AIRPORT AND PROPERLY DISPOSED OF UNLESS OTHERWISE SPECIFIED HEREIN.
11. THE CONTRACTOR SHALL BE RESPONSIBLE FOR OBTAINING PERMITS FOR HAULING ON PUBLIC ROADS, AS APPLICABLE. THE CONTRACTOR SHALL BE RESPONSIBLE FOR CORRECTING ANY DAMAGES TO ANY PAVEMENTS (PUBLIC OR PRIVATE) CAUSED BY HIS/HER CONSTRUCTION EQUIPMENT OR PERSONNEL.
12. THE OWNER SHALL HAVE THE RIGHT OF FIRST REFUSAL FOR ALL SALVAGEABLE MATERIAL REMOVED ON THE PROJECT.
13. THE CONTRACTOR SHALL COORDINATE WITH THE RESIDENT ENGINEER/TECHNICIAN SO THEY MAY DEVELOP ONE SET OF REDLINED AS-BUILT DRAWINGS AT THE COMPLETION OF THE PROJECT.
14. CONTRACTOR SHALL NOTE THAT ALL AREAS WITHIN THE AIRPORT PROPERTY LINE AND OUTSIDE THE CONSTRUCTION LIMITS MAY BE USED FOR AGRICULTURAL PURPOSES. THE CONSTRUCTION LIMITS SHALL BE RESTRICTED TO AREAS THAT ARE ABSOLUTELY NECESSARY TO DISTURB TO COMPLETE THE REQUIRED WORK ITEMS. LIMITS SHALL BE COORDINATED WITH THE RESIDENT ENGINEER/TECHNICIAN PRIOR TO BEGINNING ANY WORK. ALL AREAS WHICH HAVE BEEN FARMED AND OR DESIGNATED TO BE FARMED AFTER THE PROJECT COMPLETION, AND HAVE BEEN DISTURBED BY CONSTRUCTION ACTIVITY, SHALL BE CHISEL PLOWED (36" MAX.) OR OTHERWISE SCARIFIED TO RETURN THE AREA TO A REASONABLE TILLABLE CONDITION (IF SO PERMITTED BY THE AIRPORT MANAGER.)
15. CONTRACTOR SHALL RESTORE TO ORIGINAL CONDITION ALL GRASS, STONE, OR PAVEMENT DISTURBED BY CONTRACTOR'S CONSTRUCTION OPERATIONS, STAGING, AND CONSTRUCTION ACCESS ROUTES. DISTURBED AREAS TO BE REPAIRED, GRADED, AND SEEDED AND MULCHED UNLESS OTHERWISE NOTED. STAGING AREA AND SITE ACCESS RESTORATION SHALL BE INCLUDED IN THE COST OF THE HAUL ROUTE.
16. THE PROJECT PAY ITEMS ARE INTENDED TO BE INCLUSIVE OF ALL WORK TO BE PERFORMED AS SHOWN IN THESE PLANS. ALL INCIDENTAL WORK REQUIRED TO COMPLETE THE PROJECT TO THE SATISFACTION OF THE RESIDENT ENGINEER/TECHNICIAN IS TO BE INCLUDED IN THE COSTS OF PERFORMING THESE ITEMS.
17. APPROXIMATE LOCATIONS OF UNDERGROUND UTILITIES ARE SHOWN THROUGHOUT THESE PLANS. THE CONTRACTOR SHALL DETERMINE EXACT LOCATIONS AND PROTECT THESE UTILITIES DURING CONSTRUCTION. ANY UTILITIES DAMAGED DURING CONSTRUCTION SHALL BE REPAIRED AT THE CONTRACTOR'S EXPENSE. CONTRACTOR SHALL COORDINATE WITH THE PROPER PERSONS FOR THE PURPOSE OF LOCATING AND PROTECTING EXISTING UNDERGROUND UTILITIES.
18. THE CONTRACTOR MUST AT ALL TIMES MAINTAIN PROPER DRAINAGE FOR ALL AREAS AFFECTED BY HIS WORK.

UTILITY NOTES

THE LOCATION, SIZE, AND TYPE OF MATERIAL OF EXISTING UNDERGROUND AND/OR ABOVEGROUND UTILITIES INDICATED ON THE PLANS ARE NOT REPRESENTED AS BEING ACCURATE, SUFFICIENT OR COMPLETE. NEITHER THE OWNER NOR THE ENGINEER ASSUMES ANY RESPONSIBILITY WHATSOEVER IN RESPECT TO THE ACCURACY, COMPLETENESS, OR SUFFICIENCY OF THE INFORMATION. THERE IS NO GUARANTEE, EITHER EXPRESSED OR IMPLIED, THAT THE LOCATIONS, SIZE AND TYPE OF MATERIAL OF EXISTING UNDERGROUND UTILITIES INDICATED ARE REPRESENTATIVE OF THOSE TO BE ENCOUNTERED IN THE CONSTRUCTION. IT SHALL BE THE CONTRACTOR'S RESPONSIBILITY TO DETERMINE THE ACTUAL LOCATION OF ALL SUCH FACILITIES, INCLUDING SERVICE CONNECTIONS TO UNDERGROUND UTILITIES.

PRIOR TO CONSTRUCTION, THE CONTRACTOR SHALL NOTIFY THE UTILITY COMPANIES OF ITS OPERATIONAL PLANS AND SHALL OBTAIN FROM THE RESPECTIVE UTILITY COMPANIES DETAILED INFORMATION AND ASSISTANCE RELATIVE TO THE LOCATION OF THEIR FACILITIES AND THE WORKING SCHEDULE OF THE COMPANIES FOR REMOVAL OR ADJUSTMENT WHERE REQUIRED. IN THE EVENT AN UNEXPECTED UTILITY INTERFERENCE IS ENCOUNTERED DURING CONSTRUCTION, THE CONTRACTOR SHALL IMMEDIATELY NOTIFY THE UTILITY COMPANY OF JURISDICTION. THE OWNER'S REPRESENTATIVE AND THE RESIDENT ENGINEER/TECHNICIAN SHALL ALSO BE IMMEDIATELY NOTIFIED. ANY DAMAGE TO SUCH MAINS AND SERVICES SHALL BE RESTORED TO SERVICE AT ONCE AND PAID FOR BY THE CONTRACTOR AT NO ADDITIONAL COST TO THE CONTRACT. ALL UTILITY CABLES AND LINES SHALL BE LOCATED BY THE RESPECTIVE UTILITY. CONTACT JULIE (JOINT UTILITY LOCATION INFORMATION FOR EXCAVATORS) FOR UTILITY INFORMATION, PHONE: 1-800-892-0123. CONTACT THE FAA (FEDERAL AVIATION ADMINISTRATION) FOR ASSISTANCE IN LOCATING FAA CABLES AND UTILITIES. LOCATION OF FAA POWER, CONTROL, AND COMMUNICATION CABLES SHALL BE COORDINATED WITH AND LOCATED BY THE FAA. ALSO CONTACT AIRPORT MANAGER AND AIRPORT PERSONNEL FOR ASSISTANCE IN LOCATING UNDERGROUND AIRPORT CABLES AND UTILITIES. ALSO COORDINATE WORK WITH ALL ABOVEGROUND UTILITIES.

J.U.L.I.E. INFORMATION


COUNTY _____ EDGAR
 CITY _____ PARIS
 TOWNSHIP _____ EDGAR
 SECTION NO. _____ 5 & 6
 ADDRESS _____ EDGAR COUNTY AIRPORT
 15551 AIRPORT ROAD
 PARIS, ILLINOIS 61944



SURVEY NOTES


1. ALL COORDINATE VALUES SHOWN IN TABLE ARE BASED ON ILLINOIS STATE PLANE - EAST ZONE NAD-83 (2007).
2. REFER TO IDOT STANDARD SPECIFICATIONS 50-06, CONSTRUCTION LAYOUT STAKES, FOR ADDITIONAL INFORMATION.

CONTROL POINT DATA				
NO.	DESCRIPTION	LATITUDE	LONGITUDE	ELEV.
IP-20	IRON PIN	N039° 41' 58.68"	W087° 40' 33.90"	650.99
IP-28	IRON PIN	N039° 41' 52.65"	W087° 40' 33.21"	655.22
IP-29	IRON PIN	N039° 41' 51.78"	W087° 40' 28.84"	655.96

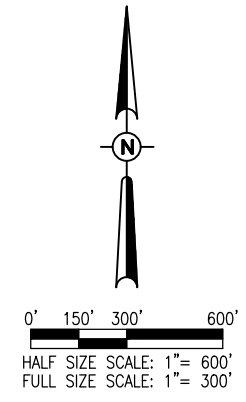

LEGEND

- EXISTING IMPROVEMENTS
- PROPOSED IMPROVEMENTS
- EXISTING BUILDINGS
- PROPOSED STAGING AREA

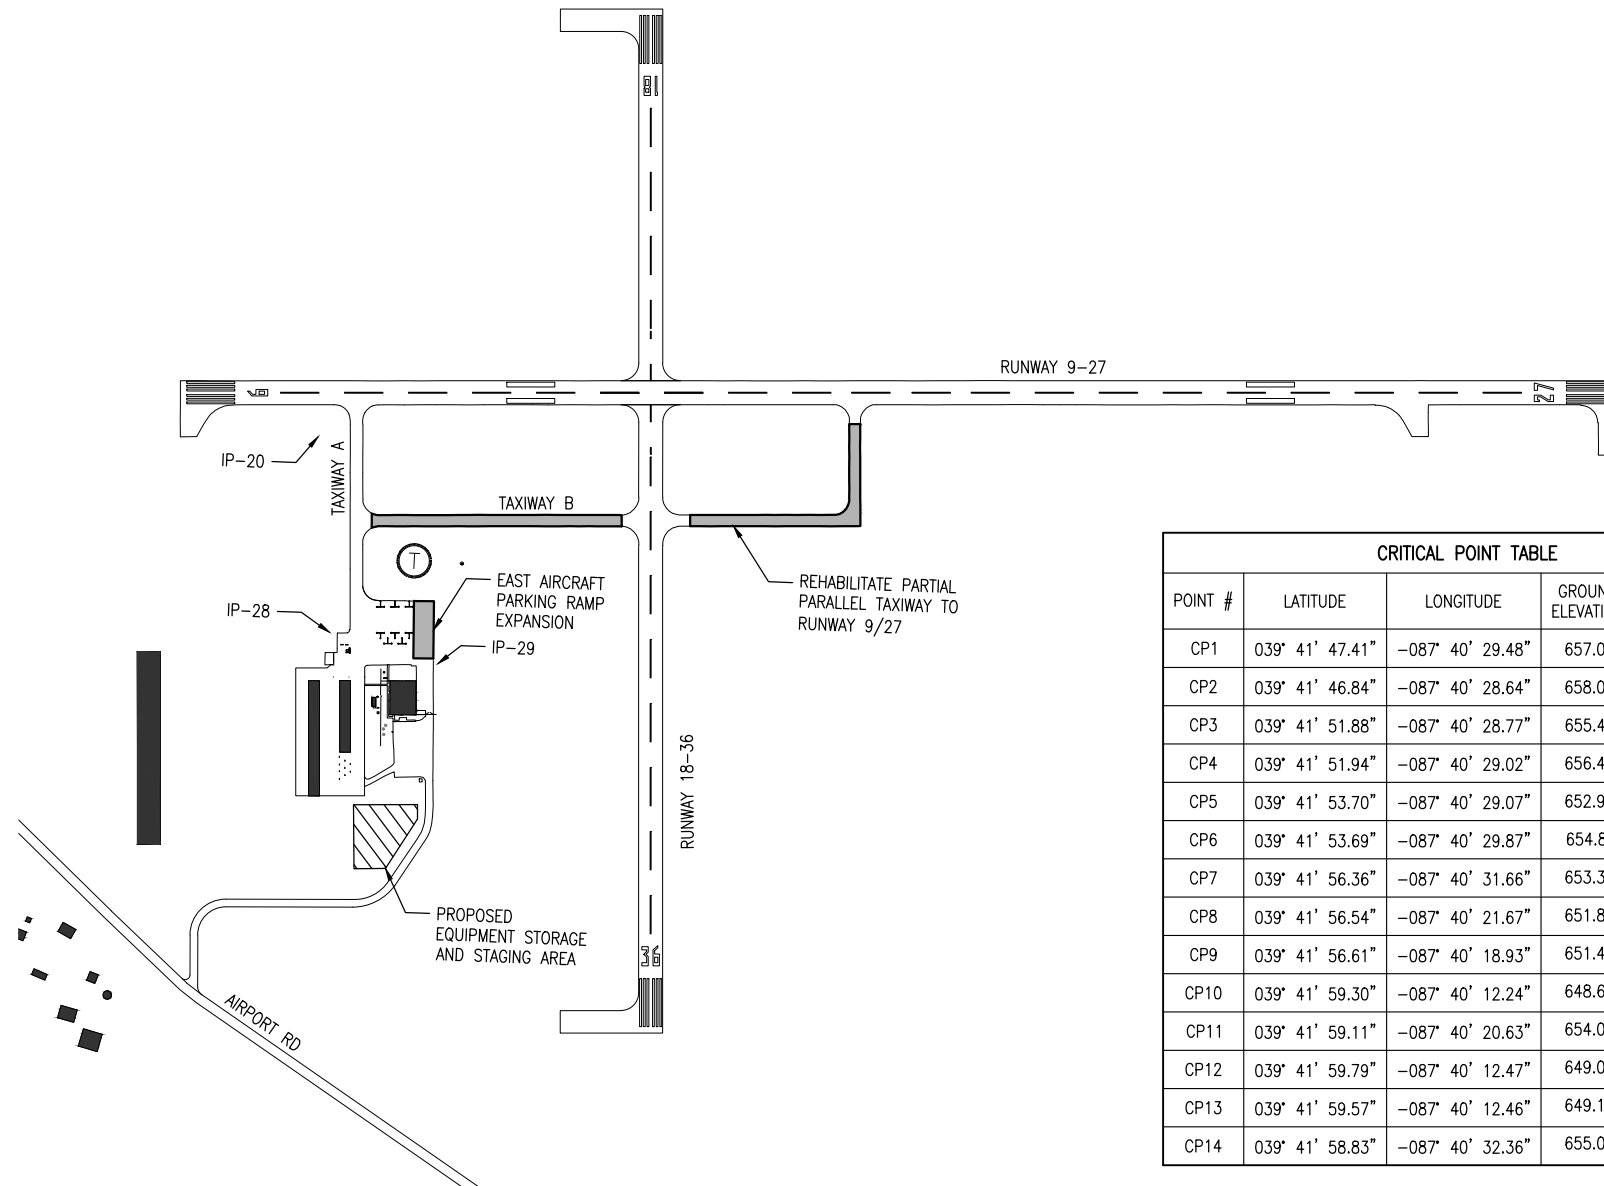

CRITICAL POINT TABLE					
POINT #	LATITUDE	LONGITUDE	GROUND ELEVATION	EQUIP. HEIGHT	EQUIP. ELEV.
CP1	039° 41' 47.41"	-087° 40' 29.48"	657.00	25'	682.00
CP2	039° 41' 46.84"	-087° 40' 28.64"	658.00	25'	683.00
CP3	039° 41' 51.88"	-087° 40' 28.77"	655.49	25'	680.49
CP4	039° 41' 51.94"	-087° 40' 29.02"	656.48	25'	681.48
CP5	039° 41' 53.70"	-087° 40' 29.07"	652.95	25'	677.95
CP6	039° 41' 53.69"	-087° 40' 29.87"	654.81	25'	679.81
CP7	039° 41' 56.36"	-087° 40' 31.66"	653.33	25'	678.33
CP8	039° 41' 56.54"	-087° 40' 21.67"	651.88	25'	676.88
CP9	039° 41' 56.61"	-087° 40' 18.93"	651.42	25'	676.42
CP10	039° 41' 59.30"	-087° 40' 12.24"	648.66	25'	673.66
CP11	039° 41' 59.11"	-087° 40' 20.63"	654.00	2'	656.00
CP12	039° 41' 59.79"	-087° 40' 12.47"	649.00	2'	651.00
CP13	039° 41' 59.57"	-087° 40' 12.46"	649.12	25'	674.12
CP14	039° 41' 58.83"	-087° 40' 32.36"	655.00	2'	657.00




Offices Nationwide
 www.hanson-inc.com

Hanson Professional Services Inc.
 1525 S. 6th Street
 Springfield, IL 62703
 phone: 217-788-2450
 fax: 217-788-2503

Illinois Licensed
 Professional Service Corporation
 #184-001084

Edgar County Airport
 Board of Edgar County
 15551 Airport Rd.
 Paris, IL 61944-8474
 Telephone: 217.465.4151

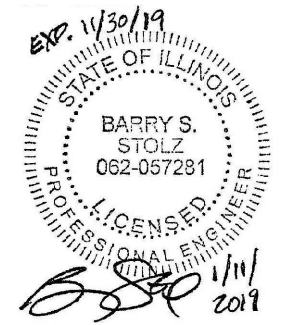

EAST AIRCRAFT PARKING RAMP EXPANSION & REHABILITATE PARTIAL PARALLEL TAXIWAY TO RUNWAY 9/27

IDA No: PRG-4558



Contract No. ED019

NO.	DATE	DESCRIPTION

ISSUE: JANUARY 11, 2019
 PROJECT NO: 17A0016D
 CAD FILE: G-003-SOW.DWG
 LAYOUT BY: JRH 11/27/2018
 DRAWN BY: JRH 11/27/2018
 REVIEWED BY: BSS 01/11/2019

SHEET TITLE

SCOPE OF WORK

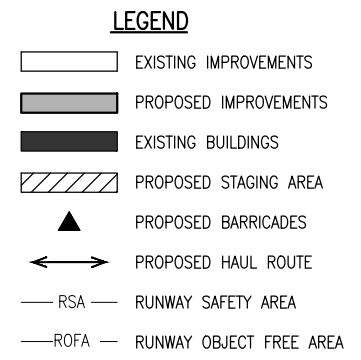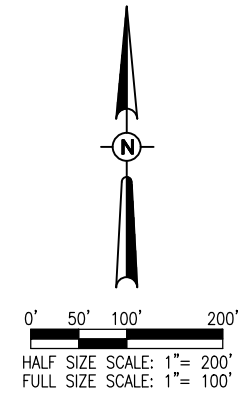


PRG CTAF/UNICOM FREQUENCY = 123.00 MHz

WORK AREA 1 NOTES

1. NO RUNWAY CLOSURES ARE REQUIRED FOR WORK OCCURRING ONLY WITHIN WORK AREA 1.
2. BARRICADES SHALL BE IN PLACE PRIOR TO BEGINNING CONSTRUCTION. CONTRACTOR MAY WORK IN ALL WORK AREAS SIMULTANEOUSLY, HOWEVER THE MAINTENANCE OF TRAFFIC DEVICES AND HAUL ROUTES SHALL REMAIN CONSISTENT WITH THOSE DEPICTED ON THESE SAFETY PLANS.
3. IN THE EVENT THAT OTHER CONSTRUCTION PROJECTS ARE IN PROGRESS AT THE AIRPORT AT THE SAME TIME AS THIS PROJECT, THE CONTRACTOR WILL BE REQUIRED TO COOPERATE WITH ALL OTHER CONTRACTORS AND THE AIRPORT MANAGER IN THE COORDINATION OF THE WORK.
4. AT ALL TIMES, THE CONTRACTOR'S OPERATIONS SHALL BE SUCH AS TO MINIMIZE DISRUPTION TO AIRCRAFT OPERATIONS.
5. ALL AIRCRAFT AND AIRPORT OPERATIONS HAVE THE RIGHT-OF-WAY. CONTRACTOR TO YIELD TO AIRPORT VEHICLES AND REMAIN CLEAR AT ALL TIMES.
6. ALL ACTIVE AIRFIELD PAVEMENTS SHALL BE KEPT CLEAN AND FREE OF DEBRIS AT ALL TIMES DURING CONSTRUCTION.
7. AT THE COMPLETION OF ALL WORK AREA CONSTRUCTION, THE HAUL ROUTE AND CONSTRUCTION EQUIPMENT PARKING AREA SHALL BE RESTORED TO PRE-CONSTRUCTION CONDITIONS PER THE SPECIFICATIONS.
8. WHENEVER CONSTRUCTION ACTIVITY NECESSITATES CLOSURE OF A RUNWAY OR TAXIWAY, THE AIRFIELD LIGHTING ASSOCIATED WITH THE CLOSED PAVEMENT SHALL BE TURNED OFF OR COMPLETELY COVERED, INCLUDING THE EDGE LIGHTS, SIGNAGE AND RUNWAY NAVAIDS. IF NECESSARY, CONTRACTOR SHALL PROVIDE TEMPORARY AIRFIELD LIGHTING CIRCUIT JUMPER CABLES, CONDUIT ENCASED ABOVE GROUND, DURING CONSTRUCTION TO MAINTAIN EXISTING LIGHTING CIRCUITS, UNLESS OTHERWISE APPROVED BY THE AIRPORT MANAGER. CONTRACTOR SHALL COORDINATE CLOSURES WITH THE AIRPORT MANAGER AT LEAST 7 DAYS IN ADVANCE SO NOTAMS CAN BE COORDINATED. IT IS THE RESPONSIBILITY OF THE AIRPORT MANAGER TO ISSUE ALL REQUIRED NOTAMS.
9. THE COSTS FOR PROVISION, PLACEMENT, MAINTENANCE AND REMOVAL OF BARRICADES/CLOSURE CROSSES ON THE AIRFIELD AND ALL ASSOCIATED INCIDENTALS SHALL BE PAID FOR UNDER ITEM AR150520 MOBILIZATION.
10. THE COSTS FOR CONSTRUCTION/MAINTENANCE OF HAUL ROUTE AND EQUIPMENT STAGING AREA AND ALL ASSOCIATED INCIDENTALS SHALL BE PAID FOR UNDER ITEM AR150540 HAUL ROUTE.

SAFETY PLAN COMPLIANCE DOCUMENT

PRIOR TO THE ISSUANCE OF A CONSTRUCTION NOTICE-TO-PROCEED (NTP), THE CONTRACTOR SHALL BE RESPONSIBLE FOR PREPARING AND SUBMITTING A SAFETY PLAN COMPLIANCE DOCUMENT IN ACCORDANCE WITH FAA ADVISORY CIRCULAR 150/5370-2G, PARAGRAPH 2.4.2, OR EQUIVALENT SECTION IN SUBSEQUENT/CURRENT ISSUE. THE AIRPORT DIRECTOR SHALL APPROVE THIS DOCUMENT AND SUBMIT TO THE AIRPORT AUTHORITY FOR APPROVAL PRIOR TO THE NTP ISSUANCE.

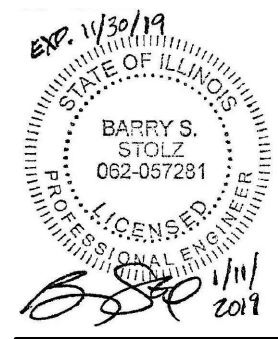

EAST AIRCRAFT PARKING RAMP EXPANSION & REHABILITATE PARTIAL PARALLEL TAXIWAY TO RUNWAY 9/27

IDA No: PRG-4558

Contract No. ED019



NO.	DATE	DESCRIPTION		
		LAY	DWN	REV

ISSUE: JANUARY 11, 2019
PROJECT NO: 17A0016D
CAD FILE: G-004-SFY.DWG
LAYOUT BY: JRH 11/29/2018
DRAWN BY: JRH 11/29/2018
REVIEWED BY: BSS 01/11/2019

SHEET TITLE

PROPOSED SAFETY PLAN - WORK AREA 1

JAN 22, 2019 2:03 PM STOLZ01647 I:\7\JOBS\17A0016D\CAD\AIRPORT\TSHEET\G-004-SFY.DWG

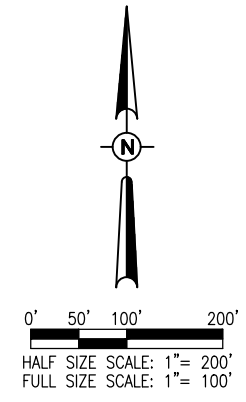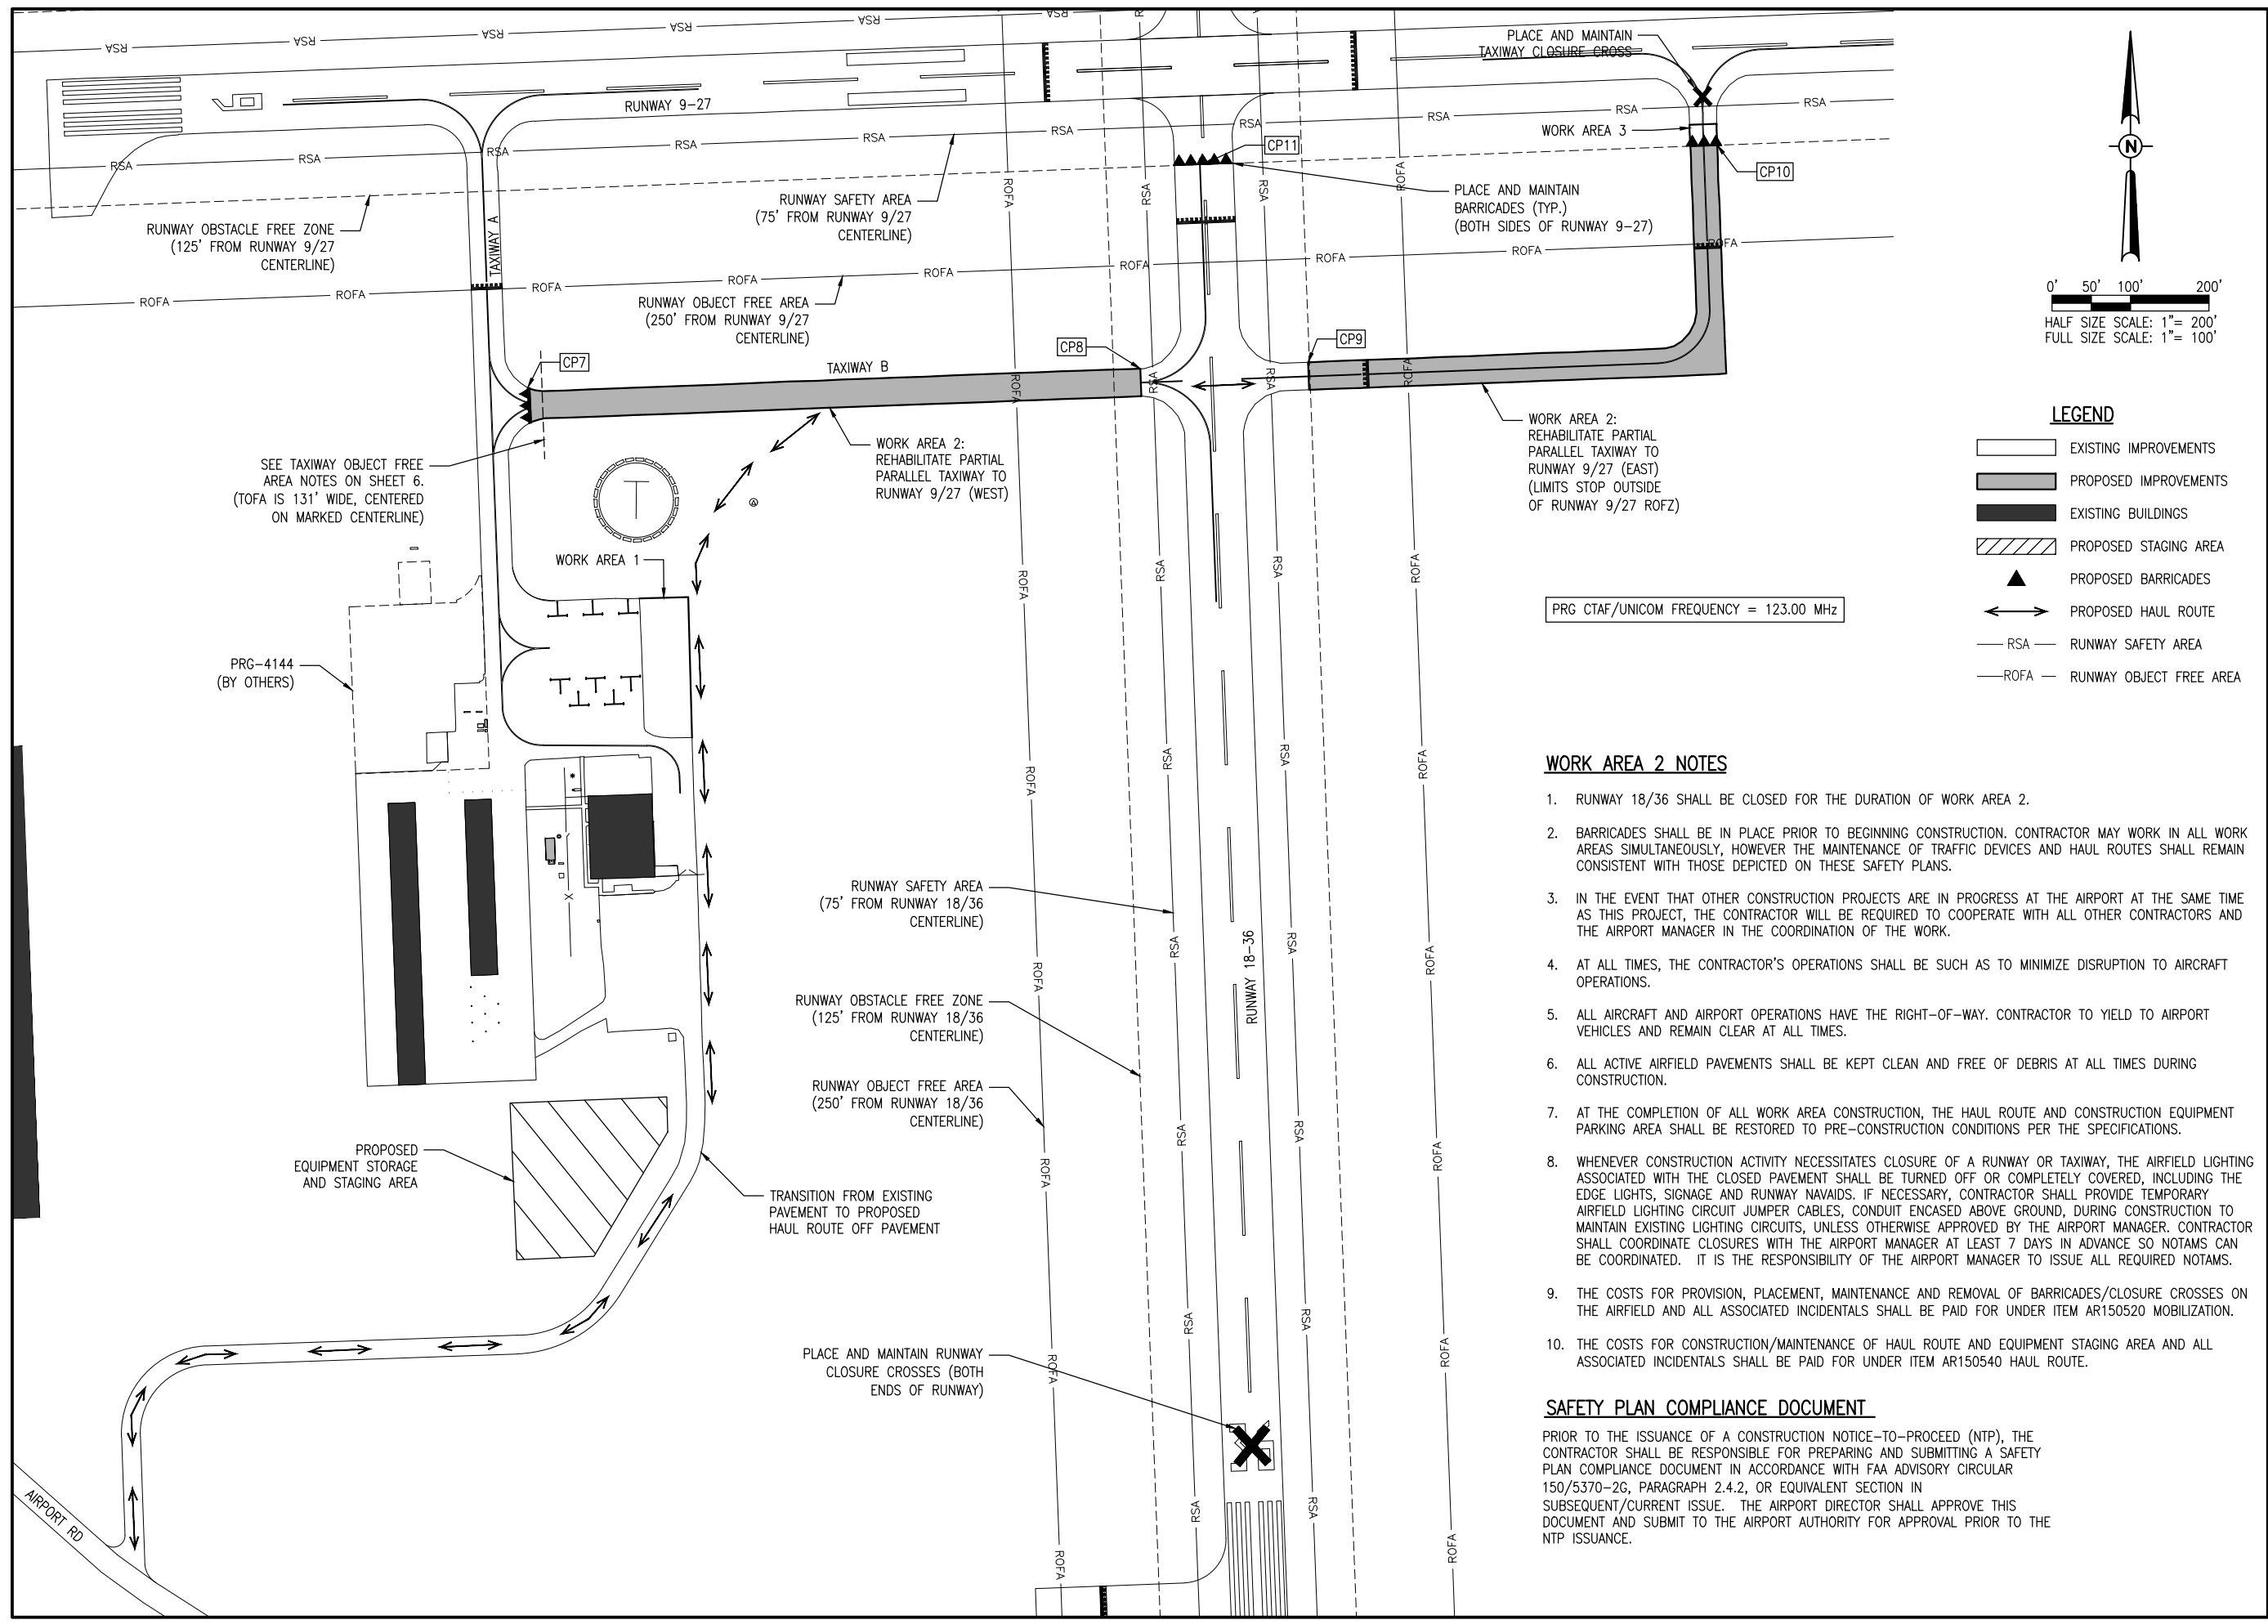

- LEGEND**
- EXISTING IMPROVEMENTS
 - PROPOSED IMPROVEMENTS
 - EXISTING BUILDINGS
 - PROPOSED STAGING AREA
 - PROPOSED BARRICADES
 - PROPOSED HAUL ROUTE
 - RSA — RUNWAY SAFETY AREA
 - ROFA — RUNWAY OBJECT FREE AREA


PRG CTAF/UNICOM FREQUENCY = 123.00 MHZ

WORK AREA 2 NOTES

1. RUNWAY 18/36 SHALL BE CLOSED FOR THE DURATION OF WORK AREA 2.
2. BARRICADES SHALL BE IN PLACE PRIOR TO BEGINNING CONSTRUCTION. CONTRACTOR MAY WORK IN ALL WORK AREAS SIMULTANEOUSLY, HOWEVER THE MAINTENANCE OF TRAFFIC DEVICES AND HAUL ROUTES SHALL REMAIN CONSISTENT WITH THOSE DEPICTED ON THESE SAFETY PLANS.
3. IN THE EVENT THAT OTHER CONSTRUCTION PROJECTS ARE IN PROGRESS AT THE AIRPORT AT THE SAME TIME AS THIS PROJECT, THE CONTRACTOR WILL BE REQUIRED TO COOPERATE WITH ALL OTHER CONTRACTORS AND THE AIRPORT MANAGER IN THE COORDINATION OF THE WORK.
4. AT ALL TIMES, THE CONTRACTOR'S OPERATIONS SHALL BE SUCH AS TO MINIMIZE DISRUPTION TO AIRCRAFT OPERATIONS.
5. ALL AIRCRAFT AND AIRPORT OPERATIONS HAVE THE RIGHT-OF-WAY. CONTRACTOR TO YIELD TO AIRPORT VEHICLES AND REMAIN CLEAR AT ALL TIMES.
6. ALL ACTIVE AIRFIELD PAVEMENTS SHALL BE KEPT CLEAN AND FREE OF DEBRIS AT ALL TIMES DURING CONSTRUCTION.
7. AT THE COMPLETION OF ALL WORK AREA CONSTRUCTION, THE HAUL ROUTE AND CONSTRUCTION EQUIPMENT PARKING AREA SHALL BE RESTORED TO PRE-CONSTRUCTION CONDITIONS PER THE SPECIFICATIONS.
8. WHENEVER CONSTRUCTION ACTIVITY NECESSITATES CLOSURE OF A RUNWAY OR TAXIWAY, THE AIRFIELD LIGHTING ASSOCIATED WITH THE CLOSED PAVEMENT SHALL BE TURNED OFF OR COMPLETELY COVERED, INCLUDING THE EDGE LIGHTS, SIGNAGE AND RUNWAY NAVAIDS. IF NECESSARY, CONTRACTOR SHALL PROVIDE TEMPORARY AIRFIELD LIGHTING CIRCUIT JUMPER CABLES, CONDUIT ENCASED ABOVE GROUND, DURING CONSTRUCTION TO MAINTAIN EXISTING LIGHTING CIRCUITS, UNLESS OTHERWISE APPROVED BY THE AIRPORT MANAGER. CONTRACTOR SHALL COORDINATE CLOSURES WITH THE AIRPORT MANAGER AT LEAST 7 DAYS IN ADVANCE SO NOTAMS CAN BE COORDINATED. IT IS THE RESPONSIBILITY OF THE AIRPORT MANAGER TO ISSUE ALL REQUIRED NOTAMS.
9. THE COSTS FOR PROVISION, PLACEMENT, MAINTENANCE AND REMOVAL OF BARRICADES/CLOSURE CROSSES ON THE AIRFIELD AND ALL ASSOCIATED INCIDENTALS SHALL BE PAID FOR UNDER ITEM AR150520 MOBILIZATION.
10. THE COSTS FOR CONSTRUCTION/MAINTENANCE OF HAUL ROUTE AND EQUIPMENT STAGING AREA AND ALL ASSOCIATED INCIDENTALS SHALL BE PAID FOR UNDER ITEM AR150540 HAUL ROUTE.

SAFETY PLAN COMPLIANCE DOCUMENT

PRIOR TO THE ISSUANCE OF A CONSTRUCTION NOTICE-TO-PROCEED (NTP), THE CONTRACTOR SHALL BE RESPONSIBLE FOR PREPARING AND SUBMITTING A SAFETY PLAN COMPLIANCE DOCUMENT IN ACCORDANCE WITH FAA ADVISORY CIRCULAR 150/5370-2G, PARAGRAPH 2.4.2, OR EQUIVALENT SECTION IN SUBSEQUENT/CURRENT ISSUE. THE AIRPORT DIRECTOR SHALL APPROVE THIS DOCUMENT AND SUBMIT TO THE AIRPORT AUTHORITY FOR APPROVAL PRIOR TO THE NTP ISSUANCE.

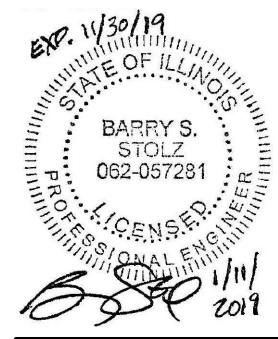

EAST AIRCRAFT
PARKING RAMP
EXPANSION &
REHABILITATE PARTIAL
PARALLEL TAXIWAY TO
RUNWAY 9/27

IDA No: PRG-4558


Contract No. ED019

NO.	DATE	DESCRIPTION		
		LAY	DWN	REV

ISSUE: JANUARY 11, 2019
PROJECT NO: 17A0016D
CAD FILE: G-004-SFY.DWG
LAYOUT BY: JRH 11/29/2018
DRAWN BY: JRH 11/29/2018
REVIEWED BY: BSS 01/11/2019

SHEET TITLE

PROPOSED SAFETY
PLAN - WORK AREA 2

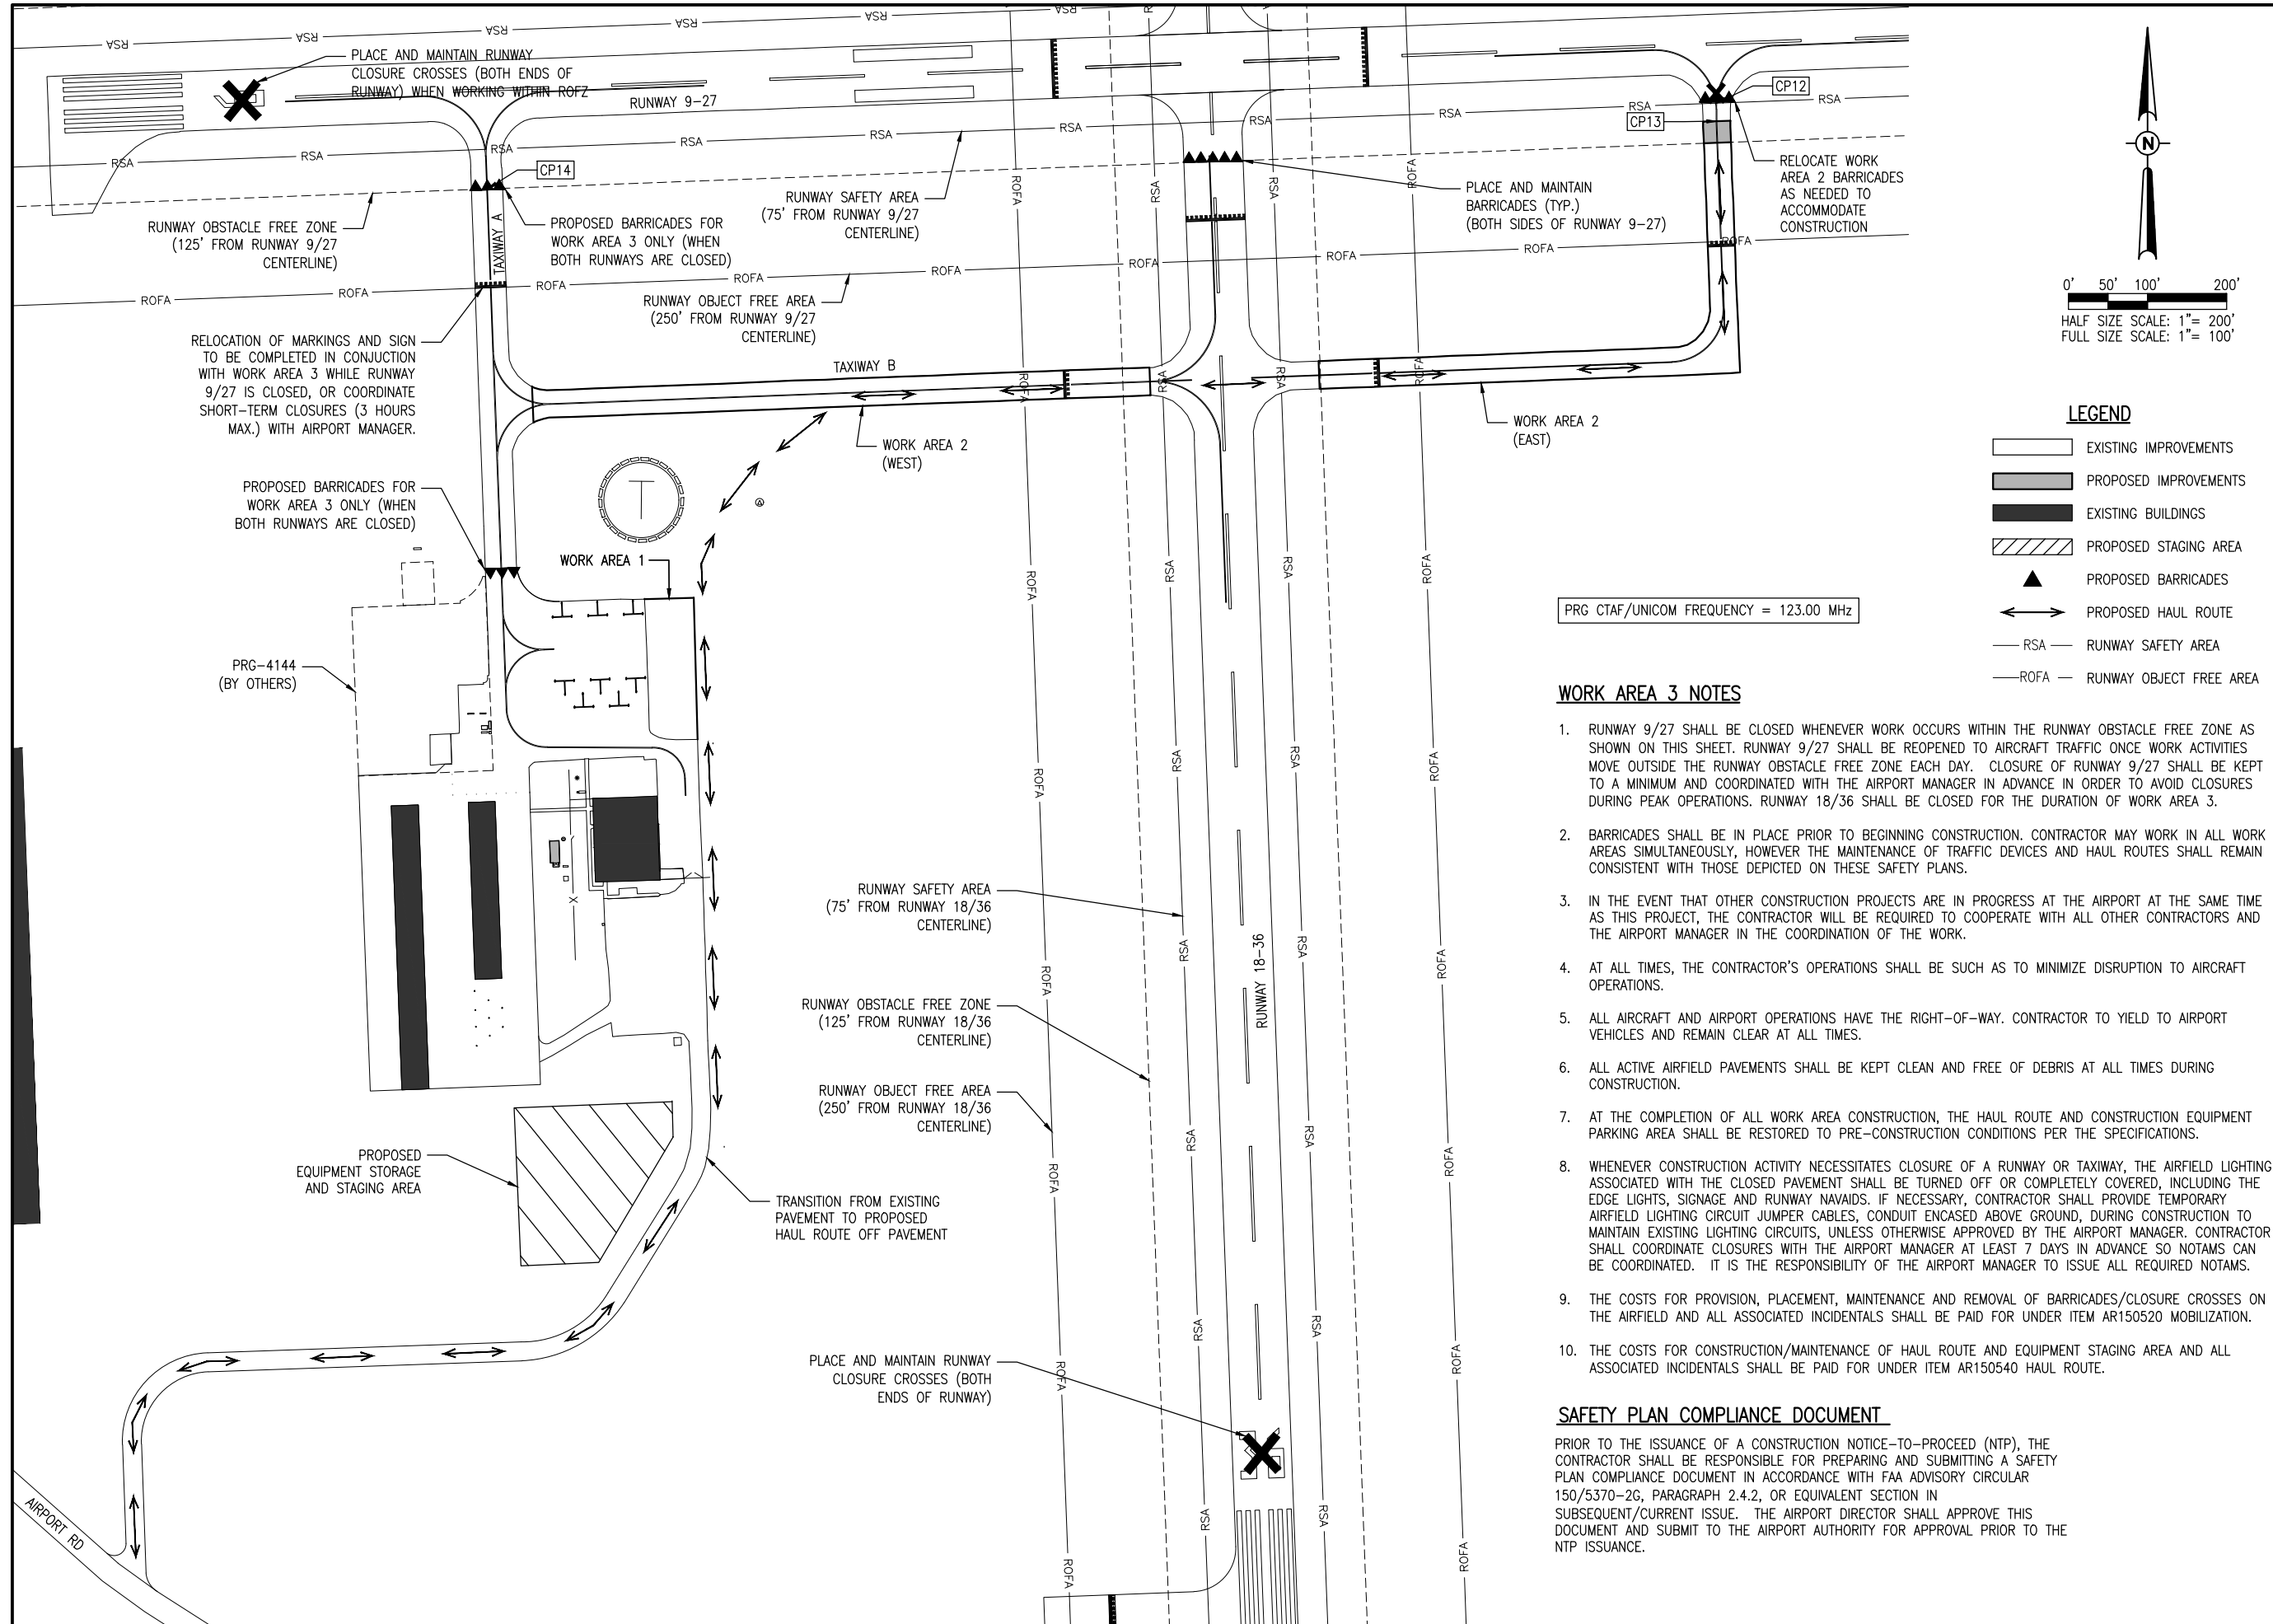

LEGEND

- EXISTING IMPROVEMENTS
- PROPOSED IMPROVEMENTS
- EXISTING BUILDINGS
- PROPOSED STAGING AREA
- PROPOSED BARRICADES
- PROPOSED HAUL ROUTE
- RSA - RUNWAY SAFETY AREA
- ROFA - RUNWAY OBJECT FREE AREA


PRG CTAF/UNICOM FREQUENCY = 123.00 MHz

WORK AREA 3 NOTES

1. RUNWAY 9/27 SHALL BE CLOSED WHENEVER WORK OCCURS WITHIN THE RUNWAY OBSTACLE FREE ZONE AS SHOWN ON THIS SHEET. RUNWAY 9/27 SHALL BE REOPENED TO AIRCRAFT TRAFFIC ONCE WORK ACTIVITIES MOVE OUTSIDE THE RUNWAY OBSTACLE FREE ZONE EACH DAY. CLOSURE OF RUNWAY 9/27 SHALL BE KEPT TO A MINIMUM AND COORDINATED WITH THE AIRPORT MANAGER IN ADVANCE IN ORDER TO AVOID CLOSURES DURING PEAK OPERATIONS. RUNWAY 18/36 SHALL BE CLOSED FOR THE DURATION OF WORK AREA 3.
2. BARRICADES SHALL BE IN PLACE PRIOR TO BEGINNING CONSTRUCTION. CONTRACTOR MAY WORK IN ALL WORK AREAS SIMULTANEOUSLY, HOWEVER THE MAINTENANCE OF TRAFFIC DEVICES AND HAUL ROUTES SHALL REMAIN CONSISTENT WITH THOSE DEPICTED ON THESE SAFETY PLANS.
3. IN THE EVENT THAT OTHER CONSTRUCTION PROJECTS ARE IN PROGRESS AT THE AIRPORT AT THE SAME TIME AS THIS PROJECT, THE CONTRACTOR WILL BE REQUIRED TO COOPERATE WITH ALL OTHER CONTRACTORS AND THE AIRPORT MANAGER IN THE COORDINATION OF THE WORK.
4. AT ALL TIMES, THE CONTRACTOR'S OPERATIONS SHALL BE SUCH AS TO MINIMIZE DISRUPTION TO AIRCRAFT OPERATIONS.
5. ALL AIRCRAFT AND AIRPORT OPERATIONS HAVE THE RIGHT-OF-WAY. CONTRACTOR TO YIELD TO AIRPORT VEHICLES AND REMAIN CLEAR AT ALL TIMES.
6. ALL ACTIVE AIRFIELD PAVEMENTS SHALL BE KEPT CLEAN AND FREE OF DEBRIS AT ALL TIMES DURING CONSTRUCTION.
7. AT THE COMPLETION OF ALL WORK AREA CONSTRUCTION, THE HAUL ROUTE AND CONSTRUCTION EQUIPMENT PARKING AREA SHALL BE RESTORED TO PRE-CONSTRUCTION CONDITIONS PER THE SPECIFICATIONS.
8. WHENEVER CONSTRUCTION ACTIVITY NECESSITATES CLOSURE OF A RUNWAY OR TAXIWAY, THE AIRFIELD LIGHTING ASSOCIATED WITH THE CLOSED PAVEMENT SHALL BE TURNED OFF OR COMPLETELY COVERED, INCLUDING THE EDGE LIGHTS, SIGNAGE AND RUNWAY NAVAIDS. IF NECESSARY, CONTRACTOR SHALL PROVIDE TEMPORARY AIRFIELD LIGHTING CIRCUIT JUMPER CABLES, CONDUIT ENCASED ABOVE GROUND, DURING CONSTRUCTION TO MAINTAIN EXISTING LIGHTING CIRCUITS, UNLESS OTHERWISE APPROVED BY THE AIRPORT MANAGER. CONTRACTOR SHALL COORDINATE CLOSURES WITH THE AIRPORT MANAGER AT LEAST 7 DAYS IN ADVANCE SO NOTAMS CAN BE COORDINATED. IT IS THE RESPONSIBILITY OF THE AIRPORT MANAGER TO ISSUE ALL REQUIRED NOTAMS.
9. THE COSTS FOR PROVISION, PLACEMENT, MAINTENANCE AND REMOVAL OF BARRICADES/CLOSURE CROSSES ON THE AIRFIELD AND ALL ASSOCIATED INCIDENTALS SHALL BE PAID FOR UNDER ITEM AR150520 MOBILIZATION.
10. THE COSTS FOR CONSTRUCTION/MAINTENANCE OF HAUL ROUTE AND EQUIPMENT STAGING AREA AND ALL ASSOCIATED INCIDENTALS SHALL BE PAID FOR UNDER ITEM AR150540 HAUL ROUTE.

SAFETY PLAN COMPLIANCE DOCUMENT

PRIOR TO THE ISSUANCE OF A CONSTRUCTION NOTICE-TO-PROCEED (NTP), THE CONTRACTOR SHALL BE RESPONSIBLE FOR PREPARING AND SUBMITTING A SAFETY PLAN COMPLIANCE DOCUMENT IN ACCORDANCE WITH FAA ADVISORY CIRCULAR 150/5370-2G, PARAGRAPH 2.4.2, OR EQUIVALENT SECTION IN SUBSEQUENT/CURRENT ISSUE. THE AIRPORT DIRECTOR SHALL APPROVE THIS DOCUMENT AND SUBMIT TO THE AIRPORT AUTHORITY FOR APPROVAL PRIOR TO THE NTP ISSUANCE.

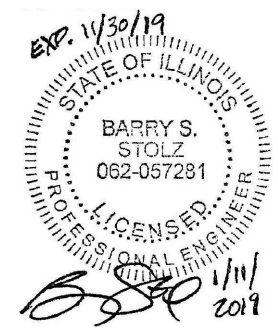

EAST AIRCRAFT PARKING RAMP EXPANSION & REHABILITATE PARTIAL PARALLEL TAXIWAY TO RUNWAY 9/27


IDA No: PRG-4558

Contract No. ED019

NO.	DATE	DESCRIPTION		
		LAY	DWN	REV

ISSUE: JANUARY 11, 2019
PROJECT NO: 17A0016D
CAD FILE: G-004-SFY.DWG
LAYOUT BY: JRH 11/29/2018
DRAWN BY: JRH 11/29/2018
REVIEWED BY: BSS 01/11/2019


PROPOSED SAFETY PLAN - WORK AREA 3

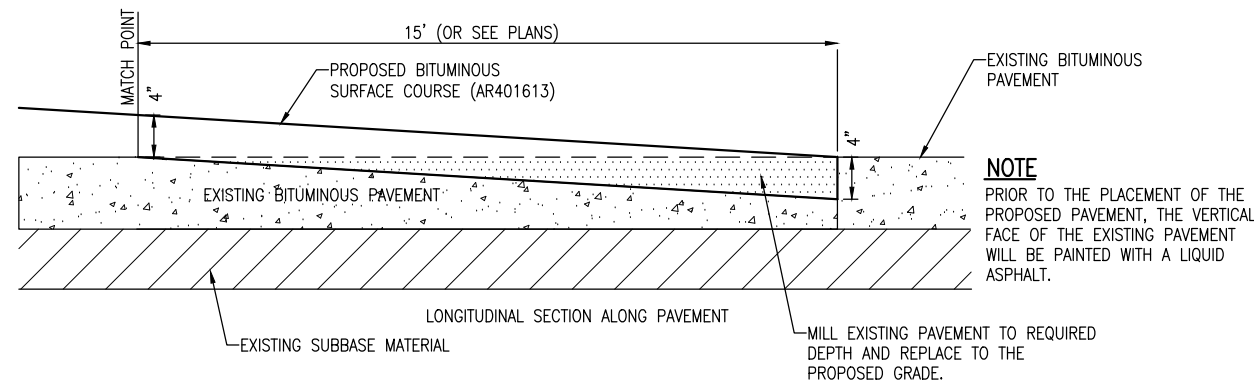

PROPOSED BUTT JOINT TRANSITION DETAIL
NOT TO SCALE


AR401655 BUTT JOINT CONSTRUCTION NOTES

1. THE PROPOSED BUTT JOINTS SHALL BE CONSTRUCTED IN ACCORDANCE WITH ITEM AR401655 "BUTT JOINT CONSTRUCTION" AS STATED IN THE STANDARD SPECIFICATIONS, ADOPTED APRIL 1, 2012.
2. THIS ITEM SHALL CONSIST OF REMOVING THE EXISTING BITUMINOUS PAVEMENT SURFACE BY MILLING IN ORDER TO CONSTRUCT A BUTT JOINT FOR THE TRANSITION OF THE PROPOSED BITUMINOUS OVERLAY AT THE LOCATIONS AS SHOWN ON THE PLANS.
3. THE PAVEMENT SURFACE WILL THEN BE MILLED TO A DEPTH OF 4" AT THE BUTT END AND WILL TAPER TO 0 IN. AT THE OPPOSITE END. THE PLANER MUST BE CAPABLE OF MILLING THE SURFACE TO THE DESIRED ELEVATIONS AND GRADES.
4. ANY ADJACENT PAVEMENT DAMAGED BY THE MILLING OPERATIONS WILL BE REPAIRED AT THE CONTRACTOR'S OWN EXPENSE.
5. ALL BITUMINOUS PAVEMENT MILLING AREAS WILL BE LOCATED AND MARKED BY THE CONTRACTOR AND ACCEPTED BY THE RESIDENT ENGINEER.
6. THE PAVEMENT MILLING WILL BE PAID FOR UNDER ITEM: AR401655 "BUTT JOINT CONSTRUCTION", PER S.Y.

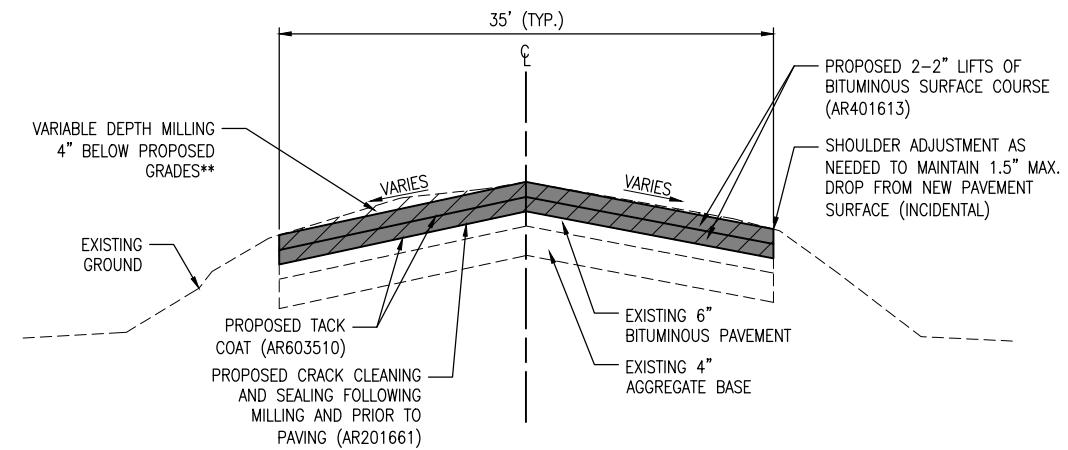


PROPOSED TAXIWAY B/B1 - TYPICAL SECTION B-B
NOT TO SCALE

** PROPOSED MILLING SHALL ACCOMMODATE 4" OF PROPOSED BITUMINOUS PAVEMENT SUCH THAT THE PROPOSED CENTERLINE ELEVATION AND THE PROPOSED EDGE OF PAVEMENT ELEVATIONS MATCH THE RESPECTIVE EXISTING PAVEMENT ELEVATIONS. THE INTENT IS TO ESTABLISH A STRAIGHT GRADE FROM CENTERLINE TO EDGE OF PAVEMENT. SEE CROSS SECTION SHEETS FOR ADDITIONAL INFORMATION.

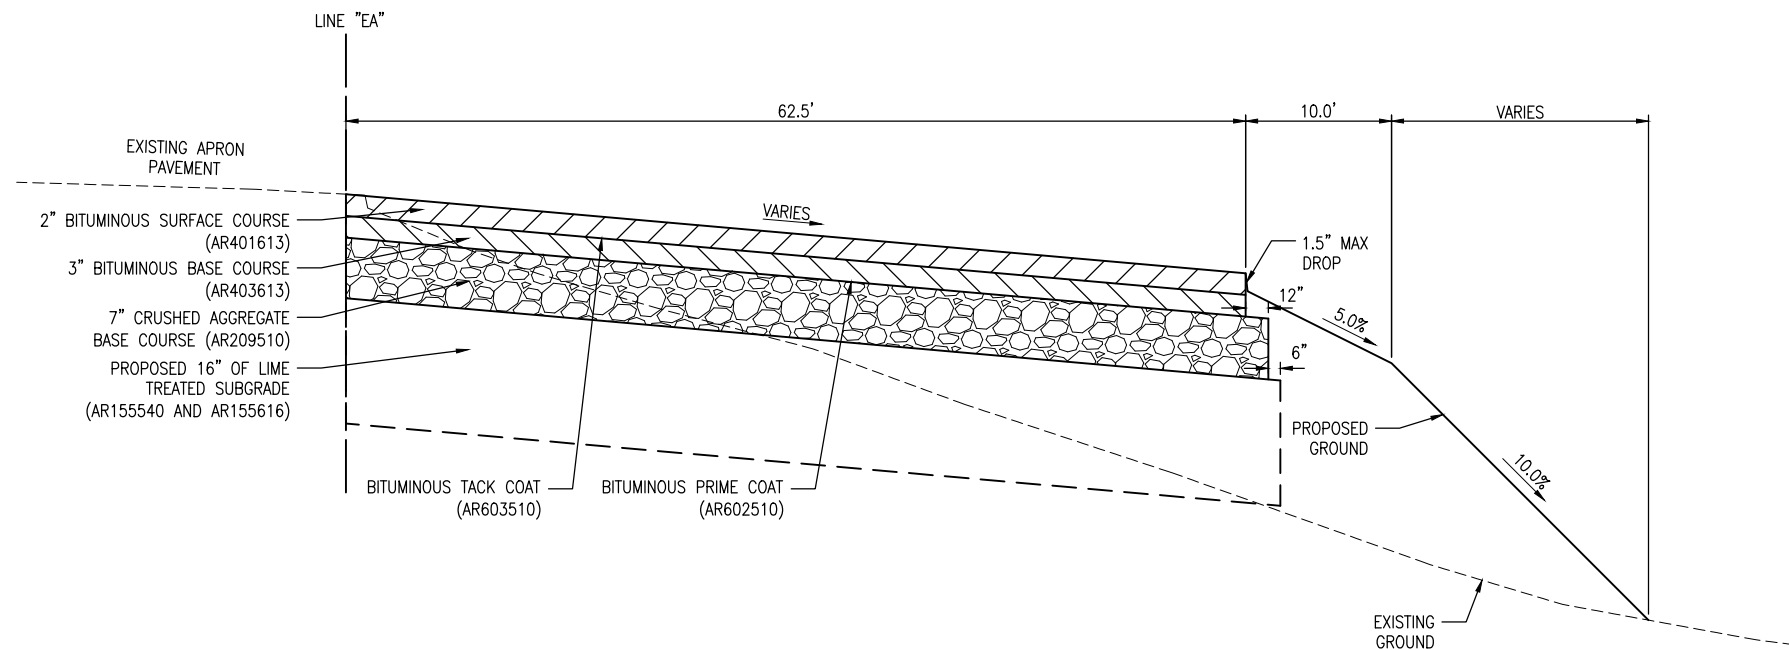

PROPOSED EAST APRON - TYPICAL SECTION A-A
NOT TO SCALE

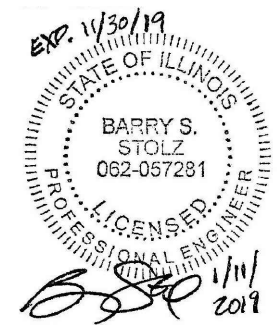

EAST AIRCRAFT
PARKING RAMP
EXPANSION &
REHABILITATE PARTIAL
PARALLEL TAXIWAY TO
RUNWAY 9/27

IDA No: PRG-4558


Contract No. ED019

NO.	DATE	DESCRIPTION		
		LAY	DWN	REV

ISSUE: JANUARY 11, 2019
PROJECT NO: 17A0016D
CAD FILE: C-301-TYP.DWG
LAYOUT BY: JRH 12/07/2018
DRAWN BY: JRH 12/07/2018
REVIEWED BY: BSS 01/11/2019


SHEET TITLE

PROPOSED TYPICAL
SECTIONS

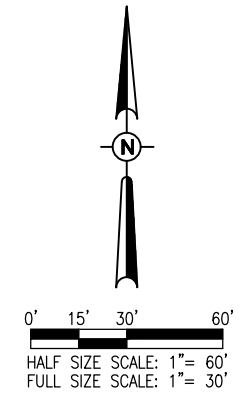

LEGEND

	EXISTING IMPROVEMENTS
	PROPOSED IMPROVEMENTS
	EXISTING BUILDINGS
	PROPOSED PAVEMENT REMOVAL
	EXISTING ELECTRICAL DUCT
	PROPOSED ELECTRICAL DUCT (BY OTHERS)
	EXISTING LIGHTING CIRCUIT
	EXISTING STAKE MOUNTED TAXIWAY LIGHT
	EXISTING BASE MOUNTED TAXIWAY LIGHT
	EXISTING SPLICE CAN
	EXISTING ELECTRICAL MANHOLE
	EXISTING ELECTRICAL HANDHOLE

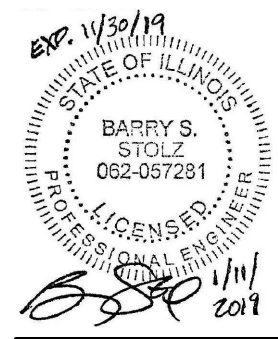

**EAST AIRCRAFT
PARKING RAMP
EXPANSION &
REHABILITATE PARTIAL
PARALLEL TAXIWAY TO
RUNWAY 9/27**

IDA No: PRG-4558


Contract No. ED019

NO.	DATE	DESCRIPTION		
		LAY	DWN	REV

ISSUE: JANUARY 11, 2019
PROJECT NO: 17A0016D
CAD FILE: C-121-CON.DWG
LAYOUT BY: JRH 11/30/2018
DRAWN BY: JRH 11/30/2018
REVIEWED BY: BSS 01/11/2019



SHEET TITLE

**PROPOSED
CONSTRUCTION
PLAN - EAST APRON**

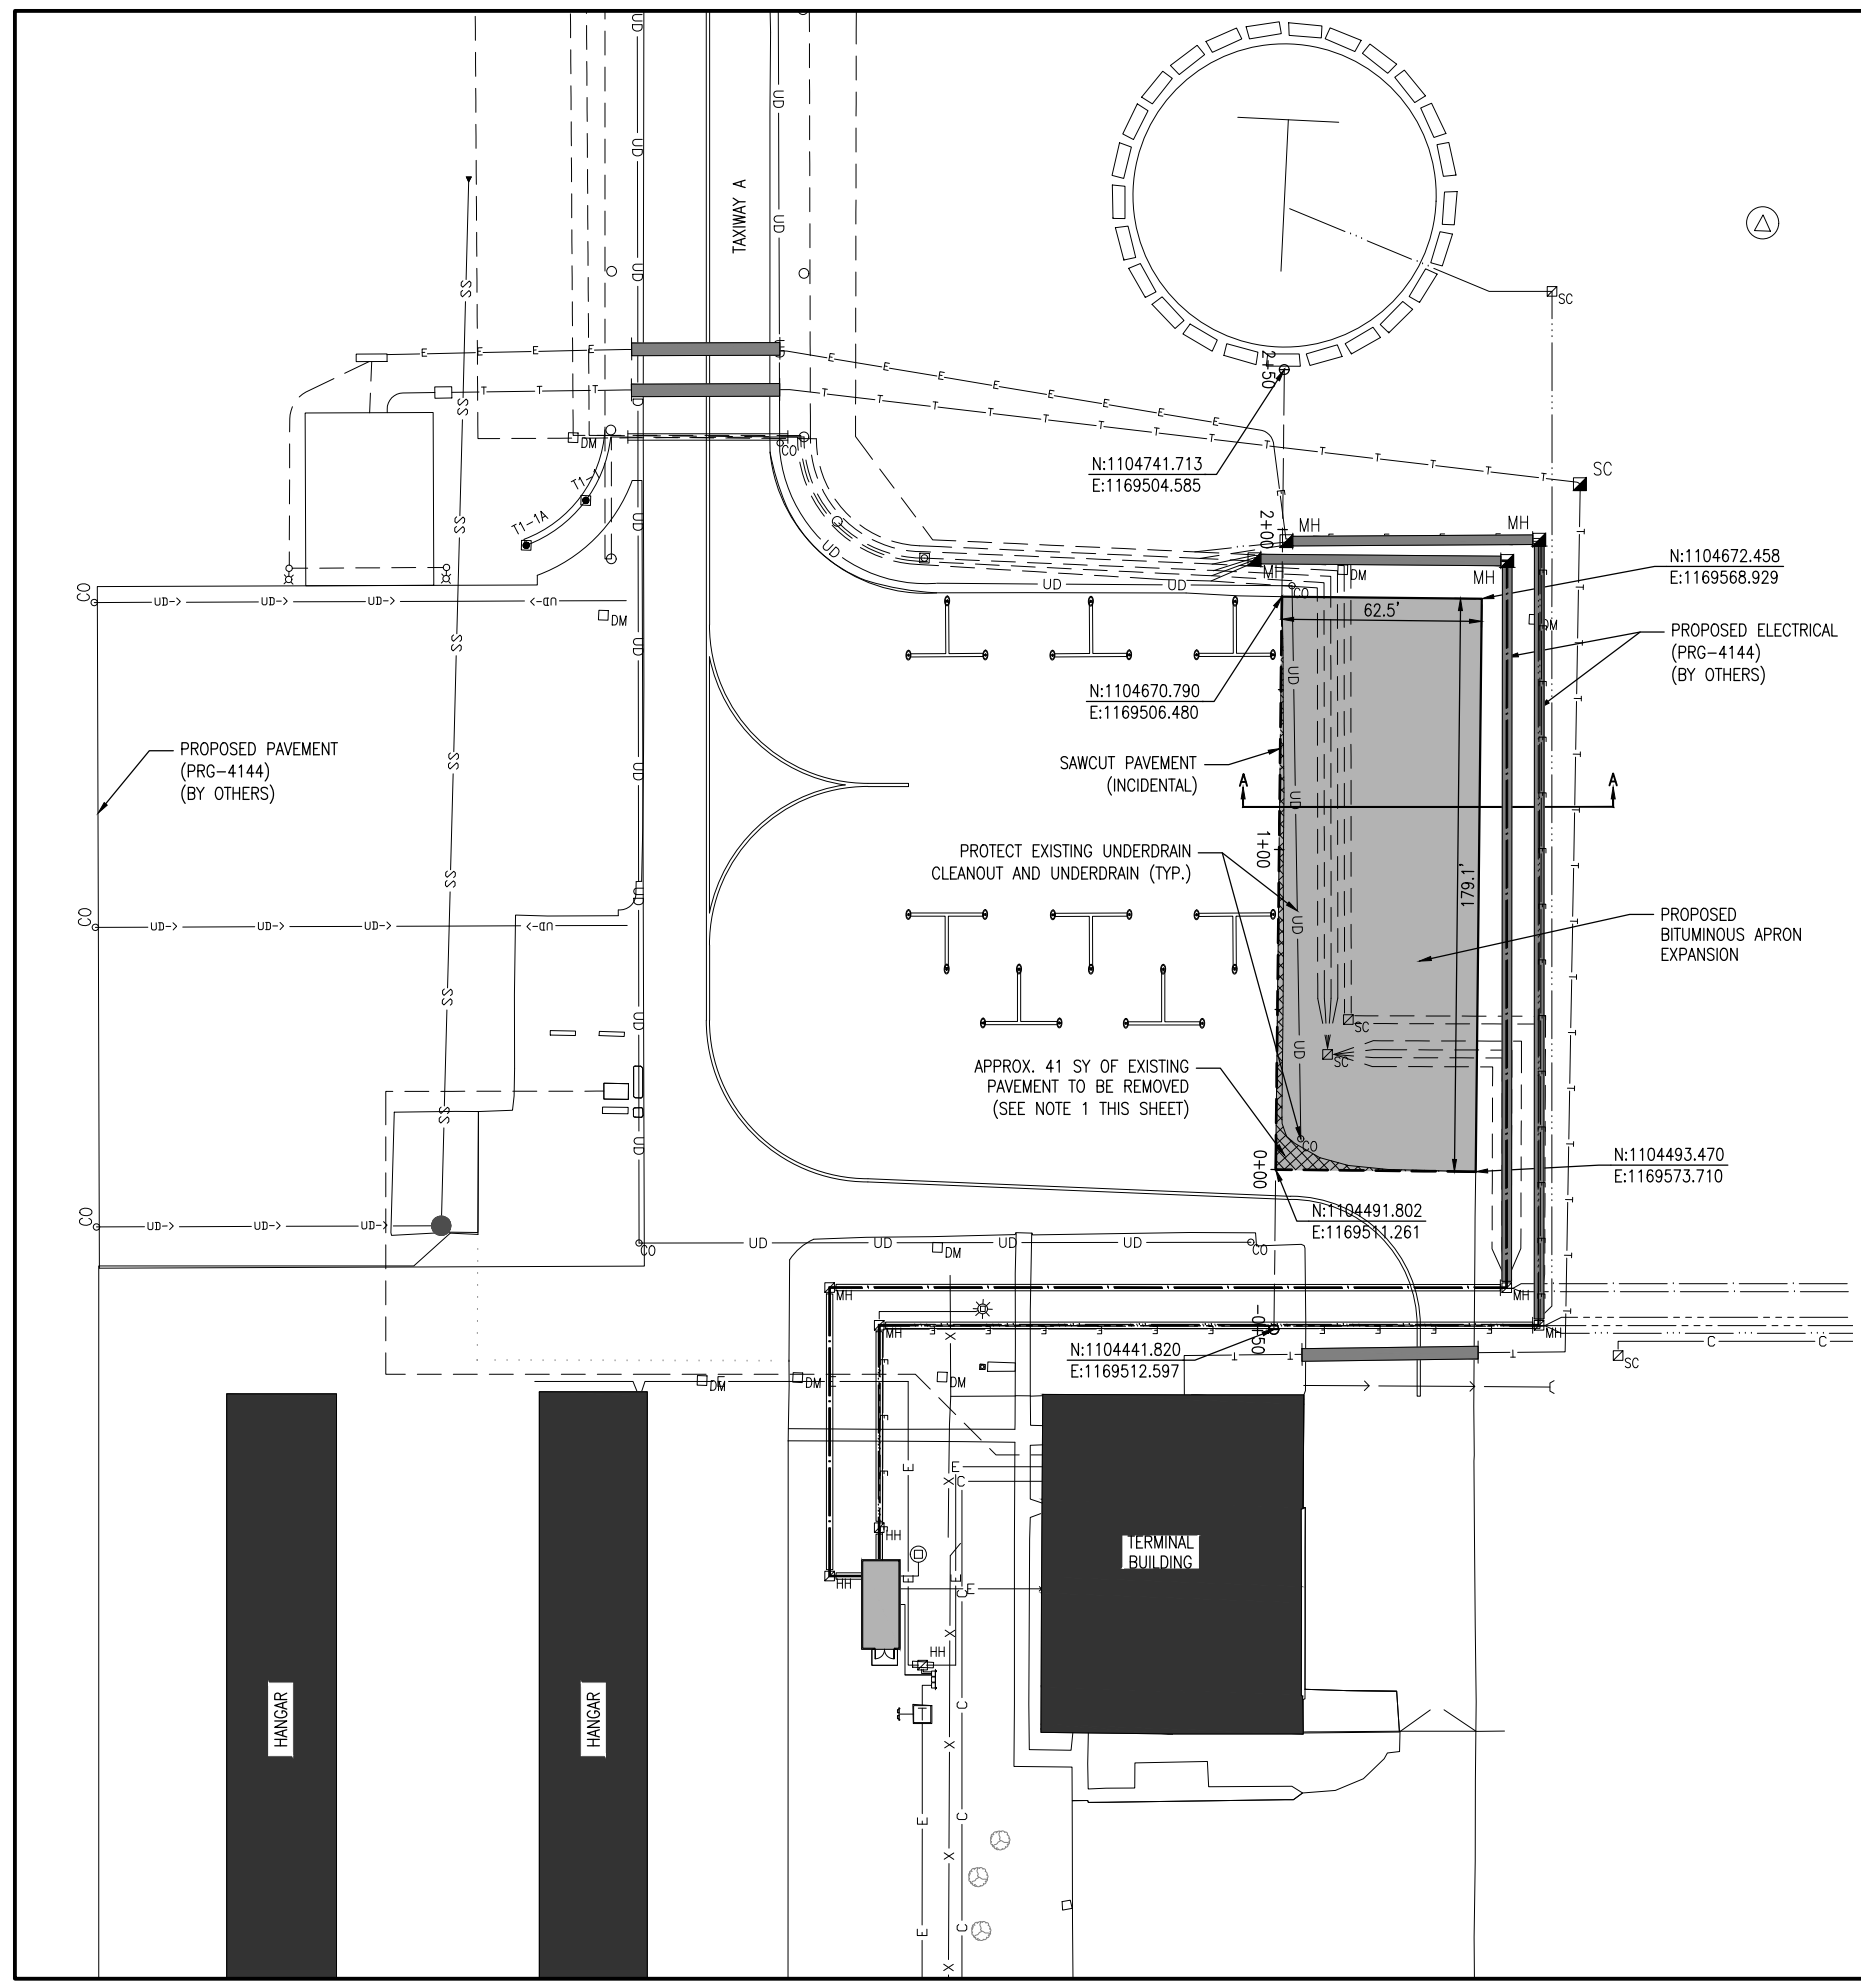


NOTES

- EXISTING APRON PAVEMENT SECTION TO BE REMOVED CONSISTS OF:
1.5" BITUMINOUS SURFACE COURSE
±1.5" BITUMINOUS LEVELING COURSE
1.2" POROUS FRICTION COURSE
2" BITUMINOUS SURFACE COURSE
6" BITUMINOUS BASE COURSE

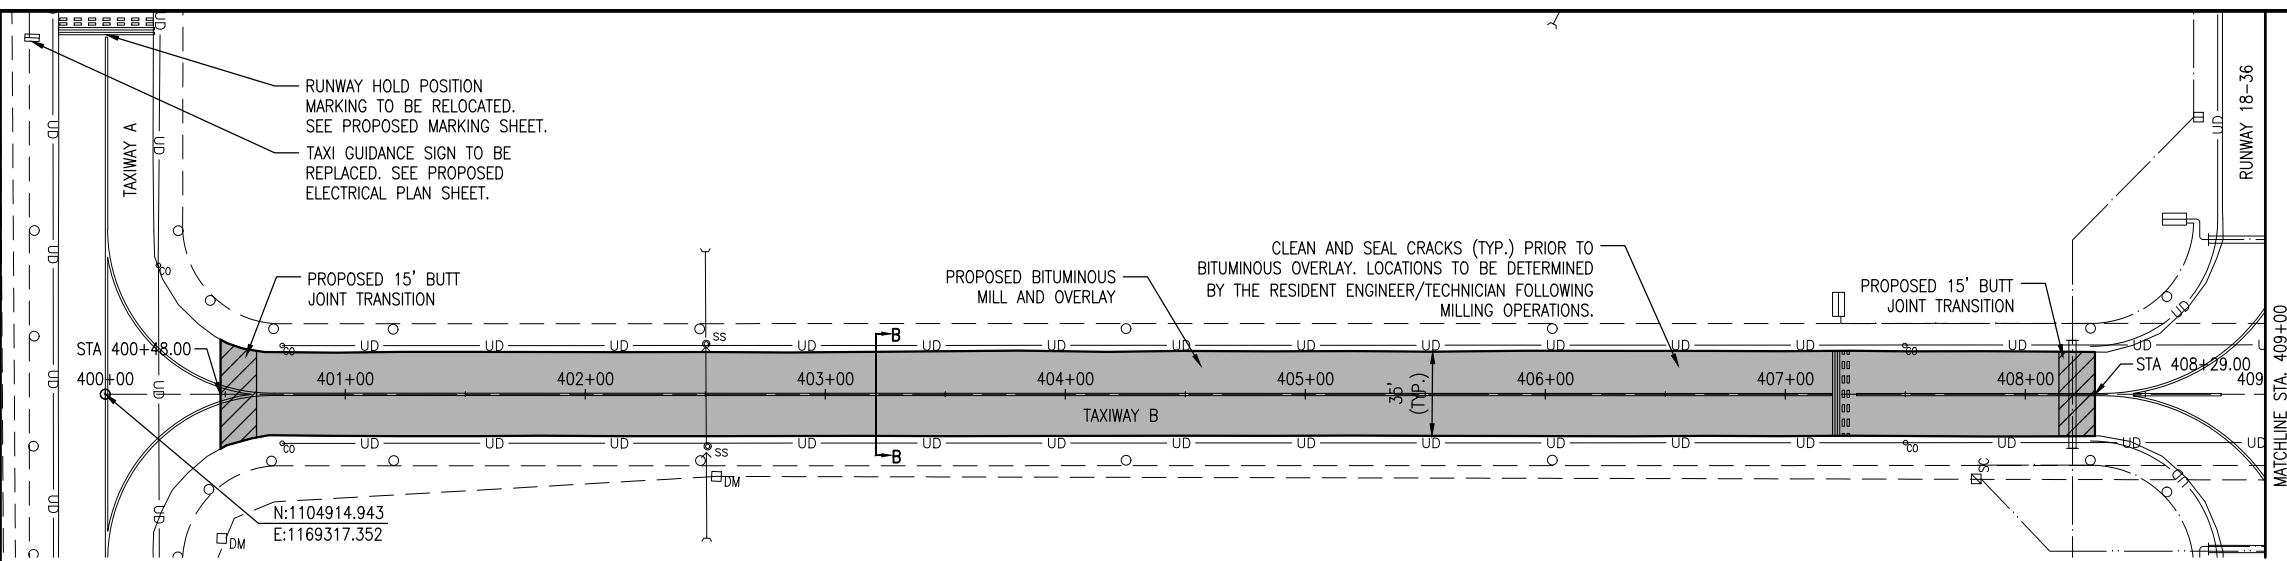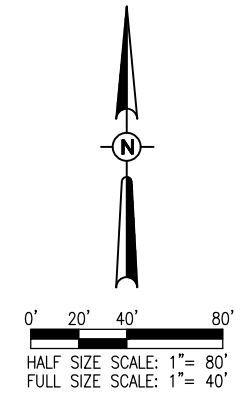

- LEGEND**
- EXISTING IMPROVEMENTS
 - PROPOSED IMPROVEMENTS
 - EXISTING BUILDINGS
 - PROPOSED BUTT JOINT
 - EXISTING ELECTRICAL DUCT
 - EXISTING LIGHTING CIRCUIT
 - EXISTING STAKE MOUNTED TAXIWAY LIGHT
 - EXISTING BASE MOUNTED TAXIWAY LIGHT
 - EXISTING STAKE MOUNTED RUNWAY LIGHT
 - EXISTING BASE MOUNTED RUNWAY LIGHT
 - EXISTING TAXI GUIDANCE SIGN
 - EXISTING SPLICE CAN
 - EXISTING ELECTRICAL MANHOLE
 - EXISTING ELECTRICAL HANDHOLE

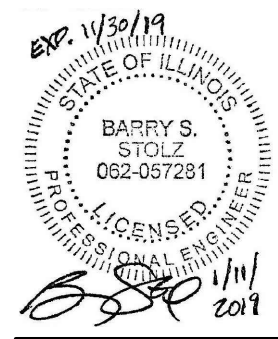

**EAST AIRCRAFT
PARKING RAMP
EXPANSION &
REHABILITATE PARTIAL
PARALLEL TAXIWAY TO
RUNWAY 9/27**

IDA No: PRG-4558


Contract No. ED019

NO.	DATE	DESCRIPTION		
		LAY	DWN	REV


ISSUE: JANUARY 11, 2019
PROJECT NO: 17A0016D
CAD FILE: C-121-CON.DWG
LAYOUT BY: JRH 11/30/2018
DRAWN BY: JRH 11/30/2018
REVIEWED BY: BSS 01/11/2019

SHEET TITLE

**PROPOSED
CONSTRUCTION
PLAN - PARALLEL
TAXIWAY**

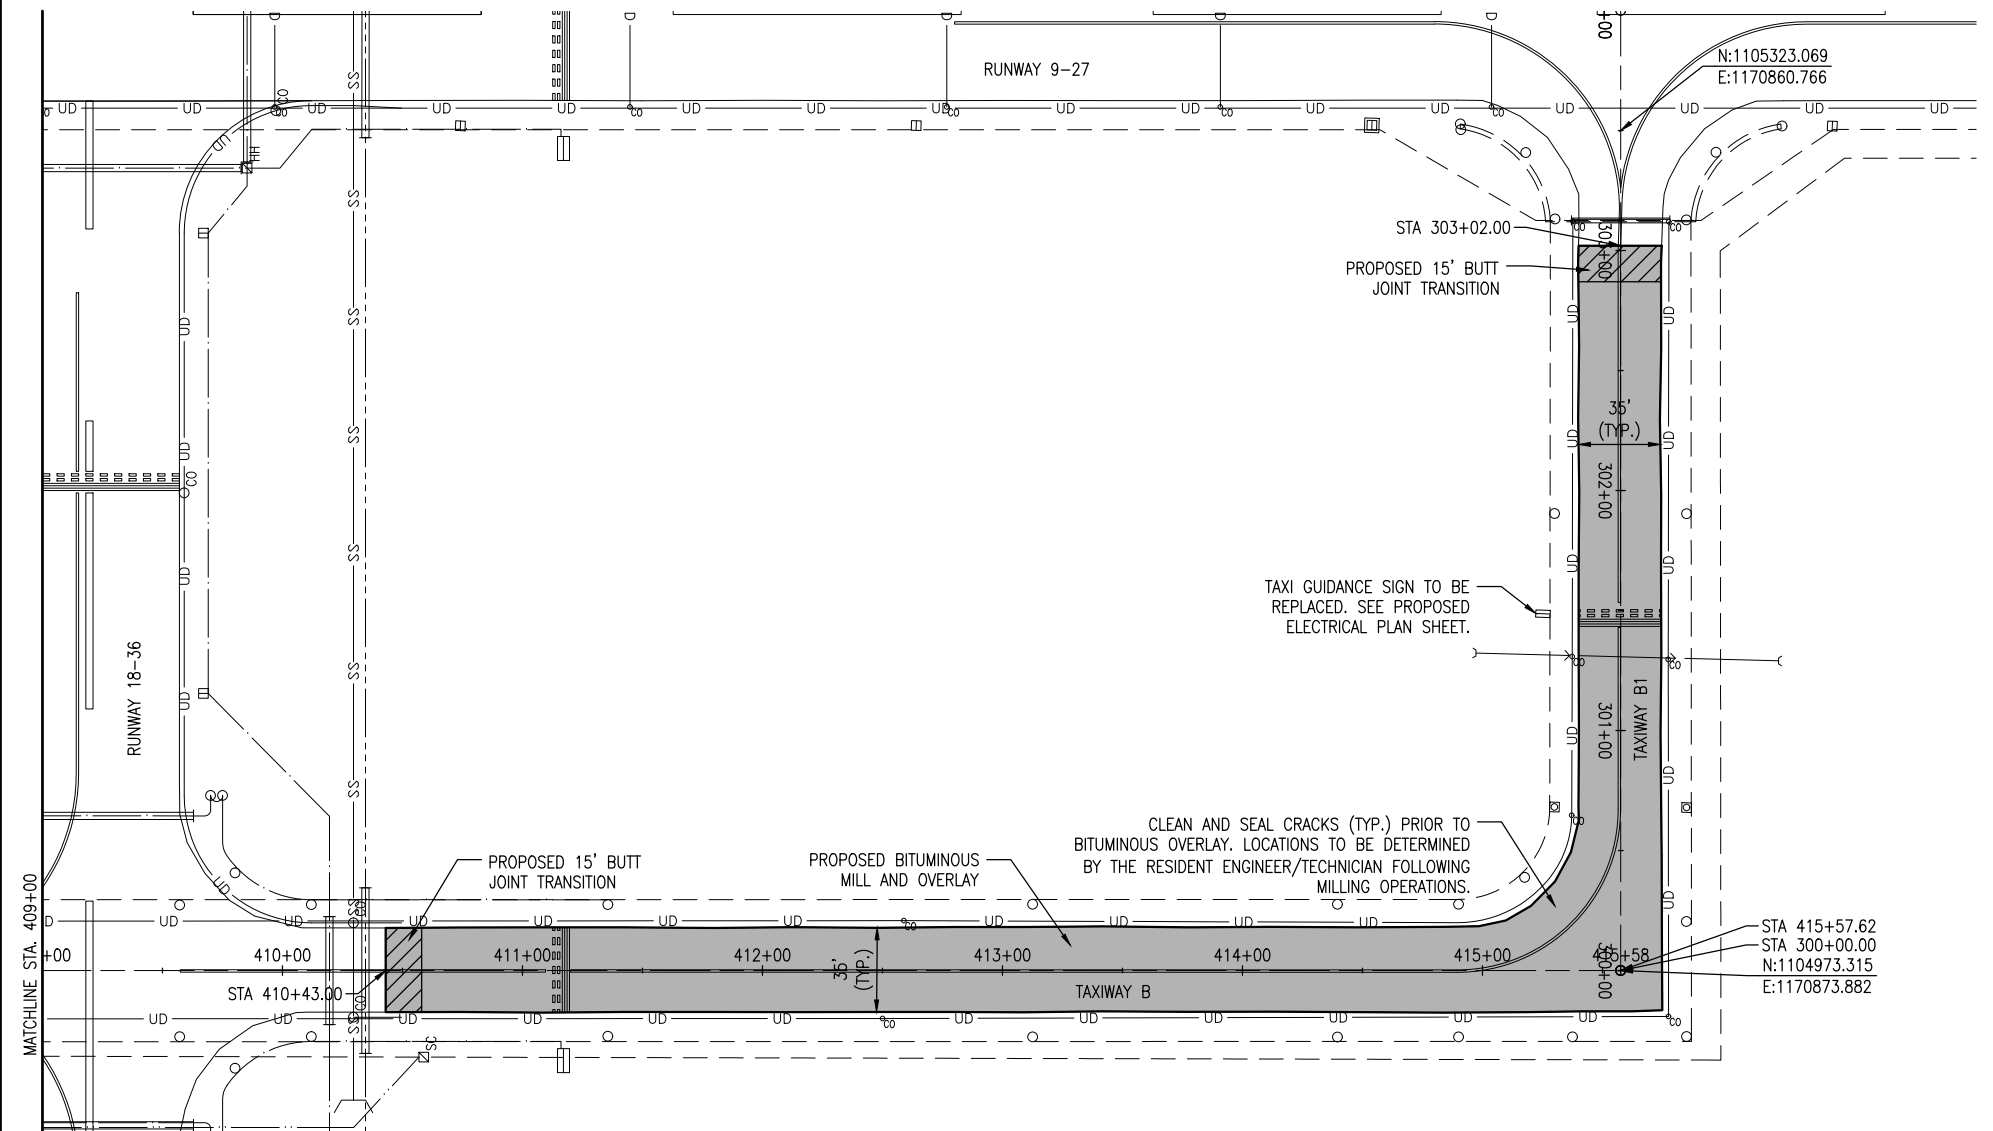

 
JAN 22, 2019 2:05 PM STOLZ01647
I:\17\JOBS\17A0016D\CAD\AIRPORT\TSHEETC-121-CON.DWG




0' 15' 30' 60'
HALF SIZE SCALE: 1" = 60'
FULL SIZE SCALE: 1" = 30'

LEGEND

- EXISTING IMPROVEMENTS
- PROPOSED IMPROVEMENTS
- EXISTING BUILDINGS
- PROPOSED SPOT ELEVATION
- PROPOSED SEEDING/MULCHING
- PROPOSED SILT FENCE

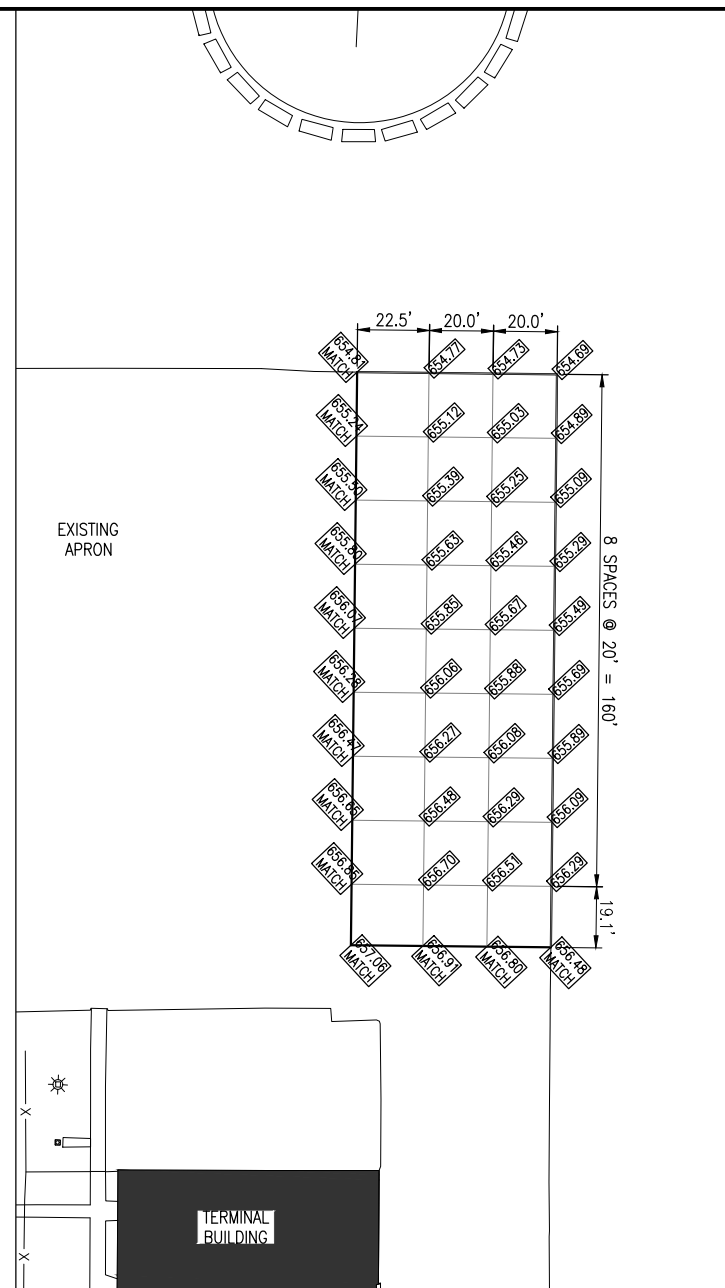


PROPOSED STAKING PLAN

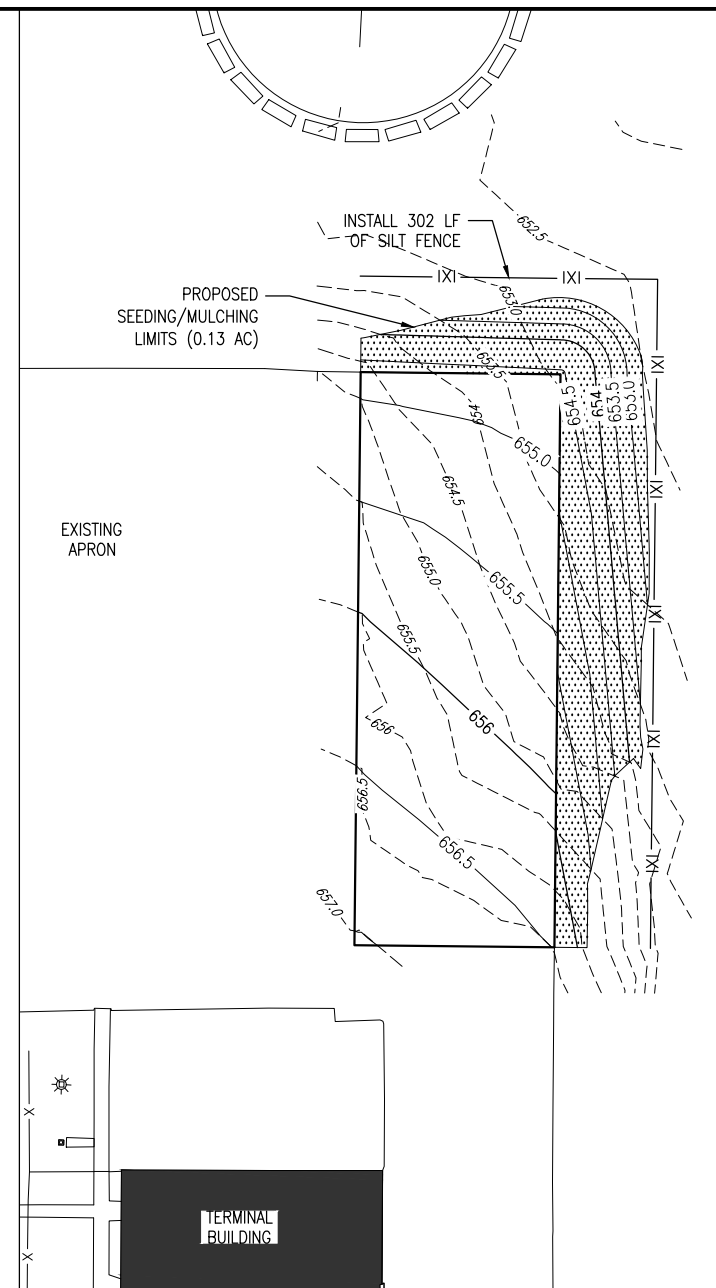

PROPOSED SWPP PLAN


STORM WATER POLLUTION PREVENTION NOTES

1. THE CONTRACTOR SHALL IMPLEMENT ALL PROVISIONS OF THE CONTRACT DOCUMENTS TO ASSURE THAT STORM WATER POLLUTION PREVENTION ITEMS ARE CONSTRUCTED AND MAINTAINED IN A TIMELY MANNER. SEDIMENTATION MUST NOT BE TRANSPORTED OFF THE CONSTRUCTION SITE. PERMANENT DRAINAGE FEATURES AND VEGETATIVE MEASURES SHALL BE PROVIDED AS SOON AS POSSIBLE.
2. THE CONTRACTOR SHALL BE REQUIRED TO IMPLEMENT AND MAINTAIN STORM WATER POLLUTION PREVENTION PRACTICES AND MEASURES PRIOR TO THE STRIPPING OF EXISTING VEGETATION WHERE EVER POSSIBLE AND AS SOON AS CONSTRUCTION PERMITS IN OTHER AREAS. POLLUTION CONTROL MEASURES SHALL BE IN ACCORDANCE WITH THE CONTRACT DOCUMENTS, INCLUDING THESE CONSTRUCTION PLANS, AND WITH STANDARDS AND SPECIFICATIONS FOR SOIL EROSION AND SEDIMENT CONTROL, ILLINOIS ENVIRONMENTAL PROTECTION AGENCY, CURRENT ISSUE. THE CONTRACTOR SHALL ADJUST HIS OPERATIONS AND IMPLEMENT POLLUTION CONTROL MEASURES SO THAT NO RUNOFF FROM STRIPPED AREAS WILL LEAVE THE CONSTRUCTION SITE OTHER THAN THROUGH SEDIMENT TRAPS OR OTHER SUITABLE CONTROL MEASURES.
3. POLLUTION CONTROL ITEMS SHALL BE PROVIDED AS NOTED ON THE STORM WATER POLLUTION PREVENTION PLAN AND IN THE STORM WATER POLLUTION PREVENTION DETAILS AND AS DIRECTED BY THE ENGINEER. THE LIMITS OF SUCH MEASURES SHALL BE STAKED BY THE CONTRACTOR PRIOR TO THE COMMENCEMENT OF CONSTRUCTION. SUCH LIMITS MAY BE ADJUSTED BY THE ENGINEER TO ACCOUNT FOR ACTUAL SITE CONDITIONS EXPERIENCED DURING CONSTRUCTION. ADDITIONAL COMPENSATION FOR MEASURES EXCEEDING THE PLAN QUANTITIES WILL BE PAID FOR AT THE CONTRACT UNIT PRICE FOR EACH ITEM.
4. THE CONTRACTOR IS TO MAINTAIN AND ADJUST, REPAIR OR REPLACE ALL POLLUTION PREVENTION MEASURES AS REQUIRED OR AS DIRECTED BY THE ENGINEER UNTIL PERMANENT VEGETATION HAS BEEN ESTABLISHED. MAINTENANCE OF POLLUTION CONTROL MEASURES IS TO BE PROVIDED AT NO ADDITIONAL COST TO THE CONTRACT.

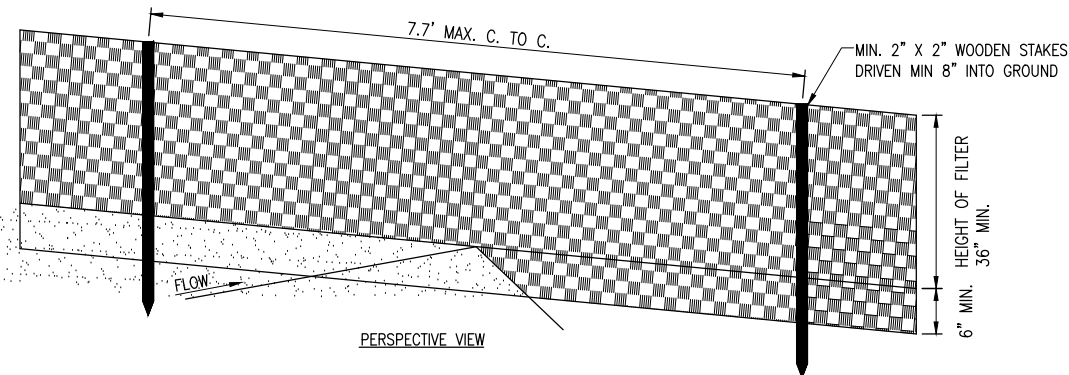


SILT FENCE DETAIL

NO SCALE

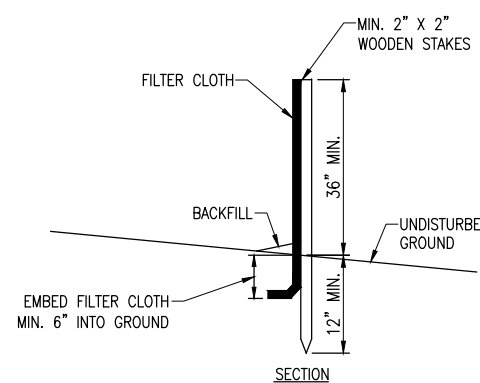

SECTION

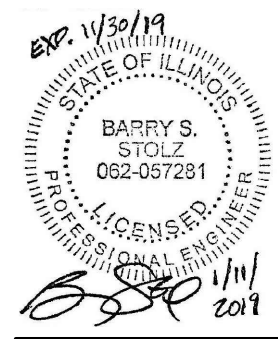

EAST AIRCRAFT
PARKING RAMP
EXPANSION &
REHABILITATE PARTIAL
PARALLEL TAXIWAY TO
RUNWAY 9/27

IDA No: PRG-4558

Contract No. ED019

NO.	DATE	DESCRIPTION		
		LAY	DWN	REV

ISSUE: JANUARY 11, 2019

PROJECT NO: 17A0016D

CAD FILE: C-181-STK.DWG

 
 
LAYOUT BY: JRH 11/30/2018

DRAWN BY: JRH 11/30/2018

REVIEWED BY: BSS 01/11/2019



SHEET TITLE

**PROPOSED STAKING
& SWPP PLAN - EAST
APRON**




LEGEND

- EXISTING IMPROVEMENTS
- PROPOSED IMPROVEMENTS
- EXISTING BUILDINGS

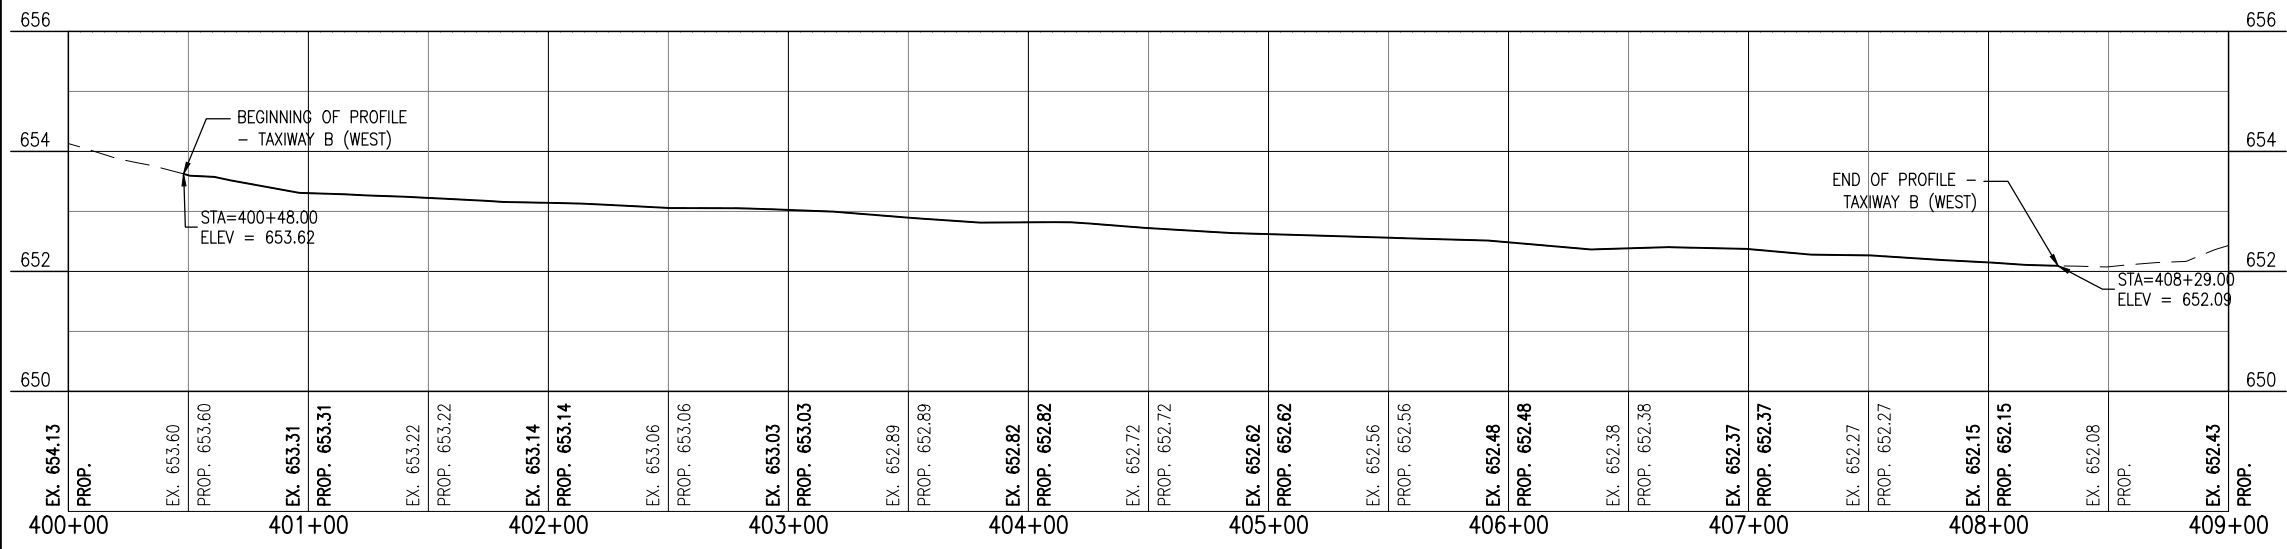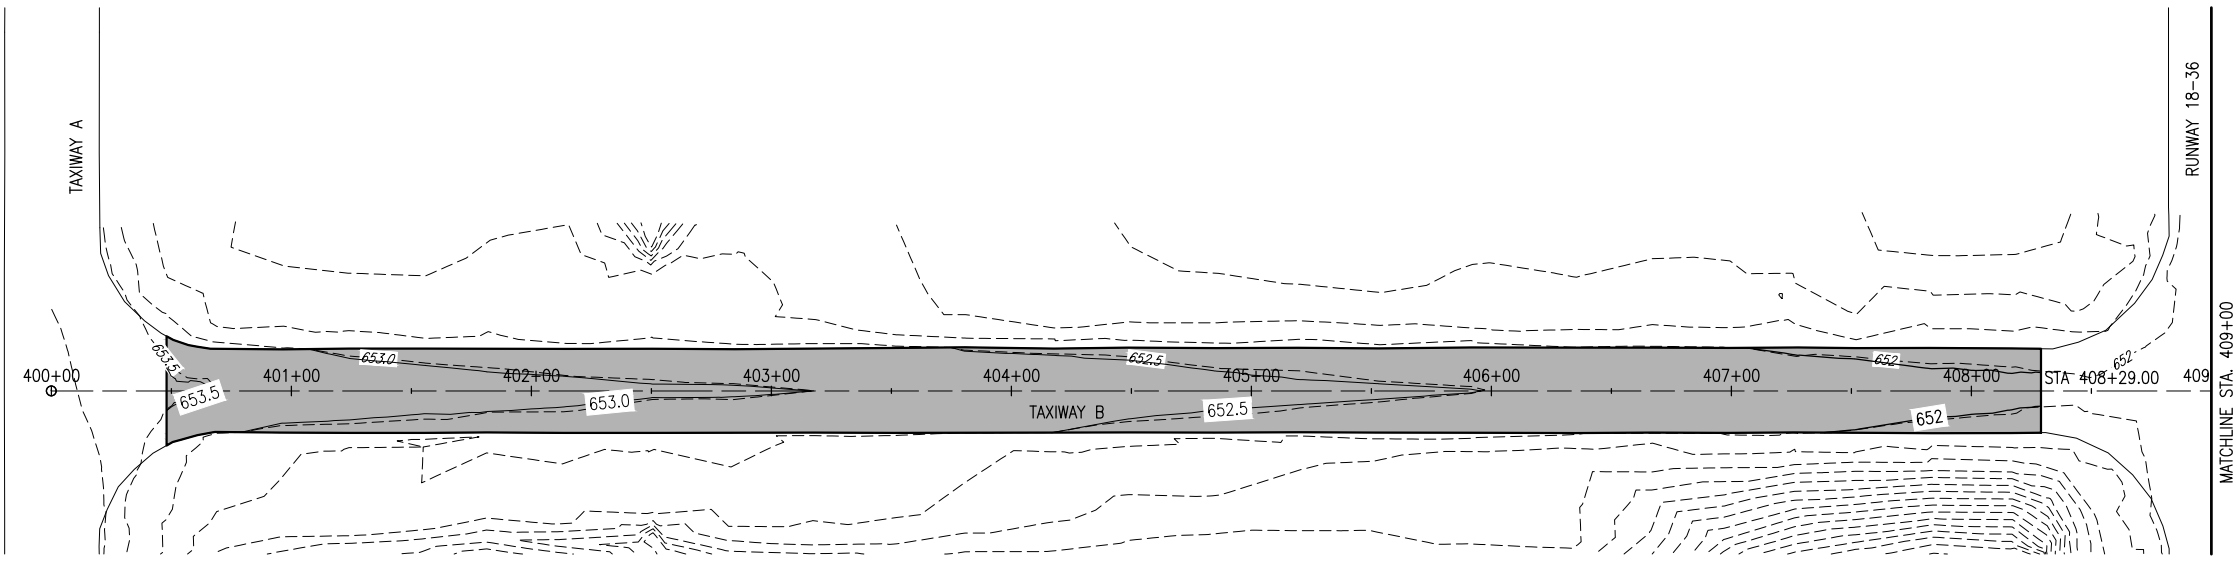

PROFILE - TAXIWAY B (WEST)

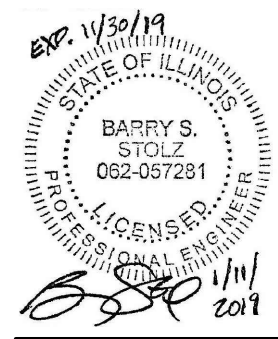

EAST AIRCRAFT
PARKING RAMP
EXPANSION &
REHABILITATE PARTIAL
PARALLEL TAXIWAY TO
RUNWAY 9/27

IDA No: PRG-4558


Contract No. ED019

NO.	DATE	DESCRIPTION		
		LAY	DWN	REV



ISSUE: JANUARY 11, 2019
PROJECT NO: 17A0016D
CAD FILE: C-701-PNP.DWG
LAYOUT BY: JRH 11/30/2018
DRAWN BY: JRH 11/30/2018
REVIEWED BY: BSS 01/11/2019

SHEET TITLE


PROPOSED PLAN
AND PROFILE -
PARALLEL TAXIWAY
(WEST)

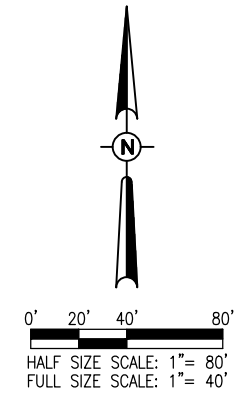


- LEGEND**
- EXISTING IMPROVEMENTS
 - PROPOSED IMPROVEMENTS
 - EXISTING BUILDINGS

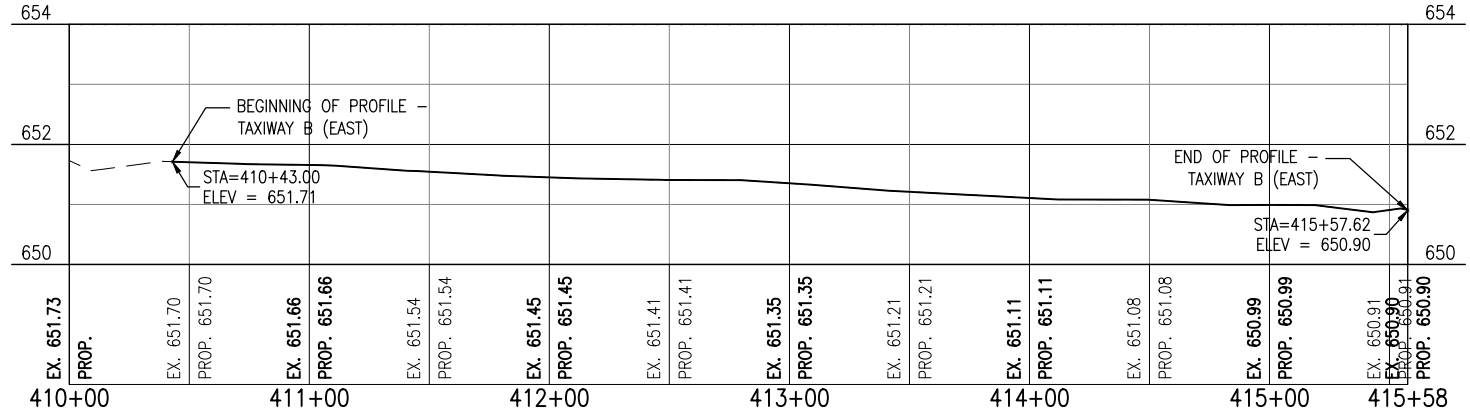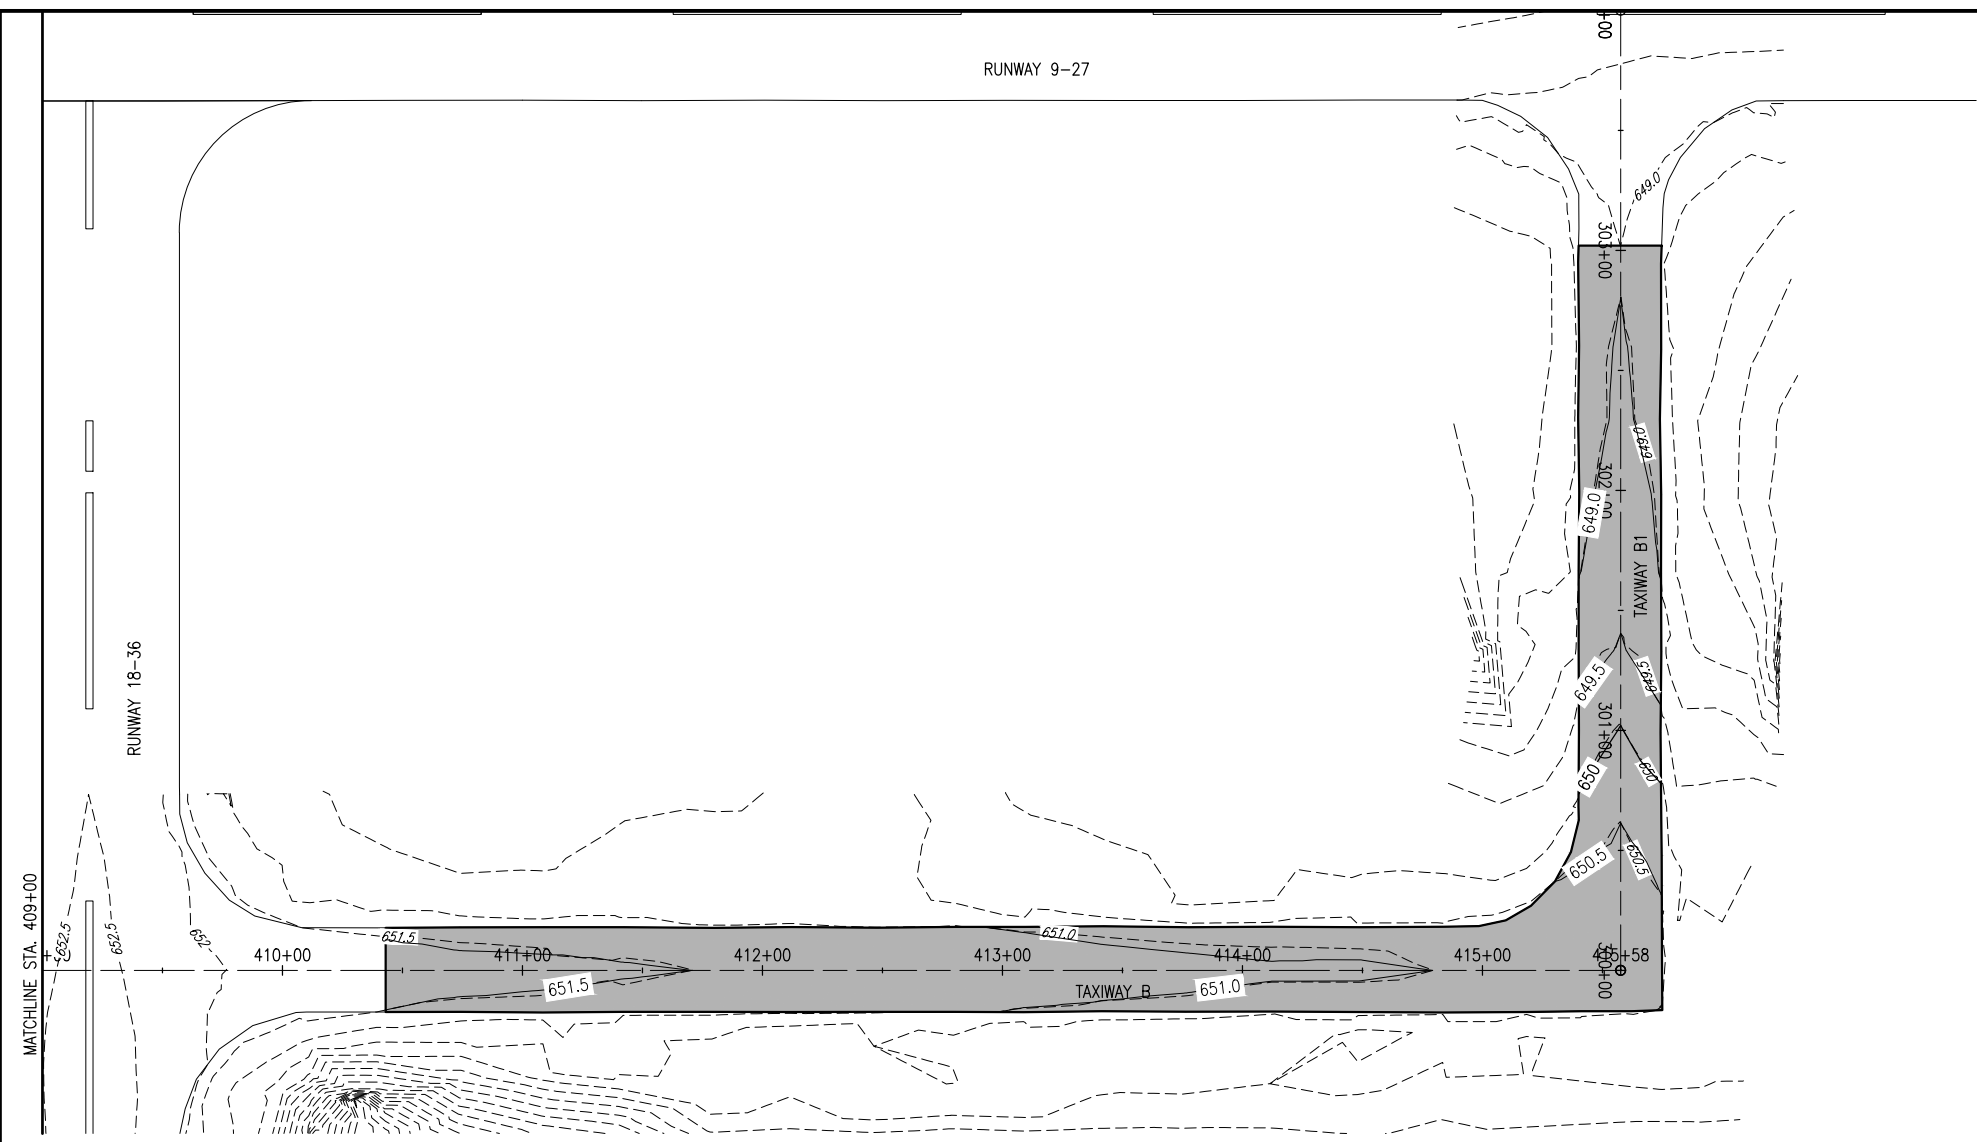

PROFILE - TAXIWAY B (EAST)

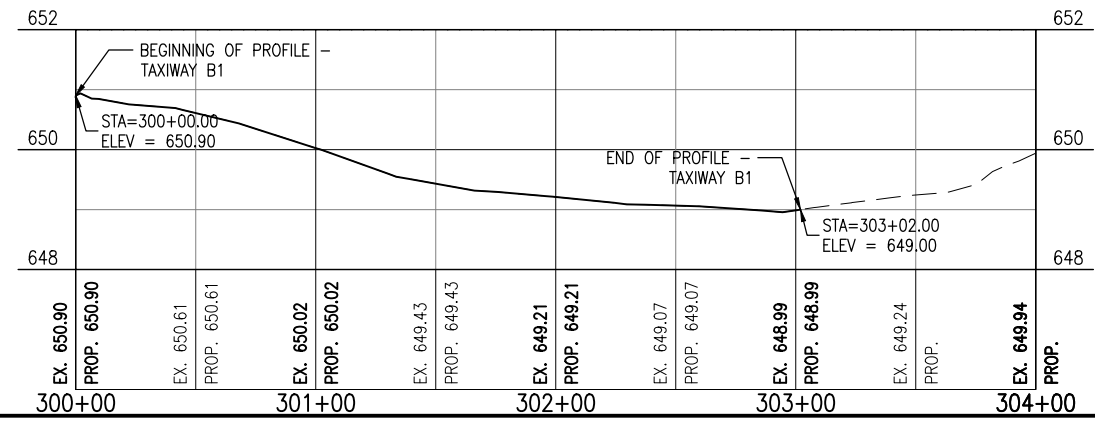

PROFILE - TAXIWAY B1

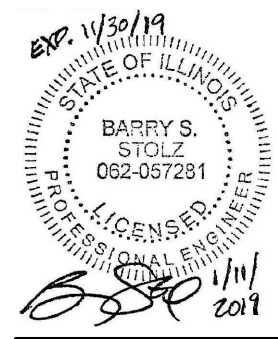

**EAST AIRCRAFT
PARKING RAMP
EXPANSION &
REHABILITATE PARTIAL
PARALLEL TAXIWAY TO
RUNWAY 9/27**

IDA No: PRG-4558




Contract No. ED019

NO.	DATE	DESCRIPTION		
		LAY	DWN	REV

ISSUE: JANUARY 11, 2019
PROJECT NO: 17A0016D
CAD FILE: C-701-PNP.DWG
LAYOUT BY: JRH 11/30/2018
DRAWN BY: JRH 11/30/2018
REVIEWED BY: BSS 01/11/2019

SHEET TITLE

**PROPOSED PLAN
AND PROFILE -
PARALLEL TAXIWAY
(EAST)**

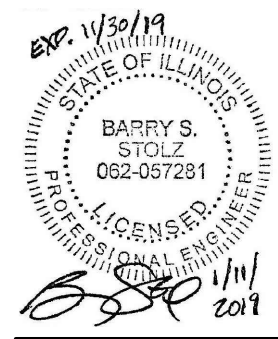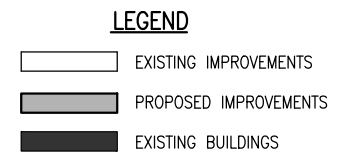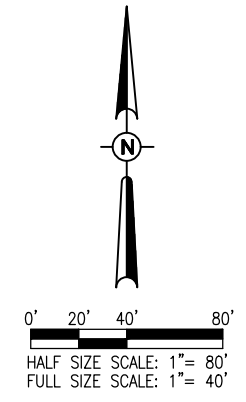

EAST AIRCRAFT
PARKING RAMP
EXPANSION &
REHABILITATE PARTIAL
PARALLEL TAXIWAY TO
RUNWAY 9/27

IDA No: PRG-4558

Contract No. ED019

NO.	DATE	DESCRIPTION		
		LAY	DWN	REV

ISSUE: JANUARY 11, 2019

PROJECT NO: 17A0016D

CAD FILE: C-151-MRK.DWG

LAYOUT BY: JRH 11/30/2018


DRAWN BY: JRH 11/30/2018

REVIEWED BY: BSS 01/11/2019

SHEET TITLE


PROPOSED MARKING
PLAN

JAN 22, 2019 2:07 PM STOLZ01647
I:\17\JOB\17A0016D\CAD\AIRPORT\151-MRK.DWG

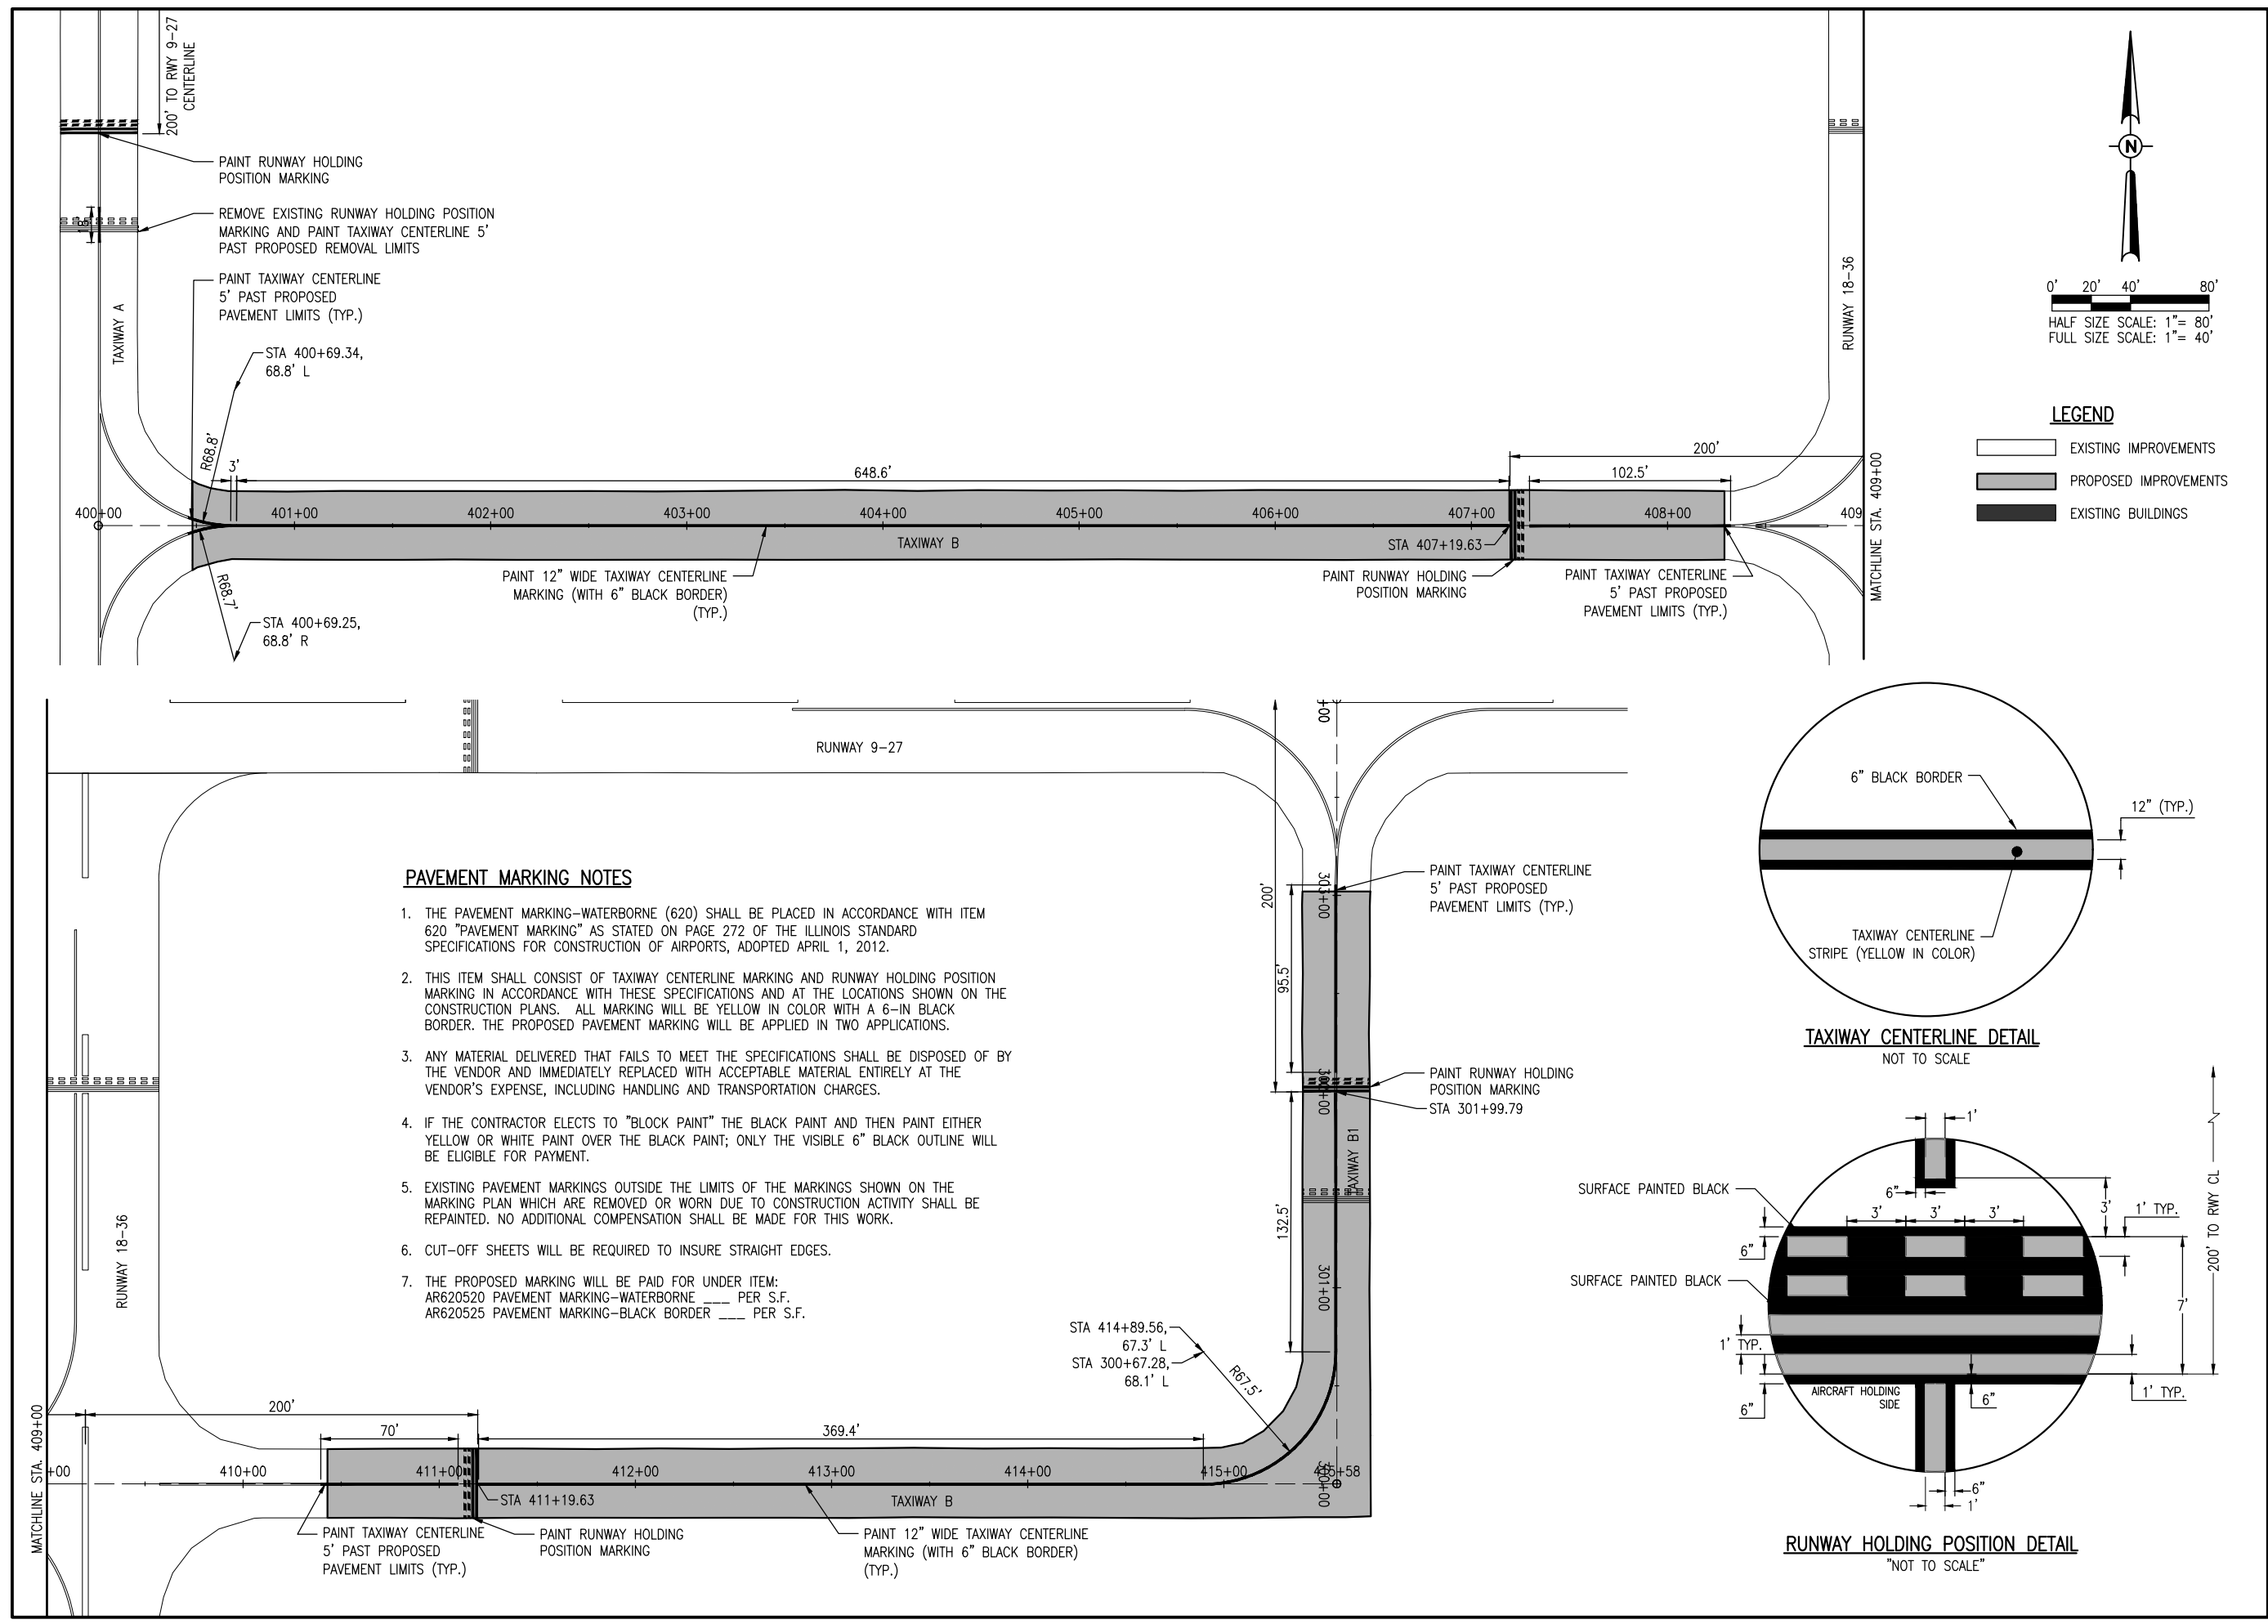


PAVEMENT MARKING NOTES



1. THE PAVEMENT MARKING-WATERBORNE (620) SHALL BE PLACED IN ACCORDANCE WITH ITEM 620 "PAVEMENT MARKING" AS STATED ON PAGE 272 OF THE ILLINOIS STANDARD SPECIFICATIONS FOR CONSTRUCTION OF AIRPORTS, ADOPTED APRIL 1, 2012.
2. THIS ITEM SHALL CONSIST OF TAXIWAY CENTERLINE MARKING AND RUNWAY HOLDING POSITION MARKING IN ACCORDANCE WITH THESE SPECIFICATIONS AND AT THE LOCATIONS SHOWN ON THE CONSTRUCTION PLANS. ALL MARKING WILL BE YELLOW IN COLOR WITH A 6-IN BLACK BORDER. THE PROPOSED PAVEMENT MARKING WILL BE APPLIED IN TWO APPLICATIONS.
3. ANY MATERIAL DELIVERED THAT FAILS TO MEET THE SPECIFICATIONS SHALL BE DISPOSED OF BY THE VENDOR AND IMMEDIATELY REPLACED WITH ACCEPTABLE MATERIAL ENTIRELY AT THE VENDOR'S EXPENSE, INCLUDING HANDLING AND TRANSPORTATION CHARGES.
4. IF THE CONTRACTOR ELECTS TO "BLOCK PAINT" THE BLACK PAINT AND THEN PAINT EITHER YELLOW OR WHITE PAINT OVER THE BLACK PAINT; ONLY THE VISIBLE 6" BLACK OUTLINE WILL BE ELIGIBLE FOR PAYMENT.
5. EXISTING PAVEMENT MARKINGS OUTSIDE THE LIMITS OF THE MARKINGS SHOWN ON THE MARKING PLAN WHICH ARE REMOVED OR WORN DUE TO CONSTRUCTION ACTIVITY SHALL BE REPAINTED. NO ADDITIONAL COMPENSATION SHALL BE MADE FOR THIS WORK.
6. CUT-OFF SHEETS WILL BE REQUIRED TO INSURE STRAIGHT EDGES.
7. THE PROPOSED MARKING WILL BE PAID FOR UNDER ITEM:
AR620520 PAVEMENT MARKING-WATERBORNE ___ PER S.F.
AR620525 PAVEMENT MARKING-BLACK BORDER ___ PER S.F.

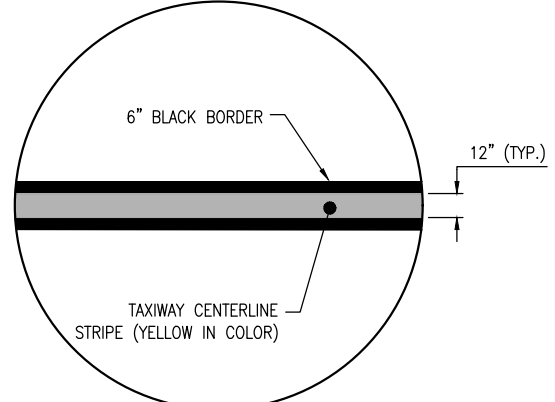


TAXIWAY CENTERLINE DETAIL
NOT TO SCALE

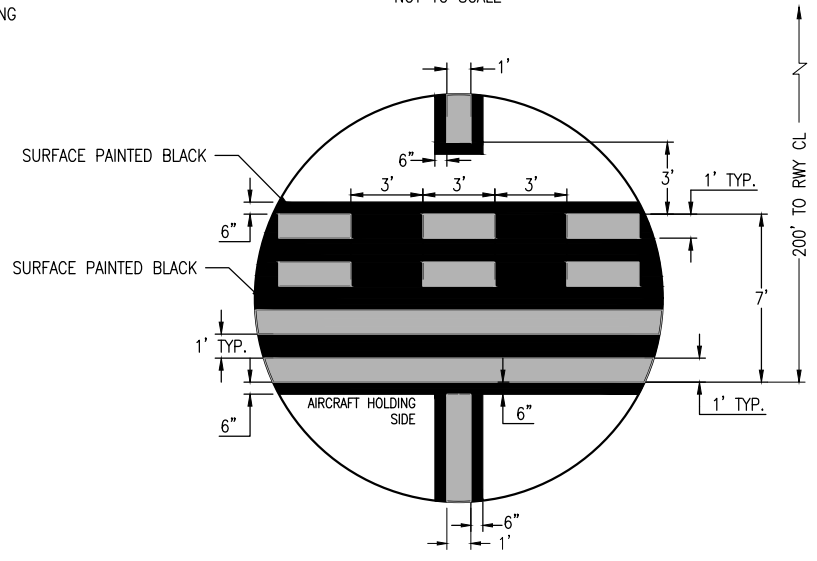

RUNWAY HOLDING POSITION DETAIL
"NOT TO SCALE"

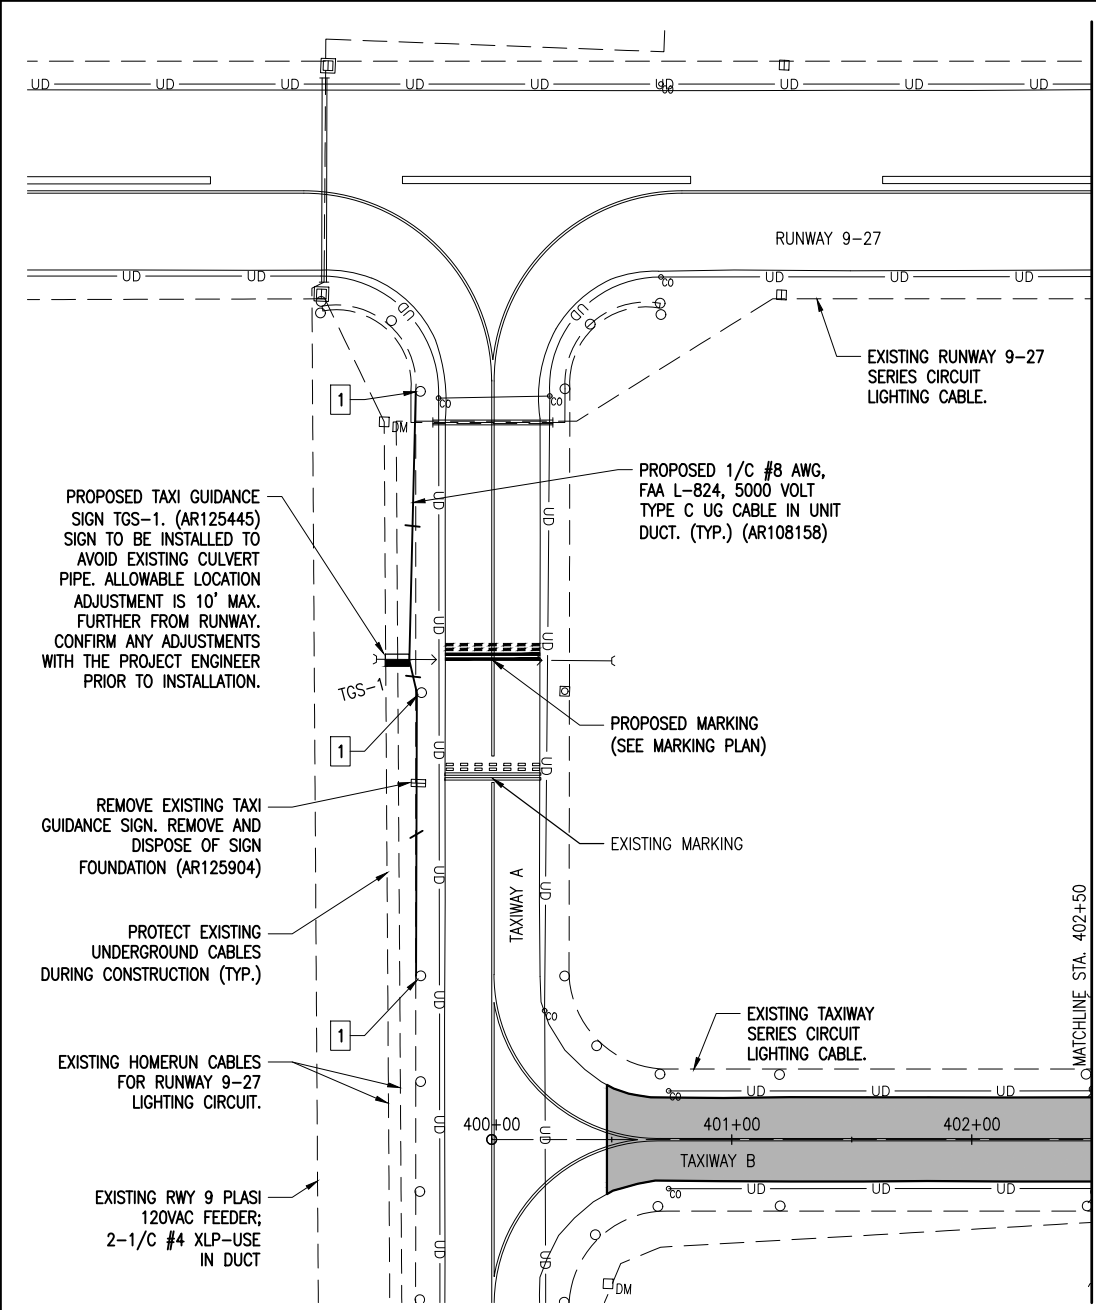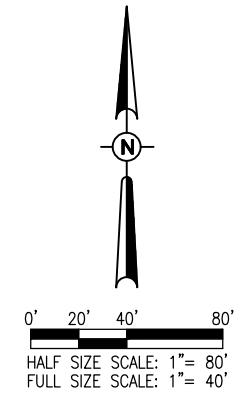

GUIDANCE SIGN PLAN - TAXIWAY A

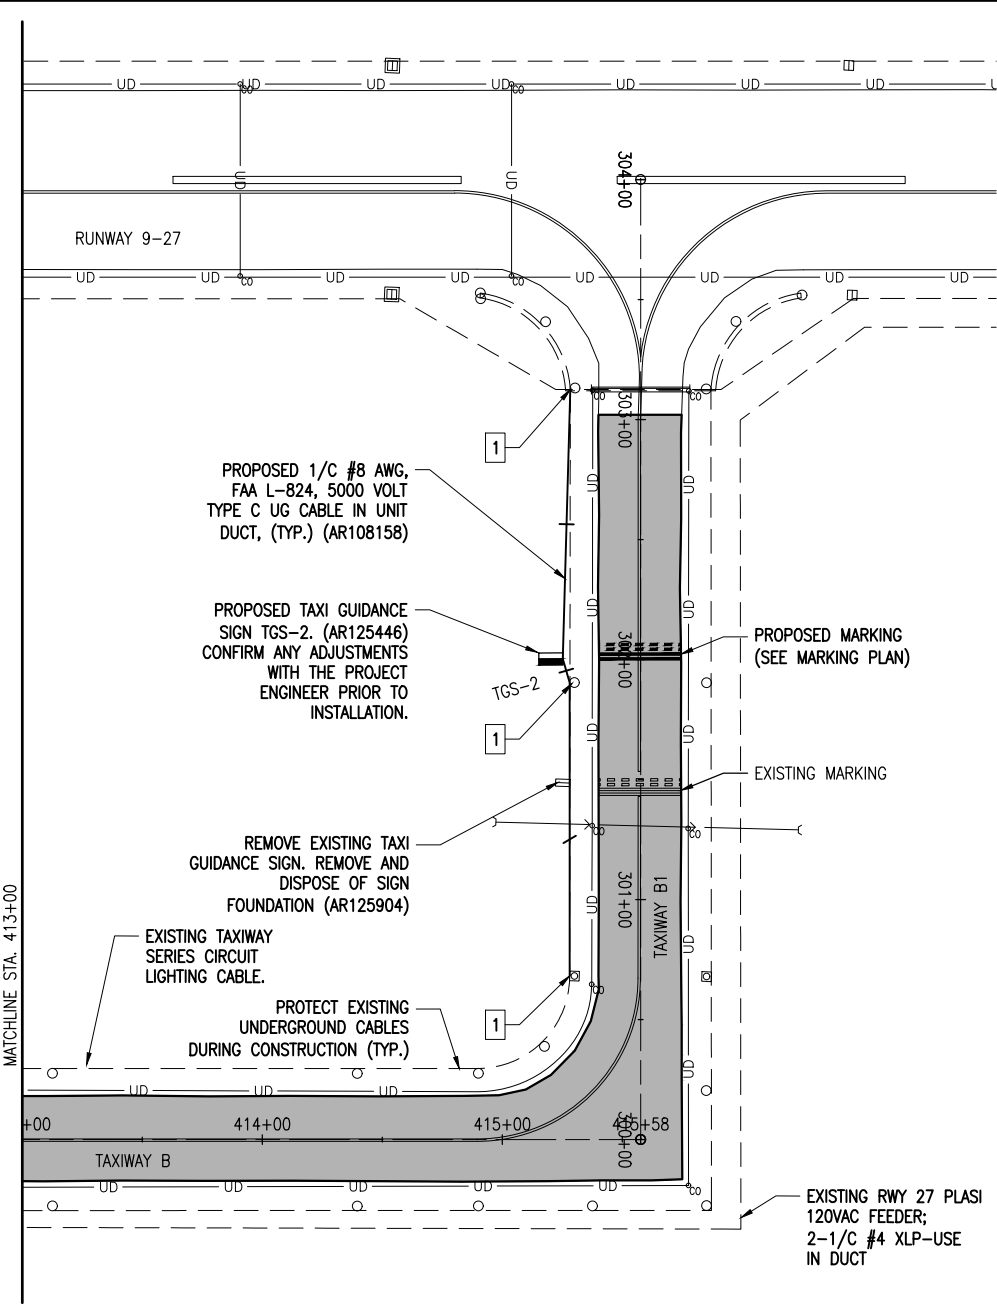

GUIDANCE SIGN PLAN - TAXIWAY B1

LEGEND

- EXISTING PAVEMENT
- PROPOSED IMPROVEMENTS
- EXISTING ELECTRICAL DUCT
- EXISTING UNDERDRAIN
- EXISTING RUNWAY/TAXIWAY CIRCUIT
- PROPOSED 1/C #8 AWG, FAA L-824, 5000 VOLT TYPE C UNDERGROUND CABLE IN UNIT DUCT
- EXISTING STAKE MOUNTED TAXIWAY LIGHT
- EXISTING BASE MOUNTED TAXIWAY LIGHT
- EXISTING STAKE MOUNTED RUNWAY LIGHT
- EXISTING BASE MOUNTED RUNWAY LIGHT
- EXISTING TAXI GUIDANCE SIGN
- PROPOSED TAXI GUIDANCE SIGN

NOTES

1. SEE AIRFIELD LIGHTING NOTES SHEET.
2. CONTRACTOR SHALL FIELD VERIFY RESPECTIVE CIRCUITS AND POWER SOURCES PRIOR TO REMOVING, DISCONNECTING, RELOCATING, WORKING ON, INSTALLING, AND/OR CONNECTING THE RESPECTIVE AIRFIELD LIGHTING, TAXI SIGN, NAVAID, OR OTHER DEVICE.
3. CONTRACTOR SHALL COMPLY WITH THE REQUIREMENTS OF FAA AC NO. 150/5370-2G (OR MOST CURRENT ISSUE) "OPERATIONAL SAFETY ON AIRPORTS DURING CONSTRUCTION".
4. CONTRACTOR SHALL COMPLY WITH THE APPLICABLE REQUIREMENTS OF NFPA 70E - STANDARD FOR ELECTRICAL SAFETY IN THE WORKPLACE.

KEYED NOTES

- 1 INTERFACE/CONNECT NEW CABLES TO EXISTING LIGHT (INCIDENTAL)

THE LOCATION, SIZE, AND TYPE OF MATERIAL OF EXISTING UNDERGROUND AND/OR ABOVEGROUND UTILITIES INDICATED ON THE PLANS ARE NOT REPRESENTED AS BEING ACCURATE, SUFFICIENT OR COMPLETE. NEITHER THE OWNER NOR THE ENGINEER ASSUMES ANY RESPONSIBILITY WHATSOEVER IN RESPECT TO THE ACCURACY, COMPLETENESS, OR SUFFICIENCY OF THE INFORMATION. THERE IS NO GUARANTEE, EITHER EXPRESSED OR IMPLIED, THAT THE LOCATIONS, SIZE AND TYPE OF MATERIAL OF EXISTING UNDERGROUND UTILITIES INDICATED ARE REPRESENTATIVE OF THOSE TO BE ENCOUNTERED IN THE CONSTRUCTION. IT SHALL BE THE CONTRACTOR'S RESPONSIBILITY TO DETERMINE THE ACTUAL LOCATION OF ALL SUCH FACILITIES, INCLUDING SERVICE CONNECTIONS TO UNDERGROUND UTILITIES. PRIOR TO CONSTRUCTION, THE CONTRACTOR SHALL NOTIFY THE UTILITY COMPANIES OF HIS OPERATIONAL PLANS AND SHALL OBTAIN FROM THE RESPECTIVE UTILITY COMPANIES DETAILED INFORMATION AND ASSISTANCE RELATIVE TO THE LOCATION OF THEIR FACILITIES AND THE WORKING SCHEDULE OF THE COMPANIES FOR REMOVAL OR ADJUSTMENT WHERE REQUIRED. IN THE EVENT AN UNEXPECTED UTILITY INTERFERENCE IS ENCOUNTERED DURING CONSTRUCTION, THE CONTRACTOR SHALL IMMEDIATELY NOTIFY THE UTILITY COMPANY OF JURISDICTION. THE OWNER'S REPRESENTATIVE AND/OR THE RESIDENT ENGINEER/TECHNICIAN SHALL ALSO BE IMMEDIATELY NOTIFIED. ANY DAMAGE TO SUCH MAINS AND SERVICES SHALL BE RESTORED TO SERVICE AT ONCE AND PAID FOR BY THE CONTRACTOR AT NO ADDITIONAL COST TO THE CONTRACT.

ALL UTILITY CABLES AND LINES SHALL BE LOCATED BY THE RESPECTIVE UTILITY. CONTACT JULIE (JOINT UTILITY LOCATION INFORMATION FOR EXCAVATORS) FOR UTILITY INFORMATION, PHONE: 1-800-892-0123. CONTACT THE FAA (FEDERAL AVIATION ADMINISTRATION) FOR ASSISTANCE IN LOCATING FAA CABLES AND UTILITIES. LOCATION OF FAA POWER, CONTROL, AND COMMUNICATION CABLES SHALL BE COORDINATED WITH AND/OR LOCATED BY THE FAA. ALSO CONTACT AIRPORT DIRECTOR/MANAGER AND AIRPORT PERSONNEL FOR ASSISTANCE IN LOCATING UNDERGROUND AIRPORT CABLES AND/OR UTILITIES. ALSO COORDINATE WORK WITH ALL ABOVEGROUND UTILITIES.



EAST AIRCRAFT
PARKING RAMP
EXPANSION &
REHABILITATE PARTIAL
PARALLEL TAXIWAY TO
RUNWAY 9/27

IDA No: PRG-4558

Contract No. ED019

NO.	DATE	DESCRIPTION		
		LAY	DWN	REV

ISSUE: JANUARY 11, 2019
PROJECT NO: 17A0016D
CAD FILE: E-401-ELEC.DWG
LAYOUT BY: JRH 11/30/2018
DRAWN BY: JRH 11/30/2018
REVIEWED BY: BSS 01/11/2019

SHEET TITLE

PROPOSED
ELECTRICAL PLAN

AIRFIELD LIGHTING REMOVAL, RELOCATION, AND INSTALLATION NOTES

1. KEEP ALL WORK, POWER OUTAGES, AND/OR SHUT DOWN OF EXISTING SYSTEMS COORDINATED WITH THE AIRPORT DIRECTOR/MANAGER. ONCE SHUT DOWN, THE CIRCUITS SHALL BE LABELED AS SUCH TO PREVENT ACCIDENTAL ENERGIZING OF THE RESPECTIVE CIRCUITS. ALL PERSONNEL SHALL FOLLOW U.S. DEPARTMENT OF LABOR OCCUPATIONAL SAFETY & HEALTH ADMINISTRATION (OSHA) 29 CFR PART 1910 OCCUPATIONAL SAFETY & HEALTH STANDARDS FOR ELECTRICAL SAFETY AND LOCKOUT/TAGOUT PROCEDURES INCLUDING, BUT NOT LIMITED TO, 29 CFR SECTION 1910.147 THE CONTROL OF HAZARDOUS ENERGY (LOCKOUT/TAGOUT).
2. EXAMINE THE SITE TO DETERMINE THE EXTENT OF THE WORK. CONTRACTOR SHALL FIELD VERIFY EXISTING SITE CONDITIONS.
3. VERIFY RESPECTIVE CIRCUITS AND POWER SOURCES PRIOR TO REMOVING, DISCONNECTING, RELOCATING, INSTALLING, OR CONNECTING THE RESPECTIVE AIRFIELD LIGHTING, TAXI SIGN, NAVAID, OR OTHER DEVICE.
4. INSTALL AIRFIELD LIGHTS, TAXIWAY LIGHTS, GUIDANCE SIGNS, OTHER AIRFIELD LIGHTING, SPLICE CANS, HANDHOLES, MANHOLES, ELECTRICAL DUCTS, AND CABLE AT THE LOCATIONS SHOWN AND IN COMPLIANCE WITH THE SPECIFICATIONS, SPECIAL PROVISIONS, RESPECTIVE DETAILS, AND MANUFACTURER'S RECOMMENDATIONS.
5. NEW CABLE FOR RUNWAY AND TAXIWAY LIGHTING CABLE IN AREAS ALONG THE RESPECTIVE PAVEMENT SHALL BE INSTALLED APPROXIMATELY 10' TO 14' FROM THE PAVEMENT EDGE. CABLES SHALL BE PLACED A MINIMUM OF 18" BELOW FINISHED GRADE.
6. LIGHTING CABLE FOR RUNWAY AND TAXIWAY LIGHTING SHALL BE 1/C, #8 AWG, FAA L-824, 5000 VOLT, TYPE C UNDERGROUND CABLE IN DUCT OR RACEWAY.
7. IN AREAS WHERE THERE IS A CONGESTION OF CABLES OR WHERE THE PROPOSED CABLE CROSSES AN EXISTING CABLE, THE CONTRACTOR IS REQUIRED TO HAND DIG THE TRENCH NECESSARY FOR THE PROPOSED CABLE. AT OTHER LOCATIONS, THE PROPOSED CABLE MAY BE TRENCHED OR PLOWED INTO PLACE. HAND DIGGING, TRENCHING AND/OR PLOWING WILL BE CONSIDERED INCIDENTAL TO THE PROPOSED CABLES AND NO ADDITIONAL COMPENSATION WILL BE ALLOWED.
8. GROUND ROD MUST BE INSTALLED AT EACH LIGHT FIXTURE AND TAXI SIGN. THE PURPOSE OF THE LIGHT BASE GROUND IS PROVIDE A DEGREE OF PROTECTION FOR MAINTENANCE PERSONNEL FROM POSSIBLE CONTACT WITH AN ENERGIZED LIGHT BASE OR MOUNTING STAKE THAT MAY RESULT FROM A SHORTED POWER CABLE OR ISOLATION TRANSFORMER. PER NATIONAL ELECTRICAL CODE ARTICLE 250.53 "GROUNDING ELECTRODE SYSTEM INSTALLATION" RESISTANCE FROM THE GROUND ROD/ELECTRODE TO EARTH GROUND MUST BE 25 OHMS OR LESS VIA MEASUREMENT WITH A GROUND TESTER. GROUNDS RODS FOR LIGHT BASE GROUNDS SHALL BE 3/4-INCH BY 10-FOOT MINIMUM LENGTH UL LISTED COPPER-CLAD STEEL SECTIONAL RODS. GROUND RODS SHALL BE PRODUCED FROM 100% DOMESTIC STEEL. EACH GROUND ROD SHALL BE TESTED AND THE RESULTS RECORDED FOR EACH AIRFIELD LIGHT FIXTURE AND TAXI SIGN INSTALLATION. COPIES OF GROUND SYSTEM TEST RESULTS SHALL BE FURNISHED TO THE PROJECT ENGINEER AND/OR THE RESIDENT ENGINEER/TECHNICIAN.
9. HOMERUN CABLES FOR A RESPECTIVE CIRCUIT THAT ARE INSTALLED IN CONDUIT OR DUCT SHALL BE RUN TOGETHER IN THE SAME RACEWAY OR DUCT.
10. THE RESPECTIVE RUNWAY AND TAXIWAY LIGHTING CCR'S (FOR THE AREAS OF WORK ON THIS PROJECT) SHALL BE TESTED FOR PROPER OPERATION BEFORE REMOVAL WORK, MODIFICATIONS, AND/OR ADDITIONS AND AFTER THE NEW CABLES AND LIGHTING SYSTEM MODIFICATIONS AND ADDITIONS HAVE BEEN COMPLETED. CONTRACTOR SHALL TEST AND RECORD THE INPUT CURRENT AND OUTPUT CURRENT FOR EACH CONSTANT CURRENT REGULATOR IN THE AUTOMATIC AND MANUAL MODES OF OPERATIONS. CONTRACTOR SHALL REPORT CONCERNS AND/OR DEFICIENCIES TO THE RESIDENT ENGINEER/TECHNICIAN. TEST RESULTS SHALL BE PROVIDED TO THE PROJECT ENGINEER AND RESIDENT ENGINEER/TECHNICIAN.
11. FAA AC 150/5370-106 "STANDARDS FOR SPECIFYING CONSTRUCTION OF AIRPORTS", ITEM L-108 "UNDERGROUND POWER CABLE FOR AIRPORTS", REQUIRES THAT EVERY AIRFIELD LIGHTING CABLE SPLICER SHALL BE QUALIFIED IN MAKING CABLE SPLICES AND TERMINATIONS ON CABLES RATED ABOVE 5,000 VOLTS AC. CABLE SPLICING/TERMINATING PERSONNEL SHALL HAVE A MINIMUM OF THREE (3) YEARS CONTINUOUS EXPERIENCE IN TERMINATING/SPLICING MEDIUM VOLTAGE CABLE.
12. OTHER CONSTRUCTION PROJECTS MIGHT BE IN PROGRESS AT THE AIRPORT AT THE SAME TIME AS THIS PROJECT. THE CONTRACTOR WILL BE REQUIRED TO COOPERATE WITH ALL OTHER CONTRACTORS AND THE AIRPORT MANAGER IN THE COORDINATION OF THE WORK.
13. OBTAIN APPROVAL FROM THE AIRPORT MANAGER PRIOR TO SHUTTING DOWN A RUNWAY OR TAXIWAY. WHEN A RESPECTIVE RUNWAY IS CLOSED THE RESPECTIVE RUNWAY LIGHTING AND NAVAIDS FOR THAT RUNWAY SHALL BE SHUT OFF. WHEN A RESPECTIVE TAXIWAY IS CLOSED THE RESPECTIVE TAXIWAY LIGHTING FOR THAT TAXIWAY SHALL BE SHUT OFF.
14. THE CONTRACTOR IS REQUIRED TO FILL IN ALL HOLES AND DEPRESSIONS RESULTING FROM THE NEW WORK, WITH EARTH MATERIAL. THE AREAS SHALL BE COMPACTED TO PREVENT FUTURE SETTLEMENT AND FERTILIZED, SEEDED, AND MULCHED IN ACCORDANCE WITH ITEMS 901 AND 908 RESPECTIVELY.
15. IN THE EVENT A CONFLICT IS DETERMINED WITH RESPECT TO MANUFACTURER INSTALLATION INSTRUCTIONS, NEC, AND/OR THE CONTRACT DOCUMENTS, CONTACT THE PROJECT ENGINEER FOR FURTHER DIRECTION.

16. SIGNS AND/OR AIRFIELD LIGHTS, INCLUDING TRANSFORMERS AND MOUNTING HARDWARE, THAT ARE DESIGNATED FOR REMOVAL SHALL BE REMOVED AND TURNED OVER TO THE AIRPORT. EXISTING SIGN FOUNDATIONS TO BE REMOVED SHALL BE DISPOSED OF OFF THE AIRPORT SITE IN A LEGAL MANNER.
17. EXISTING DUCTS AND CABLES ASSOCIATED WITH AIRFIELD LIGHTING REMOVALS, RELOCATIONS, AND/OR CABLE OR DUCT REPLACEMENTS SHALL BE ABANDONED IN PLACE UNLESS IT CONFLICTS WITH THE INSTALLATION OF A PROPOSED LIGHT OR CABLE, PAVEMENT, OR OTHER WORK, THEN IT SHALL BE REMOVED AND DISPOSED OF OFF SITE AT NO ADDITIONAL COST TO THE CONTRACT. CONTRACTOR MAY REMOVE ABANDONED CABLES AT NO ADDITIONAL COST TO THE CONTRACT AND SHALL HAVE THE SALVAGE RIGHTS TO ABANDONED CABLES.
18. OWNER HAS THE RIGHT OF FIRST REFUSAL REGARDING AIRFIELD LIGHTS AND SIGNS DESIGNATED FOR REMOVAL. IN THE EVENT THE OWNER DOES NOT WANT THE RESPECTIVE AIRFIELD LIGHTS AND/OR SIGNS DESIGNATED FOR REMOVAL, THE CONTRACTOR SHALL DISPOSE OF THEM OFF THE AIRPORT SITE IN A LEGAL MANNER.
19. ROUTE NEW CABLES AND DUCTS TO AVOID INTERFERENCES WITH OTHER UTILITIES, LINES, AND STRUCTURES.
20. ALL ABOVEGROUND JUMPERS SHALL BE IN A DUCT WITH ALL CONNECTIONS SEALED. THE CONTRACTOR SHALL SECURE, IDENTIFY AND PLACE ALL TEMPORARY EXPOSED WIRING IN CONDUIT, DUCT, OR UNIT DUCT TO PREVENT ELECTROCUTION AND FIRE IGNITION SOURCES AS PER THE REQUIREMENTS OF FAA 150/5370-2G, OPERATION SAFETY ON AIRPORTS DURING CONSTRUCTION, SECTION 2.18.3 "LIGHTING AND VISUAL NAVAIDS". ALL LABOR, MATERIALS, AND TIME NECESSARY TO COMPLY WITH THIS REQUIREMENT SHALL BE CONSIDERED INCIDENTAL TO THE CONTRACT AND NO ADDITIONAL COMPENSATION WILL BE ALLOWED.
21. CONTRACTOR SHALL COMPLY WITH THE REQUIREMENTS OF FAA AC NO. 150/5370-2G (OR MOST CURRENT ISSUE) "OPERATIONAL SAFETY ON AIRPORTS DURING CONSTRUCTION".
22. CONTRACTOR SHALL COMPLY WITH THE APPLICABLE REQUIREMENTS OF NFPA 70E - STANDARD FOR ELECTRICAL SAFETY IN THE WORKPLACE.
23. WHEN A RESPECTIVE RUNWAY IS CLOSED THE NAVAIDS FOR THAT RUNWAY SHALL BE SHUT OFF.
24. CONTRACTOR SHALL INTERFACE EXISTING AIRFIELD LIGHTING AND/OR TAXI SIGNS TO THE NEW, REMOVED, REINSTALLED, ADJUSTED, REPLACED, AND/OR RELOCATED AIRFIELD LIGHTING AND ASSOCIATED CIRCUITS.
25. HIGH VOLTAGE CIRCUITS (AIRFIELD LIGHTING 5000 VOLT SERIES CIRCUITS AND OTHER CIRCUITS RATED ABOVE 600 VOLTS) AND LOW VOLTAGE CIRCUITS (RATED 600 VOLTS AND BELOW) SHALL NOT BE INSTALLED IN THE SAME WIREWAY, CONDUIT, DUCT, RACEWAY, JUNCTION STRUCTURE, OR HANDHOLE.
26. THE PROPOSED TAXI GUIDANCE SIGNS SHALL CONFORM TO ADVISORY CIRCULAR 150/5345 44 (CURRENT ISSUE IN EFFECT) AND BE FAA-APPROVED FOR TYPE L-858Y(L) DIRECTION, DESTINATION, AND BOUNDARY SIGNS (BLACK LEGEND ON YELLOW BACKGROUND); TYPE L-858R(L) MANDATORY INSTRUCTION SIGN (BLACK OUTLINE ON OUTSIDE EDGE OF WHITE LEGEND ON RED BACKGROUND); AND/OR TYPE L-858L(L) LOCATION SIGN (YELLOW LEGEND AND BORDER ON BLACK BACKGROUND). THE SIGNS SHALL BE SIZE 1, 18-IN. SIGN FACE WITH A 12-IN. LEGEND; STYLE 2, POWERED FROM A 4.8 TO 6.6 AMP SERIES LIGHTING CIRCUIT; CLASS 2, FOR OPERATION FROM -40 DEGREES F TO 131 DEGREES F; MODE 2, TO WITHSTAND WIND LOADS OF 200 M.P.H., BASE-MOUNTED, DOUBLE-SIDED, AS SPECIFIED ON THE PLANS. THE PROPOSED TAXI GUIDANCE SIGNS SHALL USE LED (LIGHT EMITTING DIODE) TYPE ILLUMINATION. ALSO SEE FAA ENGINEERING BRIEF 67 (MOST CURRENT ISSUE) "LIGHT SOURCES OTHER THAN INCANDESCENT AND XENON FOR AIRPORT AND OBSTRUCTION LIGHTING FIXTURES".
27. ALL SIGNS SHALL BE FURNISHED WITH TETHERS. TETHERS SHALL BE 3/16" STAINLESS STEEL AIRCRAFT CABLE WITH A FORMED EYE ON BOTH ENDS. THE TETHER EYE SHALL BE ATTACHED TO THE SIGN AND BASE BY BEING SANDWICHED BETWEEN TWO STAINLESS STEEL FENDER WASHERS, WITH A 1/2" MINIMUM STAINLESS STEEL BOLT. THE TETHER SHALL BE OF SUFFICIENT LENGTH TO HAVE A MINIMUM OF 6" OF SLACK WHEN ATTACHED BETWEEN THE SIGN AND THE SIGN BASE. THE TETHERS AND BONDING CONDUCTORS SHALL BE OF SUFFICIENT LENGTH TO ALLOW THE FRANGIBLE COUPLINGS TO OPERATE WITHOUT RESTRICTIONS AND TO ALLOW THE POWER CABLE TO DISCONNECT IF THE SIGN FALLS OVER. PROVIDE 3" ± 1/2" SLACK IN TETHER AND ALL TETHERS SHALL BE THE SAME LENGTH.
28. ALL SIGNS SHALL BE ORIENTATED SUCH THAT THE LONGITUDINAL CENTERLINE OF THE SIGN IS PERPENDICULAR TO THE RESPECTIVE TAXIWAY/RUNWAY CENTERLINE, UNLESS NOTED OTHERWISE.
29. ALL MANDATORY SIGNS (SIZE 1) SHALL BE LOCATED 15' OFF THE EDGE OF FULL STRENGTH PAVEMENT, (UNLESS DETAILED OTHERWISE) AND ALIGNED WITH THE FRONT EDGE OF THE FIRST YELLOW STRIPE (FURTHEST FROM THE RUNWAY) OF THE HOLD POSITION MARKING UNLESS SHOWN OTHERWISE FOR A RESPECTIVE SIGN. CONFIRM LOCATIONS WITH THE PROJECT ENGINEER.
30. CONCRETE STEEL REINFORCEMENT SHALL BE TYPE ASTM A615 OR A706 GRADE 60. ALL REINFORCEMENT SHALL HAVE A 3" MINIMUM CONCRETE COVER. REINFORCEMENT MAY BE ADJUSTED TO MISS INTERFERENCES. CONCRETE SHALL CONFORM TO ITEM P-610 STRUCTURAL PORTLAND CEMENT CONCRETE.
31. NO CONNECTION TO AN ACTIVE LIGHTING CIRCUIT WILL BE BROKEN UNTIL THE CIRCUIT HAS BEEN TURNED OFF IN ACCORDANCE WITH NOTE 1.

THE LOCATION, SIZE, AND TYPE OF MATERIAL OF EXISTING UNDERGROUND AND/OR ABOVEGROUND UTILITIES INDICATED ON THE PLANS ARE NOT REPRESENTED AS BEING ACCURATE, SUFFICIENT OR COMPLETE. NEITHER THE OWNER NOR THE ENGINEER ASSUMES ANY RESPONSIBILITY WHATSOEVER IN RESPECT TO THE ACCURACY, COMPLETENESS, OR SUFFICIENCY OF THE INFORMATION. THERE IS NO GUARANTEE, EITHER EXPRESSED OR IMPLIED, THAT THE LOCATIONS, SIZE AND TYPE OF MATERIAL OF EXISTING UNDERGROUND UTILITIES INDICATED ARE REPRESENTATIVE OF THOSE TO BE ENCOUNTERED IN THE CONSTRUCTION. IT SHALL BE THE CONTRACTOR'S RESPONSIBILITY TO DETERMINE THE ACTUAL LOCATION OF ALL SUCH FACILITIES, INCLUDING SERVICE CONNECTIONS TO UNDERGROUND UTILITIES. PRIOR TO CONSTRUCTION, THE CONTRACTOR SHALL NOTIFY THE UTILITY COMPANIES OF HIS OPERATIONAL PLANS AND SHALL OBTAIN FROM THE RESPECTIVE UTILITY COMPANIES DETAILED INFORMATION AND ASSISTANCE RELATIVE TO THE LOCATION OF THEIR FACILITIES AND THE WORKING SCHEDULE OF THE COMPANIES FOR REMOVAL OR ADJUSTMENT WHERE REQUIRED. IN THE EVENT AN UNEXPECTED UTILITY INTERFERENCE IS ENCOUNTERED DURING CONSTRUCTION, THE CONTRACTOR SHALL IMMEDIATELY NOTIFY THE UTILITY COMPANY OF JURISDICTION. THE OWNER'S REPRESENTATIVE AND/OR THE RESIDENT ENGINEER/TECHNICIAN SHALL ALSO BE IMMEDIATELY NOTIFIED. ANY DAMAGE TO SUCH MAINS AND SERVICES SHALL BE RESTORED TO SERVICE AT ONCE AND PAID FOR BY THE CONTRACTOR AT NO ADDITIONAL COST TO THE CONTRACT.

ALL UTILITY CABLES AND LINES SHALL BE LOCATED BY THE RESPECTIVE UTILITY. CONTACT JULIE (JOINT UTILITY LOCATION INFORMATION FOR EXCAVATORS) FOR UTILITY INFORMATION, PHONE: 1-800-892-0123. CONTACT THE FAA (FEDERAL AVIATION ADMINISTRATION) FOR ASSISTANCE IN LOCATING FAA CABLES AND UTILITIES. LOCATION OF FAA POWER, CONTROL, AND COMMUNICATION CABLES SHALL BE COORDINATED WITH AND/OR LOCATED BY THE FAA. ALSO CONTACT AIRPORT DIRECTOR/MANAGER AND AIRPORT PERSONNEL FOR ASSISTANCE IN LOCATING UNDERGROUND AIRPORT CABLES AND/OR UTILITIES. ALSO COORDINATE WORK WITH ALL ABOVEGROUND UTILITIES.

JAN 22, 2019 2:08 PM STOLZ01647 I:\T\JOBS\17A00160\CAD\AIRPORT\SHHEETE-002-NOTES.DWG



Offices Nationwide
www.hanson-inc.com

Hanson Professional Services Inc.
1525 S. 6th Street
Springfield, IL 62703
phone: 217-788-2450
fax: 217-788-2503

Illinois Licensed
Professional Service Corporation
#184-001084

Edgar County Airport
Board of Edgar County
15551 Airport Rd.
Paris, IL 61944-8474
Telephone: 217.465.4151



EAST AIRCRAFT
PARKING RAMP
EXPANSION &
REHABILITATE PARTIAL
PARALLEL TAXIWAY TO
RUNWAY 9/27

IDA No: PRG-4558

Contract No. ED019

NO.	DATE	DESCRIPTION		
		LAY	DWN	REV

ISSUE: JANUARY 11, 2019
PROJECT NO: 17A0016D
CAD FILE: E-002-NOTES.DWG
LAYOUT BY: KNL 09/29/2018
DRAWN BY: CWS 10/09/2018
REVIEWED BY: BSS 01/11/2019
SHEET TITLE

AIRFIELD LIGHTING
NOTES



Kevin Lightfoot

EAST AIRCRAFT
PARKING RAMP
EXPANSION &
REHABILITATE PARTIAL
PARALLEL TAXIWAY TO
RUNWAY 9/27

IDA No: PRG-4558





Contract No. ED019

NO.	DATE	DESCRIPTION		
		LAY	DWN	REV

ISSUE: JANUARY 11, 2019
PROJECT NO: 17A0016D
CAD FILE: E-508-ELEC.DWG
LAYOUT BY: KHL 12/10/2018
DRAWN BY: CWS 12/10/2018
REVIEWED BY: BSS 01/11/2019

SHEET TITLE

TAXIWAY LIGHT
DETAILS (FOR
REFERENCE)

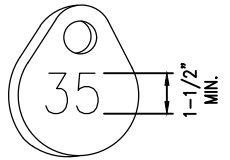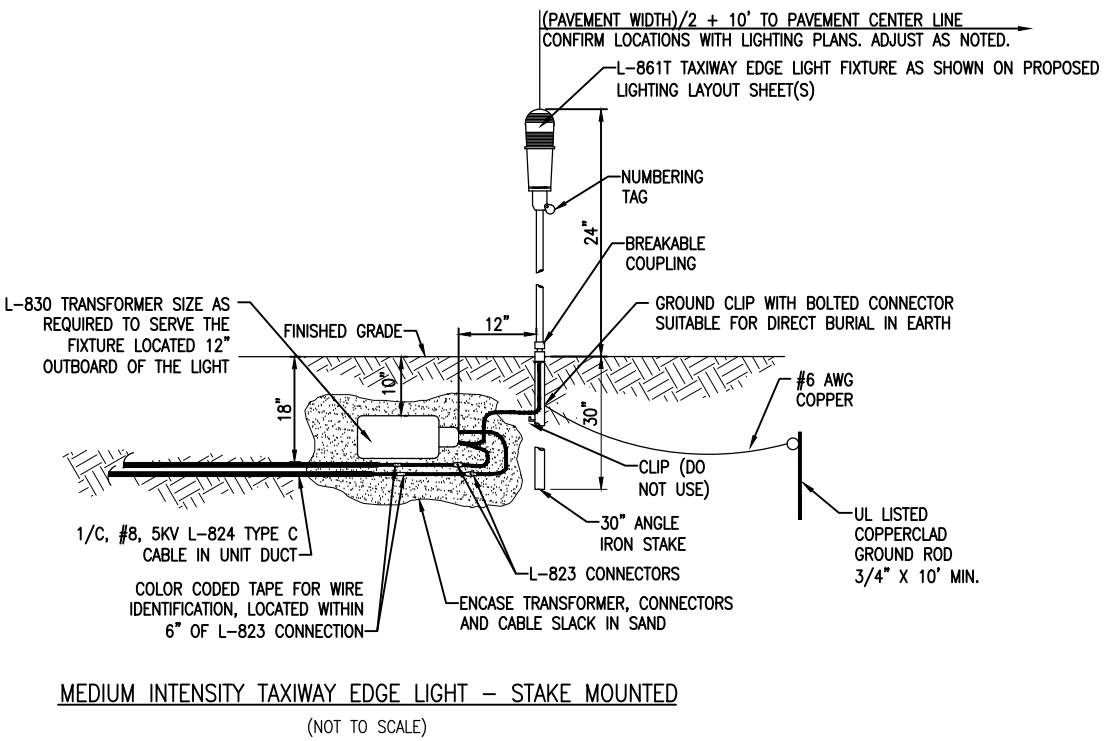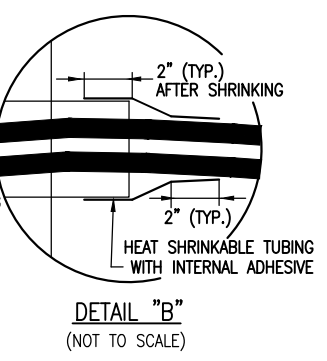
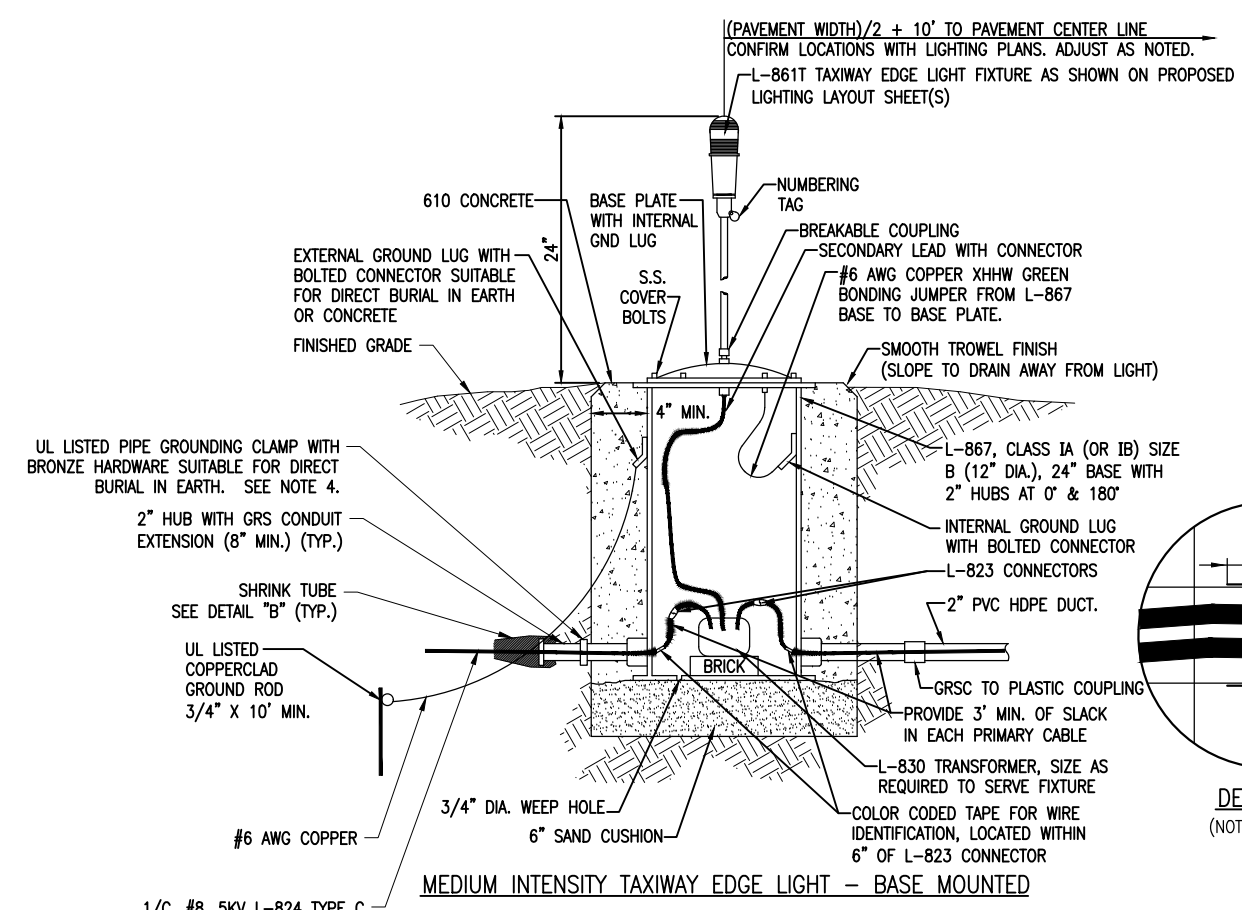


NOTE:
AFFIX NON-CORROSIVE TAG TO FIXTURE FACING RUNWAY WITH SET SCREW, WIRE TIE, OR METAL BAND. NUMERALS SHALL BE ENGRAVED FOR PERMANENT READABILITY.

- NOTES:
- SEE ELECTRICAL NOTES SHEETS.
 - SEE "ELECTRICAL NOTES SHEET 2" AND "GROUNDING NOTES" SHEET FOR GROUNDING NOTES FOR AIRFIELD LIGHTING.
 - SEE PROPOSED LIGHTING LAYOUT SHEET(S) FOR LIGHT LOCATIONS
 - WHERE GROUND LUGS ARE NOT ACCESSIBLE ON BASE CANS, PROVIDE A UL LISTED PIPE GROUND CLAMP RATED FOR DIRECT BURIAL IN EARTH AND BOND TO THE METAL CONDUIT EXTENSION TO PROVIDE GROUND PATH TO LIGHT BASE.

A LIGHT BASE GROUND SHALL BE INSTALLED AT EACH STAKE MOUNTED LIGHT AND EACH TRANSFORMER BASE/LIGHT CAN ASSOCIATED WITH RUNWAY LIGHTS, TAXIWAY LIGHTS, AND LIGHTED TAXI GUIDANCE SIGNS. THE LIGHT BASE GROUND SHALL BE A #6 AWG BARE COPPER CONDUCTOR CONNECTED TO THE GROUND LUG ON THE RESPECTIVE L-867 TRANSFORMER BASE/LIGHT CAN OR MOUNTING STAKE AND A 3/4-INCH DIAMETER BY 10-FEET LONG (MINIMUM) UL LISTED COPPER CLAD GROUND ROD.

THIS DETAILS SHEET IS PROVIDED FOR CONTRACTOR REFERENCE ONLY. CONTRACTOR WILL BE INTERFACING WITH EXISTING EDGE LIGHTS. NO PROPOSED LIGHTS ARE INCLUDED ON THE PROJECT.

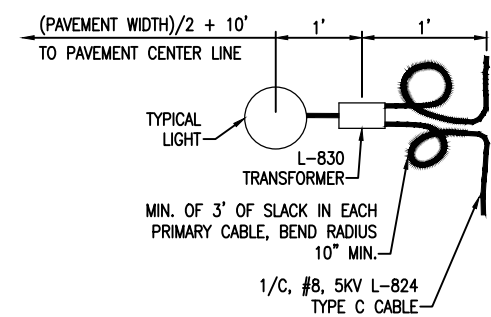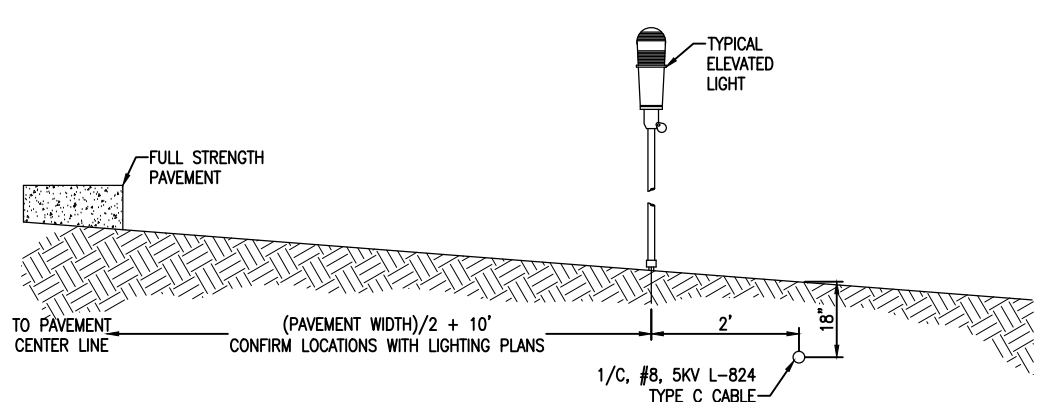

NOTES:
SEE PROPOSED LIGHTING LAYOUT SHEET FOR LIGHT LOCATIONS.



Kevin Lightfoot

EAST AIRCRAFT
PARKING RAMP
EXPANSION &
REHABILITATE PARTIAL
PARALLEL TAXIWAY TO
RUNWAY 9/27

IDA No: PRG-4558

Contract No. ED019

NO.	DATE	DESCRIPTION		
		LAY	DWN	REV

ISSUE: JANUARY 11, 2019
PROJECT NO: 17A0016D
CAD FILE: E-503-ELEC.DWG
LAYOUT BY: KNL 12/10/2018
DRAWN BY: CWS 12/10/2018
REVIEWED BY: BSS 01/11/2019

SHEET TITLE





TAXI GUIDANCE SIGN
DETAILS

SIGN NUMBER	LOCATION	SIDE A	SIDE B	NORTHING	EASTING
TGS-1	TAXIWAY A AT RUNWAY 9-27 HOLD POSITION	A 9-27	RAMP ↑	1105113.26	1169275.57
TGS-2	TAXIWAY B1 AT RUNWAY 9-27 HOLD POSITION	B1 9-27	RAMP →	1105172.28	1170834.00

- A** TYPE L-858(L) LOCATION SIGN - YELLOW LEGEND AND BORDER ON A BLACK BACKGROUND
- 9-27** TYPE L-858R(L) MANDATORY INSTRUCTION SIGN - BLACK OUTLINE ON OUTSIDE EDGE OF WHITE LEGEND ON A RED BACKGROUND
- RAMP ↑** TYPE L-858Y(L) DIRECTION, DESTINATION, AND BOUNDARY SIGN - BLACK LEGEND ON A YELLOW BACKGROUND

THE PROPOSED TAXI GUIDANCE SIGNS SHALL CONFORM TO ADVISORY CIRCULAR 150/5345 44 (CURRENT ISSUE IN EFFECT) AND BE FAA-APPROVED FOR TYPE L-858Y(L) DIRECTION, DESTINATION, AND BOUNDARY SIGNS (BLACK LEGEND ON YELLOW BACKGROUND); TYPE L-858R(L) MANDATORY INSTRUCTION SIGN (BLACK OUTLINE ON OUTSIDE EDGE OF WHITE LEGEND ON RED BACKGROUND); AND/OR TYPE L-858L(L) LOCATION SIGN (YELLOW LEGEND AND BORDER ON BLACK BACKGROUND). THE SIGNS SHALL BE SIZE 1, 18-IN. SIGN FACE WITH A 12-IN. LEGEND; STYLE 2, POWERED FROM A 4.8 TO 6.6 AMP SERIES LIGHTING CIRCUIT; CLASS 2, FOR OPERATION FROM -40 DEGREES F TO 131 DEGREES F; MODE 2, TO WITHSTAND WIND LOADS OF 200 M.P.H., BASE-MOUNTED, DOUBLE-SIDED, AS SPECIFIED ON THE PLANS. THE PROPOSED TAXI GUIDANCE SIGNS SHALL USE LED (LIGHT EMITTING DIODE) TYPE ILLUMINATION. ALSO SEE FAA ENGINEERING BRIEF 67 (MOST CURRENT ISSUE) "LIGHT SOURCES OTHER THAN INCANDESCENT AND XENON FOR AIRPORT AND OBSTRUCTION LIGHTING FIXTURES".

A LIGHT BASE GROUND SHALL BE INSTALLED AT EACH STAKE MOUNTED LIGHT AND EACH TRANSFORMER BASE/LIGHT CAN ASSOCIATED WITH RUNWAY LIGHTS, TAXIWAY LIGHTS, AND LIGHTED TAXI GUIDANCE SIGNS. THE LIGHT BASE GROUND SHALL BE A #6 AWG BARE COPPER CONDUCTOR CONNECTED TO THE GROUND LUG ON THE RESPECTIVE L-867 TRANSFORMER BASE/LIGHT CAN OR MOUNTING STAKE AND A 3/4-INCH DIAMETER BY 10-FEET LONG (MINIMUM) UL LISTED COPPER CLAD GROUND ROD.

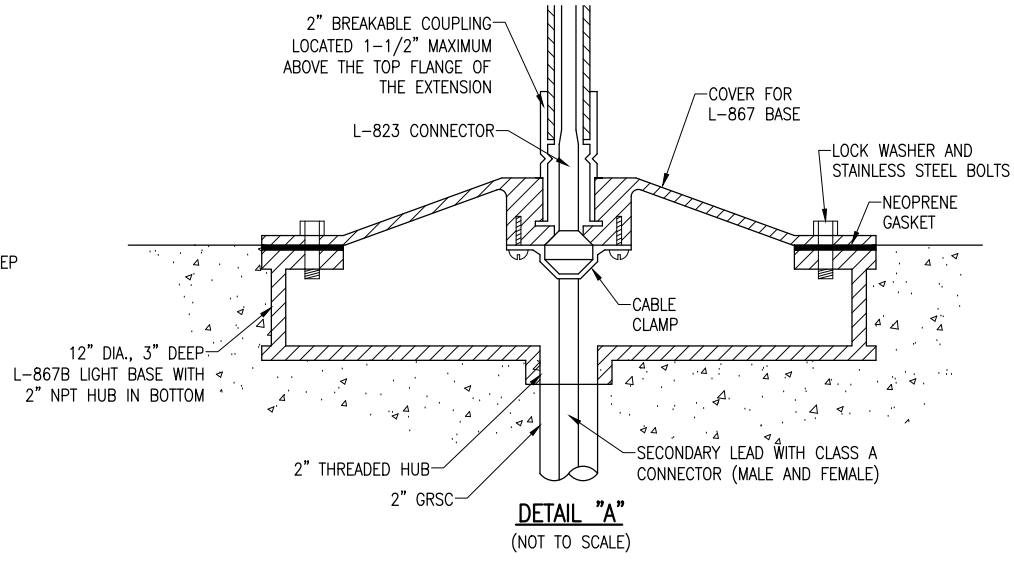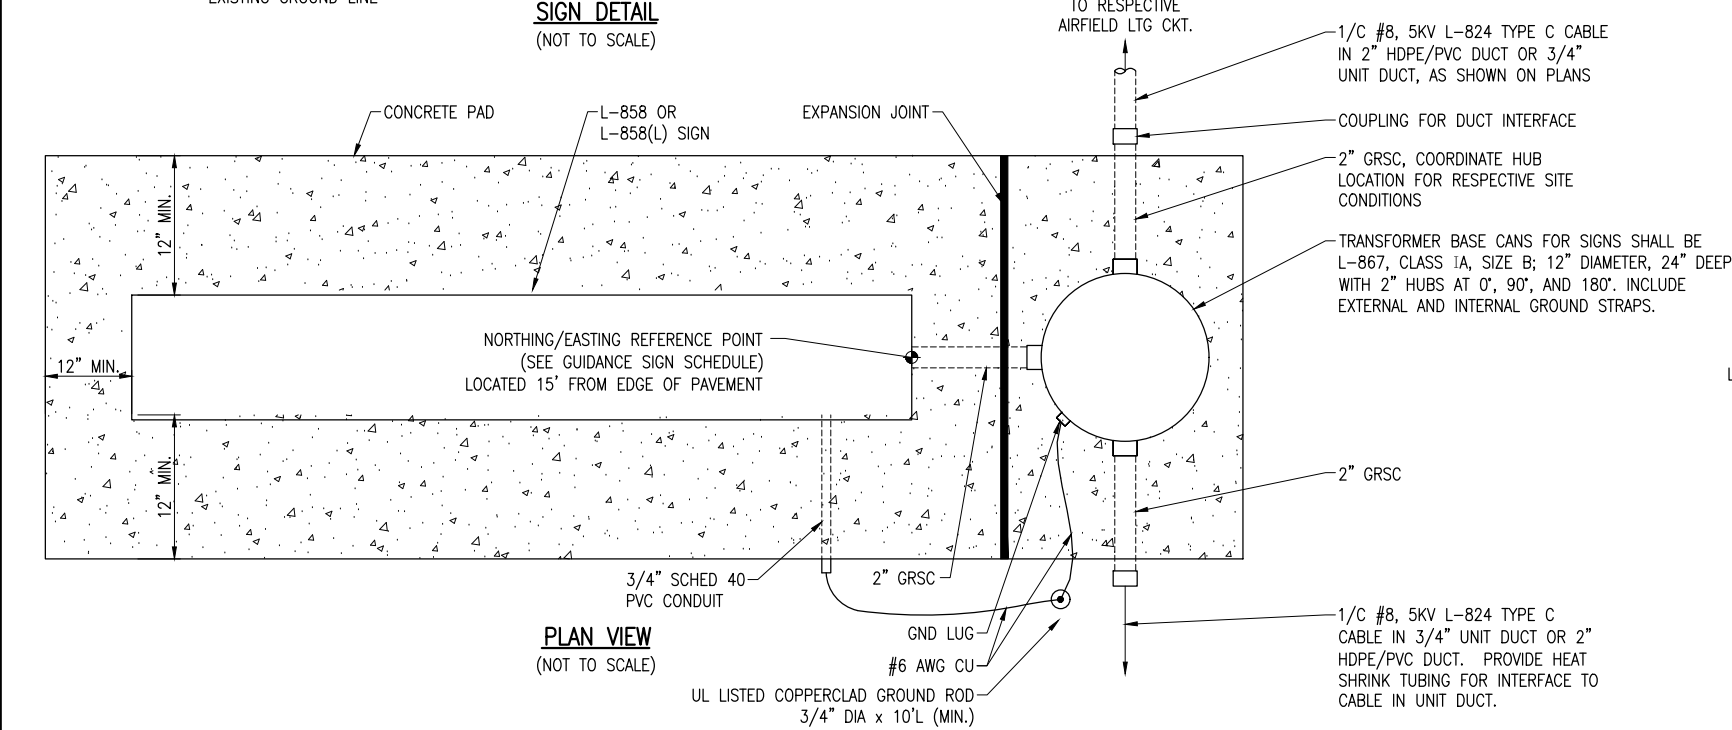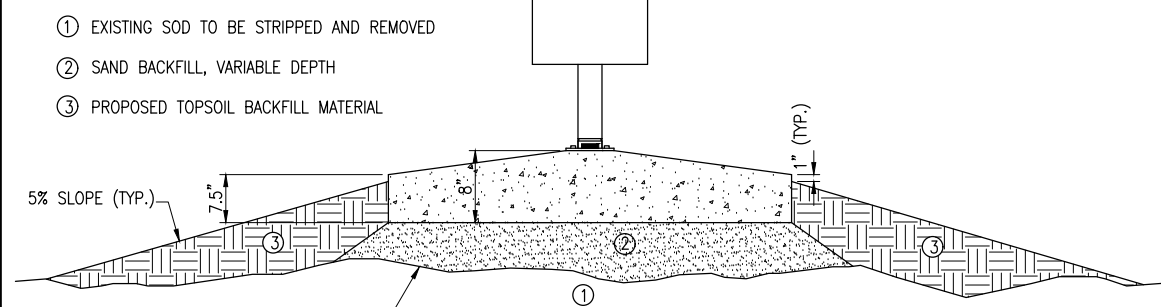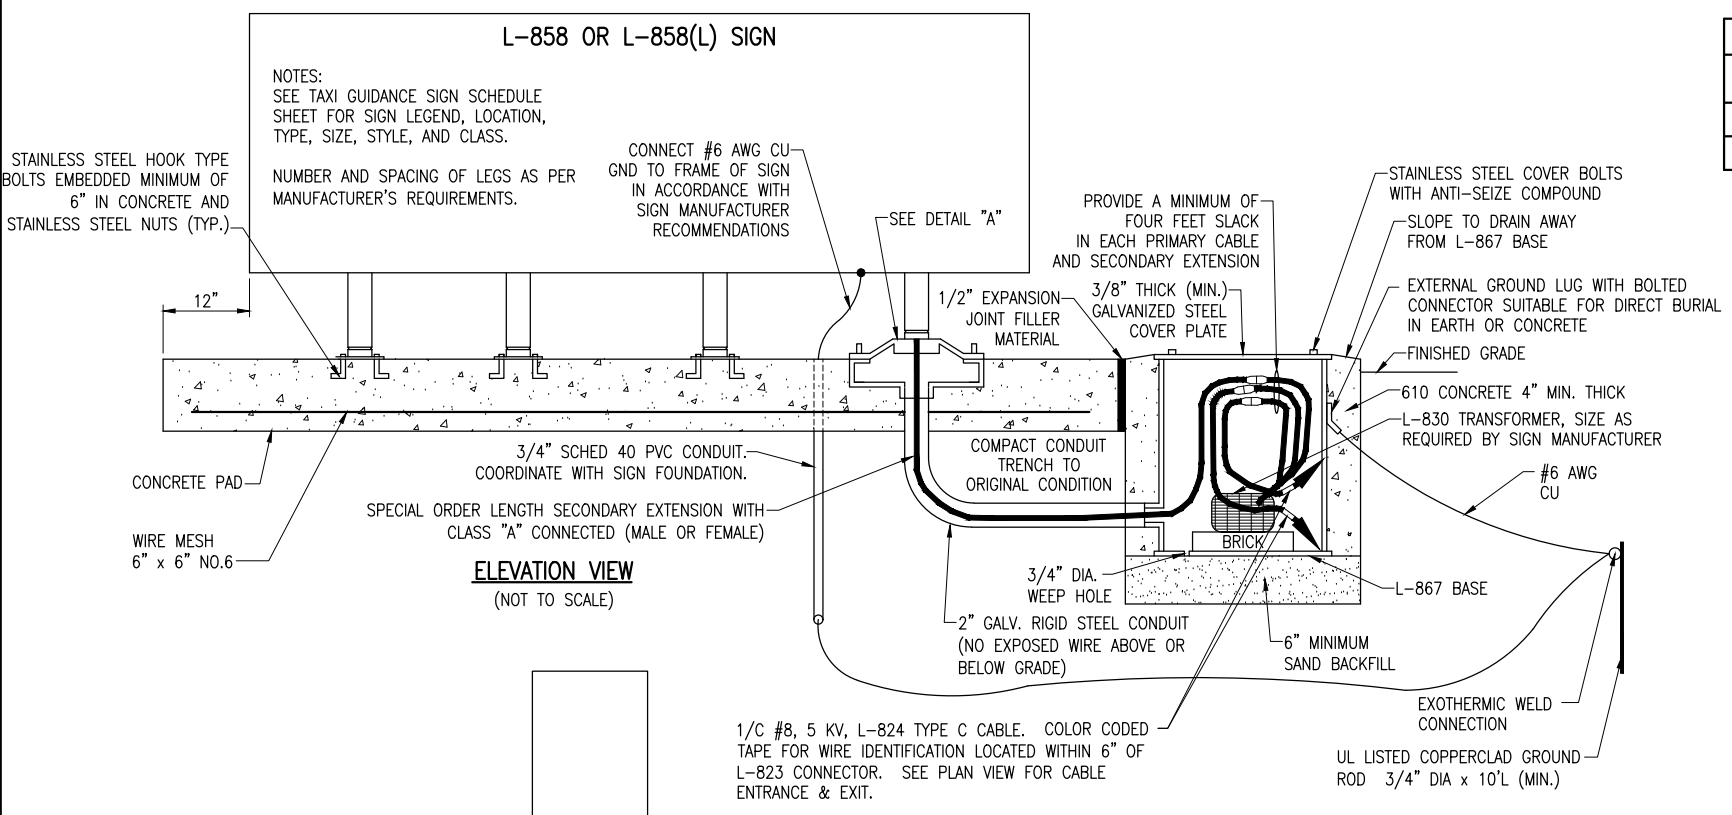

- GENERAL NOTES**
- SEE LIGHTING LAYOUT SHEETS, AIRFIELD LIGHTING NOTES AND TAXI GUIDANCE SIGN SCHEDULES FOR SIGN LEGEND, LOCATION, TYPE, SIZE, STYLE, AND CLASS.
 - SEE ELECTRICAL NOTES SHEETS.



EAST AIRCRAFT
PARKING RAMP
EXPANSION &
REHABILITATE PARTIAL
PARALLEL TAXIWAY TO
RUNWAY 9/27

IDA No: PRG-4558

Contract No. ED019

NO.	DATE	DESCRIPTION		
		LAY	DWN	REV


ISSUE: JANUARY 11, 2019
PROJECT NO: 17A0016D
CAD FILE: E-501-ELEC.DWG
LAYOUT BY: KNL 12/10/2018
DRAWN BY: CWS 12/10/2018
REVIEWED BY: BSS 01/11/2019

SHEET TITLE

AIRFIELD LIGHTING
CABLE SPLICE
DETAILS


NOTES:

1. SPLICE DETAILS ARE PROVIDED FOR NEW WORK AND TO ASSIST IN REPAIRS OF ACCIDENTAL OR UNEXPECTED INTERRUPTIONS AND/OR CUTS TO AIRFIELD LIGHTING CABLES.
2. KEEP ON HAND A MINIMUM OF 10 SETS OF SPLICE KITS FOR L-823 CONNECTORS AND A MINIMUM OF 10 SETS OF TYPE A LOW VOLTAGE SPLICE KITS TO ACCOMMODATE REPAIRS.
3. EVERY AIRFIELD LIGHTING CABLE SPLICER SHALL BE QUALIFIED IN MAKING CABLE SPLICES AND TERMINATIONS ON CABLES RATED AT AND/OR ABOVE 5,000 VOLTS AC TO COMPLY WITH THE REQUIREMENTS OF FAA AC 150/5370-10G ITEM L-108.
4. INSIDE DIAMETER OF RESPECTIVE CABLE CONNECTOR SHALL PROPERLY MATCH OUTSIDE DIAMETER OF CABLE.
5. WHEN PREPARING CABLE FOR SPLICES, THE CONTRACTOR SHALL USE A CABLE STRIPPER/PENCILLER WHENEVER CABLE CONNECTIONS ARE MADE.
6. WRAP ALL PRIMARY AND SECONDARY POWER CONNECTIONS WITH SUFFICIENT LAYERS OF HIGH VOLTAGE ELECTRICAL INSULATING TAPE (RUBBER SPLICING TAPE SUITABLE FOR PRIMARY ELECTRICAL INSULATION FOR SPLICING CABLE FROM 600 VOLTS TO 69,000 VOLTS) AND COVER WITH VINYL ELECTRICAL TAPE (ALL-WEATHER VINYL INSULATING TAPE SUITABLE FOR PROTECTIVE JACKETING FOR HIGH-VOLTAGE CABLE SPLICES AND REPAIRS) FOR FULL VALUE OF CABLE INSULATION VOLTAGE. PER ILLINOIS STANDARD SPECIFICATIONS FOR CONSTRUCTION OF AIRPORTS ITEM 108, ITEM 125, AND FAA AC 150/5370-10G ITEM L-108, HIGH VOLTAGE ELECTRICAL INSULATING TAPE SHALL BE 3M SCOTCH 23, 3M SCOTCH 130C OR APPROVED EQUIVALENT, AND VINYL ELECTRICAL TAPE SHALL BE 3M SCOTCH 88 OR APPROVED EQUIVALENT. TAPES MUST BE RATED SUITABLE FOR THE APPLICATION.
7. PROVIDE CABLE TAGS TO IDENTIFY THE RESPECTIVE CIRCUITS ALL POINTS OF ACCESS INCLUDING L-867 BASES, L-868 BASES, HANDHOLES, MANHOLES, JUNCTION BOXES, AND WIREWAYS.
8. CONNECTION OF CONDUCTORS MUST BE MADE BY USING CRIMP CONNECTORS AND A CRIMPING TOOL APPROVED BY THE CONNECTOR/LUG MANUFACTURER. THE TOOL MUST PRODUCE A COMPLETE CRIMP BEFORE IT CAN BE REMOVED. FOR THE L-823 CONNECTORS, THE CRIMPING TOOL USED MUST BE LISTED BY THE L-823 KIT MANUFACTURER. MAKE THE NUMBER AND TYPE OF CRIMPS PER THE KIT MANUFACTURER'S INSTRUCTIONS.

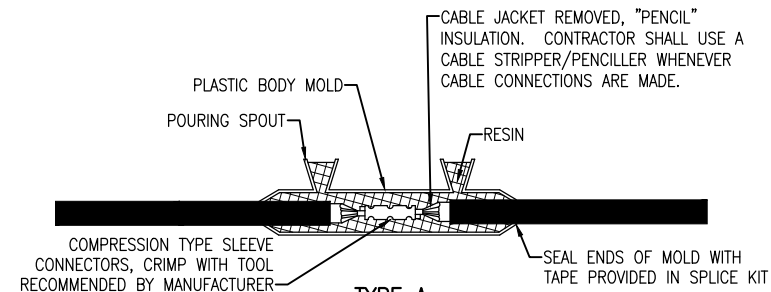

TYPE A


FOR SPLICES IN LOW VOLTAGE CABLE (600V) HOMERUNS FOR EXTENSIONS TO EXISTING LOW VOLTAGE CABLES ONLY. TYPE A SPLICES SHALL BE MADE IN SPLICE CANS, HANDHOLES, MANHOLES, OR JUNCTIONS BOXES

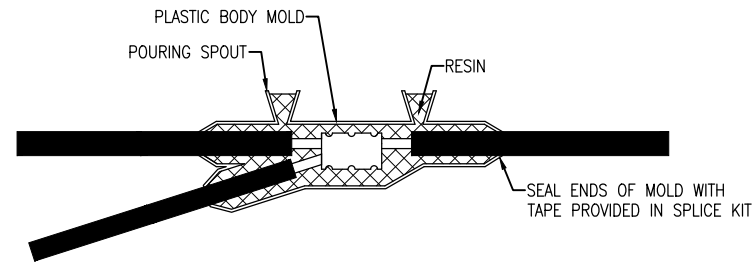

LOW VOLTAGE UNDERGROUND TAP SPLICE


FOR TAP SPLICES IN LOW VOLTAGE (600V) CABLE. SPLICES SHALL BE RATED AND LISTED SUITABLE FOR DIRECT BURIAL LOCATIONS. FOR SPLICES UP TO #2 AWG CONDUCTOR, SPLICES SHALL BE WYE RESIN TYPE POWER CABLE TAP SPLICE KIT SUITABLE FOR THE RESPECTIVE CABLES AND RESPECTIVE APPLICATION.

CONTINUOUS HEAT SHRINK TUBING PLACED OVER THE ENTIRE L-823 CONNECTOR(S) BOTH MALE AND FEMALE AT ALL 5KV JUNCTIONS. THE HEAT SHRINK TUBING SHALL BE APPROXIMATELY 18" IN LENGTH WITH 6 INCHES OF MASTIC ON BOTH ENDS AND VOID OF MASTIC IN MIDDLE OF TUBE RATED FOR 5KV.

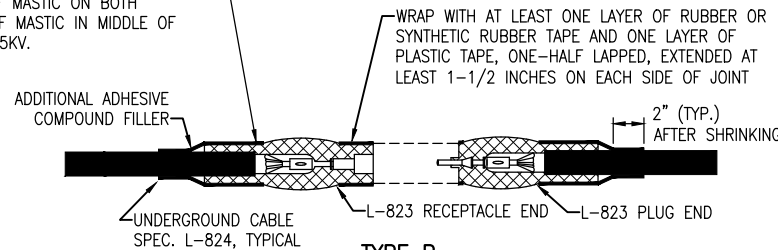

TYPE B


FOR SPLICES AT JUNCTION OF HOMERUN WITH LOOP CIRCUIT AND FOR SPLICES IN HOMERUNS TO EXISTING CABLES

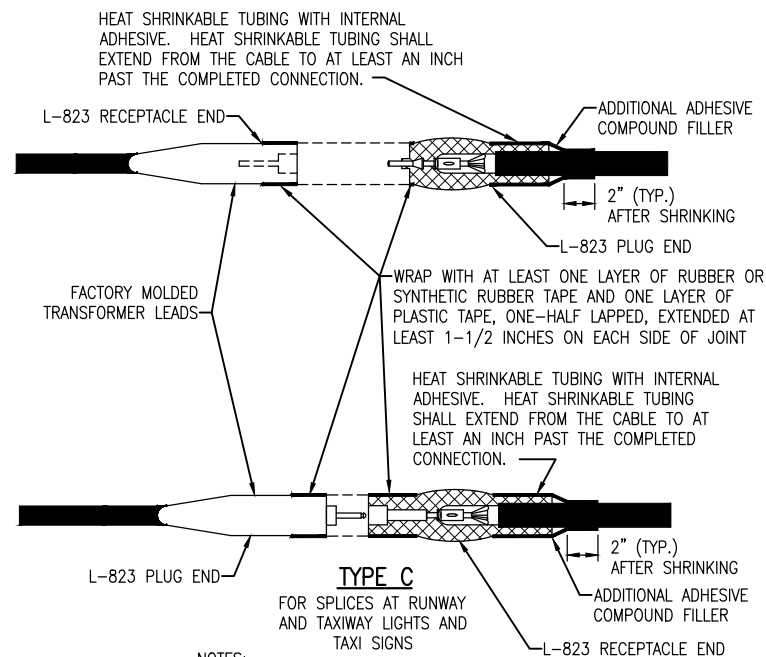

TYPE C

FOR SPLICES AT RUNWAY AND TAXIWAY LIGHTS AND TAXI SIGNS

CABLE SPLICES
(NOT TO SCALE)

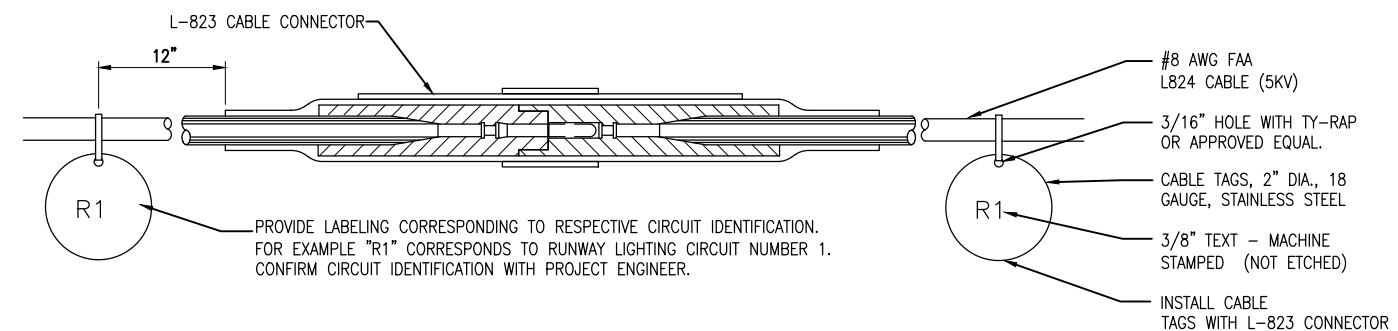

1. CONTRACTOR SHALL PROVIDE CABLE CIRCUIT IDENTIFICATION MARKERS ATTACHED TO BOTH SIDES OF EACH CABLE CONNECTION.
2. CABLE IDENTIFICATION TAGS SHALL BE STAINLESS STEEL OR BRASS.
3. THE CABLE SHALL THOROUGHLY BE CLEANED PRIOR TO THE INSTALLATION OF THE L-823 CONNECTOR KIT.
4. ATTACH EACH CABLE TIE ENOUGH TO HOLD IN PLACE WITHOUT COMPRESSING EDGE OF CABLE TAG INTO CONDUCTOR. TRIM OFF EXCESS CABLE TIE.
5. CABLE TAGS SHALL BE PROVIDED AT ALL POINTS OF ACCESS INCLUDING L-867 BASES, L-868 BASES, HANDHOLES, MANHOLES, JUNCTION BOXES, AND WIREWAYS.
6. R1 CORRESPONDS TO EDGAR CO. AIRPORT RUNWAY 9-27 LIGHTING CIRCUIT. R2 CORRESPONDS TO EDGAR CO. AIRPORT RUNWAY 18-36 LIGHTING CIRCUIT. T1 CORRESPONDS TO EDGAR CO. AIRPORT TAXIWAY LIGHTING CIRCUIT 1.

CABLE TAG DETAIL
"NOT TO SCALE"



Kevin Lightfoot

EAST AIRCRAFT
PARKING RAMP
EXPANSION &
REHABILITATE PARTIAL
PARALLEL TAXIWAY TO
RUNWAY 9/27

IDA No: PRG-4558


Contract No. ED019

NO.	DATE	DESCRIPTION		
		LAY	DWN	REV

ISSUE: JANUARY 11, 2019
PROJECT NO: 17A0016D
CAD FILE: E-502-ELEC.DWG
LAYOUT BY: KNL 12/10/2018
DRAWN BY: CWS 12/10/2018
REVIEWED BY: BSS 01/11/2019

SHEET TITLE

CONDUIT TRENCH
DETAILS

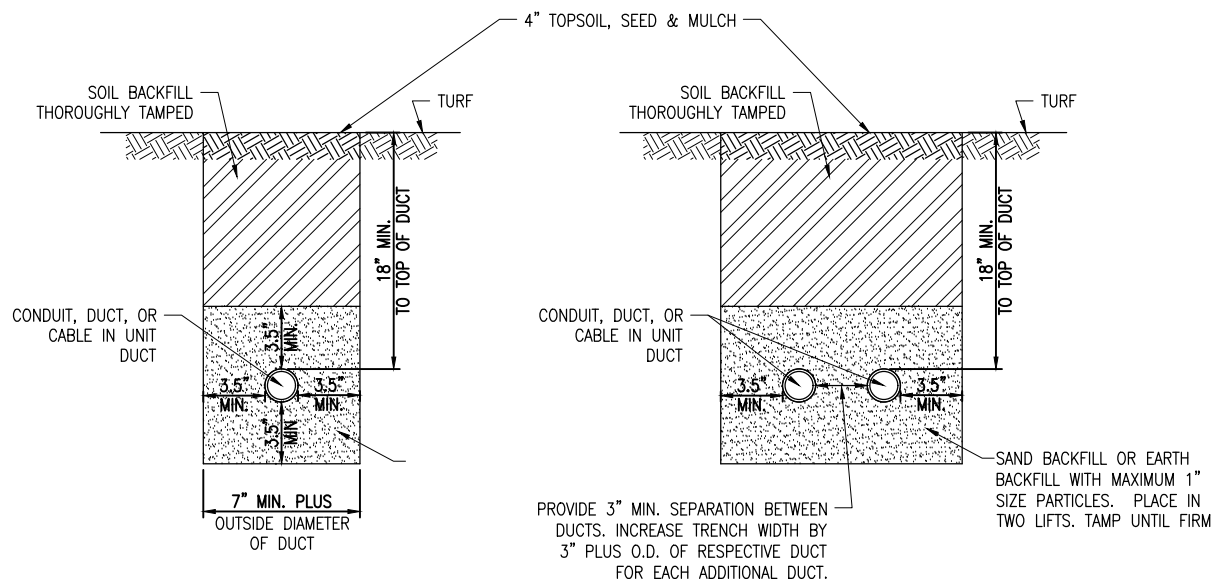


CONDUIT IN TRENCH – NON-PAVEMENT AREAS

"NOT TO SCALE"


NOTES:

- DIMENSIONS FOR COVERAGE AND SEPARATION BETWEEN DUCTS ARE MINIMUM.
- TRENCHES WITH MORE THAN TWO DUCTS OR CABLE IN UNIT DUCTS SHALL BE INCREASED 3" IN WIDTH PLUS DIAMETER OF RESPECTIVE DUCT FOR EACH ADDITIONAL CONDUIT, DUCT, OR CABLE IN UNIT DUCT; IF SPECIFIED ON PLANS TWO PARALLEL TRENCHES MAY BE CONSTRUCTED.
- DEPTH OF TRENCHES SHALL BE AS SHOWN ABOVE UNLESS OTHERWISE SPECIFIED ON THE PLANS. MINIMUM COVER REQUIREMENTS FOR CABLES AND DUCTS AT AIRPORT RUNWAYS AND ADJACENT AREAS WHERE TRESPASSING IS PROHIBITED IS 18 INCHES PER NEC 300.5 AND 300.50. MINIMUM COVER REQUIREMENTS FOR DUCTS LOCATED BELOW PAVEMENT OR ROADWAYS IS 30". MINIMUM COVER REQUIREMENTS FOR DUCTS LOCATED IN AREAS SUBJECT TO FARMING IS 42". ADJUST/INCREASE BURIAL DEPTHS TO ACCOMMODATE SITE CONDITIONS, DRAINAGE AND/OR OBSTRUCTIONS. COVER IS DEFINED AS THE SHORTEST DISTANCE IN INCHES MEASURED BETWEEN A POINT ON THE TOP SURFACE OF ANY DIRECT-BURIED CONDUCTOR, CABLE, CONDUIT, OR OTHER RACEWAY AND THE TOP SURFACE OF FINISHED GRADE, CONCRETE OR SIMILAR COVER.
- HIGH VOLTAGE CIRCUITS (AIRFIELD LIGHTING 5000 VOLT SERIES CIRCUITS AND/OR OTHER CIRCUITS RATED ABOVE 600 VOLTS) AND LOW VOLTAGE CIRCUITS (RATED 600 VOLTS AND BELOW) SHALL NOT BE INSTALLED IN THE SAME RACEWAY, CONDUIT, DUCT, HANDHOLE, OR MANHOLE.
- CONDUIT, DUCT, CABLE, AND/OR CABLE IN UNIT DUCT INTERFACE TO HANDHOLES, MANHOLES, SPLICE CANS, OR OTHER JUNCTION STRUCTURES WILL BE CONSIDERED INCIDENTAL TO THE RESPECTIVE CABLE PAY ITEM OR RESPECTIVE DUCT PAY ITEM.
- ALL DISTURBED SURFACES SHALL BE RESTORED TO THEIR ORIGINAL CONDITION. COST IS INCIDENTAL TO TRENCH.

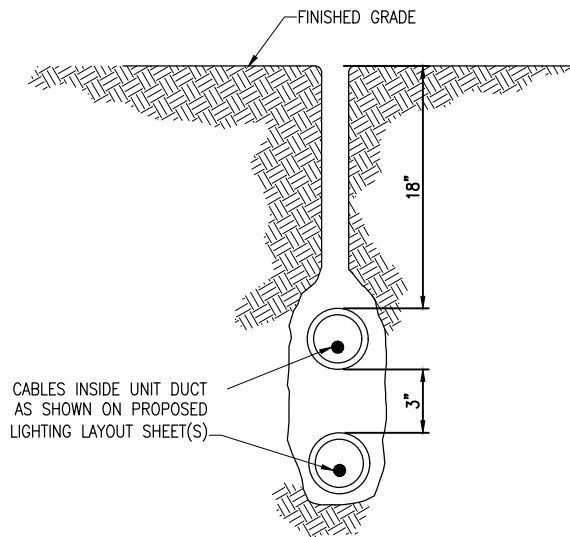

PLOWED CABLE

"NOT TO SCALE"

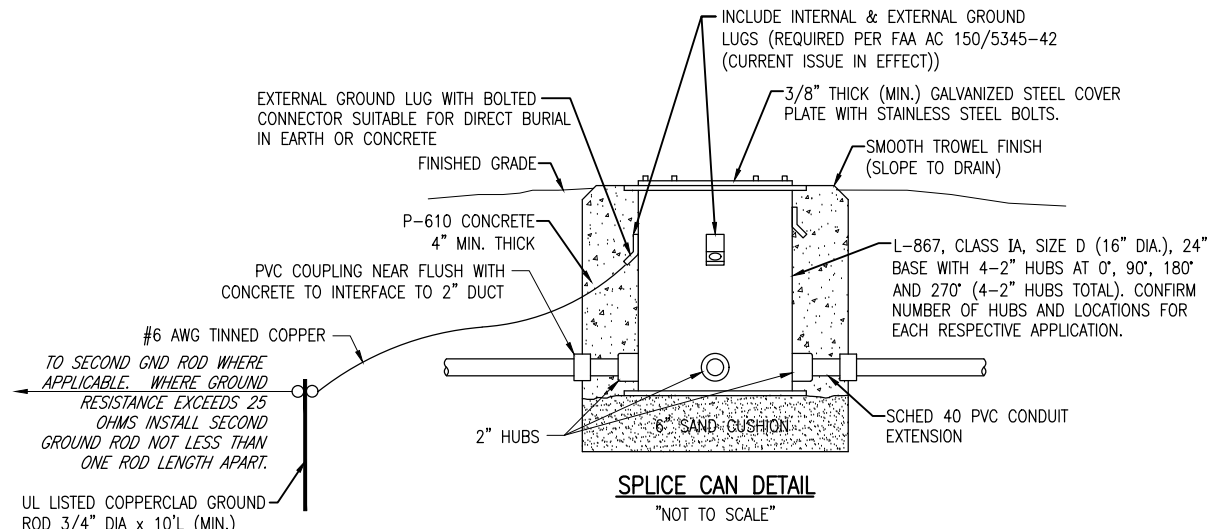

SPLICE CAN DETAIL

"NOT TO SCALE"

NOTES FOR SPLICE CAN DETAIL:

- SPLICE CANS SHALL CONFORM TO THE REQUIREMENTS OF FAA AC 150/5345-42F, OR MOST CURRENT ISSUE IN FORCE, FOR TYPE L-867, CLASS IA, SIZE D, (16 IN. NOMINAL DIAMETER), AND 24 IN. DEEP AND/OR AS DETAILED ON THE PLANS. EACH SPLICE CAN SHALL INCLUDE INTERNAL AND EXTERNAL GROUND LUGS TO ACCOMMODATE THE RESPECTIVE APPLICATIONS. SPLICE CANS AND/OR JUNCTION CANS SHALL HAVE GALVANIZED STEEL COVERS, 3/8-INCH THICK (MINIMUM), WITH STAINLESS STEEL BOLTS.
- FOR THE PURPOSE OF ENHANCING SAFETY, EACH BASE MUST HAVE INSTALLED, BY THE MANUFACTURER, AN INTERNAL AND EXTERNAL GROUND STRAP THAT IS AVAILABLE FOR THE PURPOSE OF ATTACHING A GROUND LUG THAT IS CONNECTED TO AN EARTH GROUND OR A SAFETY GROUND CONDUCTOR INSTALLED WITH THE RESPECTIVE CIRCUIT. FOR AIRPORT PROJECTS RECEIVING FEDERAL FUNDS THIS REQUIREMENT IS MANDATORY PER FAA AC 150/5345-42 (CURRENT ISSUE IN EFFECT).
- APPLY AN OXIDE-INHIBITING, ANTI-SEIZING COMPOUND TO ALL SCREWS, NUTS, AND ALL PLACES WHERE METAL COMES INTO CONTACT WITH METAL.
- THE CONCRETE USED IN THE CONSTRUCTION OF THE BASES FOR THE AIRFIELD LIGHTING CANS SHALL BE IN ACCORDANCE WITH ITEM 610.
- LIDS FOR THE SPLICE CANS CONTAINING HIGH VOLTAGE AIRFIELD LIGHTING CABLES SHALL INCLUDE MINIMUM 1/2-INCH HIGH LETTERING LABELED "DANGER HIGH VOLTAGE KEEP OUT" TO COMPLY WITH NEC ARTICLE 300.45 "WARNING SIGNS" AND NEC ARTICLE 314.71(E) "SUITABLE COVERS". THIS WILL NEED TO BE COORDINATED WITH THE SPLICE CAN MANUFACTURER.
- LIDS FOR THE SPLICE CANS CONTAINING LOW VOLTAGE CABLES (RATED 600 VOLTS AND BELOW) WILL BE ACCEPTABLE TO USE BLANK COVERS.
- LIDS FOR SPLICE CANS CONTAINING COMMUNICATIONS OR TELEPHONE CABLES SHALL INCLUDE MINIMUM 1/2 - HIGH LETTERING LABELED "COMM".



Kevin Lightfoot

EAST AIRCRAFT
PARKING RAMP
EXPANSION &
REHABILITATE PARTIAL
PARALLEL TAXIWAY TO
RUNWAY 9/27

IDA No: PRG-4558

Contract No. ED019

NO.	DATE	DESCRIPTION		
		LAY	DWN	REV

ISSUE: JANUARY 11, 2019

PROJECT NO: 17A0016D

CAD FILE: E-003-NOTES.DWG

LAYOUT BY: KNL 12/10/2018

DRAWN BY: CWS 12/10/2018

REVIEWED BY: BSS 01/11/2019

SHEET TITLE

ELECTRICAL NOTES
SHEET 1

GENERAL NOTES

- ALL ELECTRICAL EQUIPMENT SHALL BE INSTALLED IN CONFORMANCE WITH NFPA 70 - NATIONAL ELECTRICAL CODE (NEC) MOST CURRENT ISSUE IN FORCE, THE RESPECTIVE EQUIPMENT MANUFACTURER'S DIRECTIONS AND ALL OTHER APPLICABLE LOCAL CODES, LAWS, ORDINANCES, AND REQUIREMENTS IN FORCE. ANY INSTALLATIONS WHICH VOID THE U.L. LISTING, INTERTEK TESTING SERVICES VERIFICATION/ETL LISTING (OR OTHER THIRD PARTY LISTING) AND/OR THE MANUFACTURER'S WARRANTY OF A DEVICE WILL NOT BE PERMITTED.
- CONTRACTOR SHALL KEEP A COPY OF THE LATEST NEC IN FORCE ON SITE AT ALL TIMES DURING CONSTRUCTION FOR USE AS A REFERENCE.
- CONTRACTOR SHALL COORDINATE WORK AND ANY POWER OUTAGES AND/OR SHUT DOWN OF SYSTEMS WITH THE RESPECTIVE FACILITY OWNER PERSONNEL AND THE AIRPORT MANAGER/DIRECTOR. ONCE SHUT DOWN, THE CIRCUITS SHALL BE LABELED AS SUCH TO PREVENT ACCIDENTAL ENERGIZING OF THE RESPECTIVE CIRCUITS. ALL PERSONNEL SHALL FOLLOW U.S. DEPARTMENT OF LABOR OCCUPATIONAL SAFETY & HEALTH ADMINISTRATION (OSHA) 29 CFR PART 1910 OCCUPATIONAL SAFETY & HEALTH STANDARDS FOR ELECTRICAL SAFETY AND LOCKOUT/TAGOUT PROCEDURES INCLUDING, BUT NOT LIMITED TO, 29 CFR SECTION 1910.147 THE CONTROL OF HAZARDOUS ENERGY (LOCKOUT/TAGOUT).
- THE CONTRACTOR SHALL ASCERTAIN THAT ALL LIGHTING SYSTEM COMPONENTS FURNISHED BY HIM, INCLUDING FAA APPROVED EQUIPMENT, ARE COMPATIBLE IN ALL RESPECTS WITH EACH OTHER AND THE REMAINDER OF THE NEW/EXISTING SYSTEM. ANY NONCOMPATIBLE COMPONENTS FURNISHED BY THIS CONTRACTOR SHALL BE REPLACED BY HIM AT NO ADDITIONAL COST TO THE AIRPORT SPONSOR WITH A SIMILAR UNIT, APPROVED BY THE ENGINEER (DIFFERENT MODEL OR DIFFERENT MANUFACTURER) THAT IS COMPATIBLE WITH THE REMAINDER OF THE AIRPORT LIGHTING SYSTEM.
- IN CASE THE CONTRACTOR ELECTS TO FURNISH AND INSTALL AIRPORT LIGHTING EQUIPMENT REQUIRING ADDITIONAL WIRING, TRANSFORMERS, ADAPTORS, MOUNTINGS, ETC., TO THOSE SHOWN ON THE DRAWINGS AND/OR LISTED IN THE SPECIFICATION, ANY COST FOR THESE ITEMS SHALL BE INCIDENTAL TO THE EQUIPMENT COST.
- THE CONTRACTOR INSTALLED EQUIPMENT (INCLUDING FAA APPROVED) SHALL NOT GENERATE ANY ELECTROMAGNETIC INTERFERENCE IN THE EXISTING AND/OR NEW COMMUNICATIONS, WEATHER, AIR NAVIGATION, AND AIR TRAFFIC CONTROL EQUIPMENT. ANY EQUIPMENT GENERATING SUCH INTERFERENCE SHALL BE REPLACED BY THE CONTRACTOR AT NO ADDITIONAL COST WITH THE EQUIPMENT MEETING THE APPLICABLE SPECIFICATIONS AND NOT GENERATING ANY INTERFERENCE.
- WHEN A SPECIFIC TYPE, STYLE, CLASS, ETC. OF FAA APPROVED EQUIPMENT IS SPECIFIED ONLY THAT TYPE, STYLE, CLASS, WILL BE ACCEPTABLE, EVEN THOUGH EQUIPMENT OF OTHER TYPES STYLES, CLASSES, ETC. MAY BE APPROVED.
- ANY AND ALL INSTRUCTIONS FROM THE RESIDENT ENGINEER/RESIDENT TECHNICIAN TO THE CONTRACTOR REGARDING CHANGES IN OR DEVIATIONS FROM THE PLANS AND SPECIFICATIONS SHALL BE IN WRITING WITH COPIES SENT TO THE AIRPORT SPONSOR AND THE ILLINOIS DEPARTMENT OF TRANSPORTATION DIVISION OF AERONAUTICS. THE CONTRACTOR SHALL NOT ACCEPT ANY VERBAL INSTRUCTIONS FROM THE RESIDENT ENGINEER/RESIDENT TECHNICIAN REGARDING ANY CHANGES FROM THE PLANS AND SPECIFICATIONS.
- A MINIMUM OF THREE COPIES OF THE INSTRUCTION BOOK SHALL BE SUPPLIED WITH EACH DIFFERENT TYPE OF EQUIPMENT. THE BOOKS DESCRIBING A MORE SOPHISTICATED TYPE OF EQUIPMENT, SUCH AS REGULATORS, PAPI, REIL, ETC. AS A MINIMUM SHALL CONTAIN THE FOLLOWING:
 - A DETAILED DESCRIPTION OF THE OVERALL EQUIPMENT AND ITS INDIVIDUAL COMPONENTS.
 - THEORY OF OPERATION INCLUDING THE FUNCTION OF EACH COMPONENT.
 - INSTALLATION INSTRUCTION.
 - START-UP INSTRUCTIONS.
 - PREVENTATIVE MAINTENANCE REQUIREMENTS.
 - CHART FOR TROUBLE-SHOOTING.
 - COMPLETE POWER AND CONTROL DETAILED WIRING DIAGRAM(S), SHOWING EACH CONDUCTOR/CONNECTION/COMPONENT - "BLACK" BOXES ARE NOT ACCEPTABLE. THE DIAGRAM OF THE NARRATIVE SHALL SHOW VOLTAGE/CURRENTS/WAVE SHAPES AT STRATEGIC LOCATIONS TO BE USED WHEN CHECKING AND/OR TROUBLE-SHOOTING THE EQUIPMENT. WHEN THE EQUIPMENT HAS SEVERAL MODES OF OPERATION, SUCH AS SEVERAL BRIGHTNESS STEPS, THESE PARAMETERS SHALL BE INDICATED FOR ALL DIFFERENT MODES.
 - PARTS LIST WHICH WILL INCLUDE ALL MAJOR AND MINOR COMPONENTS SUCH AS RESISTORS, DIODES, ETC. IT SHALL INCLUDE A COMPLETE NOMENCLATURE OF EACH COMPONENT AND, IF APPLICABLE, THE NAME OF ITS MANUFACTURER AND THE CATALOG NUMBER.
 - SAFETY INSTRUCTIONS.

POWER AND CONTROL NOTES

- PROVIDE LEGEND PLATES FOR ALL ELECTRICAL EQUIPMENT TO IDENTIFY FUNCTION, CIRCUIT VOLTAGE AND PHASE. WHERE THE EQUIPMENT CONTAINS FUSES, ALSO IDENTIFY THE FUSE OR FUSE LINK AMPERE RATING. WHERE THE EQUIPMENT DOES NOT HAVE SUFFICIENT AREA TO INSTALL LEGEND PLATES, THE LEGEND PLATES SHALL BE INSTALLED ON THE WALL NEXT TO THE UNIT. LEGEND PLATES SHALL BE WEATHERPROOF ENGRAVED PLASTIC OR PHENOLIC MATERIAL, 1/4" HIGH BLACK LETTERS ON A WHITE BACKGROUND UNLESS NOTED OTHERWISE. SECURE WITH WEATHERPROOF ADHESIVE AND MACHINE SCREWS. FURNISH ADDITIONAL LEGEND PLATES WHERE REQUIRED BY CODE, FOR ADDITIONAL EQUIPMENT, AS DETAILED HEREIN ON THE PLANS, AND AS NOTED IN THE SPECIAL PROVISION SPECIFICATIONS.
- COLOR CODE ALL PHASE WIRING BY THE USE OF COLORED WIRE INSULATION AND/OR COLORED TAPE. WHERE TAPE IS USED, THE WIRE INSULATION SHALL BE BLACK. BLACK AND RED SHALL BE USED FOR PHASE CONDUCTORS ON 120/240VAC SINGLE-PHASE, THREE WIRE SYSTEMS AND BLACK, ORANGE (FOR HIGH LEG) AND BLUE SHALL BE USED FOR PHASE CONDUCTORS ON 240/120VAC THREE-PHASE, FOUR WIRE SYSTEMS. NEUTRAL CONDUCTORS, SIZE NO. 6 AWG OR SMALLER, SHALL BE IDENTIFIED BY A CONTINUOUS WHITE OR NATURAL GRAY OUTER FINISH ALONG ITS ENTIRE LENGTH. NEUTRAL CONDUCTORS LARGER THAN NO. 6 AWG SHALL BE IDENTIFIED EITHER BY A CONTINUOUS WHITE OR NATURAL GRAY OUTER FINISH ALONG ITS ENTIRE LENGTH OR BY THE USE OF WHITE TAPE AT ITS TERMINATIONS AND INSIDE ACCESSIBLE WIREWAYS. INSULATED GROUND CONDUCTORS SHALL HAVE GREEN COLORED INSULATION FOR ALL CONDUCTOR SIZES (AWG OR KCMIL).
- ALL BRANCH CIRCUIT CONDUCTORS CONNECTED TO A PARTICULAR PHASE SHALL BE IDENTIFIED WITH THE SAME COLOR. THE COLOR CODING SHALL BE EXTENDED TO THE POINT OF UTILIZATION.
- IN CONTROL WIRING THE SAME COLOR SHALL BE USED THROUGHOUT THE SYSTEM FOR THE SAME FUNCTION, SUCH AS 10%, 30%, 100% BRIGHTNESS CONTROL, ETC.
- LOW VOLTAGE (600 V.) AND HIGH VOLTAGE (5000 V.) CONDUCTORS SHALL BE INSTALLED IN SEPARATE WIREWAYS.
- NEATLY LACE WIRING IN DISTRIBUTION PANELS, WIREWAYS, SWITCHES AND JUNCTION/PULL BOXES.
- THE MINIMUM SIZE OF PULL/JUNCTION BOXES, REGARDLESS OF THE QUANTITY AND SIZE OF THE CONDUCTORS SHOWN, SHALL BE AS FOLLOWS:
 - IN STRAIGHT PULLS THE LENGTH OF THE BOX SHALL NOT BE LESS THAN EIGHT TIMES THE TRADE DIAMETER OF THE LARGER CONDUIT. THE TOTAL AREA (INCLUDING THE CONDUIT CROSS-SECTIONAL AREA) OF A BOX END SHALL BE AT LEAST 3 TIMES GREATER THAN THE TOTAL TRADE CROSS-SECTIONAL AREA OF THE CONDUITS TERMINATING AT THE END.
 - IN ANGLE PULLS OR 'U' PULLS THE DISTANCE BETWEEN EACH CONDUIT ENTRY INSIDE THE BOX AND THE OPPOSITE WALL OF THE BOX SHALL NOT BE LESS THAN SIX (6) TIMES THE TRADE DIAMETER OF THE LARGEST CONDUIT. THIS DISTANCE SHALL BE INCREASED FOR ADDITIONAL ENTRIES BY THE AMOUNT OF THE SUM OF THE DIAMETERS OF ALL OTHER CONDUIT ENTRIES ON THE SAME WALL AS THE BOX. THE DISTANCE BETWEEN CONDUIT ENTRIES ENCLOSING THE SAME CONDUCTOR SHALL NOT BE LESS THAN SIX TIMES THE TRADE DIAMETER OF THE LARGEST CONDUIT.
- A RUN OF CONDUIT BETWEEN TERMINATIONS AT EQUIPMENT ENCLOSURES, SQUARE DUCTS AND PULL/JUNCTION BOXES, SHALL NOT CONTAIN MORE THAN THE EQUIVALENT OF FOUR QUARTER BENDS (360 DEGREES TOTAL), INCLUDING THOSE BENDS LOCATED IMMEDIATELY AT THE TERMINATIONS, CAST, CONDUIT TYPE OUTLETS SHALL NOT BE TREATED AS PULL/JUNCTION BOXES.
- EQUIPMENT CABINETS SHALL NOT BE USED AS PULL/JUNCTION BOXES. ONLY WIRING TERMINATING AT THE EQUIPMENT SHALL BE BROUGHT INTO THESE ENCLOSURES.
- SPLICES AND JUNCTION POINTS SHALL BE PERMITTED ONLY IN JUNCTION BOXES, DUCTS EQUIPPED WITH REMOVABLE COVERS, AND AT EASILY ACCESSIBLE LOCATIONS.
- CIRCUIT BREAKERS IN POWER DISTRIBUTION PANEL(S) SHALL BE THERMAL-MAGNETIC MOLDED CASE, PERMANENT TRIP WITH 100 AMPERE, MINIMUM FRAME.
- DUAL LUGS SHALL BE USED WHERE TWO (2) WIRES, SIZE NO. 6 OR LARGER, ARE TO BE CONNECTED TO THE SAME TERMINAL.
- ALL INTERIOR WALL MOUNTED EQUIPMENT ENCLOSURES SHALL BE MOUNTED ON HOT DIPPED GALVANIZED STEEL STRUT SUPPORT, OR STAINLESS STEEL STRUT SUPPORT, WITH CORROSION RESISTANT HARDWARE.
- SUPPORT FOR EXTERIOR MOUNTED EQUIPMENT SHALL USE HOT DIPPED GALVANIZED STEEL STRUT SUPPORT OR STAINLESS STEEL STRUT SUPPORT WITH STAINLESS STEEL HARDWARE. PROVIDE ZINC RICH PAINT APPLIED TO FIELD CUTS OF GALVANIZED STEEL SUPPORT TO MINIMIZE THE POTENTIAL FOR CORROSION PER THE RESPECTIVE STRUT SUPPORT MANUFACTURER'S RECOMMENDATIONS.
- CONDUITS FOR ELECTRIC SERVICE ENTRANCE AND FEEDERS SHALL BE AS DETAILED HEREIN ON THE PLANS. WHERE GALVANIZED RIGID STEEL CONDUIT IS SPECIFIED IT SHALL HAVE THREADED FITTINGS. SET SCREW TYPE FITTINGS WILL NOT BE ACCEPTABLE. CONDUITS FOR UNDERGROUND APPLICATIONS SHALL BE AS DETAILED HEREIN. CONDUITS FOR GROUNDING ELECTRODE CONDUCTORS OR INDIVIDUAL GROUNDING CONDUCTORS SHALL BE SCHEDULE 40 OR SCHEDULE 80 PVC.
- PROVIDE LIQUID TIGHT FLEXIBLE METAL CONDUIT AT CONNECTIONS TO EQUIPMENT SUBJECT TO VIBRATION OR WHERE FLEXIBILITY IS REQUIRED. LIQUID TIGHT FLEXIBLE METAL CONDUIT AND ASSOCIATED FITTINGS SHALL BE U.L. LISTED TO MEET THE REQUIREMENTS OF NEC 350.6, SUITABLE FOR GROUNDING, SUNLIGHT RESISTANT, AND RESISTANT TO OIL, GASOLINE, AND GREASE. LIQUID TIGHT FLEXIBLE METAL CONDUIT THAT IS USED FOR FLEXIBILITY (INCLUDING CONNECTIONS TO MOTORS, TRANSFORMERS, & CONSTANT CURRENT REGULATORS) SHALL REQUIRE AN EXTERNAL BONDING JUMPER OR INTERNAL EQUIPMENT GROUNDING CONDUCTOR PER NEC 350.60. DO NOT INSTALL LIQUID TIGHT FLEXIBLE METAL CONDUIT THAT IS NOT UL LISTED. CONFIRM LIQUID-TIGHT FLEXIBLE METAL CONDUIT BEARS THE UL LABEL PRIOR TO INSTALLING IT.
- UNLESS OTHERWISE SHOWN, ALL EXPOSED CONDUITS SHALL BE RUN PARALLEL TO OR AT RIGHT ANGLES WITH THE LINES OF THE STRUCTURE.
- ALL STEEL CONDUITS, FITTINGS, NUTS, BOLTS, ETC. SHALL BE GALVANIZED.
- USE CONDUIT BUSHINGS AT EACH CONDUIT TERMINATION. WHERE NO. 4 AWG OR LARGER UNDERGROUND WIRE IS INSTALLED, USE INSULATED BUSHINGS.
- USE DOUBLE LOCK NUTS AT EACH CONDUIT TERMINATION.
- WRAP ALL PRIMARY AND SECONDARY POWER CONNECTIONS WITH SUFFICIENT LAYERS OF HIGH VOLTAGE ELECTRICAL INSULATING TAPE (RUBBER SPLICING TAPE SUITABLE FOR PRIMARY ELECTRICAL INSULATION FOR SPLICING CABLE FROM 600 VOLTS TO 69,000 VOLTS) AND COVER WITH VINYL ELECTRICAL TAPE (ALL-WEATHER VINYL INSULATING TAPE SUITABLE FOR PROTECTIVE JACKETING FOR HIGH-VOLTAGE CABLE SPLICES AND REPAIRS) FOR FULL VALUE OF CABLE INSULATION VOLTAGE. PER ILLINOIS STANDARD SPECIFICATIONS FOR CONSTRUCTION OF AIRPORTS ITEM 108, ITEM 125 AND FAA AC 150/5370-10G ITEM L-108, HIGH VOLTAGE ELECTRICAL INSULATING TAPE SHALL BE 3M SCOTCH 23, 3M SCOTCH 130C OR APPROVED EQUIVALENT, AND VINYL ELECTRICAL TAPE SHALL BE 3M SCOTCH 88 OR APPROVED EQUIVALENT. TAPES MUST BE RATED SUITABLE FOR THE APPLICATION.
- UNLESS OTHERWISE NOTED, ALL SINGLE CONDUCTOR CONTROL WIRING SHALL BE NO. 12 AWG. COPPER MINIMUM.
- THE FOLLOWING SHALL APPLY TO RELAY/CONTACTOR PANELS/ENCLOSURES:
 - FOR INTERIOR LOCATIONS ALL COMPONENTS SHALL BE MOUNTED IN NEMA 12 (DUST TIGHT) ENCLOSURE(S) WITH VERTICALLY HINGED COVERS. FOR EXTERIOR/OUTDOOR LOCATIONS ALL COMPONENTS SHALL BE MOUNTED IN NEMA 4X STAINLESS STEEL ENCLOSURE(S) WITH VERTICALLY HINGED COVERS. ALL CONDUIT ENTRIES INTO NEMA 4, 4X ENCLOSURES SHALL HAVE NEMA 4 HUBS LISTED SUITABLE FOR THE RESPECTIVE ENCLOSURE TO MAINTAIN THE NEMA 4, 4X RATING OF THE ENCLOSURE.
 - THE ENCLOSURE(S) SHALL HAVE AMPLE SPACE FOR THE CIRCUIT COMPONENTS, TERMINAL BLOCKS AND INCOMING AND INTERNAL WIRING.
 - ALL CONTROL CONDUCTOR TERMINATIONS SHALL BE OF THE OPEN-EYE CONNECTOR/SCREW TYPE. SOLDERED CLOSED-EYE TERMINATIONS, OR TERMINATIONS WITHOUT CONNECTORS ARE NOT ACCEPTABLE.
 - WHEN THE ENCLOSURE COVER IS OPENED, ALL CIRCUIT COMPONENTS, WIRING AND TERMINALS SHALL BE EXPOSED AND ACCESSIBLE WITHOUT REMOVAL OF ANY PANELS, COVERS, ETC., EXCEPT THOSE COVERING HIGH VOLTAGE COMPONENTS.
 - ACCESS TO, OR REMOVAL OF A CIRCUIT COMPONENT OR TERMINAL BLOCK WILL NOT REQUIRE THE REMOVAL OF ANY OTHER CIRCUIT COMPONENT OR TERMINAL BLOCK.
 - EACH CIRCUIT COMPONENT SHALL BE CLEARLY IDENTIFIED INDICATING ITS CORRESPONDING NUMBER SHOWN ON THE DRAWINGS AND ITS FUNCTION.
 - A COMPLETE WIRING DIAGRAM SHALL BE MOUNTED ON THE INSIDE OF THE COVER. THE DIAGRAM SHALL REPRESENT EACH CONDUCTOR BY A SEPARATE LINE.
 - THE DIAGRAM SHALL IDENTIFY EACH CIRCUIT COMPONENT AN NUMBERING AND COLOR OF EACH TERMINAL CONDUCTOR AND TERMINAL.
 - ALL WIRING SHALL BE NEATLY TRAINED AND LACED.
 - MINIMUM WIRE SIZE SHALL BE NO. 12 AWG.
- FURNISH & INSTALL A WEATHERPROOF WARNING LABEL FOR EACH METER SOCKET, SERVICE DISCONNECT, SAFETY SWITCH, CUTOFF, PANELBOARD, & CONTROL PANEL TO WARN PERSONS OF POTENTIAL ELECTRIC ARC FLASH HAZARDS, PER THE REQUIREMENTS OF NEC 110.16 "ARC FLASH HAZARD WARNING".

AIRFIELD LIGHTING NOTES

- 1. UNLESS OTHERWISE NOTED, ALL UNDERGROUND AIRFIELD LIGHTING SERIES CIRCUIT CONDUCTORS WHETHER DEB OR IN DUCT/CONDUIT SHALL BE FAA APPROVED 5000 VOLT L-824 TYPE. ALL UNDERGROUND FIELD POWER LOW VOLTAGE (600 VOLT & BELOW) CIRCUIT CONDUCTORS WHETHER DEB OR IN DUCT/CONDUIT SHALL BE UL LISTED 600 VOLT, TYPE XLP-USE-2 COPPER CONDUCTORS. CONDUCTOR SIZES SHALL BE AS SPECIFIED, HEREIN.
- 2. NO COMPONENTS OF PRIMARY CIRCUIT SUCH AS CABLE, CONNECTORS AND TRANSFORMERS SHALL BE BROUGHT ABOVE GROUND AT EDGE LIGHTS, SIGNS, REIL, PAPI, ETC.
- 3. THERE SHALL BE NO EXPOSED POWER/CONTROL CABLES BETWEEN THE POINT WHERE THEY LEAVE THE UNDERGROUND (DEB OR L-867 BASES) AND WHERE THEY ENTER THE EQUIPMENT (SUCH AS TAXIWAY SIGNS, PAPI, REIL, ETC.) ENCLOSURES. THESE CABLES SHALL BE ENCLOSED IN RIGID CONDUIT OR IN FLEXIBLE, WATERTIGHT CONDUIT WITH BREAKABLE COUPLING(S) AT THE GRADE OR THE HOUSING COVER, AS SHOWN IN APPLICABLE DETAILS.
- 4. THE JOINTS OF THE L-823 PRIMARY CONNECTORS SHALL BE WRAPPED WITH AT LEAST ONE LAYER OF RUBBER OR SYNTHETIC RUBBER TAPE AND ONE LAYER OF PLASTIC TAPE, ONE-HALF LAPPED, EXTENDING AT LEAST 1-1/2 INCHES ON EACH SIDE OF THE JOINT, AS SHOWN ON AIRFIELD LIGHTING CABLE SPLICE DETAILS.
- 5. THE CABLE ENTRANCE INTO THE FIELD-ATTACHED L-823 CONNECTORS SHALL BE ENCLOSED BY A HEAT-SHRINKABLE TUBING WITH CONTINUOUS INTERNAL ADHESIVE, AS SHOWN ON AIRFIELD LIGHTING CABLE SPLICE DETAILS.
- 6. L-823 TYPE II, TWO-CONDUCTOR SECONDARY CONNECTORS SHALL BE CLASS 'A' (FACTORY MOLDED).
- 7. THERE SHALL BE NO SPLICES IN THE SECONDARY CABLE(S) WITHIN THE STEMS OF A RUNWAY/TAXIWAY EDGE/THRESHOLD LIGHTING FIXTURE AND THE WIREWAYS LEADING TO TAXIWAY SIGNS AND PAPI/REIL EQUIPMENT.
- 8. ELECTRICAL INSULATING GREASE SHALL BE APPLIED WITHIN THE L-823, SECONDARY, TWO CONDUCTOR CONNECTORS TO PREVENT WATER ENTRANCE. THESE CONNECTORS SHALL NOT BE TAPED.
- 9. DEB ISOLATION TRANSFORMERS SHALL BE BURIED AT A DEPTH OF TEN (10") INCHES ON A LINE CROSSING THE LIGHT AND PERPENDICULAR TO THE RUNWAY/TAXIWAY CENTERLINE AT A LOCATION TWELVE (12") INCHES FROM THE LIGHT OPPOSITE FROM THE RUNWAY/TAXIWAY.
- 10. A SLACK OF THREE (3') FEET, MINIMUM, PLUS DEPTH OF BASE CAN (IF APPLICABLE), SHALL BE PROVIDED IN THE PRIMARY CABLE AT EACH TRANSFORMER/CONNECTOR TERMINATION. AT STAKE-MOUNTED LIGHTS, THE SLACK SHALL BE LOOSELY COILED IMMEDIATELY BELOW THE ISOLATION TRANSFORMER. THERE SHALL BE NO ADDITIONAL PAYMENT FOR CABLE SLACK AND THEREFORE THE QUANTITY OF PROPOSED CABLE SLACK HAS NOT BEEN INCLUDED IN THE RESPECTIVE CABLE PAY ITEMS.
- 11. DIRECTION OF PRIMARY CABLES SHALL BE IDENTIFIED BY COLOR CODING AS FOLLOWS: WHEN FACING LIGHT WITH BACK TO PAVEMENT, CABLE TO THE LEFT IS CODED RED AND CABLE TO RIGHT IS CODED BLUE. THIS APPLIES TO STAKE MOUNTED LIGHTS AND BASE MOUNTED LIGHTS WHERE THE BASE HAS ONLY ONE ENTRANCE.
- 12. L-867 BASES SHALL BE SIZE B, 24" DEEP, CLASS I, UNLESS OTHERWISE NOTED.
- 13. BASE MOUNTED BREAKABLE COUPLINGS SHALL NOT HAVE WEEP HOLES TO THE OUTSIDE. PLUGGED UP HOLES SHALL NOT BE ACCEPTABLE. IT SHALL BE A 1/4" DIAMETER, MINIMUM, OR EQUIVALENT OPENING FOR DRAINAGE FROM THE SPACE AROUND THE SECONDARY CONNECTOR INTO THE L-867 BASE.
- 14. THE ELEVATION OF THE BREAKABLE COUPLING GROOVE SHALL NOT EXCEED 1-1/2" ABOVE THE EDGE OF THE COVER IN CASE OF BASE MOUNTED COUPLINGS, OR THE TOP OF THE STAKE IN CASE OF STAKE MOUNTED COUPLINGS.
- 15. WHERE THE BREAKABLE COUPLING IS NOT AN INTEGRAL PART OF THE LIGHT FIXTURE STEM OR MOUNTING LEG, A BEAD OF SILICON SEAL SHALL BE APPLIED COMPLETELY AROUND LIGHT STEM OR WIREWAY AT BREAKABLE COUPLING TO PROVIDE A WATERTIGHT SEAL.
- 16. TOPS OF THE STAKES SUPPORTING LIGHT FIXTURES SHALL BE FLUSH WITH THE SURROUNDING GRADE.
- 17. PLASTIC LIGHTING FIXTURE COMPONENTS, SUCH AS LAMP HEADS, STEMS, BREAKABLE COUPLINGS, BASE COVERS, BRACKETS, STAKES, SHALL NOT BE ACCEPTABLE.
- 18. THE TOLERANCE FOR THE HEIGHT OF RUNWAY/TAXIWAY EDGE LIGHTS SHALL BE: ONE (1) INCH. IN CASE OF STAKE MOUNTED LIGHTS, THE SPECIFIED LIGHTING FIXTURE HEIGHT SHALL BE MEASURED BETWEEN THE TOP OF THE STAKE AND THE TOP OF THE LENS. IN CASE OF BASE MOUNTED LIGHTS, THE SPECIFIED LIGHTING FIXTURE HEIGHT SHALL BE MEASURED BETWEEN THE TOP OF THE BASE FLANGE AND THE TOP OF THE LENS, THUS INCLUDING THE BASE COVER, THE FRANGIBLE COUPLING, THE STEM, THE LAMP HOUSING AND THE LENS.
- 19. THE TOLERANCE FOR THE LATERAL SPACING (LIGHT LANE TO RUNWAY/TAXIWAY CENTERLINE) OF RUNWAY/TAXIWAY EDGE LIGHTS SHALL BE ONE (1) INCH. THIS ALSO APPLIES AT INTERSECTIONS TO LATERAL SPACING BETWEEN LIGHTS OF A RUNWAY/TAXIWAY AND THE INTERSECTING RUNWAY/TAXIWAY.

GROUNDING NOTES FOR AIRFIELD LIGHTING

- 20. ENTRANCES INTO L-867 BASES SHALL HAVE CONDUIT COUPLINGS OR REDUCERS TO INTERFACE UNIT DUCT/CONDUIT TO L-867 BASE HUBS, OR SHALL BE SEALED WITH HEAT SHRINK.
- 21. GALVANIZED/PAINTED EQUIPMENT/COMPONENT SURFACES SHALL NOT BE DAMAGED BY DRILLING, FILING, ETC. DRAIN HOLES IN METAL TRANSFORMER HOUSINGS SHALL BE MADE BEFORE GALVANIZING.
- 22. EDGE LIGHT NUMBERING TAGS SHALL BE FACING THE PAVEMENT.
- 23. CABLE/SPLICE/DUCT MARKERS SHALL BE PRECAST CONCRETE OF THE SIZE SHOWN. LETTERS/NUMBERS/ARROWS FOR THE LEGEND TO BE IMPRESSED INTO THE TOPS OF THE MARKERS SHALL BE PRE-ASSEMBLED AND SECURED IN THE MOLD BEFORE THE CONCRETE IS POURED. LEGEND INSCRIBED BY HAND IN WET CONCRETE SHALL NOT BE ACCEPTABLE.
- 24. ALL UNDERGROUND CABLE RUNS SHALL BE IDENTIFIED BY CABLE MARKERS AT 200 FEET MAXIMUM SPACING, WITH AN ADDITIONAL MARKER AT EACH CHANGE OF DIRECTION OF THE CABLE RUN. CABLE MARKERS SHALL BE INSTALLED IMMEDIATELY ABOVE THE CABLES.
- 25. THERE SHALL BE NO SPLICES BETWEEN THE ISOLATION TRANSFORMERS. L-823 CONNECTORS ARE ALLOWED AT TRANSFORMER CONNECTIONS ONLY, UNLESS OTHERWISE SHOWN.
- 26. APPLY AN OXIDE INHIBITING, ANTI-SEIZING COMPOUND TO ALL SCREWS, NUTS AND BREAKAGE COUPLING THREADS.
- 27. LOCATIONS OF ENDS OF ALL UNDERGROUND DUCTS SHALL BE IDENTIFIED BY DUCT MARKERS.
- 28. WHERE A PARALLEL, CONSTANT VOLTAGE PAPI SYSTEM IS PROVIDED, THE "T" SPLICES SHALL BE OF THE CAST TYPE.
- 29. CONCRETE USED FOR SLABS, FOOTINGS, BACKFILL AROUND TRANSFORMER HOUSINGS, MARKINGS, ETC. SHALL BE 3500 PSI (MINIMUM) AT 14 DAYS, IN ACCORDANCE WITH ITEM 610 STRUCTURAL PORTLAND CEMENT CONCRETE.
- 30. ALL POWER AND CONTROL CABLES IN MAN/HAND HOLES SHALL BE TAGGED. USE EMBOSSED COPPER STRIPS TO BE ATTACHED AT BOTH ENDS TO THE CABLE BY THE USE OF PLASTIC STRAPS. MINIMUM OF TWO TAGS SHALL BE PROVIDED ON EACH CABLE IN A MAN/HAND HOLE-ONE AT THE CABLE ENTRANCE AND ONE AT THE CABLE EXIT.
- 31. THE LOCATION, SIZE AND TYPE OF MATERIAL OF EXISTING UNDERGROUND AND/OR ABOVEGROUND UTILITIES INDICATED ON THE PLANS IS NOT REPRESENTED AS BEING ACCURATE, SUFFICIENT OR COMPLETE. NEITHER THE OWNER NOR THE ENGINEER ASSUMES ANY RESPONSIBILITY WHATSOEVER IN RESPECT TO ACCURACY, COMPLETENESS, OR SUFFICIENCY OF THE INFORMATION. THERE IS NO GUARANTEE EITHER EXPRESSED OR IMPLIED, THAT THE LOCATIONS, SIZE AND TYPE OF MATERIAL OF EXISTING UNDERGROUND UTILITIES INDICATED ARE REPRESENTATIVE OF THOSE TO BE ENCOUNTERED IN THE CONSTRUCTION. IT SHALL BE THE CONTRACTOR'S RESPONSIBILITY TO DETERMINE THE ACTUAL LOCATION OF ALL SUCH FACILITIES, INCLUDING SERVICE CONNECTIONS TO UNDERGROUND UTILITIES. PRIOR TO CONSTRUCTION, THE CONTRACTOR SHALL NOTIFY THE UTILITY COMPANIES OF HIS OPERATIONAL PLANS AND SHALL OBTAIN FROM THE RESPECTIVE UTILITY COMPANIES DETAILED INFORMATION AND ASSISTANCE RELATIVE TO THE LOCATION OF THEIR FACILITIES AND THE WORKING SCHEDULE OF THE COMPANIES FOR REMOVAL OR ADJUSTMENT WHERE REQUIRED. IN THE EVENT AN UNEXPECTED UTILITY INTERFERENCE IS ENCOUNTERED DURING CONSTRUCTION, THE CONTRACTOR SHALL IMMEDIATELY NOTIFY THE UTILITY COMPANY OF JURISDICTION. THE OWNER'S REPRESENTATIVE AND/OR THE RESIDENT ENGINEER SHALL ALSO BE IMMEDIATELY NOTIFIED. ANY DAMAGE TO SUCH MAINS AND SERVICES SHALL BE RESTORED TO SERVICE AT ONCE AND PAID FOR BY THE CONTRACTOR AT NO ADDITIONAL COST TO THE CONTRACT. ALL UTILITY CABLES AND LINES SHALL BE LOCATED BY THE RESPECTIVE UTILITY. CONTACT JULIE (JOINT UTILITY LOCATION INFORMATION FOR EXCAVATORS) FOR UTILITY INFORMATION, PHONE: 1-800-892-0123. CONTACT THE FAA (FEDERAL AVIATION ADMINISTRATION) FOR ASSISTANCE IN LOCATING FAA CABLES AND UTILITIES. LOCATION OF FAA POWER, CONTROL AND COMMUNICATION CABLES SHALL BE COORDINATED WITH AND/OR LOCATED BY THE FAA. ALSO CONTACT AIRPORT DIRECTOR/MANAGER AND AIRPORT PERSONNEL FOR ASSISTANCE IN LOCATING UNDERGROUND AIRPORT CABLES AND/OR UTILITIES. ALSO COORDINATE WORK WITH ALL ABOVE GROUND UTILITIES.
- 32. WHEN PREPARING CABLE FOR SPLICES, THE CONTRACTOR SHALL USE A CABLE STRIPPER/PENCILLER WHENEVER CABLE CONNECTIONS ARE MADE.

- 1. GROUNDING FOR RUNWAY LIGHTS, TAXIWAY LIGHTS, AND LIGHTED TAXI GUIDANCE SIGNS SHALL BE AS DETAILED ON THE PLANS AND AS SPECIFIED HEREIN. A GROUND ROD MUST BE INSTALLED AT EACH LIGHT FIXTURE, TAXI GUIDANCE SIGN AND L-867/L-868 BASE. THE PURPOSE OF THE LIGHT BASE GROUND IS TO PROVIDE A DEGREE OF PROTECTION FOR MAINTENANCE PERSONNEL FROM POSSIBLE CONTACT WITH AN ENERGIZED LIGHT BASE OR MOUNTING STAKE THAT MAY RESULT FROM A SHORTED POWER CABLE OR ISOLATION TRANSFORMER. A LIGHT BASE GROUND SHALL BE INSTALLED AT EACH TRANSFORMER BASE/LIGHT CAN ASSOCIATED WITH RUNWAY LIGHTS, TAXIWAY LIGHTS, AND LIGHTED TAXI GUIDANCE SIGNS. A LIGHT BASE GROUND SHALL ALSO BE INSTALLED AT EACH STAKE MOUNTED LIGHT FIXTURE. A LIGHT BASE GROUND SHALL BE INSTALLED AND CONNECTED TO THE METAL FRAME OF EACH TAXI GUIDANCE SIGN AS DETAILED ON THE PLANS AND IN ACCORDANCE WITH THE RESPECTIVE TAXI GUIDANCE SIGN MANUFACTURER RECOMMENDATIONS. THE LIGHT BASE GROUND SHALL BE A #6 AWG BARE COPPER CONDUCTOR BONDED TO THE GROUND LUG ON THE RESPECTIVE L-867 TRANSFORMER BASE/LIGHT CAN OR MOUNTING STAKE AND A 3/4-INCH DIAMETER BY 10-FOOT LONG (MINIMUM) UL LISTED COPPER CLAD GROUND ROD. CONNECTIONS TO GROUND LUGS ON THE L-867 TRANSFORMER BASE/LIGHT CAN OR MOUNTING STAKE SHALL BE WITH A UL LISTED GROUNDING CONNECTOR. CONNECTIONS TO LIGHT BASES MAY ALSO BE MADE WITH A UL 467 LISTED PIPE CLAMP CONNECTED TO THE GRSC NIPPLE EXTENDING FROM A THREADED LIGHT BASE HUB. CONNECTIONS TO GROUND RODS SHALL BE MADE WITH EXOTHERMIC WELD TYPE CONNECTORS, CADWELD BY PENTAIR ERICO PRODUCTS, INC., THERMOWELD BY CONTINENTAL INDUSTRIES, INC., ULTRAWELD BY HARGER, OR APPROVED EQUAL. EXOTHERMIC WELD CONNECTIONS SHALL BE INSTALLED IN CONFORMANCE WITH THE RESPECTIVE MANUFACTURER'S DIRECTIONS USING MOLDS AS REQUIRED FOR EACH RESPECTIVE APPLICATION. BOLTED CONNECTIONS WILL NOT BE PERMITTED AT GROUND RODS. TOP OF GROUND RODS SHALL BE BURIED 12 INCHES MINIMUM BELOW GRADE, UNLESS SPECIFIED OTHERWISE HEREIN, FOR RESPECTIVE APPLICATIONS.
- 2. PER THE REQUIREMENTS OF FAA AC 150/5340-30J DESIGN AND INSTALLATION DETAILS FOR AIRPORT VISUAL AIDS, CHAPTER 12, PART 12.6 "LIGHT FIXTURE BONDING" IT NOTES THE FOLLOWING: BOND THE LIGHT FIXTURE TO THE LIGHT BASE INTERNAL GROUND LUG VIA A NO. 6 AWG STRANDED COPPER WIRE RATED 600 VOLTS WITH GREEN XHHW, THWN-2, OR OTHER SUITABLE INSULATION, BARE STRANDED CONDUCTOR OR A BRAIDED GROUND STRAP OF EQUIVALENT CURRENT RATING. THE BONDING CONDUCTOR LENGTH MUST BE SUFFICIENT TO ALLOW THE REMOVAL OF THE LIGHT FIXTURE FROM THE LIGHT BASE FOR ROUTINE MAINTENANCE. SEE THE LIGHT FIXTURE MANUFACTURER'S INSTRUCTIONS FOR PROPER METHODS OF ATTACHING A BONDING WIRE TO THE FIXTURE.
- 3. STEEL USED TO MANUFACTURE GROUND RODS SHALL BE 100 PERCENT DOMESTIC STEEL.
- 4. CLEAN ALL METAL SURFACES BEFORE MAKING GROUND CONNECTIONS. METALLIC SURFACES TO BE JOINED SHALL BE PREPARED BY THE REMOVAL OF ALL NON-CONDUCTIVE MATERIAL PER 2017 NATIONAL ELECTRICAL CODE ARTICLE 250-12.
- 5. THE RESISTANCE TO GROUND OF THE RESPECTIVE MOUNTING STAKE OR LIGHT BASE (WITH GROUND ROD CONNECTED) MUST BE 25 OHMS OR LESS.
- 6. FOR EACH AIRFIELD LIGHT FIXTURE, TAXI GUIDANCE SIGN, JUNCTION STRUCTURE/L-867 BASE/L-868 BASE, OR OTHER AIRFIELD LIGHT FIXTURE, THE CONTRACTOR SHALL TEST THE MADE ELECTRODE GROUND SYSTEM WITH AN INSTRUMENT SPECIFICALLY DESIGNED FOR TESTING GROUNDING SYSTEMS. TEST RESULTS SHALL BE RECORDED FOR EACH AIRFIELD LIGHT FIXTURE AND EACH TAXI GUIDANCE SIGN INSTALLATION. IF GROUND RESISTANCE EXCEEDS 25 OHMS, LONGER GROUND RODS OR ADDITIONAL GROUND RODS MIGHT BE REQUIRED. IF GROUND RESISTANCE EXCEEDS 25 OHMS CONTACT THE PROJECT ENGINEER FOR FURTHER DIRECTION. ALSO REFER TO EOR-47643 FOR ADDITIONAL INFORMATION ON GROUNDING REQUIREMENTS WHERE APPLICABLE. COPIES OF THE GROUND SYSTEM TEST RESULTS SHALL BE FURNISHED TO THE RESIDENT ENGINEER/RESIDENT TECHNICIAN AND THE PROJECT ENGINEER.

JAN 22, 2019 2:09 PM STOLZ01647 I:\17\JOBS\17A0016\CAD\AIRPORT\TSHEETE-004-NOTES.DWG

Offices Nationwide
www.hanson-inc.com

Hanson Professional Services Inc.
1525 S. 6th Street
Springfield, IL 62703
phone: 217-788-2450
fax: 217-788-2503

Illinois Licensed
Professional Service Corporation
#184-001084

Edgar County Airport
Board of Edgar County
15551 Airport Rd.
Paris, IL 61944-8474
Telephone: 217.465.4151



EAST AIRCRAFT
PARKING RAMP
EXPANSION &
REHABILITATE PARTIAL
PARALLEL TAXIWAY TO
RUNWAY 9/27

IDA No: PRG-4558

Contract No. ED019

NO.	DATE	DESCRIPTION		
		LAY	DWN	REV

ISSUE: JANUARY 11, 2019
PROJECT NO: 17A0016D
CAD FILE: E-004-NOTES.DWG
LAYOUT BY: KNL 12/10/2018
DRAWN BY: CWS 12/10/2018
REVIEWED BY: BSS 01/11/2019

SHEET TITLE

ELECTRICAL NOTES
SHEET 2



EAST AIRCRAFT
PARKING RAMP
EXPANSION &
REHABILITATE PARTIAL
PARALLEL TAXIWAY TO
RUNWAY 9/27

IDA No: PRG-4558


Contract No. ED019

NO.	DATE	DESCRIPTION		
		LAY	DWN	REV

ISSUE: JANUARY 11, 2019
PROJECT NO: 17A0016D
CAD FILE: E-506-DTL.DWG
LAYOUT BY: KNL 12/10/2018
DRAWN BY: CWS 12/10/2018
REVIEWED BY: BSS 01/11/2019

SHEET TITLE

GROUNDING DETAILS

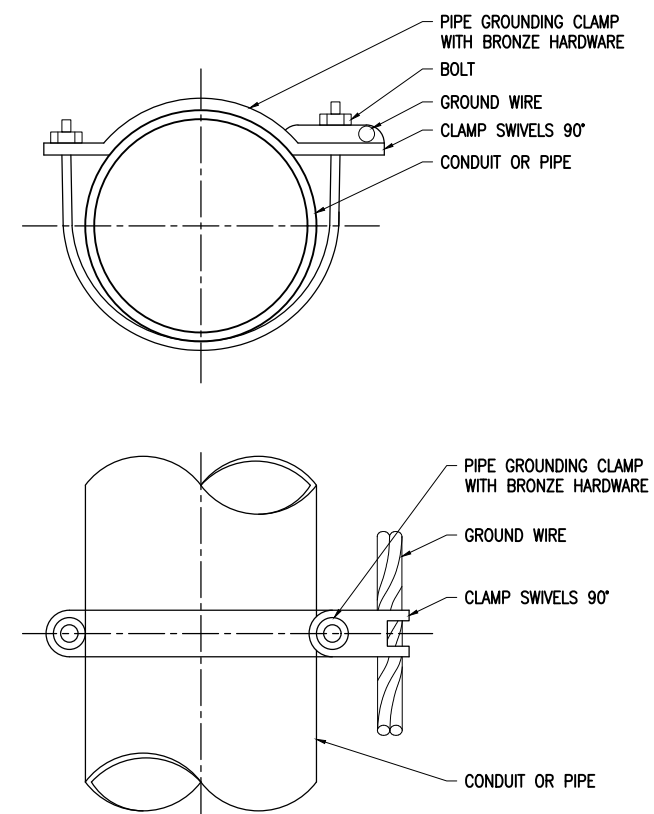


BURNDY CAT. NO.	THOMAS & BETTS CAT. NO.	PIPE SIZE
GAR3902-BU	3902BU	1/2" - 1"
GAR3903-BU	3903BU	1 1/4" - 2"
GAR3904-BU	3904BU	2 1/2" - 3 1/2"
GAR3905-BU	3905BU	4" - 5"
GAR3906-BU	3906BU	6"

NOTES

- PIPE GROUNDING CLAMPS SHALL HAVE BRONZE HARDWARE, BE CORROSION RESISTANT, SUITABLE FOR DIRECT BURIAL IN EARTH OR CONCRETE, & UL 467 LISTED.

PIPE/CONDUIT GROUNDING CLAMP DETAIL

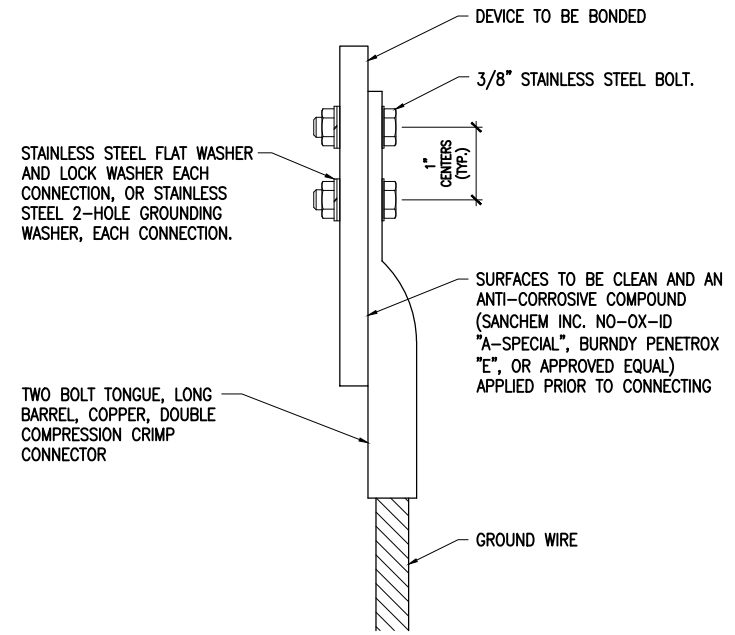


WIRE SIZE	BURNDY CAT. NO.	THOMAS & BETTS CAT. NO.	PENN-UNION CAT. NO.
#8 AWG STRANDED	YA8C-2TC38	256-30695-1157	BBLU-8D-2TC38
#6 AWG SOLID	YA8C-2TC38 OR YGA6C-2TC38E2G1		
#6 AWG STRANDED	YA6C-2TC38	256-30695-1158	BBLU-6D-2TC38
#4 AWG STRANDED	YA4C-2TC38	256-30695-1159	BBLU-4D-2TC38
#2 AWG STRANDED	YA2C-2TC38	256-30695-1160	BBLU-2D-2TC38
#2 AWG SOLID	YA3C-2TC38	256-30695-1160	BBLU-3D-2TC38
#1/0 AWG STRANDED	YA25-2TC38	256-30695-1162	BBLU-1/0D-2TC38
#2/0 AWG STRANDED	YA26-2TC38	256-30695-1116	BBLU-2/0D-2TC38
#3/0 AWG STRANDED	YA27-2TC38	54816BE	BBLU-3/0D-2TC38
#4/0 AWG STRANDED	YA28-2TC38	256-30695-1117	BBLU-4/0D-2TC38

NOTES

- ALL CONNECTIONS TO GROUND BUS BAR SHALL BE WITH 2 HOLE TONGUE LONG BARREL COMPRESSION LUGS BOLTED TO THE BUS BAR.
- GROUND WIRE CONNECTIONS TO EQUIPMENT SHALL BE WITH 2 HOLE TONGUE LONG BARREL COMPRESSION LUGS BOLTED TO THE DEVICE OR WITH THE RESPECTIVE EQUIP MANUFACTURER'S LUG OR TERMINAL WHERE APPLICABLE.
- GROUNDING ELECTRODE CONDUCTORS, BONDING JUMPERS, & INDIVIDUAL GROUND WIRES SHALL NOT BE INSTALLED IN METAL CONDUIT. WHERE PLASTIC CONDUIT IS USED FOR INDIVIDUAL GROUND WIRES, DO NOT COMPLETELY ENCIRCLE THE CONDUIT WITH FERROUS AND/OR MAGNETIC MATERIALS. WHERE METAL CLAMPS ARE INSTALLED USE NYLON BOLTS, NUTS, WASHERS, & SPACERS TO INTERRUPT A COMPLETE METALLIC APTH FROM ENCIRCLING THE CONDUIT.
- ALL CONNECTIONS SHALL BE COATED WITH A CORROSION PREVENTATIVE COMPOUND (SANCHEM INC. NO-OX-ID "A-SPECIAL", BURNDY PENETROX E, OR APPROVED EQUAL) BEFORE JOINING. ALL COPPER BUS BARS SHALL BE CLEANED PRIOR TO MAKING CONNECTIONS TO REMOVE SURFACE OXIDATION. CLEAN SURFACES, OF RESPECTIVE DEVICES TO BE BONDED, TO BARE METAL, PER NEC 250-12.

GROUNDING LUG CONNECTION DETAIL

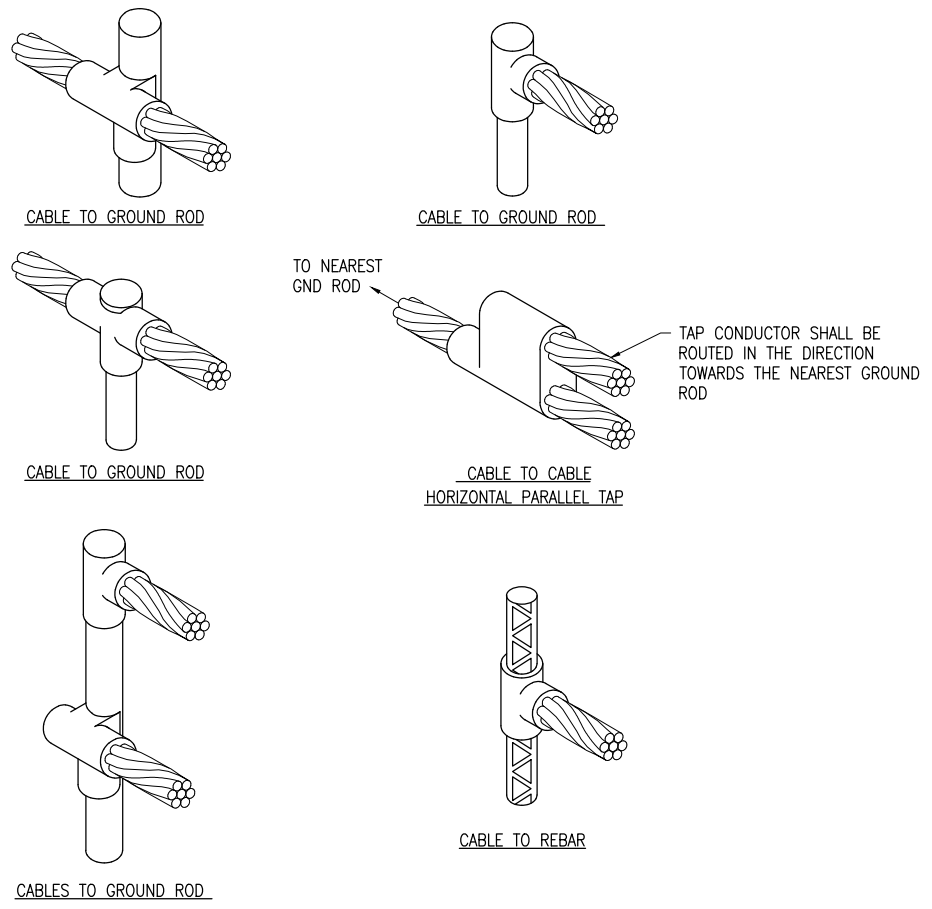

EXOTHERMIC WELD DETAILS

DETAIL NOTES

- ALL BELOW GRADE CONNECTIONS TO GROUND RODS & GROUND RING CONDUCTORS SHALL BE EXOTHERMIC WELD TYPE CONNECTIONS. EXOTHERMIC WELDS SHALL BE CADWELD AS MANUFACTURED BY PENTAIR ERICO PRODUCTS, ULTRAWELD AS MANUFACTURED BY HARGER LIGHTNING PROTECTION & GROUNDING EQUIPMENT, OR THERMOWELD AS MANUFACTURED BY CONTINENTAL INDUSTRIES OR APPROVED EQUAL. VERIFY PROPER SIZES, MOLDS, TYPES, AND REQUIREMENTS FOR THE RESPECTIVE APPLICATION WITH THE MANUFACTURER, AND INSTALL PER THEIR DIRECTIONS.
- FOR APPLICATIONS TO GALVANIZED STEEL OR PAINTED STEEL, REMOVE GALVANIZING AND/OR PAINT & CLEAN THE SURFACE TO EXPOSE BARE STEEL BEFORE MAKING EXOTHERMIC WELD CONNECTION.
- INDIVIDUAL GROUNDING ELECTRODE CONDUCTORS SHALL NOT BE INSTALLED IN METAL CONDUIT. INSTALL GROUNDING ELECTRODE CONDUCTORS IN SCHED 40 PVC CONDUIT AS REQUIRED IN FOUNDATIONS, FOR PROTECTION, WHERE ENTERING ENCLOSURES, ETC. WHERE PLASTIC CONDUIT IS USED FOR INDIVIDUAL GROUND WIRES, DO NOT COMPLETELY ENCIRCLE THE CONDUIT WITH FERROUS AND/OR MAGNETIC MATERIALS. WHERE METAL CLAMPS ARE INSTALLED USE NYLON BOLTS, NUTS, WASHERS, & SPACERS TO INTERRUPT A COMPLETE METALLIC PATH FROM ENCIRCLING THE CONDUIT.


JAN 22, 2019 2:10 PM STOLZ01647 I:\7\JOBS\17A0016D\CAD\AIRPORT\TSHEETE-506-DTL.DWG

GROUNDING NOTES

THE CONTRACTOR SHALL FURNISH AND INSTALL ALL GROUNDING AS MAY BE NECESSARY OR REQUIRED TO MAKE A COMPLETE GROUNDING SYSTEM AS REQUIRED BY THE LATEST NATIONAL ELECTRICAL CODE (NFPA 70) IN FORCE AND FAA-STD-019e (LIGHTNING AND SURGE PROTECTION, GROUNDING, BONDING, AND SHIELDING REQUIREMENTS FOR FACILITIES AND ELECTRONIC EQUIPMENT). THE RELIABILITY OF THE GROUNDING SYSTEM IS DEPENDENT ON CAREFUL, PROPER INSTALLATION AND CHOICE OF MATERIALS. IMPROPER PREPARATION OF SURFACES TO BE JOINED TO MAKE AN ELECTRICAL PATH, LOOSE JOINTS OR CORROSION CAN INTRODUCE IMPEDANCE THAT WILL SERIOUSLY IMPAIR THE ABILITY OF THE GROUND PATH TO PROTECT PERSONNEL AND EQUIPMENT AND TO ABSORB TRANSIENTS THAT CAN CAUSE NOISE IN COMMUNICATIONS CIRCUITS. THE FOLLOWING FUNCTIONS ARE PARTICULARLY IMPORTANT TO ENSURE A RELIABLE GROUND SYSTEM:

- FURNISH AND INSTALL GROUND RODS AS DETAILED HEREIN. GROUND RODS SHALL BE MINIMUM 3/4-IN. DIAMETER BY 10-FT LONG, UL-LISTED, COPPER CLAD WITH 10-MIL MINIMUM COPPER COATING (UNLESS DETAILED OTHERWISE HEREIN). GROUND RODS SHALL BE SPACED OR AS DETAILED ON THE RESPECTIVE PLANS, AND IN NO CASE SPACED LESS THAN ONE ROD LENGTH APART. ALL CONNECTIONS TO GROUND RODS AND THE GROUND RING SHALL BE MADE WITH EXOTHERMIC WELD TYPE CONNECTORS, CADWELD BY PENTAIR ERICO PRODUCTS, INC., THERMOWELD BY CONTINENTAL INDUSTRIES, INC., ULTRAWELD BY HARGER, OR APPROVED EQUAL. EXOTHERMIC WELD CONNECTIONS SHALL BE INSTALLED IN CONFORMANCE WITH THE RESPECTIVE MANUFACTURER'S DIRECTIONS USING MOLDS AS REQUIRED FOR EACH RESPECTIVE APPLICATION. BOLTED CONNECTIONS WILL NOT BE PERMITTED AT GROUND RODS OR AT BURIED GROUNDING ELECTRODE CONDUCTORS.
- CONTRACTOR SHALL TEST EACH MADE ELECTRODE GROUND ROD/GROUND FIELD/GROUND RING WITH AN INSTRUMENT SPECIFICALLY DESIGNED FOR TESTING GROUND FIELD SYSTEMS. IF GROUND RESISTANCE EXCEEDS 25 OHMS, CONTACT THE PROJECT ENGINEER FOR FURTHER DIRECTION. ALSO REFER TO EOR-47643 FOR ADDITIONAL INFORMATION ON GROUNDING REQUIREMENTS WHERE APPLICABLE. COPIES OF GROUND ROD TEST RESULTS SHALL BE FURNISHED TO THE RESIDENT ENGINEER/RESIDENT TECHNICIAN AND THE PROJECT ENGINEER.
- ALL PRODUCTS ASSOCIATED WITH THE GROUNDING SYSTEM SHALL BE UL-LISTED AND LABELED.
- ALL BOLTED OR MECHANICAL CONNECTIONS SHALL BE COATED WITH A CORROSION PREVENTATIVE COMPOUND BEFORE JOINING, SANCHEM INC. "NO-OX-ID "A-SPECIAL" COMPOUND, BURNDY PENETROX E, OR APPROVED EQUAL.
- METALLIC SURFACES TO BE JOINED SHALL BE PREPARED BY THE REMOVAL OF ALL NON-CONDUCTIVE MATERIAL, PER 2017 NATIONAL ELECTRICAL CODE ARTICLE 250-12. ALL COPPER BUS BARS MUST BE CLEANED PRIOR TO MAKING CONNECTIONS TO REMOVE SURFACE OXIDATION.
- METALLIC RACEWAY FITTINGS SHALL BE MADE UP TIGHT TO PROVIDE A PERMANENT LOW IMPEDANCE PATH FOR ALL CIRCUITS. METAL CONDUIT TERMINATIONS IN ENCLOSURES SHALL BE BONDED TO THE ENCLOSURE WITH UL-LISTED FITTINGS SUITABLE FOR GROUNDING. PROVIDE GROUNDING BUSHINGS WITH BONDING JUMPERS FOR ALL METAL CONDUITS ENTERING SERVICE EQUIPMENT (METER BASE, CT CABINET, MAIN SERVICE BREAKER ENCLOSURE, ETC.). PROVIDE GROUNDING BUSHINGS WITH BONDING JUMPERS FOR ALL METAL CONDUITS ENTERING AN ENCLOSURE THROUGH CONCENTRIC OR ECCENTRIC KNOCKOUTS THAT ARE PUNCHED OR OTHERWISE FORMED SO AS TO IMPAIR THE ELECTRICAL CONNECTION TO GROUND. STANDARD LOCKNUTS OR BUSHINGS SHALL NOT BE THE SOLE MEANS FOR BONDING WHERE A CONDUIT ENTERS AN ENCLOSURE THROUGH A CONCENTRIC OR ECCENTRIC KNOCKOUT
- ALL CONNECTIONS, LOCATED ABOVE GRADE, BETWEEN THE DIFFERENT TYPES OF GROUNDING CONDUCTORS SHALL BE MADE USING UL-LISTED DOUBLE COMPRESSION CRIMP TYPE CONNECTORS OR UL-LISTED BOLTED GROUND CONNECTORS. FOR GROUND CONNECTIONS TO ENCLOSURES, CASES AND FRAMES OF ELECTRICAL EQUIPMENT NOT SUPPLIED WITH GROUND LUGS THE CONTRACTOR SHALL DRILL REQUIRED HOLES FOR MOUNTING A BOLTED GROUND CONNECTOR. ALL BOLTED GROUND CONNECTORS SHALL BE BURNDY, DOSSERT CORPORATION, ILSCO CORPORATION, PENN-UNION CORPORATION, THOMAS & BETTS, OR APPROVED EQUAL. TIGHTEN CONNECTIONS TO COMPLY WITH TIGHTENING TORQUES IN UL STANDARD 486A TO ASSURE PERMANENT AND EFFECTIVE GROUNDING.
- ALL METAL EQUIPMENT ENCLOSURES, CONDUITS, CABINETS, BOXES, RECEPTACLES, MOTORS, ETC. SHALL BE BONDED TO THE RESPECTIVE GROUNDING SYSTEM.
- PROVIDE ALL BOXES FOR PROPOSED OUTLETS, SWITCHES, CIRCUIT BREAKERS, ETC. WITH GROUNDING SCREWS. PROVIDE ALL PANELBOARD, SWITCHGEAR, ETC., ENCLOSURES WITH GROUNDING BARS WITH INDIVIDUAL SCREWS, LUGS, CLAMPS, ETC., FOR EACH OF THE GROUNDING CONDUCTORS THAT ENTER THEIR RESPECTIVE ENCLOSURES.
- EACH NEW FEEDER CIRCUIT AND/OR BRANCH CIRCUIT SHALL INCLUDE AN EQUIPMENT GROUND WIRE. METAL RACEWAY OR CONDUIT SHALL NOT MEET THIS REQUIREMENT. THE EQUIPMENT GROUND WIRE FROM EQUIPMENT SHALL NOT BE SMALLER THAN ALLOWED BY 2017 NEC TABLE 250-122 "MINIMUM SIZE CONDUCTORS OR GROUNDING RACEWAY AND EQUIPMENT." WHEN CONDUCTORS ARE ADJUSTED IN SIZE TO COMPENSATE FOR VOLTAGE DROP, EQUIPMENT-GROUNDING CONDUCTORS SHALL BE ADJUSTED PROPORTIONATELY ACCORDING TO CIRCULAR MIL AREA. ALL EQUIPMENT GROUND WIRES SHALL BE COPPER, EITHER BARE OR INSULATED GREEN IN COLOR. WHERE THE EQUIPMENT GROUNDING CONDUCTORS ARE INSULATED, THEY SHALL BE IDENTIFIED BY THE COLOR GREEN, AND SHALL BE THE SAME INSULATION TYPE AS THE PHASE CONDUCTORS.

- ALL EXTERIOR METAL CONDUIT, WHERE NOT ELECTRICALLY CONTINUOUS BECAUSE OF MANHOLES, HANDHOLES, NON-METALLIC JUNCTION BOXES, ETC., SHALL BE BONDED TO ALL OTHER METAL CONDUIT IN THE RESPECTIVE DUCT RUN, AND AT EACH END, WITH A COPPER-BONDING JUMPER SIZED IN CONFORMANCE WITH 2017 NEC 250-102. WHERE METAL CONDUITS TERMINATE IN AN ENCLOSURE (SUCH AS A MOTOR CONTROL CENTER, SWITCHBOARD, ETC) WHERE THERE IS NOT ELECTRICAL CONTINUITY WITH THE CONDUIT AND THE RESPECTIVE ENCLOSURE, PROVIDE A BONDING JUMPER FROM THE RESPECTIVE ENCLOSURE GROUND BUS TO THE CONDUIT SIZED PER 2017 NEC 250-102.
- IT IS THE INTENT OF THIS SPECIFICATION THAT ALL MOTOR FRAMES, PUMP BASES ELECTRICAL EQUIPMENT ENCLOSURES, PANEL HOUSINGS, CONDUITS, BOXES, ETC. HAVE A CONTINUOUS COPPER WIRE GROUND CONNECTION AND SHALL BE POSITIVELY BONDED TO THE RESPECTIVE GROUNDING SYSTEM. CONDUIT CONNECTORS WILL NOT BE CONSIDERED AS ADEQUATE GROUNDING.
- PROVIDE A POSITIVE GROUND BOND FOR ALL OUTLET BOXES, ELECTRICAL EQUIPMENT ENCLOSURES, GROUNDING RECEPTACLES, TOGGLE SWITCHES, ETC. INSTALL A GROUNDING CONDUCTOR IN ALL WIRE AND CABLE RACEWAYS. GROUND CONDUCTOR TO HAVE 600-VOLT INSULATION AND BE IDENTIFIED BY A CONTINUOUS GREEN COLOR COATING. THEY SHALL BE USED SOLELY FOR GROUNDING PURPOSES AND BE ENTIRELY SEPARATE FROM WHITE GROUNDED NEUTRAL CONDUCTOR, EXCEPT AT SUPPLY SIDE OF WHITE DISCONNECTING MEANS, WHERE GROUNDING AND NEUTRAL SYSTEMS ARE TO BE CONNECTED TO SERVICE GROUND.
- EACH AND ALL GROUNDED CASED AND METAL PARTS ASSOCIATED WITH ELECTRICAL EQUIPMENT SHALL BE TESTED FOR CONTINUITY OF CONNECTION WITH GROUND BUS SYSTEM BY CONTRACTOR IN PRESENCE OF OWNER'S REPRESENTATIVE.
- ALL CONNECTIONS BETWEEN THE DIFFERENT TYPES OF GROUNDING CONDUCTORS ABOVE GRADE SHALL BE MADE USING BOLTED GROUND CONNECTORS. GROUND LUGS SHALL BE PROVIDED IN ALL ENCLOSURES AND WIRING TERMINATION JUNCTION BOXES. EQUIPMENT GROUNDS AND GROUNDING CONDUCTOR SHALL BE CONNECTED TO THESE GROUND LUGS. FOR GROUND CONNECTIONS TO ENCLOSURES, CASES AND FRAMES OF ELECTRICAL EQUIPMENT NOT SUPPLIED WITH GROUND LUGS THE CONTRACTOR SHALL DRILL REQUIRED HOLES FOR MOUNTING A BOLTED GROUND CONNECTOR. ALL BOLTED GROUND CONNECTORS SHALL BE BURNDY, DOSSERT CORPORATION, ILSCO CORPORATION, PENN-UNION CORPORATION, THOMAS & BETTS, OR APPROVED EQUAL.
- BOND ALL NONCURRENT-CARRYING PARTS OF METAL EQUIPMENT TO GROUND SYSTEM.
- BUILDING STRUCTURAL STEEL SYSTEM SHALL BE BONDED TO ELECTRICAL GROUND SYSTEM.
- INSTALL GROUNDING ELECTRODE CONDUCTORS, LIGHTNING PROTECTION DOWN CONDUCTORS AND SEPARATE GROUND CONDUCTORS IN SCHEDULE 40 OR SCHEDULE 80 PVC CONDUIT OR EXPOSED WHERE ACCEPTABLE TO LOCAL CODES. WHERE GROUNDING ELECTRODE CONDUCTORS, LIGHTNING PROTECTION DOWN CONDUCTORS OR INDIVIDUAL GROUND CONDUCTORS ARE RUN IN PVC CONDUIT, DO NOT COMPLETELY ENCIRCLE CONDUIT WITH FERROUS AND/OR MAGNETIC MATERIALS. USE NON-METALLIC REINFORCED FIBERGLASS STRUT SUPPORT. WHERE METAL CONDUIT CLAMPS ARE INSTALLED, USE NYLON BOLTS, NUTS, WASHERS AND SPACERS TO INTERRUPT A COMPLETE METALLIC PATH FROM ENCIRCLING THE CONDUIT. THIS IS REQUIRED TO AVOID GIRDLING OF GROUND CONDUCTORS. GIRDLING OF A GROUND CONDUCTOR IS THE RESULT OF PLACING THE CONDUCTOR IN A RING OF MAGNETIC MATERIAL. THIS RING COULD BE A METALLIC CONDUIT, U-BOLT OR STRUT SUPPORT PIPE CLAMP, OR OTHER SUPPORT HARDWARE. THE RESULT OF GIRDLING GROUND CONDUCTORS SIGNIFICANTLY INCREASES THE INDUCTIVE IMPEDANCE OF THE GROUND CONDUCTOR. INDUCTIVE AND CAPACITIVE IMPEDANCE IS A TYPE OF RESISTANCE THAT OPPOSES THE FLOW OF ALTERNATING CURRENT. ANY INCREASE IN THE IMPEDANCE OF A GROUND CONDUCTOR REDUCES ITS ABILITY TO EFFECTIVELY MITIGATE RADIO FREQUENCY NOISE IN THE GROUND SYSTEM. THE CONDITION WHERE A GROUND CONDUCTOR IS GIRDLED DURING A LIGHTNING STRIKE RESULTS IN PHENOMENA KNOWN AS SURGE IMPEDANCE LOADING. SURGE IMPEDANCE LOADING IS A RESULT OF VOLTAGE AND CURRENT REACHING 500,000 VOLTS AND 10,000 AMPS FOR A SHORT DURATION. GIRDLING FURTHER INCREASES THE IMPEDANCE AT LIGHTNING FREQUENCIES OF 100 KILOHERTZ TO 100 MEGAHERTZ. AT THESE POWER AND FREQUENCY LEVELS ANY INCREASE IN THE IMPEDANCE OF THE GROUND CONDUCTOR MUST BE CONTROLLED. DURING LIGHTNING DISCHARGE CONDITIONS A LOW INDUCTIVE IMPEDANCE PATH IS MORE IMPORTANT THAN A LOW DC RESISTANCE PATH.
- IF LOCAL CODES DICTATE THAT INDIVIDUAL GROUNDING CONDUCTORS MUST BE RUN IN METAL CONDUIT OR RACEWAY, THEN THE CONDUIT OR RACEWAY MUST BE BONDED AT EACH END OF THE RUN WITH A BONDING JUMPER SIZED EQUAL TO THE INDIVIDUAL GROUNDING CONDUCTOR OR AS REQUIRED BY 2017 NEC 250-102. NOTE THIS DOES NOT APPLY TO AC EQUIPMENT GROUNDING CONDUCTORS RUN WITH AC CIRCUITS.
- NEVER REMOVE, ALTER, OR ATTEMPT TO REPAIR CONDUCTORS OR CONDUIT SYSTEMS PROVIDING GROUNDING OR ELECTRICAL BONDING FOR ANY ELECTRICAL EQUIPMENT UNTIL ALL POWER IS REMOVED FROM EQUIPMENT. WARN ALL PERSONNEL OF THE UNGROUNDED CONDITION OF THE EQUIPMENT. DISPLAY APPROPRIATE WARNING SIGNS, SUCH AS DANGER TAGS, TO WARN PERSONNEL OF THE POSSIBLE HAZARDS.
- WHERE A CONFLICT IS DETERMINED WITH RESPECT TO GROUNDING REQUIREMENTS PER MANUFACTURER INSTALLATION INSTRUCTIONS, NEC, AND/OR THE CONTRACT DOCUMENTS, CONTACT THE RESIDENT ENGINEER OR PROJECT ENGINEER FOR FURTHER DIRECTIONS.
- GROUND RODS SHALL BE MANUFACTURED IN THE UNITED STATES OF AMERICA FROM 100 PERCENT DOMESTIC STEEL TO COMPLY WITH THE AIRPORT IMPROVEMENT PROGRAM BUY AMERICAN REQUIREMENTS AND THE STEEL PRODUCTS PROCUREMENT ACT.

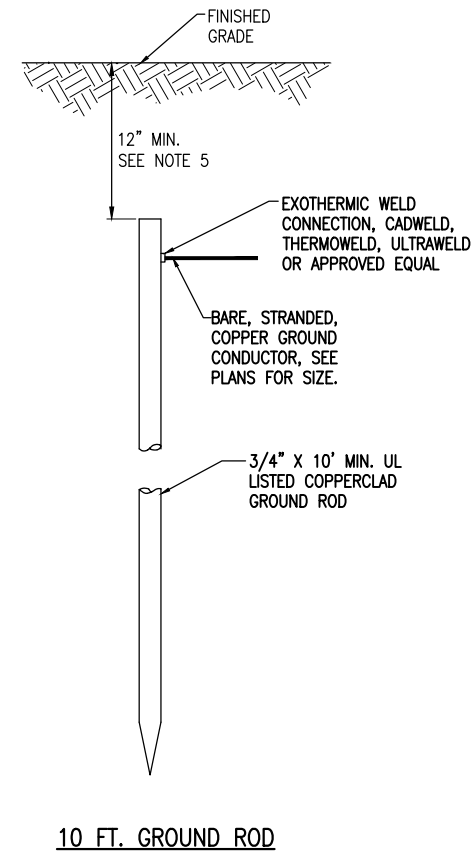

10 FT. GROUND ROD

GROUND RODS
NOT TO SCALE

NOTES

- TYPE AND MINIMUM NUMBER OF GROUND RODS SHALL BE AS SPECIFIED ON THE PLAN.
- THE RESISTANCE TO GROUND OF THE GROUNDING SYSTEM SHALL NOT EXCEED 25 OHMS.
- COST OF GROUND RODS IS INCIDENTAL TO THE ASSOCIATED ITEMS REQUIRING GROUNDING UNLESS OTHERWISE SPECIFIED.
- GROUND RODS SHALL BE SPACED AS DETAILED ON THE PLANS AND SHALL NOT BE SPACED LESS THAN ONE ROD LENGTH APART.
- TOP OF GROUND RODS FOR AIRFIELD LIGHT FIXTURES AND TAXI GUIDANCE SIGNS, SHALL BE 12" MINIMUM BELOW GRADE UNLESS DETAILED OTHERWISE HEREIN. GROUND RING CONDUCTORS SHALL BE 40" MINIMUM BELOW GRADE TO BE BELOW FROST LINE (FOR EDGAR COUNTY, ILLINOIS).

JAN 22, 2019 2:10 PM STOLZ01647
I:\17\JOBS\17A0016D\CAD\AIRPORT\ISHEETE-005-NOTES.DWG



Offices Nationwide
www.hanson-inc.com

Hanson Professional Services Inc.
1525 S. 6th Street
Springfield, IL 62703
phone: 217-788-2450
fax: 217-788-2503

Illinois Licensed
Professional Service Corporation
#184-001084

Edgar County Airport
Board of Edgar County
15551 Airport Rd.
Paris, IL 61944-8474
Telephone: 217.465.4151



EAST AIRCRAFT
PARKING RAMP
EXPANSION &
REHABILITATE PARTIAL
PARALLEL TAXIWAY TO
RUNWAY 9/27

IDA No: PRG-4558

Contract No. ED019

NO.	DATE	DESCRIPTION		
		LAY	DWN	REV

ISSUE: JANUARY 11, 2019
PROJECT NO: 17A0016D
CAD FILE: E-005-NOTES.DWG
LAYOUT BY: KNL 12/10/2018
DRAWN BY: CWS 12/10/2018
REVIEWED BY: BSS 01/11/2019

SHEET TITLE

GROUNDING NOTES



EAST AIRCRAFT
PARKING RAMP
EXPANSION &
REHABILITATE PARTIAL
PARALLEL TAXIWAY TO
RUNWAY 9/27

IDA No: PRG-4558


Contract No. ED019

NO.	DATE	DESCRIPTION		
		LAY	DWN	REV

ISSUE: JANUARY 11, 2019
PROJECT NO: 17A0016D
CAD FILE: E-507-DETL.DWG
LAYOUT BY: KNL 12/10/2018
DRAWN BY: CWS 12/10/2018
REVIEWED BY: BSS 01/11/2019

SHEET TITLE

**GROUND
RESISTANCE
TESTING DETAILS**

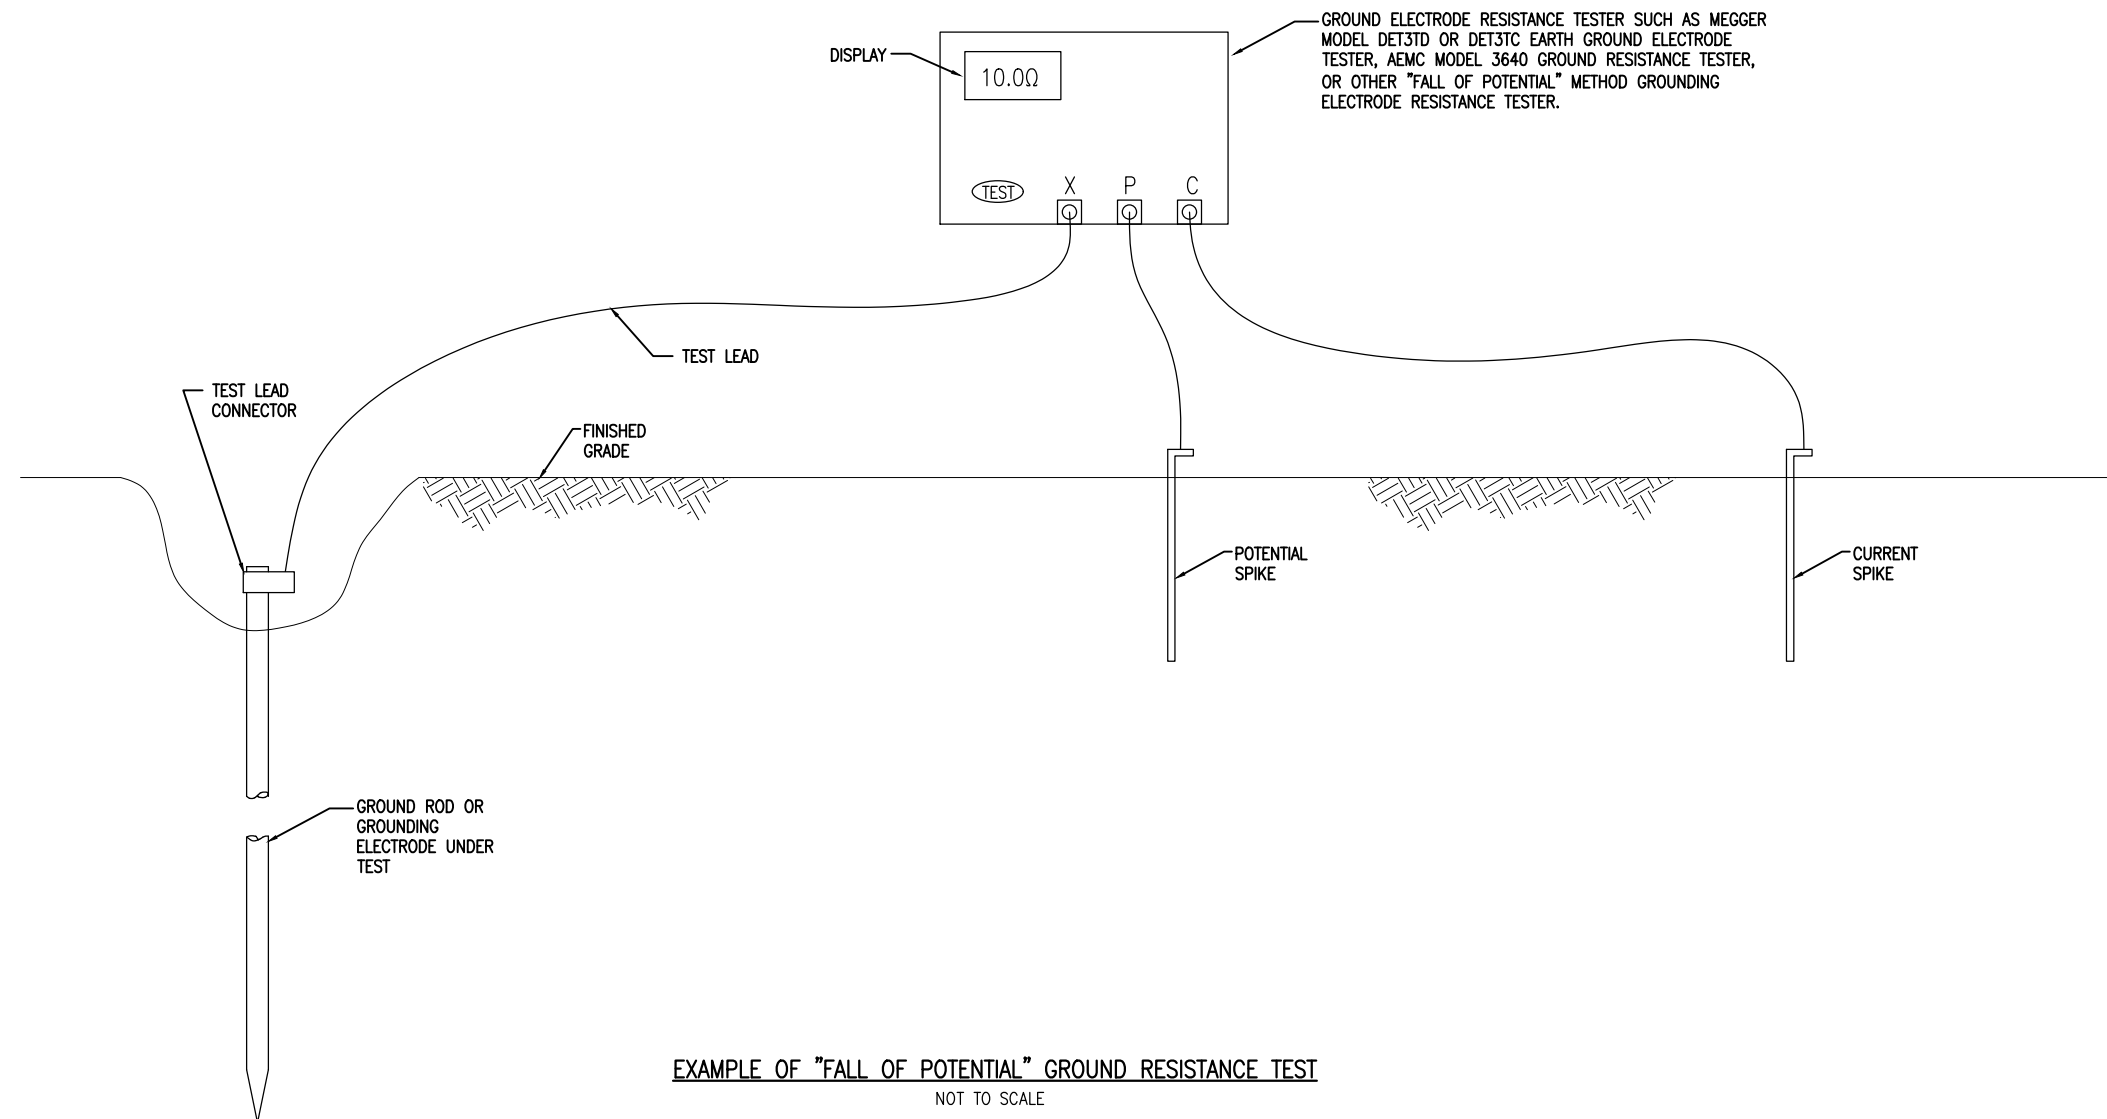

EXAMPLE OF "FALL OF POTENTIAL" GROUND RESISTANCE TEST
NOT TO SCALE

NOTES

1. CONTRACTOR SHALL TEST AND RECORD THE RESISTANCE FOR EACH MADE ELECTRODE GROUND ROD/GROUND FIELD/GROUND RING WITH AN INSTRUMENT SPECIFICALLY DESIGNED FOR TESTING GROUNDING ELECTRODE SYSTEMS. IF GROUND RESISTANCE EXCEEDS 25 OHMS, CONTACT THE PROJECT ENGINEER FOR FURTHER DIRECTION. COPIES OF GROUND ROD TEST RESULTS SHALL BE FURNISHED TO THE RESIDENT ENGINEER/RESIDENT TECHNICIAN, AND THE PROJECT ENGINEER.
2. FOR EACH AIRFIELD LIGHT FIXTURE, TAXI GUIDANCE SIGN, SPLICE CAN AND NAVAID THE CONTRACTOR SHALL TEST THE MADE ELECTRODE GROUND SYSTEM WITH AN INSTRUMENT SPECIFICALLY DESIGNED FOR TESTING GROUND SYSTEMS. TEST RESULTS SHALL BE RECORDED FOR EACH AIRFIELD LIGHT FIXTURE, TAXI GUIDANCE SIGN, AND NAVAIDS INSTALLATION. IF GROUND RESISTANCE EXCEEDS 25 OHMS, CONTACT THE PROJECT ENGINEER FOR FURTHER DIRECTION. ALSO REFER TO EOR-47643 FOR ADDITIONAL INFORMATION ON GROUNDING REQUIREMENTS WHERE APPLICABLE. COPIES OF THE GROUND SYSTEM TEST RESULTS SHALL BE FURNISHED TO THE RESIDENT ENGINEER / RESIDENT TECHNICIAN, AND THE PROJECT ENGINEER.
3. GROUND RESISTANCE TEST SHALL BE CONDUCTED IN ACCORDANCE WITH THE RESPECTIVE GROUND ELECTRODE RESISTANCE TESTING EQUIPMENT MANUFACTURER'S INSTRUCTIONS.
4. RECORD SITE CONDITIONS DURING TESTS.
5. "FALL OF POTENTIAL" TYPE GROUND ELECTRODE RESISTANCE TESTER IS RECOMMENDED FOR TESTING INDIVIDUAL STAND ALONE GROUND RODS.



EAST AIRCRAFT
PARKING RAMP
EXPANSION &
REHABILITATE PARTIAL
PARALLEL TAXIWAY TO
RUNWAY 9/27

IDA No: PRG-4558
Contract No. ED019

NO.	DATE	DESCRIPTION		
		LAY	DWN	REV

ISSUE: JANUARY 11, 2019
PROJECT NO: 17A0016D
CAD FILE: E-001-LGND.DWG
LAYOUT BY: KNL 12/10/2018
DRAWN BY: CWS 12/10/2018
REVIEWED BY: BSS 01/11/2019

SHEET TITLE

ELECTRICAL LEGEND
AND ABBREVIATIONS

ELECTRICAL LEGEND – ONE-LINE DIAGRAM	
	CABLE TERMINATOR/LUG
	TRANSFORMER
	DISCONNECT SWITCH
	FUSIBLE DISCONNECT SWITCH
	CIRCUIT BREAKER
	THERMAL MAGNETIC CIRCUIT BREAKER
	FUSE
	TRANSIENT VOLTAGE SURGE SUPPRESSOR OR SURGE PROTECTOR DEVICE
	GROUND – GROUND ROD, GROUNDING ELECTRODE, OR AT EARTH POTENTIAL
	INDICATING LIGHT
	MOTOR
	LOAD, MOTOR, # = HORSEPOWER
	ELECTRIC UTILITY METER BASE
	JUNCTION BOX WITH SPLICE
	EQUIPMENT, XXX = DEVICE DESCRIPTION
	GROUND BUS OR TERMINAL
	NEUTRAL BUS
	PANELBOARD WITH MAIN LUGS
	PANELBOARD WITH MAIN BREAKER
	FUSE PANEL WITH MAIN FUSE PULLOUT
	DUPLEX RECEPTACLE 120V SINGLE PHASE GROUNDING TYPE
	CONTROL STATION
	TRANSFER SWITCH
	ENGINE GENERATOR SET

ELECTRICAL LEGEND – SCHEMATIC	
	NORMALLY OPEN (N.O.) CONTACT
	NORMALLY CLOSED (N.C.) CONTACT
	STARTER COIL, * = STARTER NUMBER
	OVERLOAD RELAY CONTACT
	CONTROL RELAY, * = CONTROL RELAY NUMBER
	RELAY, * = RELAY NUMBER
	TOGGLE SWITCH / 2 POSITION SWITCH
	2-POSITION SELECTOR SWITCH
	3-POSITION SELECTOR SWITCH (H-O-A SHOWN)
	2 POLE DISCONNECT SWITCH
	3 POLE DISCONNECT SWITCH
	PHOTOCELL
	TERMINAL BLOCK, * = TERMINAL NUMBER
	DEVICE TERMINAL, * = DEVICE TERMINAL NUMBER
	INTERNAL PANEL WIRING
	FIELD WIRING
	FUSE
	GROUND BUS OR TERMINAL
	NEUTRAL BUS
	GROUND, GROUND ROD, GROUND BUS
	INDUSTRIAL CONTROL RELAY OR LIGHTING CONTACTOR
	S1 CUTOUT HANDLE REMOVED
	S1 CUTOUT HANDLE INSERTED
	N.O. THERMAL SWITCH
	N.C. THERMAL SWITCH
	L-830 SERIES ISOLATION TRANSFORMER

ELECTRICAL ABBREVIATIONS	
A.F.F.	ABOVE FINISHED FLOOR
A, AMP	AMPERES
ATS	AUTOMATIC TRANSFER SWITCH
AWG	AMERICAN WIRE GAUGE
BKR	BREAKER
C	CONDUIT
CB	CIRCUIT BREAKER
CKT	CIRCUIT
CR	CONTROL RELAY
CU	COPPER
DPDT	DOUBLE POLE DOUBLE THROW
DPST	DOUBLE POLE SINGLE THROW
EM	EMERGENCY
EMT	ELECTRICAL METALLIC TUBING
ENCL	ENCLOSURE
EOR	ENGINEER OF RECORD
EP	EXPLOSION PROOF
ES	EMERGENCY STOP
ETL	INTERTEK – ELECTRICAL TESTING LABS
ETM	ELAPSE TIME METER
GFCI	GROUND FAULT CIRCUIT INTERRUPTER
GFI	GROUND FAULT INTERRUPTER
GND	GROUND
GRSC	GALVANIZED RIGID STEEL CONDUIT
HID	HIGH INTENSITY DISCHARGE
HOA	HAND OFF AUTOMATIC
HP	HORSEPOWER
HPS	HIGH PRESSURE SODIUM
J	JUNCTION BOX
KVA	KILOVOLT AMPERE(S)
KW	KILOWATTS
LC	LIGHTING CONTACTOR
LTFMC	LIQUID TIGHT FLEXIBLE METAL CONDUIT (UL LISTED)
LTG	LIGHTING
LP	LIGHTING PANEL
MAX	MAXIMUM
MCB	MAIN CIRCUIT BREAKER
MCM	THOUSAND CIRCULAR MIL
MDP	MAIN DISTRIBUTION PANEL
MFR	MANUFACTURER
MH	METAL HALIDE
MIN	MINIMUM
MLO	MAIN LUGS ONLY
NEC	NATIONAL ELECTRICAL CODE (NFPA 70)
NC	NORMALLY CLOSED
NO	NORMALLY OPEN
NTS	NOT TO SCALE
OHE	OVERHEAD ELECTRIC
OL	OVERLOAD

ELECTRICAL ABBREVIATIONS (CONTINUED)	
PB	PULL BOX
PC	PHOTO CELL
PDB	POWER DISTRIBUTION BLOCK
PNL	PANEL
RCPT	RECEPTACLE
R	RELAY
S	STARTER
SPD	SURGE PROTECTION DEVICE
SPST	SINGLE POLE SINGLE THROW
TVSS	TRANSIENT VOLTAGE SURGE SUPPRESSOR
TYP	TYPICAL
UG	UNDERGROUND
UGE	UNDERGROUND ELECTRIC
UL	UNDERWRITER'S LABORATORIES
V	VOLTS
W/	WITH
W/O	WITHOUT
WP	WEATHER PROOF
XFER	TRANSFER
XFMR	TRANSFORMER

AIRPORT EQUIPMENT/FACILITY ABBREVIATIONS	
ASOS	AUTOMATED SURFACE OBSERVING SYSTEM
ATCT	AIR TRAFFIC CONTROL TOWER
AWOS	AUTOMATED WEATHER OBSERVING SYSTEM
CCR	CONSTANT CURRENT REGULATOR
DME	DISTANCE MEASURING EQUIPMENT
FAR	FEDERAL AVIATION REGULATION
GS	GLIDE SLOPE FACILITY
HIRL	HIGH INTENSITY RUNWAY LIGHT
ILS	INSTRUMENT LANDING SYSTEM
IM	INNER MARKER
LIR	LOW IMPACT-RESISTANT
LOC	LOCALIZER FACILITY
MALS	MEDIUM INTENSITY APPROACH LIGHTING SYSTEM
MALSR	MEDIUM INTENSITY APPROACH LIGHTING SYSTEM WITH RUNWAY ALIGNMENT INDICATING LIGHTS
MIRL	MEDIUM INTENSITY RUNWAY LIGHT
MITL	MEDIUM INTENSITY TAXIWAY LIGHT
NDB	NON-DIRECTIONAL BEACON
PAPI	PRECISION APPROACH PATH INDICATOR
PLASI	PULSE LIGHT APPROACH SLOPE INDICATOR
RAIL	RUNWAY ALIGNMENT INDICATING LIGHTS
REIL	RUNWAY END IDENTIFIER LIGHT
RVR	RUNWAY VISUAL RANGE
VADI	VISUAL APPROACH DESCENT INDICATOR
VASI	VISUAL APPROACH SLOPE INDICATOR
VOR	VERY HIGH FREQUENCY OMNIDIRECTIONAL RANGE FACILITY
WC	WIND CONE

NOTES:

1. ALL ELECTRICAL EQUIPMENT AND MATERIALS SHALL BE INSTALLED IN CONFORMANCE WITH NFPA 70 – NATIONAL ELECTRICAL CODE (NEC) MOST CURRENT ISSUE IN FORCE, THE RESPECTIVE EQUIPMENT MANUFACTURER'S DIRECTIONS AND ALL OTHER APPLICABLE LOCAL CODES, LAWS, ORDINANCES, AND REQUIREMENTS IN FORCE. ANY INSTALLATIONS WHICH VOID THE U.L. LISTING, INTERTEK TESTING SERVICES VERIFICATION/ETL LISTING (OR OTHER THIRD PARTY LISTING) AND/OR THE MANUFACTURER'S WARRANTY OF A DEVICE WILL NOT BE PERMITTED.
2. KEEP A COPY OF THE LATEST NEC IN FORCE ON SITE AT ALL TIMES DURING CONSTRUCTION FOR USE AS A REFERENCE.
3. VAULT WORK, POWER OUTAGES, AND/OR SHUT DOWN OF EXISTING SYSTEMS SHALL BE COORDINATED WITH THE AIRPORT MANAGER AND MAINTENANCE SUPERVISOR. ONCE SHUT DOWN, THE CIRCUITS SHALL BE LABELED AS SUCH TO PREVENT ACCIDENTAL ENERGIZING OF THE RESPECTIVE CIRCUITS. ALL PERSONNEL SHALL FOLLOW U.S. DEPARTMENT OF LABOR OCCUPATIONAL SAFETY & HEALTH ADMINISTRATION (OSHA) 29 CFR PART 1910 OCCUPATIONAL SAFETY & HEALTH STANDARDS FOR ELECTRICAL SAFETY AND LOCKOUT/TAGOUT PROCEDURES INCLUDING, BUT NOT LIMITED TO, 29 CFR SECTION 1910.147 THE CONTROL OF HAZARDOUS ENERGY (LOCKOUT/TAGOUT).
4. IN THE EVENT A CONFLICT IS DETERMINED WITH RESPECT TO MANUFACTURER INSTALLATION INSTRUCTIONS, NEC, AND/OR THE CONTRACT DOCUMENTS, CONTACT THE PROJECT ENGINEER FOR FURTHER DIRECTIONS.
5. COLOR CODE PHASE AND NEUTRAL CONDUCTOR INSULATION FOR NO. 6 AWG OR SMALLER. PROVIDE COLORED INSULATION OR COLORED MARKING TAPE FOR PHASE AND NEUTRAL CONDUCTORS FOR NO. 4 AWG AND LARGER. INSULATED GROUND CONDUCTORS SHALL HAVE GREEN COLORED INSULATION FOR ALL CONDUCTOR AWG AND/OR KCMIL TO COMPLY WITH NEC 250.119. NEUTRAL CONDUCTORS SHALL HAVE WHITE COLORED INSULATION FOR NO. 6 AWG AND SMALLER TO MEET THE REQUIREMENTS OF NEC 200.6. STANDARD COLORS FOR POWER WIRING AND BRANCH CIRCUITS SHALL BE AS FOLLOWS:
 - 120/240 VAC, 1 PHASE, 3 WIRE
 - PHASE A BLACK
 - PHASE B RED
 - NEUTRAL WHITE
 - GROUND GREEN
6. SEE RESPECTIVE SITE PLANS FOR SITE LEGEND INFORMATION.
7. LTFMC DENOTES LIQUID TIGHT FLEXIBLE METAL CONDUIT UL LISTED, SUNLIGHT RESISTANT, & SUITABLE FOR GROUNDING. LIQUID TIGHT FLEXIBLE METAL CONDUIT AND ASSOCIATED FITTINGS SHALL BE U.L. LISTED TO MEET THE REQUIREMENTS OF NEC 350.6. LIQUID TIGHT FLEXIBLE METAL CONDUIT THAT IS USED FOR FLEXIBILITY (INCLUDING CONNECTIONS TO CCR'S & TRANSFORMERS) SHALL REQUIRE AN EXTERNAL BONDING JUMPER OR INTERNAL EQUIPMENT GROUNDING CONDUCTOR PER NEC 350.60. EXTERNAL BONDING JUMPERS USED WITH CCR INSTALLATIONS SHALL BE #6 AWG COPPER (MINIMUM). DO NOT INSTALL LTFMC THAT IS NOT UL LISTED. CONFIRM LTFMC BEARS THE UL LABEL PRIOR TO INSTALLATION.
8. ALL ENCLOSURES RATED NEMA 4, 4X SHALL HAVE WATERTIGHT HUBS AT CONDUIT ENTRANCES UL LISTED NEMA 4, 4X FOR THE RESPECTIVE ENCLOSURE, TO MAINTAIN THE NEMA 4, 4X RATING.
9. CONTRACTOR SHALL FIELD VERIFY EXISTING SITE CONDITIONS. CONTRACTOR SHALL FIELD VERIFY RESPECTIVE CIRCUITS AND POWER SOURCES PRIOR TO REMOVING, DISCONNECTING, ADJUSTING, CONNECTING, OR WORKING ON THE RESPECTIVE AIRFIELD LIGHTING, TAXI SIGN, NAVIAID, OR OTHER DEVICE.
10. HIGH VOLTAGE CIRCUITS (AIRFIELD LIGHTING 5000 VOLT SERIES CIRCUITS AND OTHER CIRCUITS RATED ABOVE 600 VOLTS) AND LOW VOLTAGE CIRCUITS (RATED 600 VOLTS AND BELOW) SHALL NOT BE INSTALLED IN THE SAME WIREWAY, CONDUIT, DUCT, RACEWAY, JUNCTION STRUCTURE OR HANDHOLE.



EAST AIRCRAFT
PARKING RAMP
EXPANSION &
REHABILITATE PARTIAL
PARALLEL TAXIWAY TO
RUNWAY 9/27

IDA No: PRG-4558

Contract No. ED019

NO.	DATE	DESCRIPTION		
		LAY	DWN	REV

ISSUE: JANUARY 11, 2019

PROJECT NO: 17A0016D

CAD FILE: E-601.DWG

LAYOUT BY: KNL 12/10/2018

DRAWN BY: CWS 12/10/2018


REVIEWED BY: BSS 01/11/2019

SHEET TITLE

EXISTING
ELECTRICAL
ONE-LINE DIAGRAM -
VAULT & AIRFIELD

NOTES:

- CONTRACTOR SHALL EXAMINE THE SITE TO DETERMINE EXISTING CONDITIONS. CONTRACTOR SHALL FIELD VERIFY RESPECTIVE CIRCUITS AND POWER SOURCES PRIOR TO REMOVING, DISCONNECTING, CONNECTING, OR WORKING ON THE RESPECTIVE AIRFIELD LIGHTING, TAXI SIGN, NAVAID, OR OTHER DEVICE.
- ALL POWER OUTAGES, AND/OR SHUT DOWN OF EXISTING AIRFIELD LIGHTING OR OTHER SYSTEMS SHALL BE COORDINATED WITH THE AIRPORT MANAGER AND/OR AIRPORT REPRESENTATIVE. ONCE SHUT DOWN, THE CIRCUITS SHALL BE LABELED AS SUCH TO PREVENT ACCIDENTAL ENERGIZING OF THE RESPECTIVE CIRCUITS. ALL PERSONNEL SHALL FOLLOW U.S. DEPARTMENT OF LABOR OCCUPATIONAL SAFETY & HEALTH ADMINISTRATION (OSHA) 29 CFR PART 1910 OCCUPATIONAL SAFETY & HEALTH STANDARDS FOR ELECTRICAL SAFETY AND LOCKOUT/TAGOUT PROCEDURES INCLUDING, BUT NOT LIMITED TO, 29 CFR SECTION 1910.147 THE CONTROL OF HAZARDOUS ENERGY (LOCKOUT/TAGOUT).
- CONTRACTOR SHALL COMPLY WITH THE REQUIREMENTS OF FAA AC NO. 150/5370-2G (OR MOST CURRENT ISSUE) "OPERATIONAL SAFETY ON AIRPORTS DURING CONSTRUCTION".
- CONTRACTOR SHALL COMPLY WITH THE APPLICABLE REQUIREMENTS OF NFPA 70E - STANDARD FOR ELECTRICAL SAFETY IN THE WORKPLACE.
- THE RESPECTIVE PERSONNEL PERFORMING AIRFIELD LIGHTING WORK, VAULT WORK, AND/OR TESTS SHALL BE FAMILIAR WITH, AND QUALIFIED TO WORK ON, 5000 VOLT AIRFIELD LIGHTING SERIES CIRCUITS, CONSTANT CURRENT REGULATORS AND ASSOCIATED AIRPORT ELECTRICAL VAULT EQUIPMENT.
- MEGGER TEST AND RECORD EXISTING SERIES CIRCUITS PRIOR TO CABLE WORK AND AGAIN AFTER PAVEMENT WORK, AIRFIELD WORK, ADDITIONS, AND/OR UPGRADES HAVE BEEN COMPLETED. ALSO TEST AND RECORD SERIES CIRCUIT LOOP RESISTANCE.
- EACH CCR SHALL BE TESTED FOR PROPER OPERATION BEFORE AIRFIELD AND/OR APRON WORK BEGINS AND AGAIN AFTER AIRFIELD WORK, APRON WORK AND FUEL SYSTEM WORK IS COMPLETED.
- ALL EXISTING AIRFIELD LIGHTING SYSTEMS, NAVAIDS, APRON LIGHTING, AND/OR OTHER AIRPORT FACILITIES (THAT ARE NOT SCHEDULED FOR REMOVAL OR REPLACEMENT) SHALL BE OPERABLE DURING NIGHTFALL WHEN THE RESPECTIVE RUNWAY IS OPEN FOR OPERATION UNLESS OTHERWISE APPROVED BY THE AIRPORT MANAGER AND/OR OTHERWISE DETAILED HEREIN. CONTRACTOR SHALL PROVIDE ALL TEMPORARY WORK AS NECESSARY TO MAINTAIN OPERATION OF THE AIRFIELD LIGHTING SYSTEMS AT NIGHTFALL. CONTRACTOR SHALL COORDINATE TRANSFER OF EXISTING AIRFIELD CIRCUITS TO MINIMIZE DOWNTIME.
- OTHER PROJECTS MIGHT BE UNDER CONSTRUCTION PRIOR TO OR DURING THIS PROJECT. COORDINATE WORK WITH OTHER CONTRACTORS.

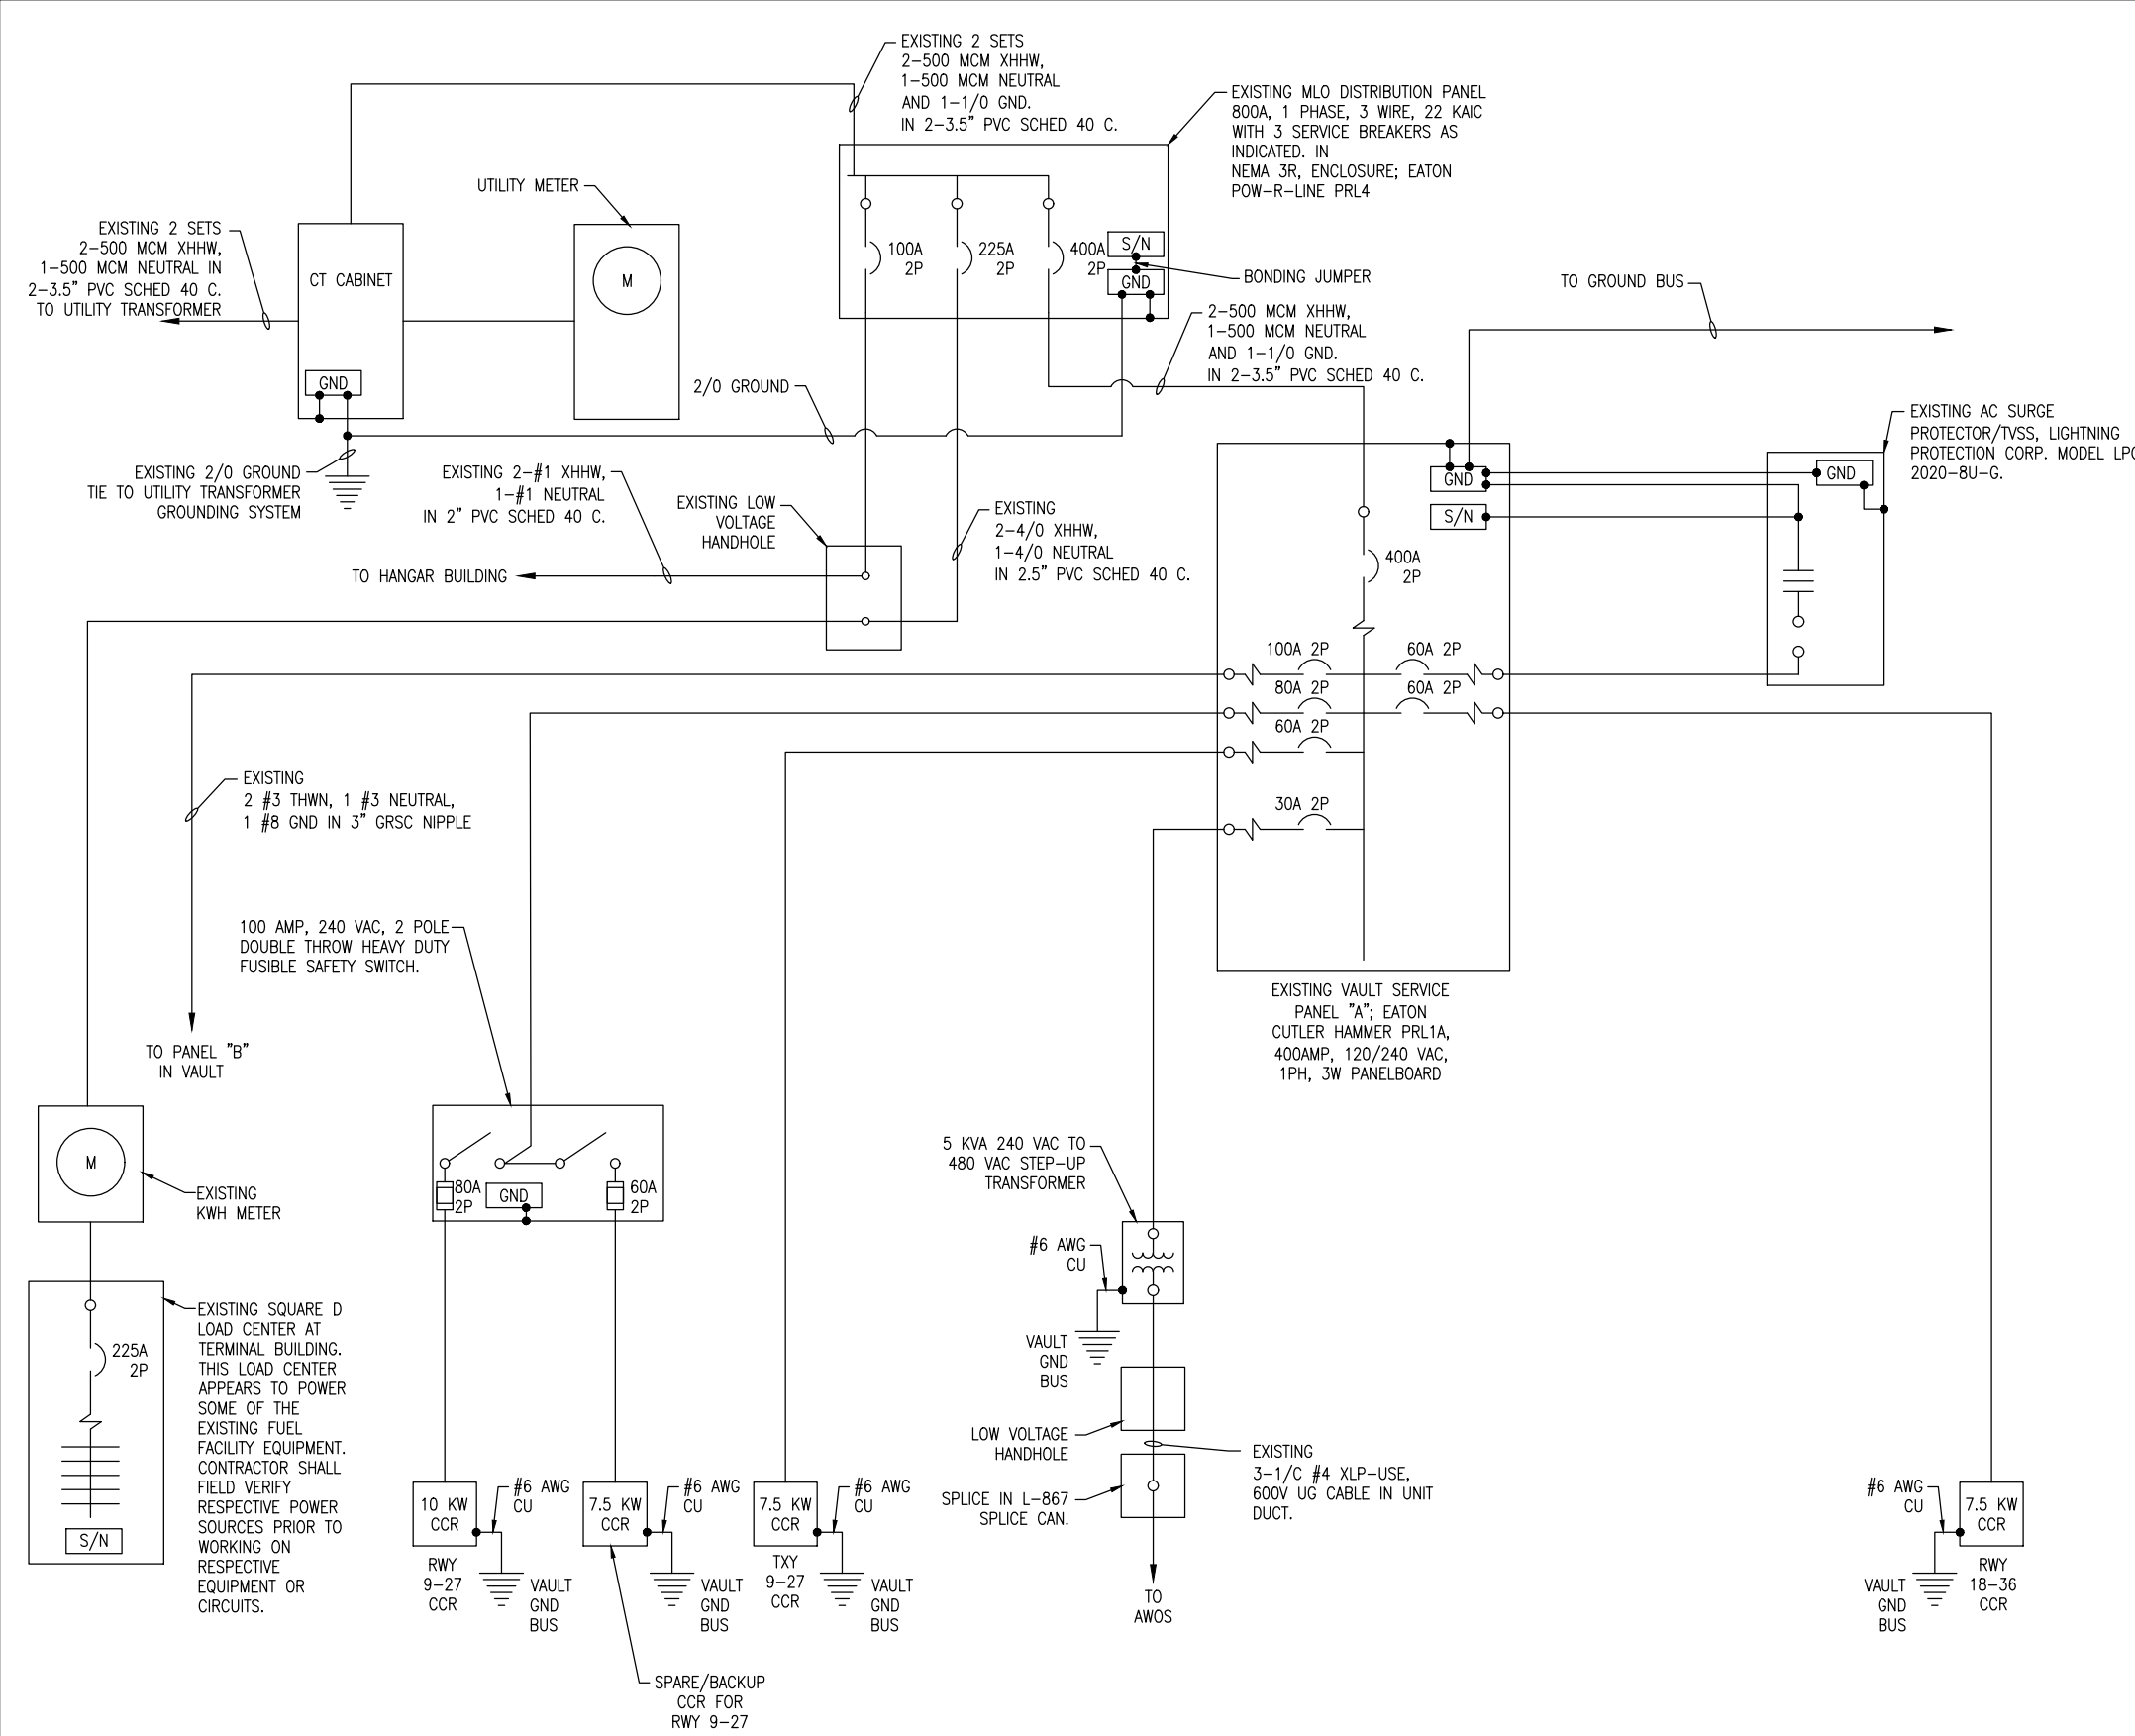

EXISTING ELECTRICAL ONE-LINE
DIAGRAM FOR VAULT AND AIRFIELD



EAST AIRCRAFT
PARKING RAMP
EXPANSION &
REHABILITATE PARTIAL
PARALLEL TAXIWAY TO
RUNWAY 9/27

IDA No: PRG-4558

Contract No. ED019

NO.	DATE	DESCRIPTION		
		LAY	DWN	REV

ISSUE: JANUARY 11, 2019


PROJECT NO: 17A0016D
CAD FILE: E-605.DWG

LAYOUT BY: KNL 12/10/2018
DRAWN BY: CWS 12/10/2018

REVIEWED BY: BSS 01/11/2019

SHEET TITLE

EXISTING ELECTRICAL ONE-LINE DIAGRAM - VAULT & AIRFIELD (CONT.)

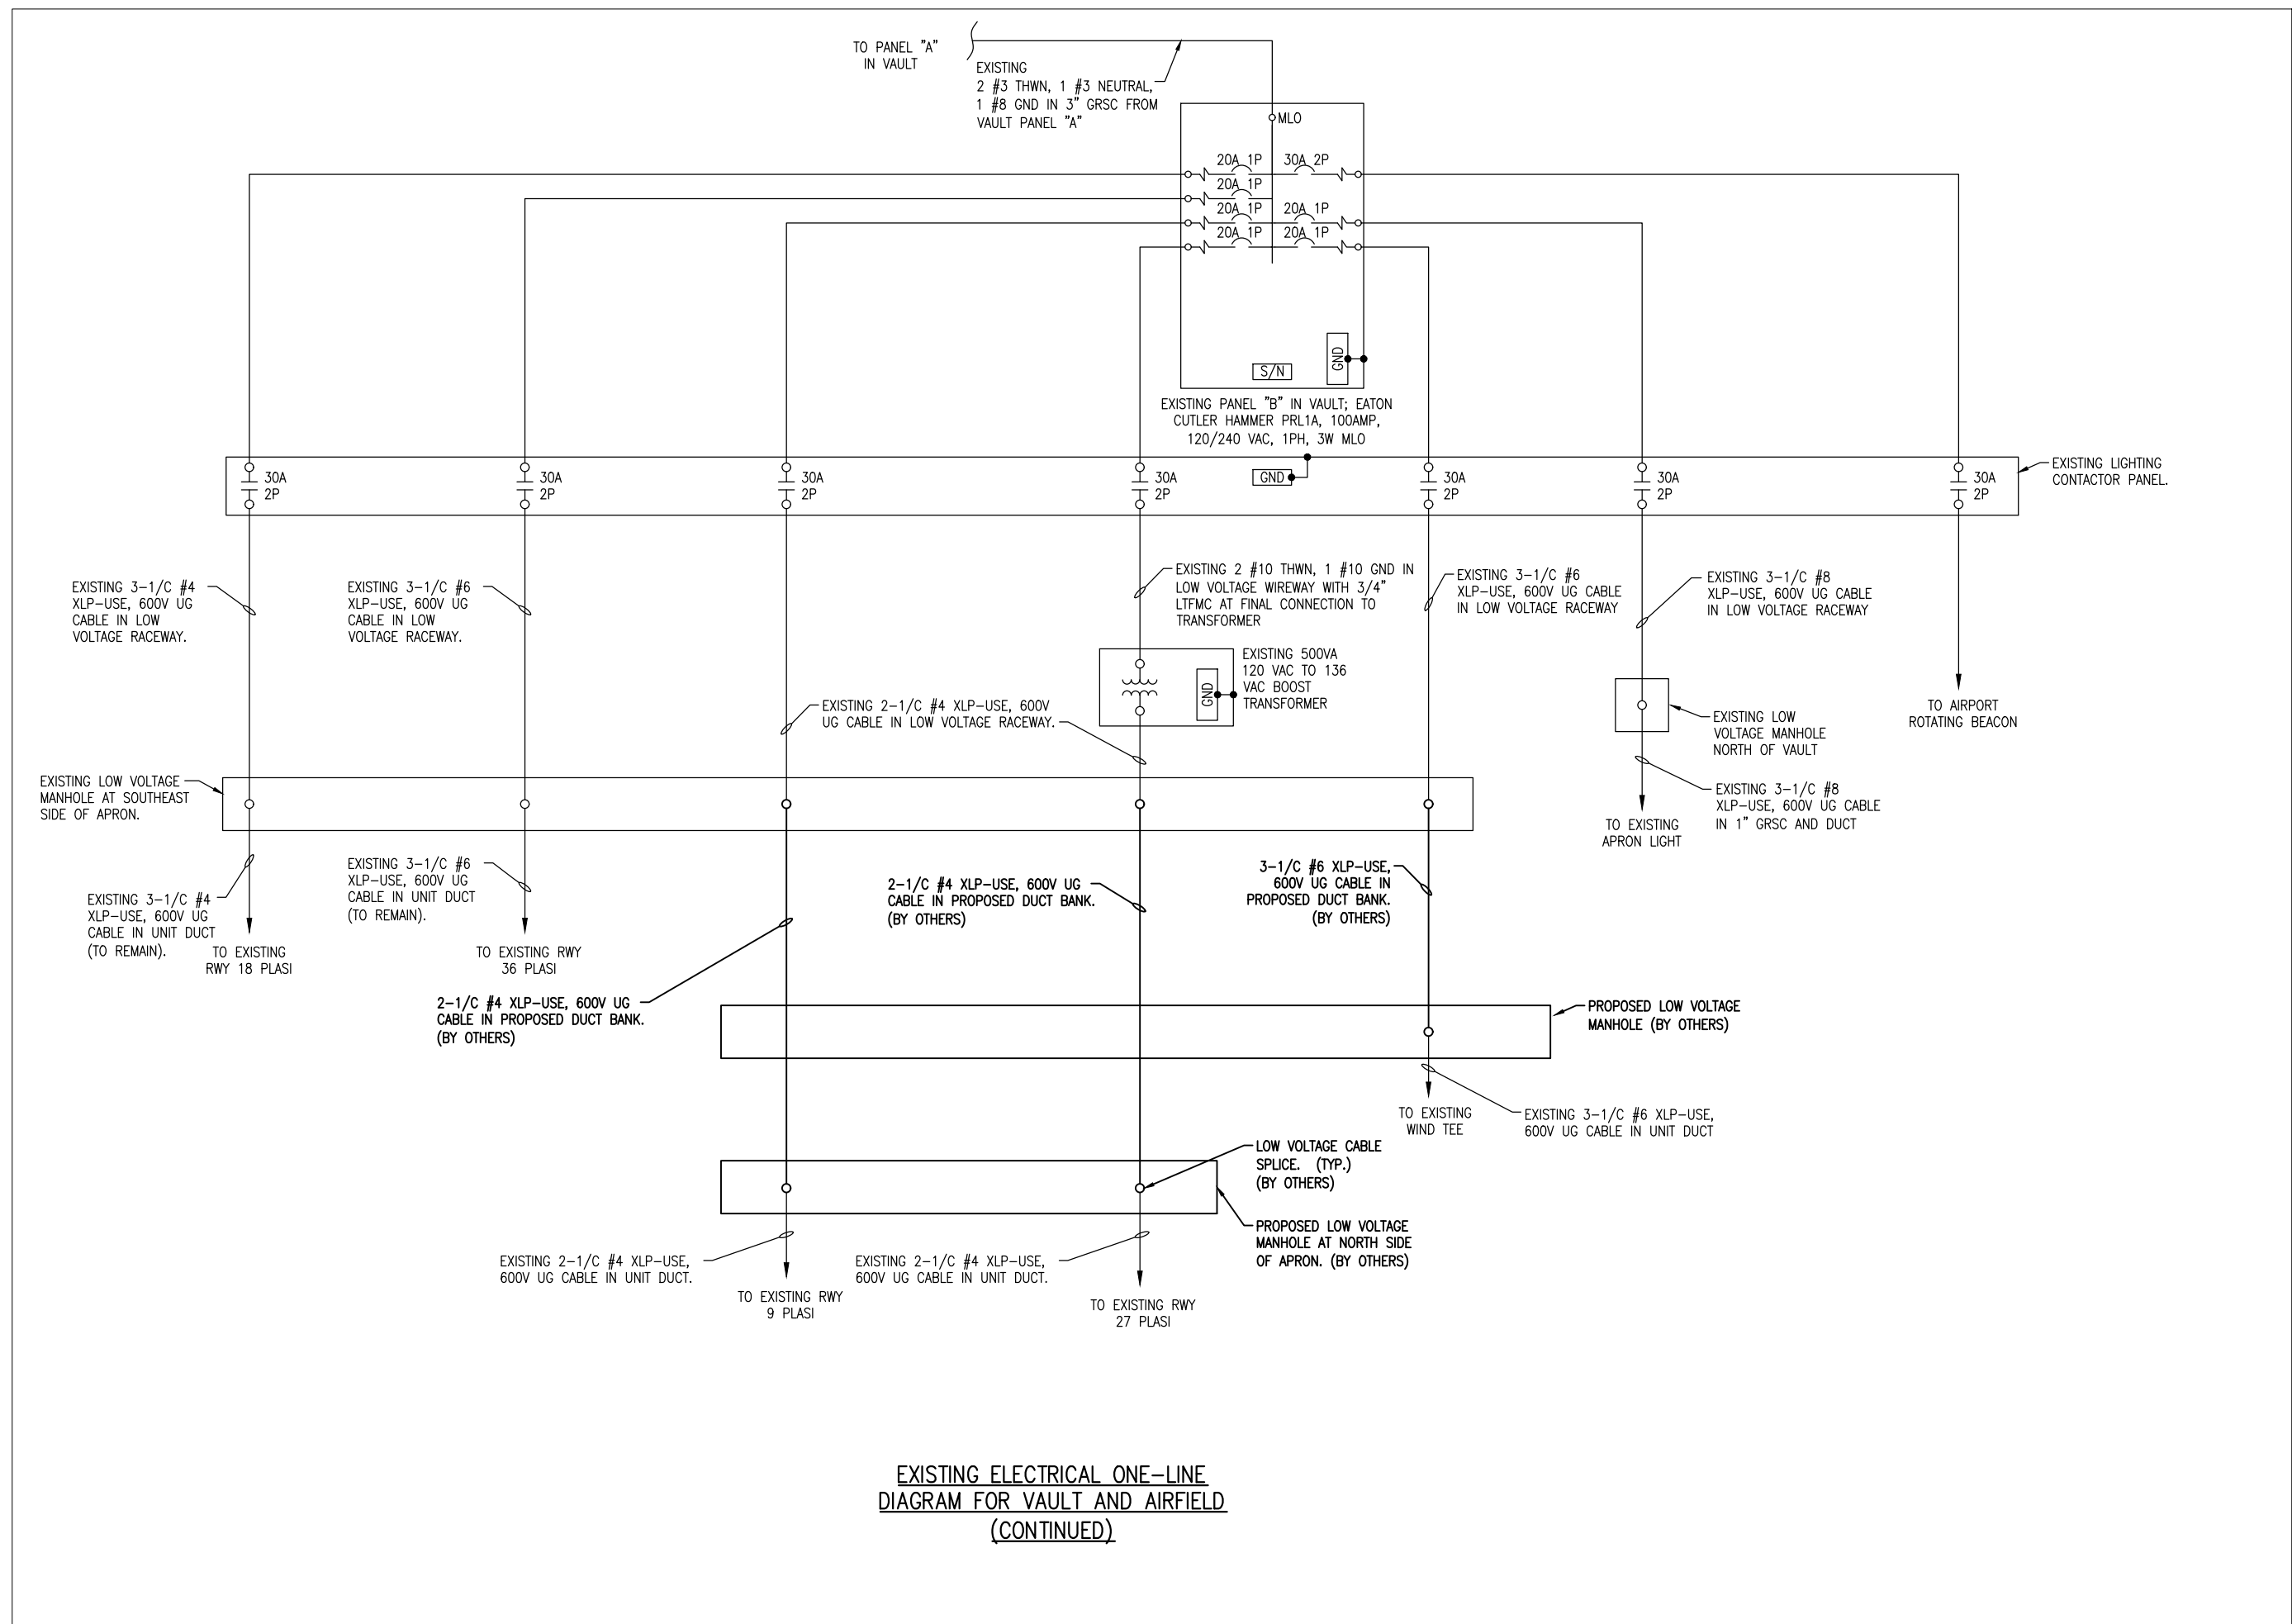

EXISTING ELECTRICAL ONE-LINE
DIAGRAM FOR VAULT AND AIRFIELD
(CONTINUED)

JAN 22, 2019 2:11 PM STOLZ01647
I:\17\JOBS\17A0016D\CAD\AIRPORT\TSHEET1E-605.DWG



EAST AIRCRAFT
PARKING RAMP
EXPANSION &
REHABILITATE PARTIAL
PARALLEL TAXIWAY TO
RUNWAY 9/27

IDA No: PRG-4558


Contract No. ED019

NO.	DATE	DESCRIPTION		
		LAY	DWN	REV

ISSUE: JANUARY 11, 2019
PROJECT NO: 17A0016D
CAD FILE: E-606.DWG
LAYOUT BY: KNL 12/10/2018
DRAWN BY: CWS 12/10/2018
REVIEWED BY: BSS 01/11/2019

SHEET TITLE

HIGH VOLTAGE
WIRING SCHEMATIC

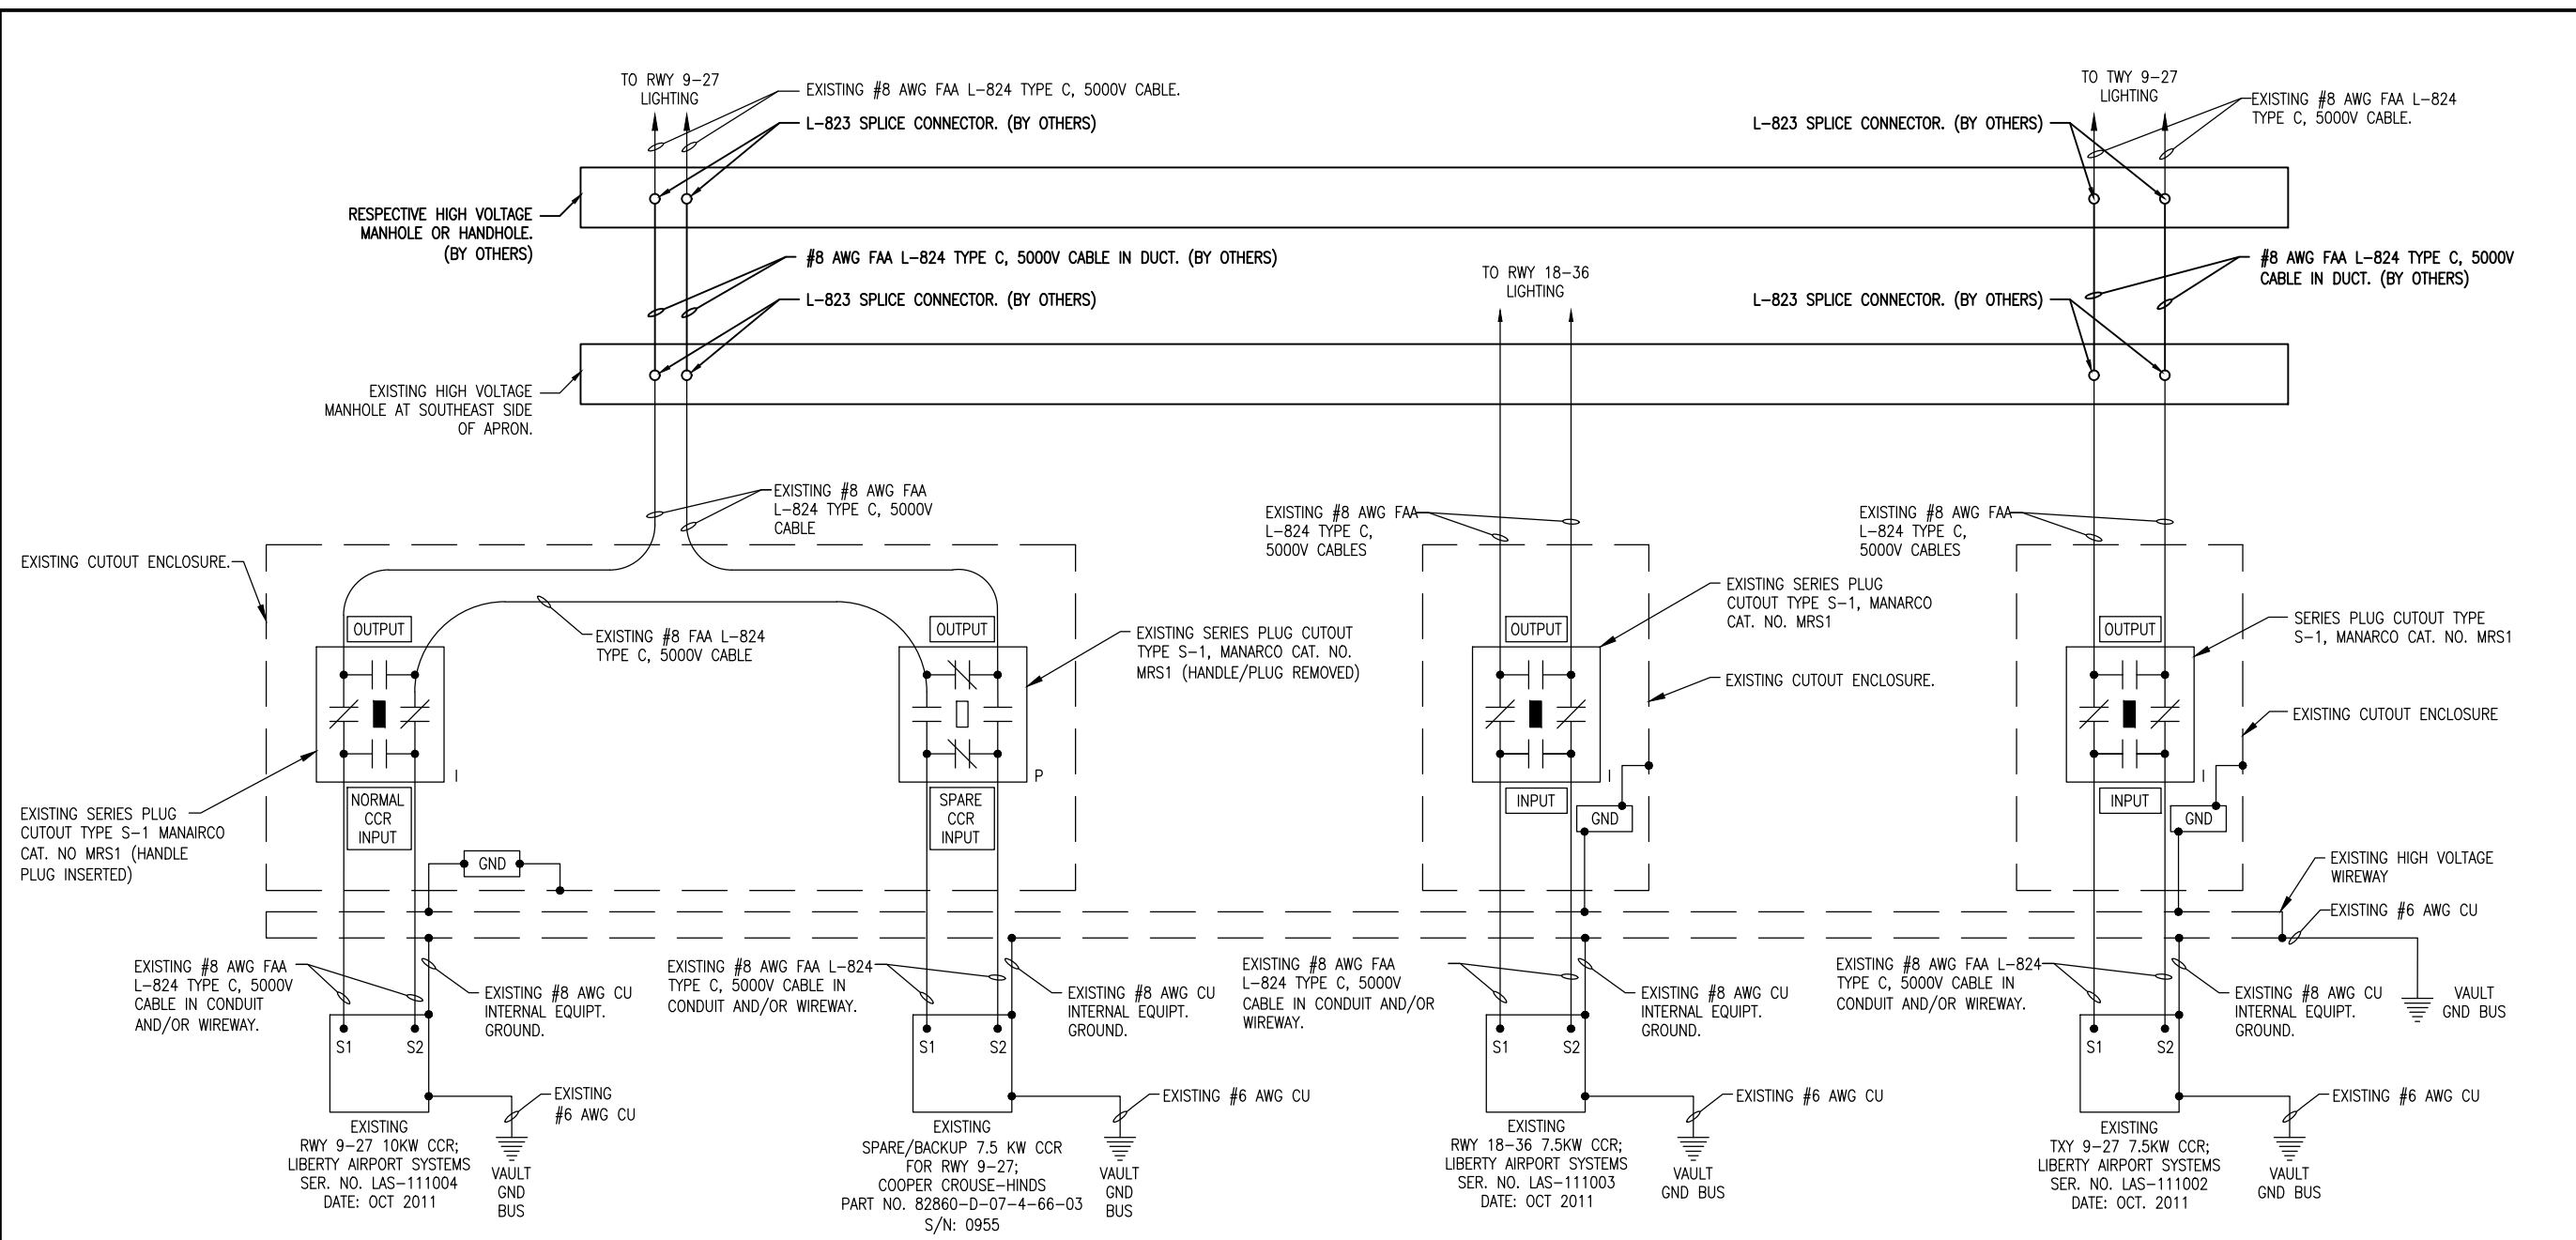

HIGH VOLTAGE WIRING SCHEMATIC

NOTES:


- ALL WORK, POWER OUTAGES, AND/OR SHUT DOWN OF EXISTING SYSTEMS SHALL BE COORDINATED WITH THE AIRPORT MANAGER/DIRECTOR AND RESIDENT ENGINEER/TECHNICIAN. ONCE SHUT DOWN, THE CIRCUITS SHALL BE LABELED AS SUCH TO PREVENT ACCIDENTAL ENERGIZING OF THE RESPECTIVE CIRCUITS. ALL PERSONNEL SHALL FOLLOW U.S. DEPARTMENT OF LABOR OCCUPATIONAL SAFETY & HEALTH ADMINISTRATION (OSHA) 29 CFR PART 1910 OCCUPATIONAL SAFETY & HEALTH STANDARDS FOR ELECTRICAL SAFETY AND LOCKOUT/TAGOUT PROCEDURES INCLUDING, BUT NOT LIMITED TO, 29 CFR SECTION 1910.147 THE CONTROL OF HAZARDOUS ENERGY (LOCKOUT/TAGOUT).
- CONTRACTOR SHALL EXAMINE THE SITE TO CONFIRM AND FIELD VERIFY EXISTING SITE CONDITIONS. CONTRACTOR SHALL FIELD VERIFY RESPECTIVE CIRCUITS AND POWER SOURCES PRIOR TO REMOVING, DISCONNECTING, WORKING ON, RELOCATING, RECONNECTING, AND/OR INSTALLING THE RESPECTIVE AIRFIELD LIGHTING, TAXI SIGN, NAVAID, OR OTHER DEVICES. CONTRACTOR SHALL REPORT ANY VARIATIONS, DEFICIENCIES, AND/OR APPARENT SAFETY CONCERNS TO THE RESIDENT ENGINEER/TECHNICIAN.
- THE RESPECTIVE PERSONNEL PERFORMING AIRFIELD LIGHTING WORK, VAULT WORK, AND/OR TESTS SHALL BE FAMILIAR WITH, AND QUALIFIED TO WORK ON, 5000 VOLT AIRFIELD LIGHTING SERIES CIRCUITS, CONSTANT CURRENT REGULATORS, AND ASSOCIATED AIRPORT ELECTRICAL VAULT EQUIPMENT.
- CONTRACTOR SHALL EXERCISE CAUTION, PRACTICE SAFETY, AND DISCONNECT THE SERIES CIRCUITS FROM THE RESPECTIVE CONSTANT CURRENT REGULATORS, AS APPLICABLE WHEN PERFORMING WORK ON THE AIRFIELD LIGHTING OR WORK THAT MIGHT AFFECT THE AIRFIELD LIGHTING. CONTRACTOR SHALL MAKE NECESSARY ARRANGEMENTS TO DISCONNECT POWER AND LOCKOUT CIRCUITS FOR PROTECTION OF PERSONNEL.

- MEGGER TEST (WITH AN INSULATION RESISTANCE TESTER) AND RECORD EXISTING SERIES CIRCUITS PRIOR TO CABLE WORK OR ANY OTHER WORK THAT MIGHT POSSIBLY AFFECT AIRFIELD LIGHTING, AND AGAIN AFTER AIRFIELD LIGHTING MODIFICATIONS, ADDITIONS, AND/OR UPGRADES HAVE BEEN COMPLETED. ALSO TEST AND RECORD SERIES CIRCUIT LOOP RESISTANCE (WITH AN OHMMETER). THESE ARE REQUIRED TEST IN ACCORDANCE WITH IDOT DIVISION OF AERONAUTICS STANDARD SPECIFICATIONS FOR CONSTRUCTION OF AIRPORTS. PROVIDE TEST RESULTS TO THE PROJECT ENGINEER WITHIN 5 BUSINESS DAYS OF CONDUCTING TESTS
- RUNWAY 9-27 CCR, BACKUP CCR FOR RUNWAY 9-27, RUNWAY 18-36 CCR, TAXIWAY CCR, AND THE ASSOCIATED CUTOUTS ARE EXISTING.
- ALL CCR'S SHALL BE TESTED FOR PROPER OPERATION BEFORE REMOVAL WORK, MODIFICATIONS, AND/OR ADDITIONS AND AFTER THE NEW CABLES AND LIGHTING SYSTEM MODIFICATIONS AND ADDITIONS HAVE BEEN COMPLETED. CONTRACTOR SHALL TEST AND RECORD THE INPUT CURRENT AND OUTPUT CURRENT FOR EACH CONSTANT CURRENT REGULATOR IN THE AUTOMATIC AND MANUAL MODES OF OPERATIONS. CONTRACTOR SHALL REPORT CONCERNS AND/OR DEFICIENCIES TO THE RESIDENT ENGINEER/TECHNICIAN. TEST RESULTS SHALL BE PROVIDED TO THE PROJECT ENGINEER AND RESIDENT ENGINEER/TECHNICIAN, WITHIN 5 BUSINESS DAYS OF CONDUCTING TESTS.
- HIGH VOLTAGE CIRCUITS (AIRFIELD LIGHTING 5000 VOLT SERIES CIRCUITS AND/OR OTHER CIRCUITS RATED ABOVE 600 VOLTS) & LOW VOLTAGE CIRCUITS (RATED 600 VOLTS AND BELOW) SHALL NOT BE INSTALLED IN THE SAME RACEWAY, WIREWAY, HANDHOLE, OR MANHOLE.
- SPLICES FOR RUNWAY AND TAXIWAY SERIES CIRCUITS SHALL BE FAA APPROVED TYPE L-823 CONNECTORS AND SHALL BE INSTALLED IN HIGH VOLTAGE HANDHOLES, HIGH VOLTAGE MANHOLES, SPLICE CANS, HIGH VOLTAGE ENCLOSURES, OR AT THE RESPECTIVE AIRFIELD LIGHT OR TAXI GUIDANCE SIGN.

LEGEND

- "I" DENOTES PLUG CUTOUT WITH PLUG INSERTED
- "P" DENOTES PLUG CUTOUT WITH PLUG PULLED
- "CCR" DENOTES CONSTANT CURRENT REGULATOR

JAN 22, 2019 2:11 PM STOLZ01647 I:\17\JOBS\17A0016D\CAD\AIRPORT\ISHHEETE-606.DWG

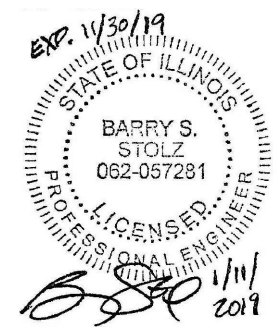

EAST AIRCRAFT
PARKING RAMP
EXPANSION &
REHABILITATE PARTIAL
PARALLEL TAXIWAY TO
RUNWAY 9/27

IDA No: PRG-4558













Contract No. ED019

NO.	DATE	DESCRIPTION		
		LAY	DWN	REV

ISSUE: JANUARY 11, 2019
PROJECT NO: 17A0016D
CAD FILE: C-301-XS.DWG
LAYOUT BY: JRH 12/12/2018
DRAWN BY: JRH 12/12/2018
REVIEWED BY: BSS 01/11/2019

SHEET TITLE


CROSS SECTIONS
STA. 400+48 TO
STA. 405+50 - LINE B

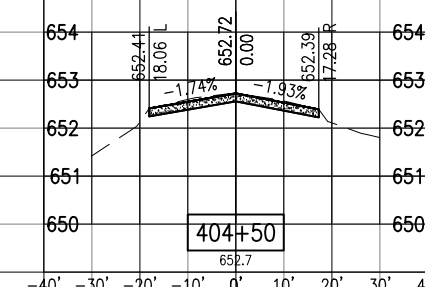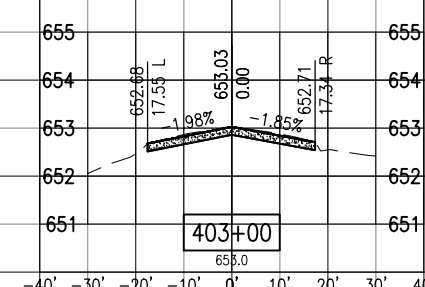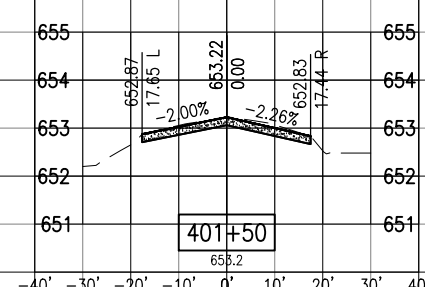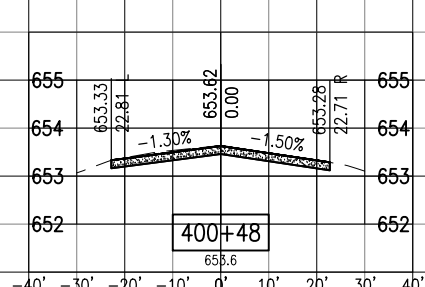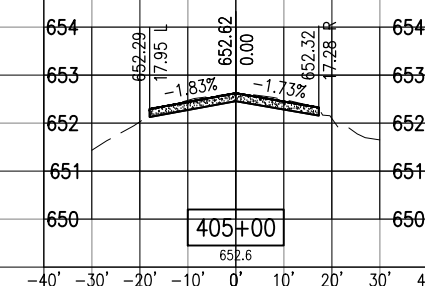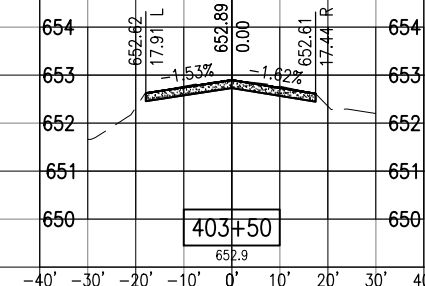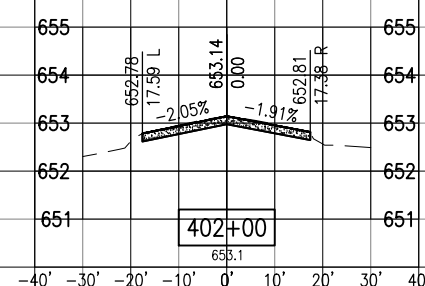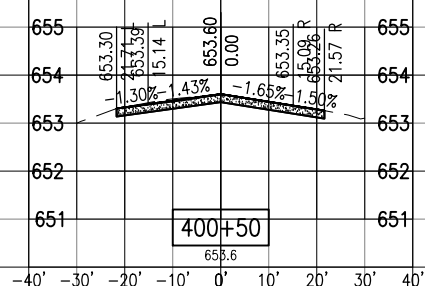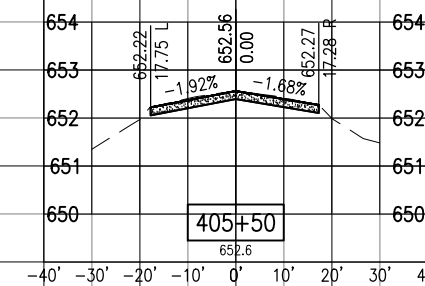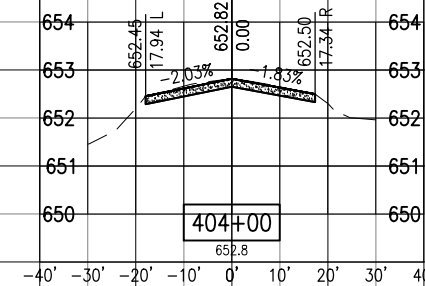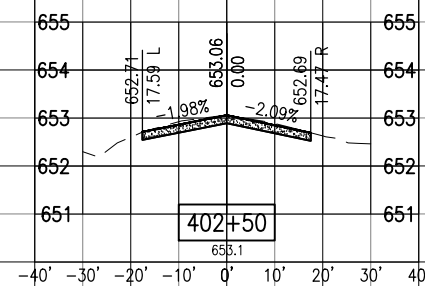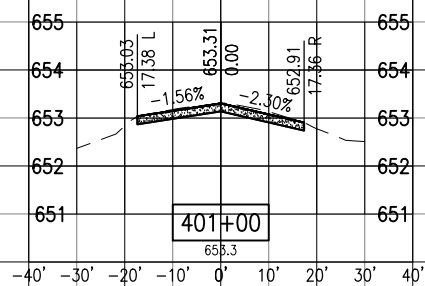

JAN 22, 2019 2:12 PM STOLZ01647
I:\7\JOBS\17A0016D\CAD\AIRPORT\TSHEETS\C-301-XS.DWG

Edgar County Airport

Board of Edgar County
15551 Airport Rd.
Paris, IL 61944-8474
Telephone: 217.465.4151

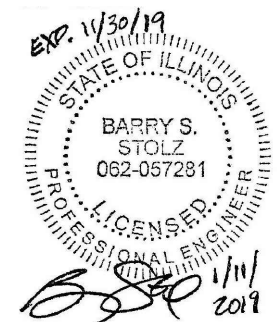

EAST AIRCRAFT
PARKING RAMP
EXPANSION &
REHABILITATE PARTIAL
PARALLEL TAXIWAY TO
RUNWAY 9/27

IDA No: PRG-4558













Contract No. ED019

NO.	DATE	DESCRIPTION		
		LAY	DWN	REV

ISSUE: JANUARY 11, 2019
PROJECT NO: 17A0016D
CAD FILE: C-301-XS.DWG
LAYOUT BY: JRH 12/12/2018
DRAWN BY: JRH 12/12/2018
REVIEWED BY: BSS 01/11/2019

SHEET TITLE

CROSS SECTIONS
STA. 406+00 TO
STA. 412+50 - LINE B

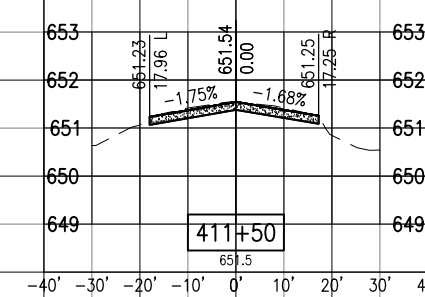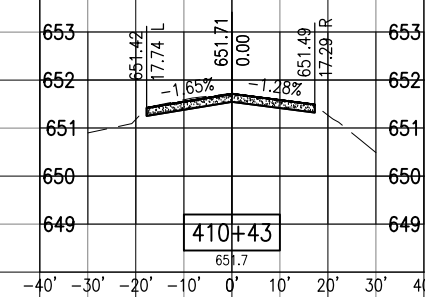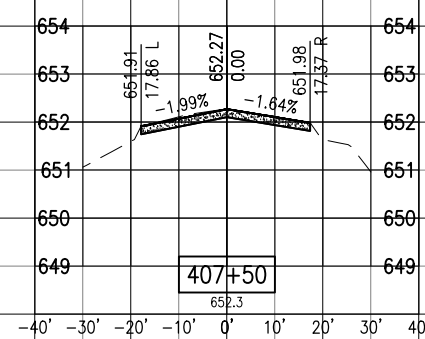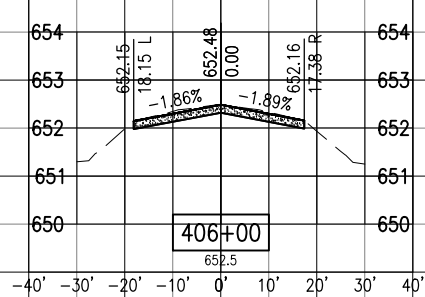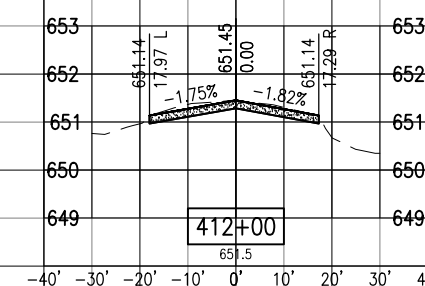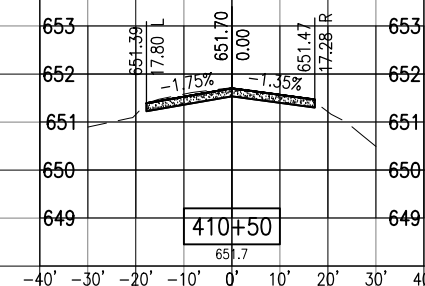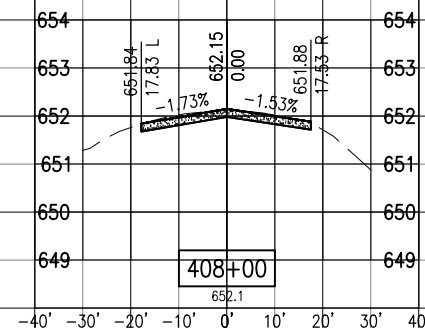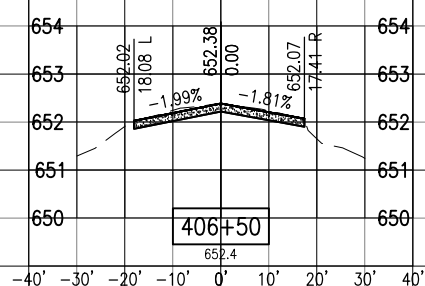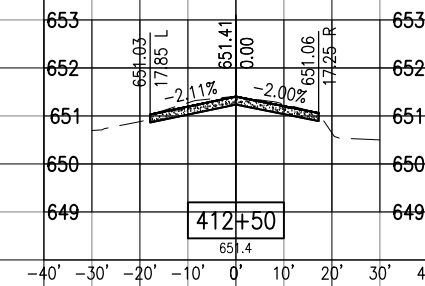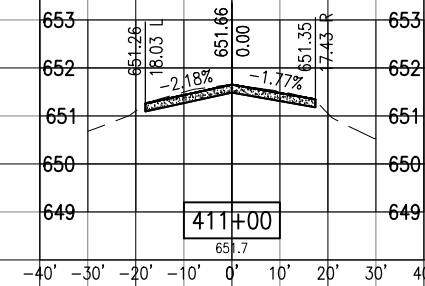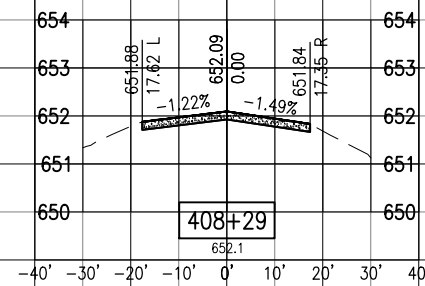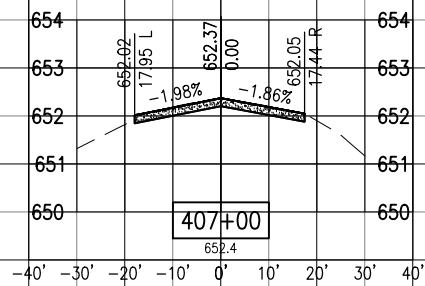



EAST AIRCRAFT
PARKING RAMP
EXPANSION &
REHABILITATE PARTIAL
PARALLEL TAXIWAY TO
RUNWAY 9/27

IDA No: PRG-4558








Contract No. ED019

NO.	DATE	DESCRIPTION		
		LAY	DWN	REV


ISSUE: JANUARY 11, 2019
PROJECT NO: 17A0016D
CAD FILE: C-301-XS.DWG
LAYOUT BY: JRH 12/12/2018
DRAWN BY: JRH 12/12/2018
REVIEWED BY: BSS 01/11/2019

SHEET TITLE

CROSS SECTIONS
STA. 413+00 TO
STA. 415+50 - LINE B

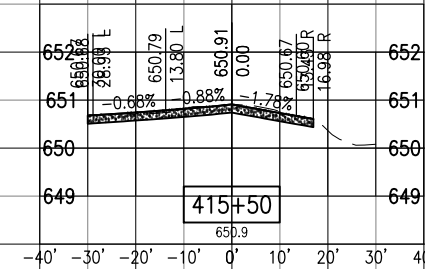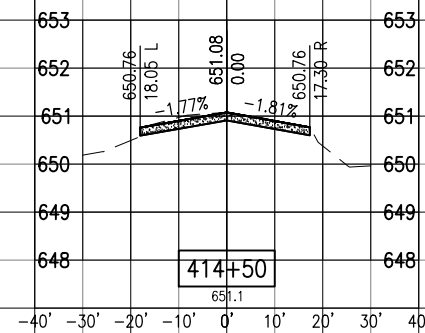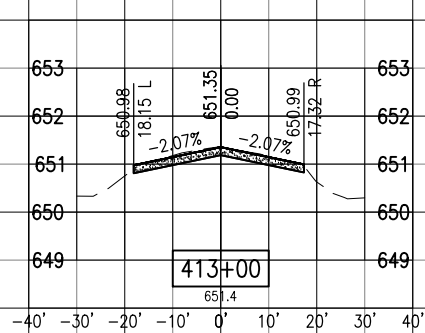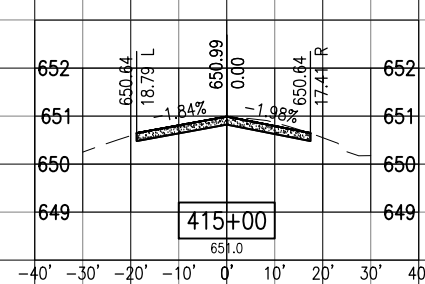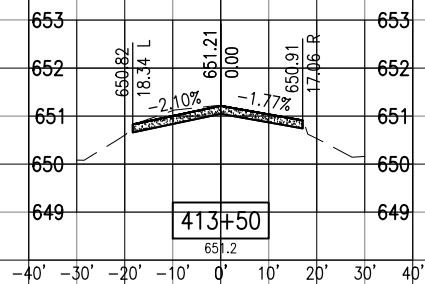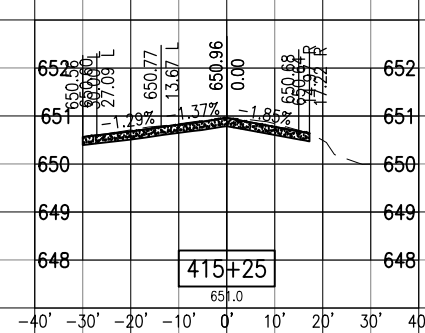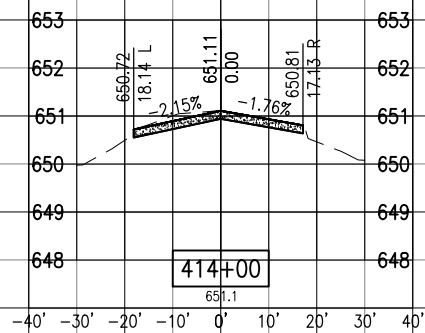

JAN 22, 2019 2:12 PM STOLZ01647
I:\7\JOBS\17A0016D\CAD\AIRPORT\TSHEETS\C-301-XS.DWG

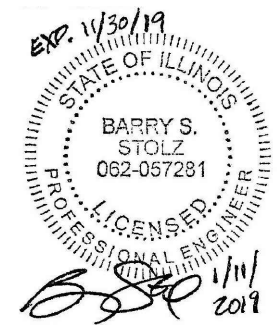

EAST AIRCRAFT
PARKING RAMP
EXPANSION &
REHABILITATE PARTIAL
PARALLEL TAXIWAY TO
RUNWAY 9/27

IDA No: PRG-4558


Contract No. ED019


NO.	DATE	DESCRIPTION		
		LAY	DWN	REV

ISSUE: JANUARY 11, 2019
PROJECT NO: 17A0016D
CAD FILE: C-301-XS.DWG
LAYOUT BY: JRH 12/12/2018
DRAWN BY: JRH 12/12/2018
REVIEWED BY: BSS 01/11/2019

SHEET TITLE

CROSS SECTIONS
STA. 300+00 TO
STA. 303+02 - LINE
B1

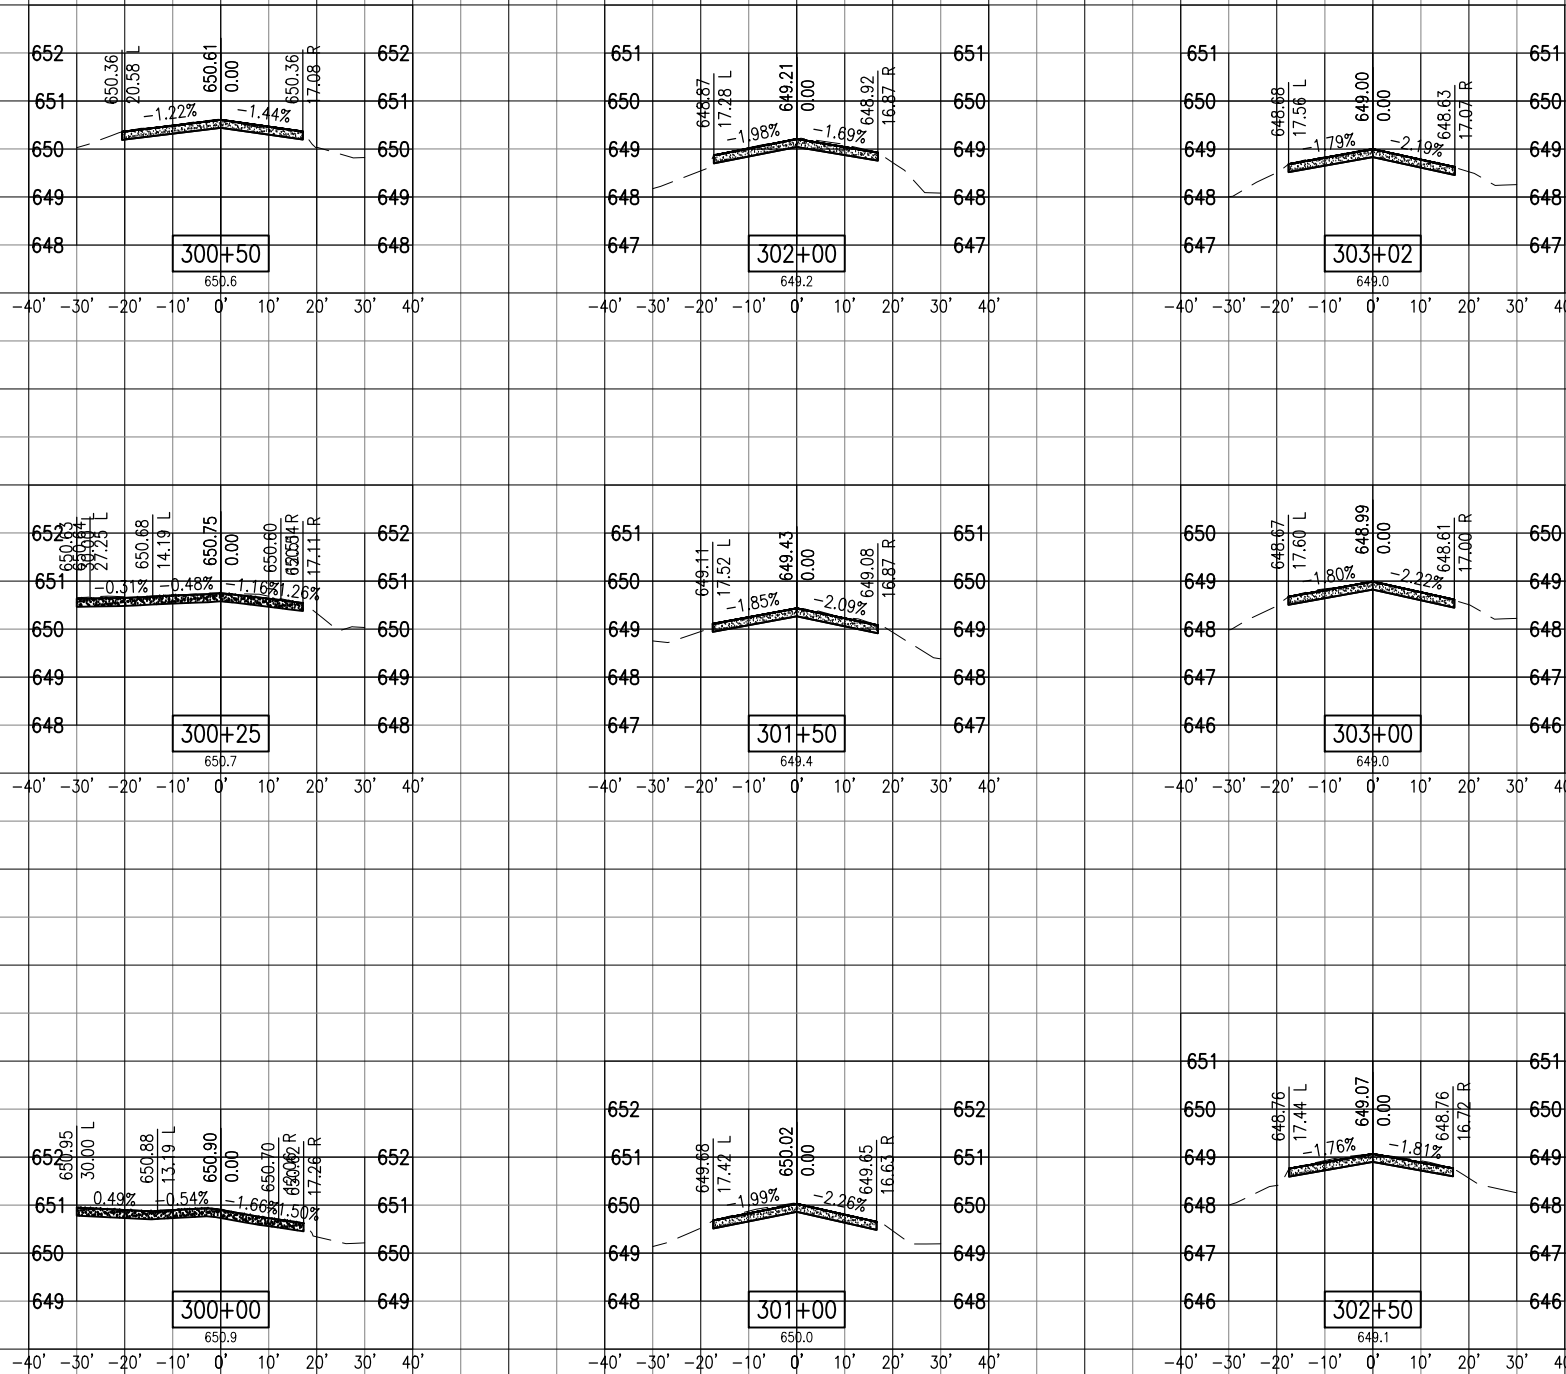

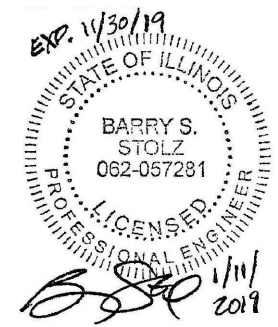

EAST AIRCRAFT
PARKING RAMP
EXPANSION &
REHABILITATE PARTIAL
PARALLEL TAXIWAY TO
RUNWAY 9/27

IDA No: PRG-4558











Contract No. ED019

NO.	DATE	DESCRIPTION		
		LAY	DWN	REV

ISSUE: JANUARY 11, 2019
PROJECT NO: 17A0016D
CAD FILE: C-301-XS.DWG
LAYOUT BY: JRH 01/10/2019
DRAWN BY: JRH 01/10/2019
REVIEWED BY: BSS 01/11/2019

SHEET TITLE

CROSS SECTIONS
STA. 0+00 TO STA.
1+25 - LINE EA

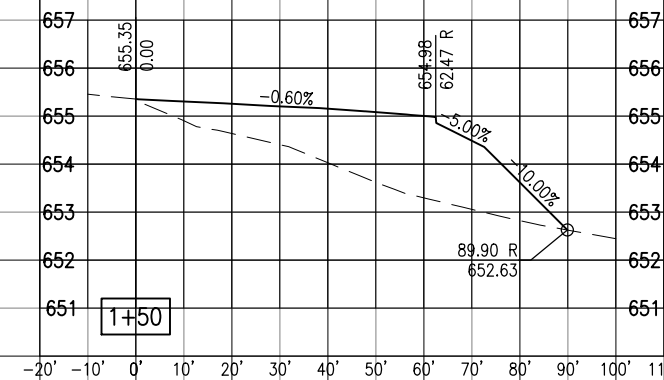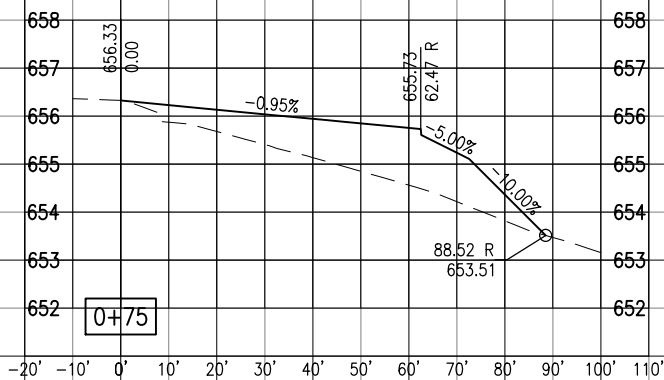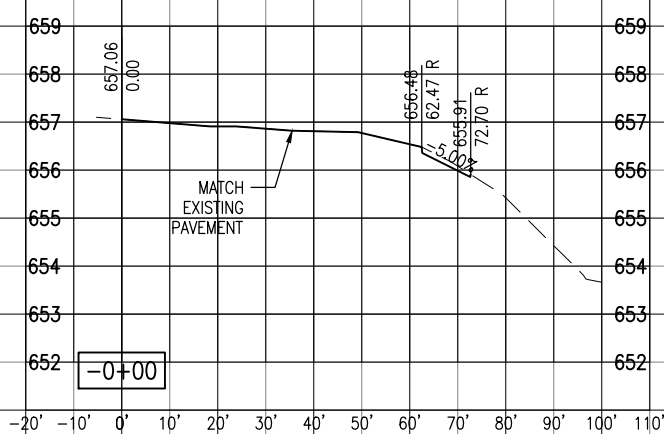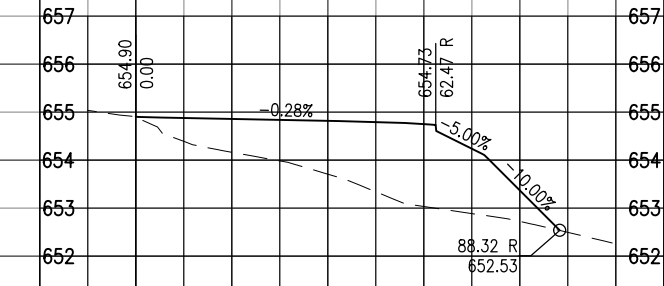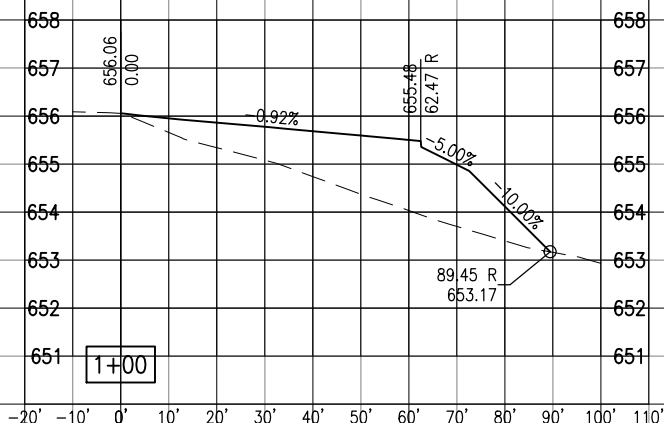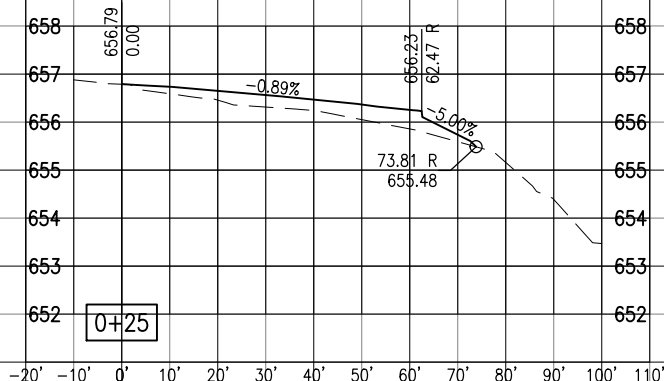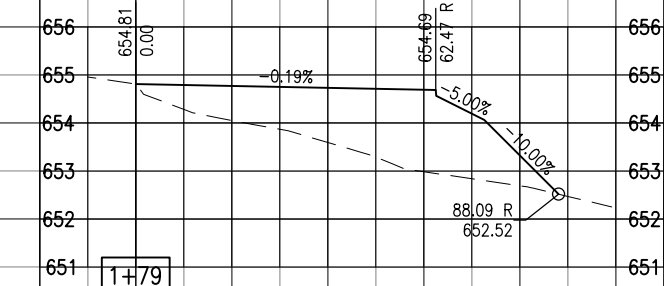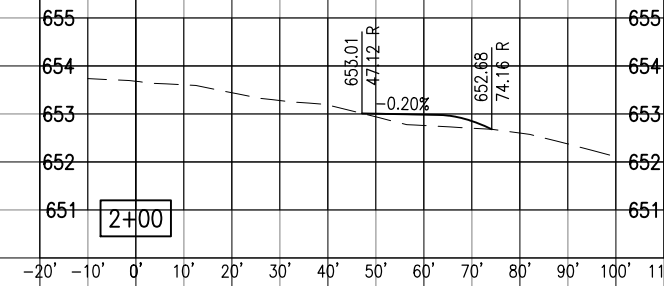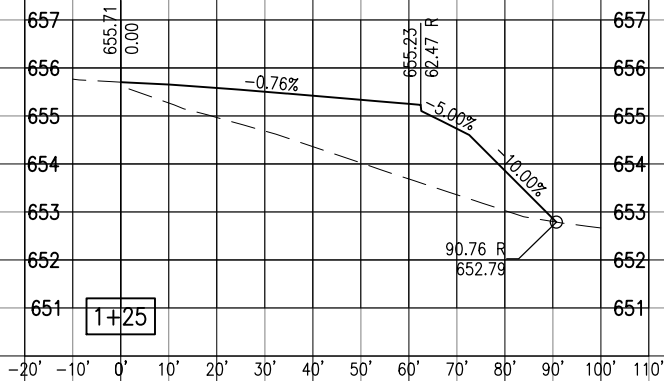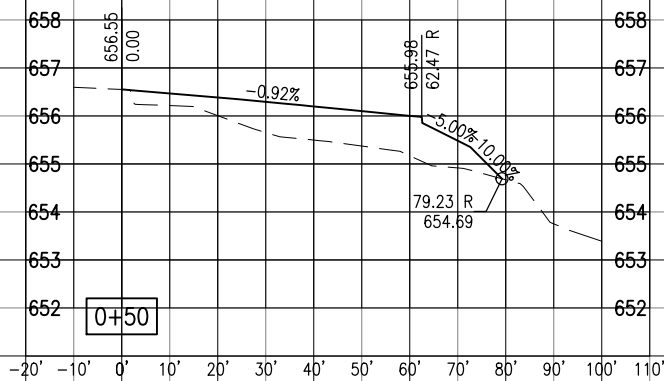

JAN 22, 2019 2:12 PM STOLZ01647
I:\7\JOBS\17A0016D\CAD\AIRPORT\17SHEETC-301-XS.DWG