


F.A.P. RTE.	SECTION	COUNTY	TOTAL SHEETS	SHEET NO.
343	*	COOK	283	129
STA.	TO STA.			
FED. ROAD DIST. NO. 1	ILLINOIS FED. AID PROJECT			
* 700-Y-R & 70HB-R-1			62897	


KEY PLAN

NOTES:

1. CONNECT EXISTING CIRCUITS TO NEW CONDUCTORS AT BASE OF POLE THROUGH EXISTING RACEWAY.
2. FOUNDATION REQUIRES THREE (3) CONDUITS FOR UNIT DUCTS.
3. ALL PROPOSED UNIT DUCTS ARE 30MM DIA. POLYETHYLENE WITH (3) 1/2 #4 & (1) 1/2 #6 GND (EPR-TYPE RHW).
4. ALL PROPOSED PUSHED CONDUITS ARE 75MM DIA. RGS.

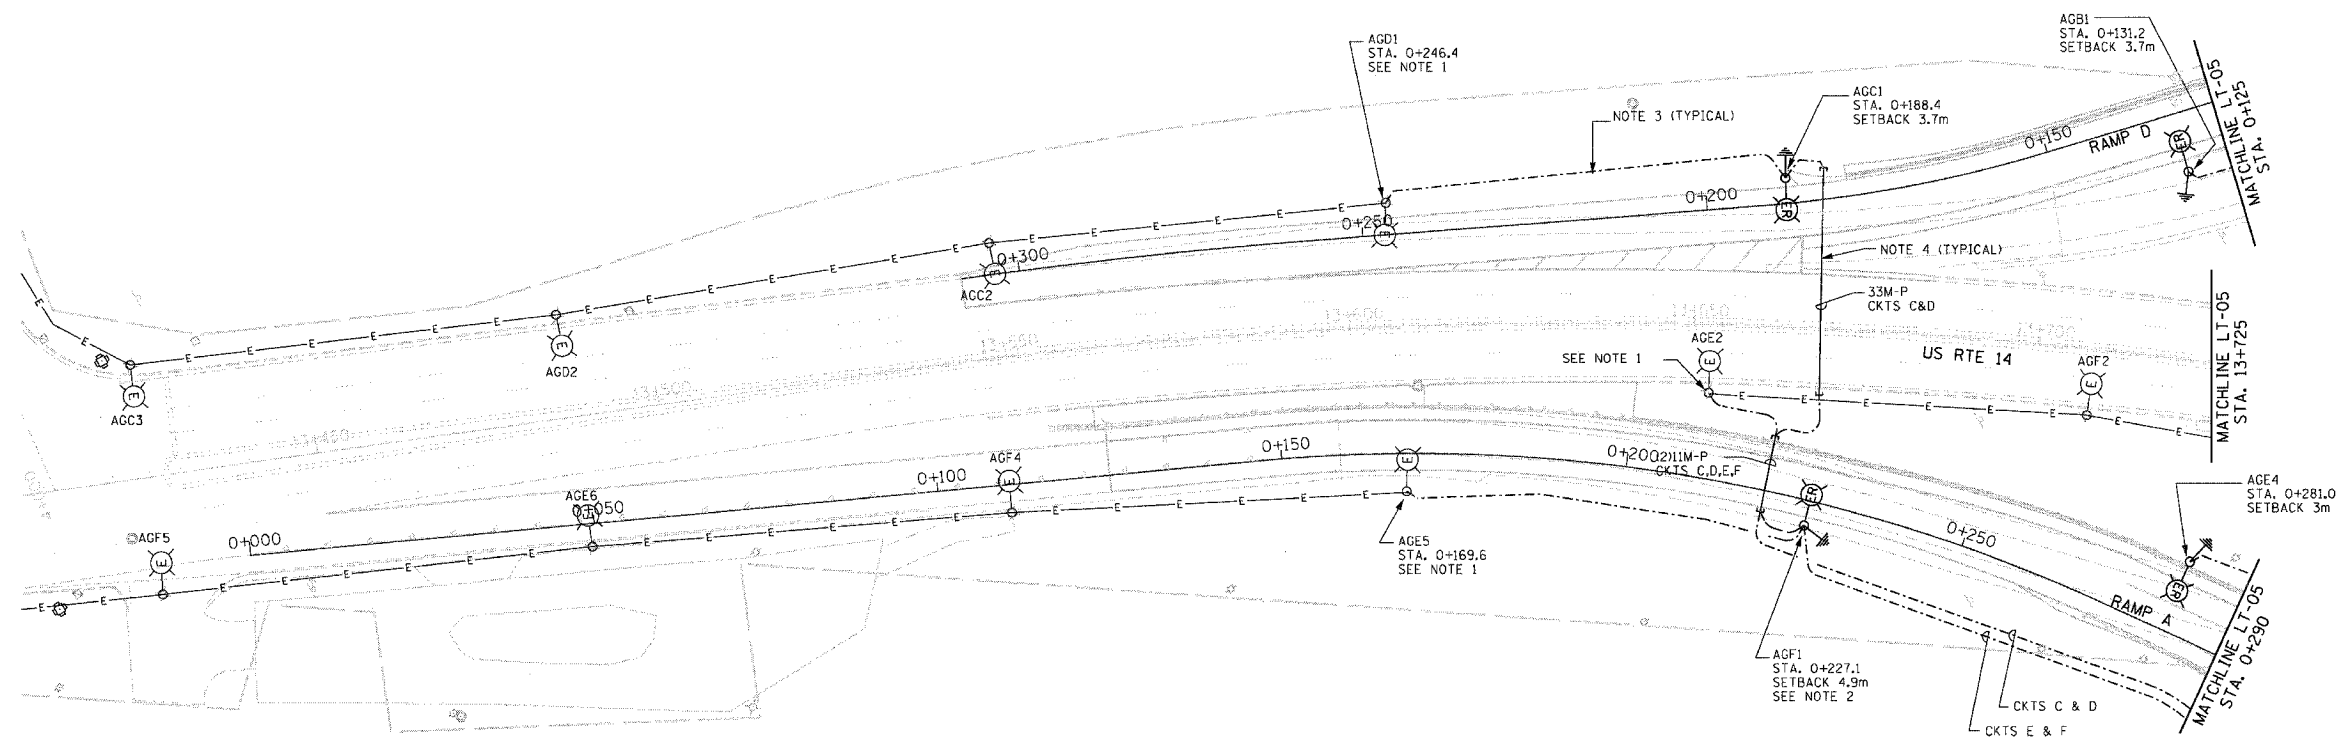

1 PROPOSED ROADWAY LIGHTING PLAN
 SCALE: 1 : 500
 5 0 5 10 15 20 25
 SCALE IN METERS

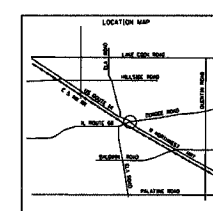

REVISIONS	
NAME	DATE

LT-04 OF 19

ILLINOIS DEPARTMENT OF TRANSPORTATION
 ILLINOIS ROUTE 68 AT U.S. ROUTE 14
 ROADWAY LIGHTING PROPOSED PLAN
 US 14 STA. 13+400 TO STA. 13+725

SCALE 1:500
 DATE NOVEMBER 2006

DRAWN BY R.P.J.
 DESIGNED BY I.B.
 CHECKED BY A.D.O.

Rick Johns
 ID01 - District 01
 02-05-ID01-STV-03 - IL 68 over US 14
 P:\02-05-ID01-STV-03 - IL 68 over US 14\Working Files\Shi\E-LT-04 - Proposed Plan.dgn
 11/27/2006 3:35:40 PM 500.0000 M / M.