


F.A.P. RTE.	SECTION	COUNTY	TOTAL SHEETS	SHEET NO.
343	#	COOK	283	137
STA.		TO STA.		
FED. ROAD DIST. NO. 1		ILLINOIS FED. AID PROJECT		
* 70D-Y-R & 70HB-R-1		62897		


KEY PLAN

NOTES:

1. SECURE AERIAL CABLE ATTACHMENT TO POLE WITH A POLE BAND. INSERT CONDUCTORS THROUGH THE 38mm GROMMETED HOLE IN THE TOP PORTION OF THE SHAFT.
2. WITH 4.5 MAST ARM, MOUNT TEMPORARY LUMINAIRE AT 14.5M ABOVE ROADWAY.
3. ALL TEMPORARY AERIAL CABLE SHALL BE (3) 1/C #2 ALUMINUM WITH MESSENGER WIRE.
4. ComEd TO RAISE NEUTRAL TO ALLOW FOR TEMPORARY AERIAL CABLES TO CROSS UNDER THE DISTRIBUTION LINES.
5. CIRCUIT/POLE NUMBERS OUTSIDE OF PRENTHESES ARE PROPOSED. CIRCUIT/POLE NUMBERS IN PRENTHESES ARE EXISTING NUMBERS AND SHALL BE REPLACED IN ACCORDANCE WITH GENERAL NOTE \*34, SHEET LT-02.
6. PROVIDE TEMPORARY IMPACT ATTENUATOR AT TEMPORARY WOOD POLE. COST OF THE TEMPORARY IMPACT ATTENUATOR SHALL BE INCIDENTAL TO THE PAY ITEM FOR THE WOOD POLE.
7. MAINTAIN A MINIMUM OF 4.9M CLEARANCE TO GRADE FOR ALL AERIAL CABLES.

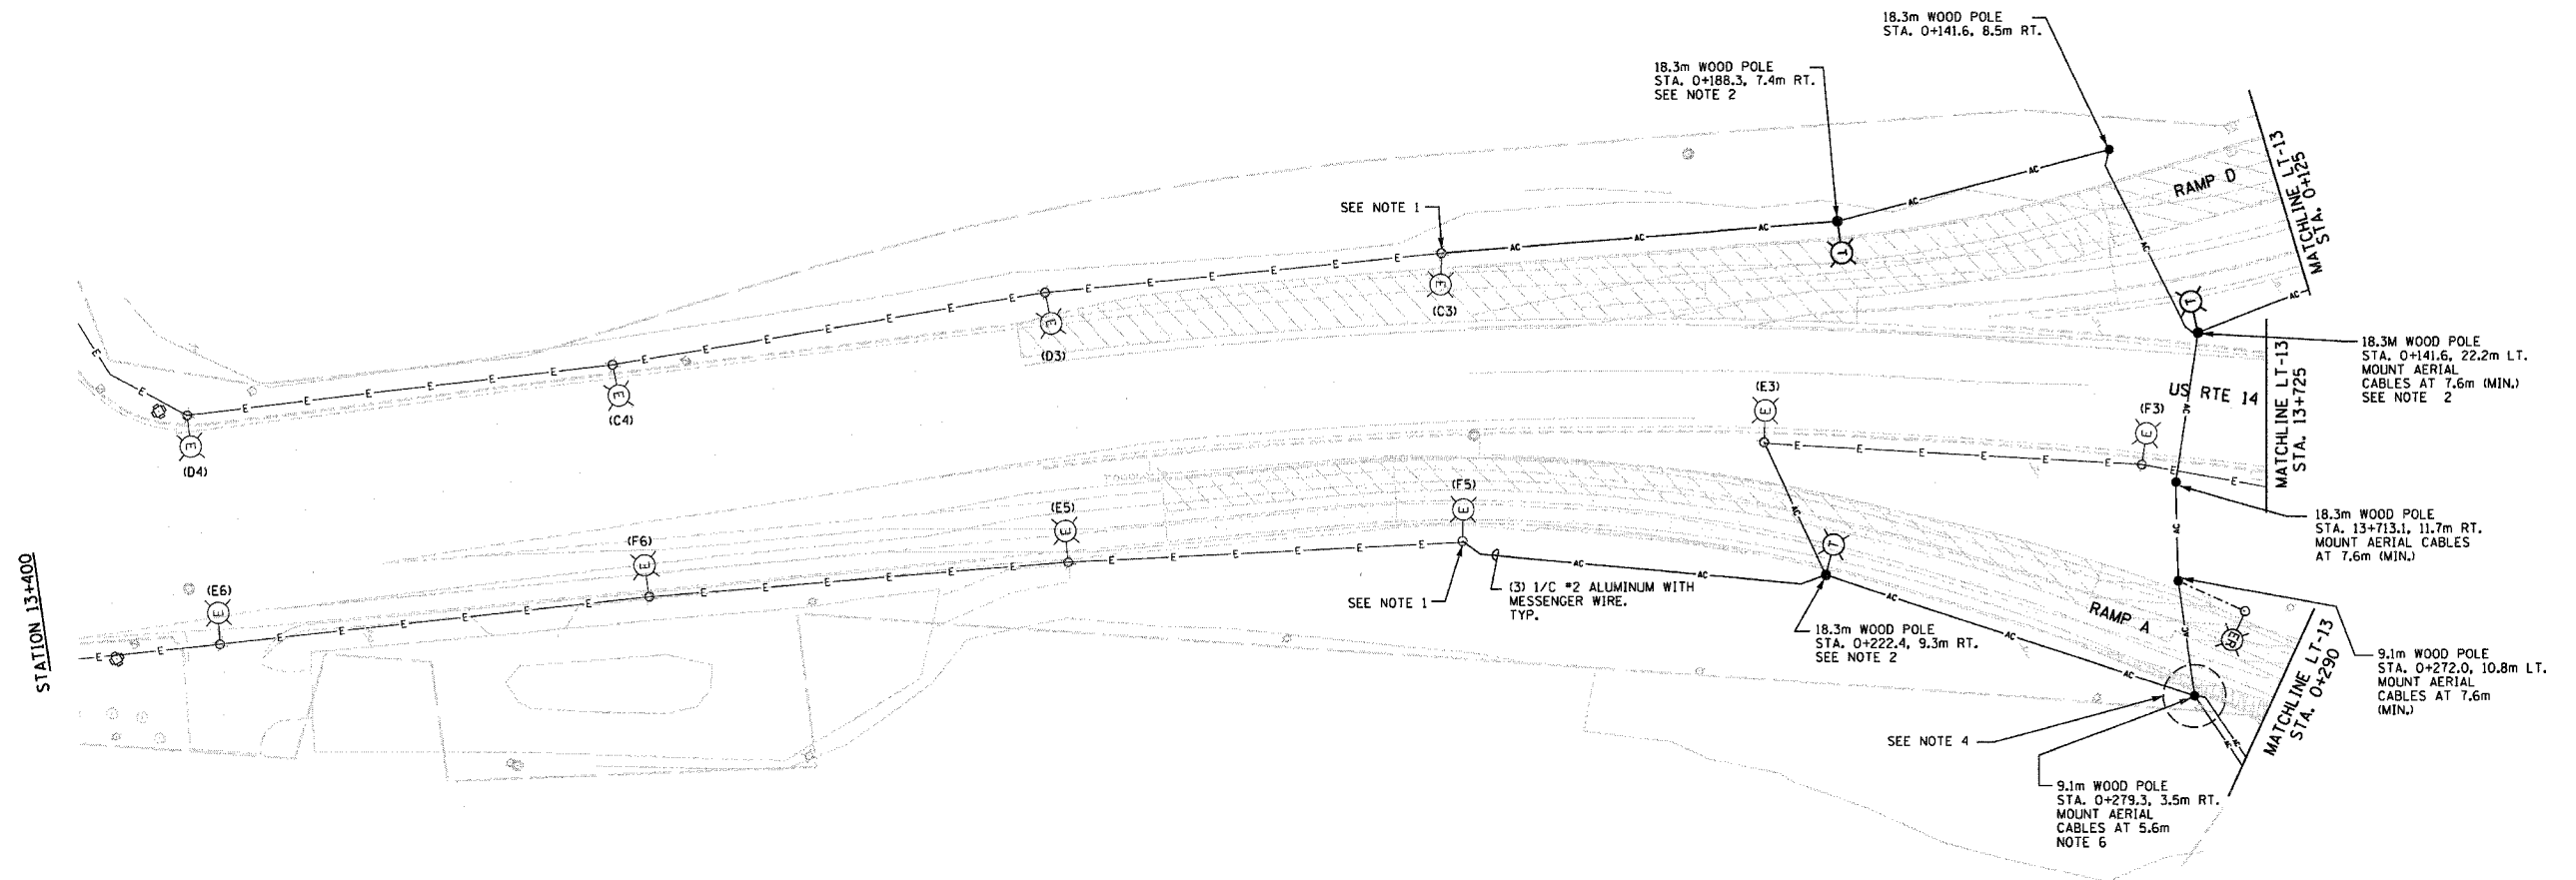

**1 ROADWAY TEMPORARY LIGHTING PLAN**  
 SCALE: 1 : 500  
 5 0 5 10 15 20 25  
 SCALE IN METERS

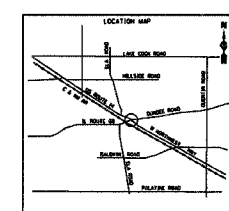

REVISIONS	
NAME	DATE

LT-12 OF 19

ILLINOIS DEPARTMENT OF TRANSPORTATION  
 ILLINOIS ROUTE 68 AT U.S. ROUTE 14  
 ROADWAY TEMPORARY LIGHTING PLAN  
 US 14 STA. 13+400 TO STA. 13+725

SCALE 1:500  
 DATE NOVEMBER 2006

DRAWN BY R.P.J.  
 DESIGNED BY I.B.  
 CHECKED BY A.D.O.

Rick Johns  
 IDOT - District 01  
 02-05-IDOT-STV-03 - IL 68 over US 14  
 PA02-05-IDOT-STV-03 - IL 68 over US 14  
 11/27/2006 3:38:40 PM 500.0000 M / M. Temporary LTG.dgn