


F.A.P. RTE.	SECTION	COUNTY	TOTAL SHEETS	SHEET NO.
343	*	COOK	283	138
STA.	TO STA.			
FED. ROAD DIST. NO. 1		ILLINOIS FED. AID PROJECT		
* 70D-Y-R & 70HB-R-1		62897		


KEY PLAN

NOTES:

1. SECURE AERIAL CABLE ATTACHMENT TO POLE WITH A POLE BAND. INSERT CONDUCTORS THROUGH THE 38mm GROMMETED HOLE IN THE TOP PORTION OF THE SHAFT.
2. WITH 4.5M MAST ARM. MOUNT TEMPORARY LUMINAIRE 14.5M ABOVE ROADWAY.
3. ALL TEMPORARY AERIAL CABLE SHALL BE (3) 1/C #2 ALUMINUM WITH MESSENGER WIRE.
4. CONNECT TEMPORARY CIRCUITS TO PROPOSED LIGHTING CONTROLLER AG AFTER CONTROLLER IS INSTALLED DURING CONSTRUCTION STAGE 2.
5. CIRCUIT/POLE NUMBERS OUTSIDE OF PRENTHESES ARE PROPOSED. CIRCUIT/POLE NUMBERS IN PRENTHESES ARE EXISTING NUMBERS AND SHALL BE REPLACED IN ACCORDANCE WITH GENERAL NOTE #34, SHEET LT-02.
6. PROVIDE CRASH PROTECTION AT TEMPORARY WOOD POLE. COST OF CRASH PROTECTION SHALL BE INCIDENTAL TO THE PAY ITEM FOR THE WOOD POLE.
7. MAINTAIN EXISTING LIGHTS IN SERVICE ON NORTH SIDE OF IL-68 WHILE CONSTRUCTION ON SOUTH SIDE IS IN PROGRESS.
8. PROPOSED LIGHT UNITS ON SOUTH SIDE OF IL-68 SHALL BE PLACED IN SERVICE WHEN NORTH SIDE OF IL-68 IS UNDER CONSTRUCTION.
9. MAINTAIN UNDERPASS LIGHTS ON NORTH SIDE OF US-14 BRIDGE IN SERVICE WHILE SOUTH SIDE OF BRIDGE IS UNDER CONSTRUCTION.
10. PROPOSED UNDERPASS LIGHTS ON SOUTH SIDE OF US-14 BRIDGE SHALL BE PLACED IN SERVICE WHEN NORTH SIDE IS UNDER CONSTRUCTION.
11. EXISTING POLE TO REMAIN DURING STAGE 1.
12. MAINTAIN A MINIMUM OF 4.9M CLEARANCE TO GRADE FOR ALL AERIAL CABLES.

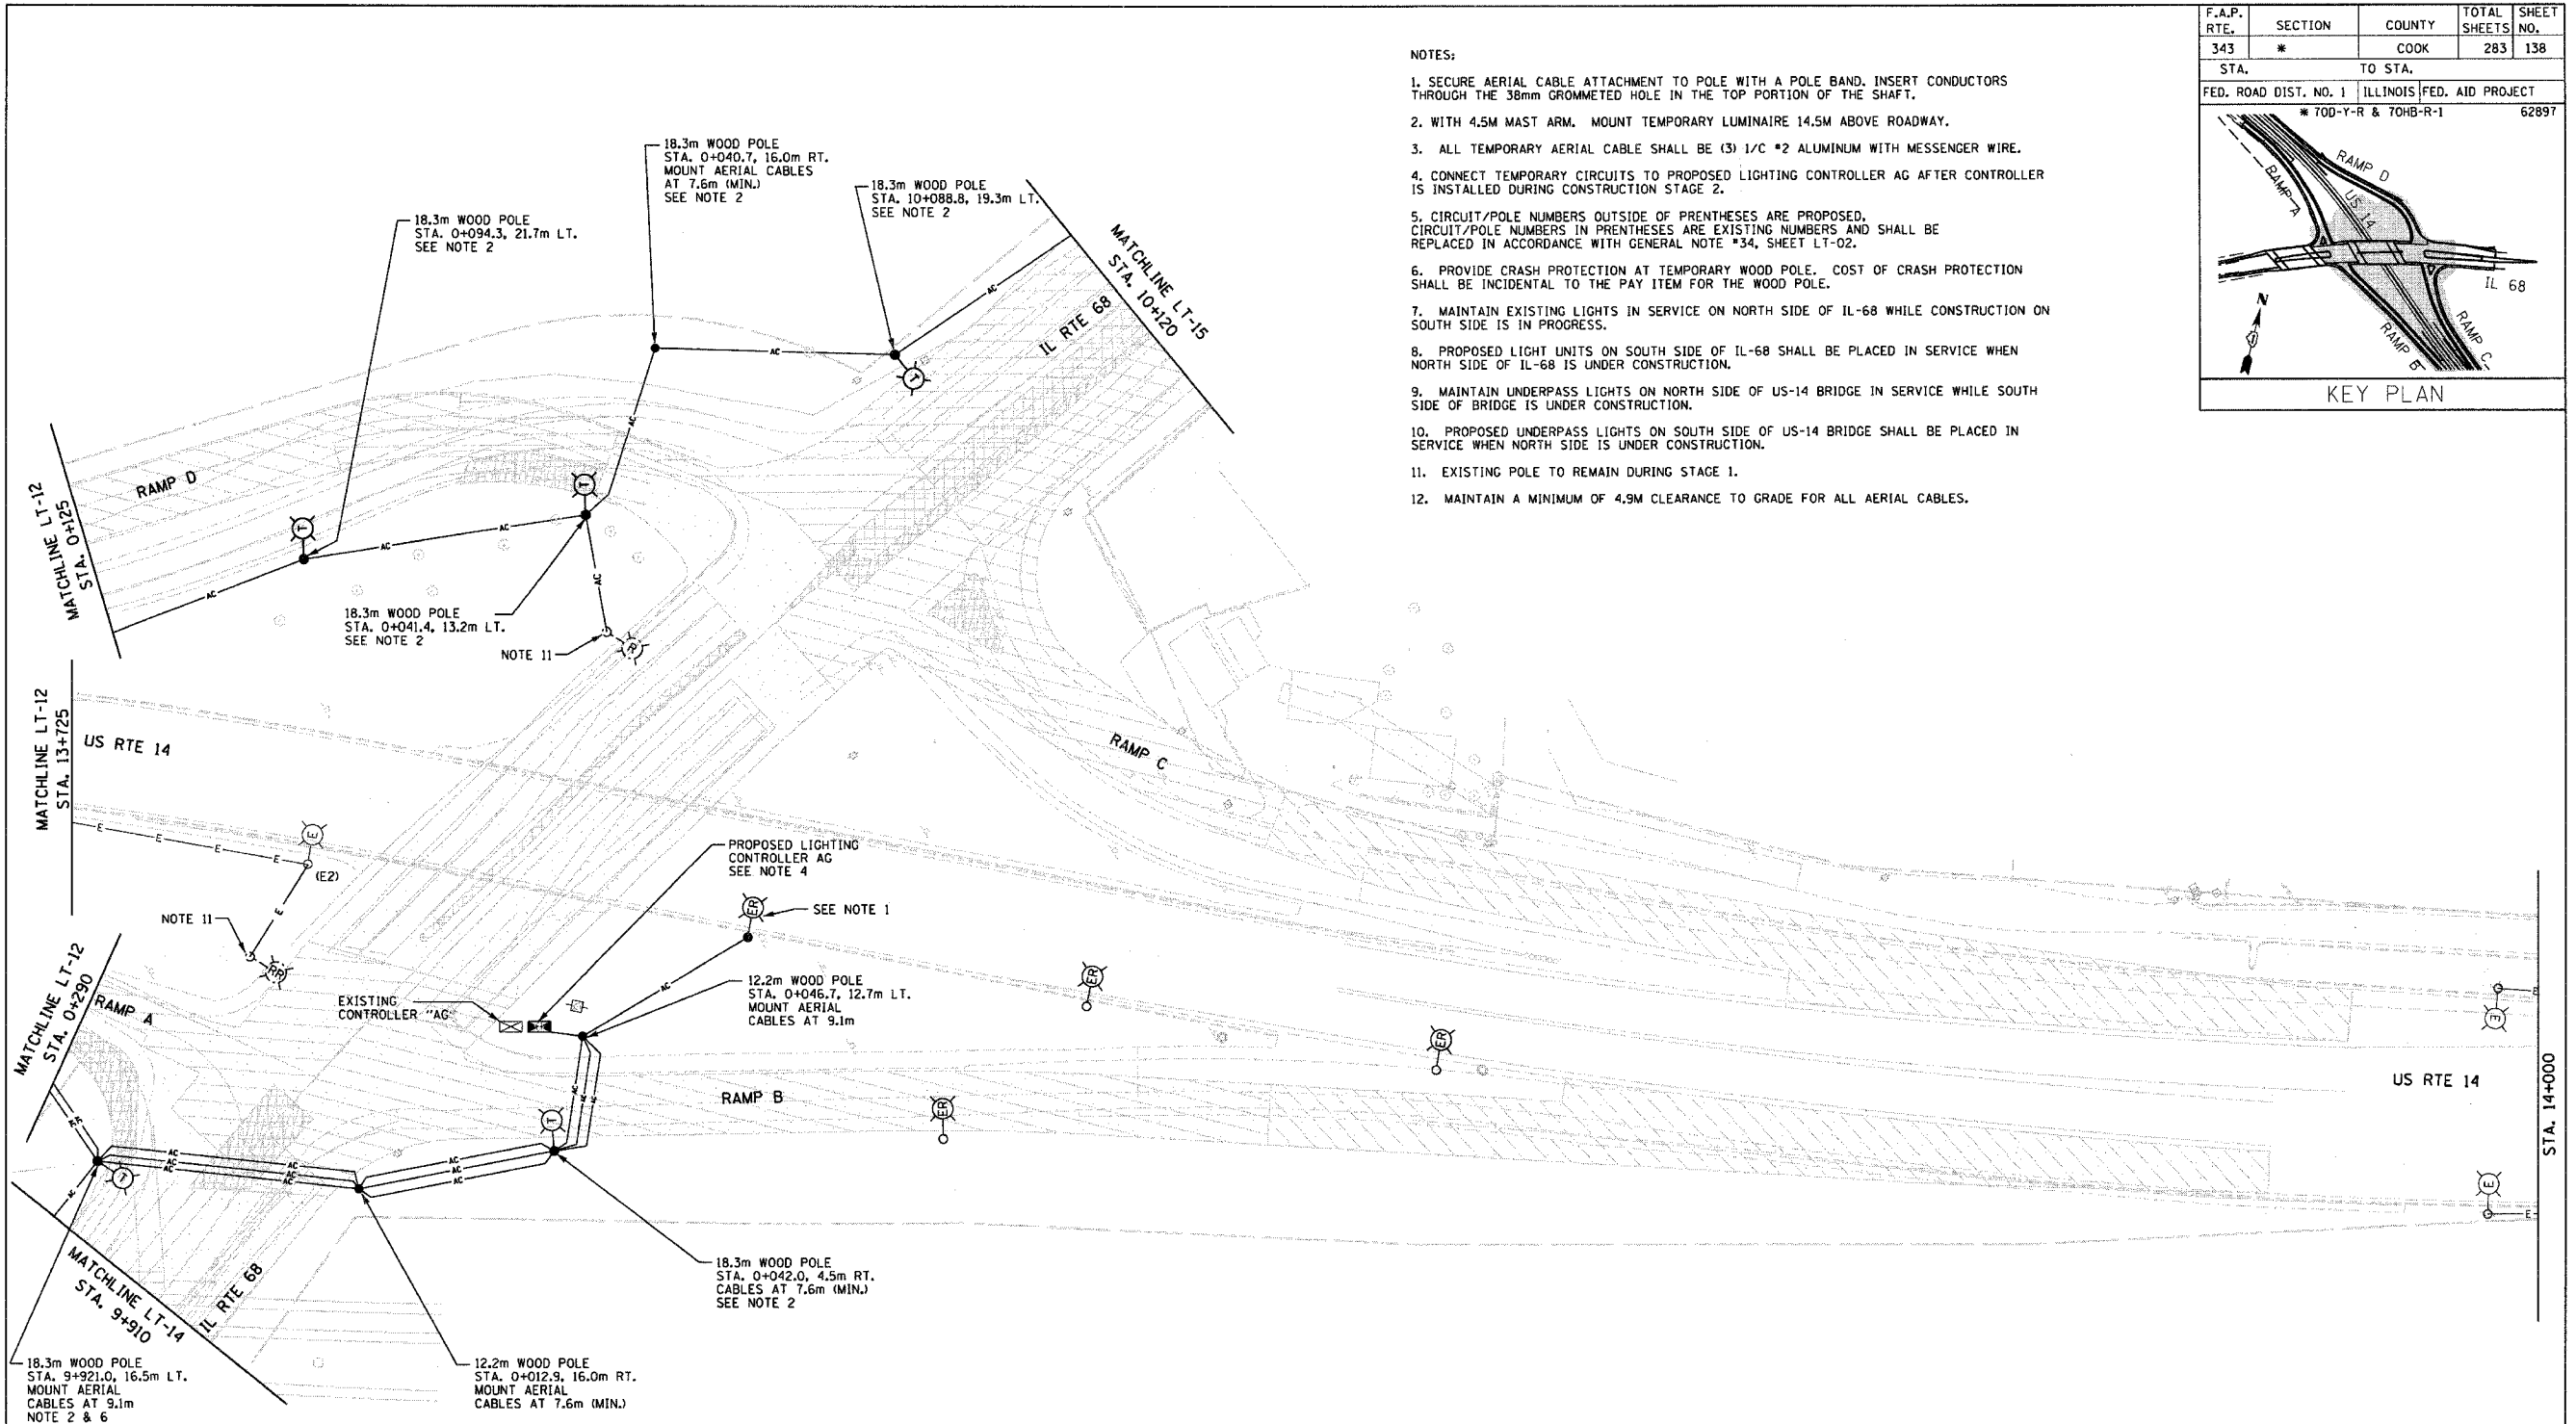

**1 ROADWAY TEMPORARY LIGHTING PLAN**  
 SCALE: 1 : 500  
 5 0 5 10 15 20 25  
 SCALE IN METERS

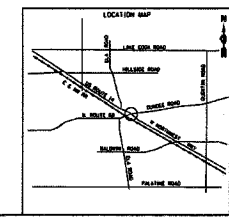

REVISIONS	
NAME	DATE

ILLINOIS DEPARTMENT OF TRANSPORTATION  
 ILLINOIS ROUTE 68 AT U.S. ROUTE 14  
 ROADWAY TEMPORARY LIGHTING PLAN  
 IL 68 STA. 9+910 TO STA. 10+120  
 US 14 STA. 13+725 TO STA. 14+100  
 SCALE 1:500  
 DATE NOVEMBER 2006  
 DRAWN BY R.P.J.  
 DESIGNED BY I.B.  
 CHECKED BY A.D.O.

Rick Johns  
 IDOT - District 01  
 02-05-IDOT-STV-03 - IL 68 over US 14  
 P:02-05-IDOT-STV-03 - IL 68 over US 14  
 11/27/2006 3:57:28 PM  
 500.0000 M / M.