
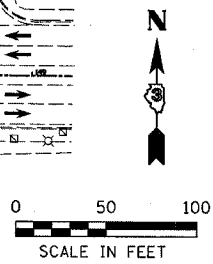


F.A.P. RTE.	SECTION	COUNTY	TOTAL SHEETS	SHEET NO.
567	34X-BR	DEKALB	90	15
STA.		TO STA.		
FED. ROAD DIST. NO.		ILLINOIS FED. AID PROJECT		

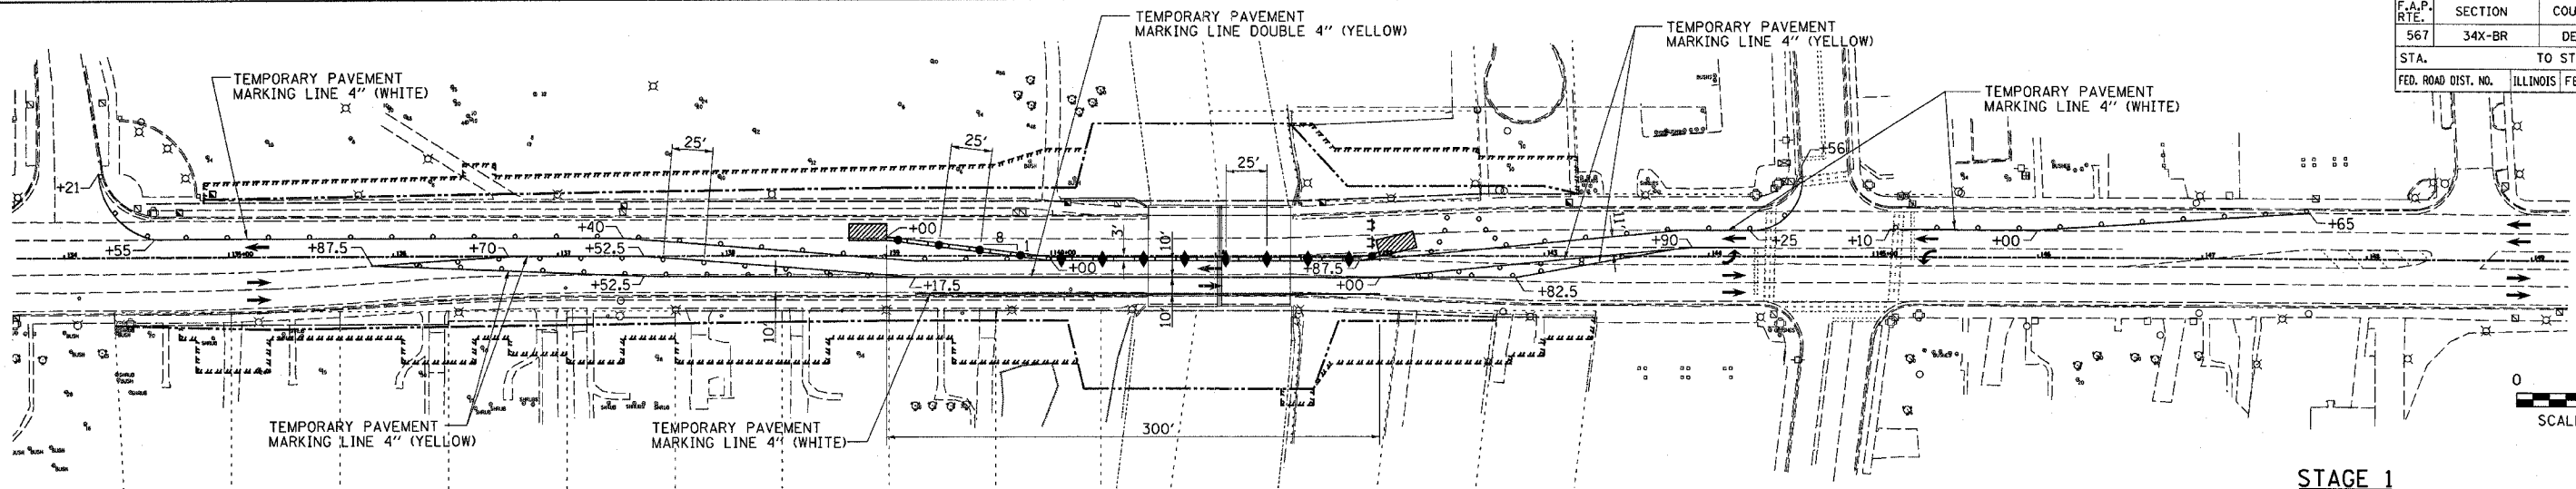


**STAGE 1
SEQUENCE OF OPERATIONS**


1. INSTALL ATTENUATOR BASES, ATTENUATORS AND TEMPORARY CONCRETE BARRIERS AS SHOWN. BEGIN OPERATING UNDER STAGE 1 TRAFFIC CONTROL CONDITIONS ACCORDING TO TRAFFIC CONTROL AND PROTECTION STANDARD 701606. ADD THREE ARROWBOARDS IN ACCORDANCE WITH STANDARD 701606. PLACE SIGNING IN ACCORDANCE WITH STANDARD 701606.
2. REMOVE NORTH HALF OF EXISTING STRUCTURE, EXISTING PAVEMENT, COMBINATION CONCRETE CURB AND GUTTER, INLETS, AND GUARDRAIL.
3. CONSTRUCT NORTH HALF OF PROPOSED STRUCTURE, BACKFILL, COMPACT, PERFORM PAVEMENT WIDENING, CONSTRUCT COMBINATION CONCRETE CURB AND INSTALL AND ADJUST INLETS AND MANHOLES, STORM SEWERS, SIDEWALKS AND DRIVEWAY PAVEMENT.

ALL TRAFFIC CONTROL DEVICES SHOWN ON THIS SHEET SHALL BE INCLUDED IN THE CONTRACT UNIT PRICE FOR TRAFFIC CONTROL PROTECTION STANDARD 701606 UNLESS SPECIFICALLY PAID FOR ELSEWHERE.

TRAFFIC CONTROL

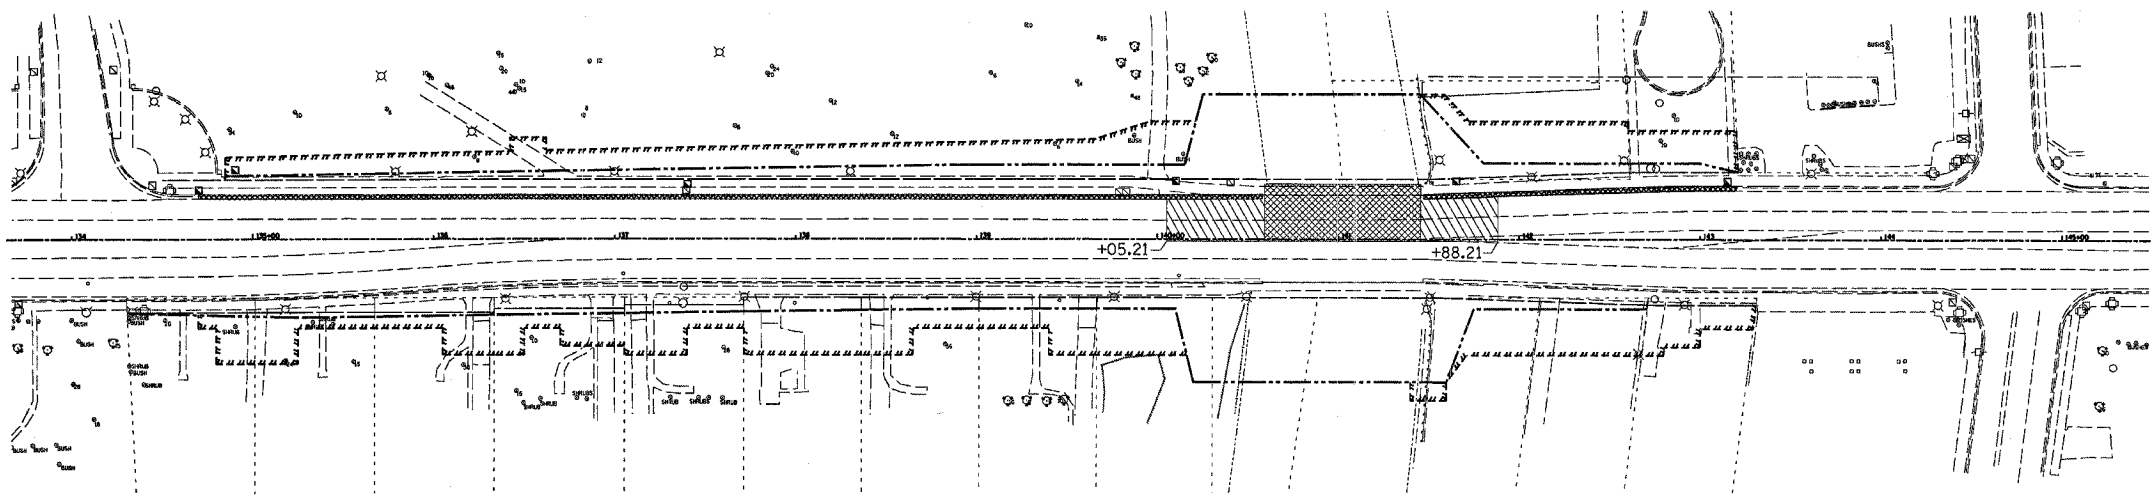

REMOVAL SCHEMATIC

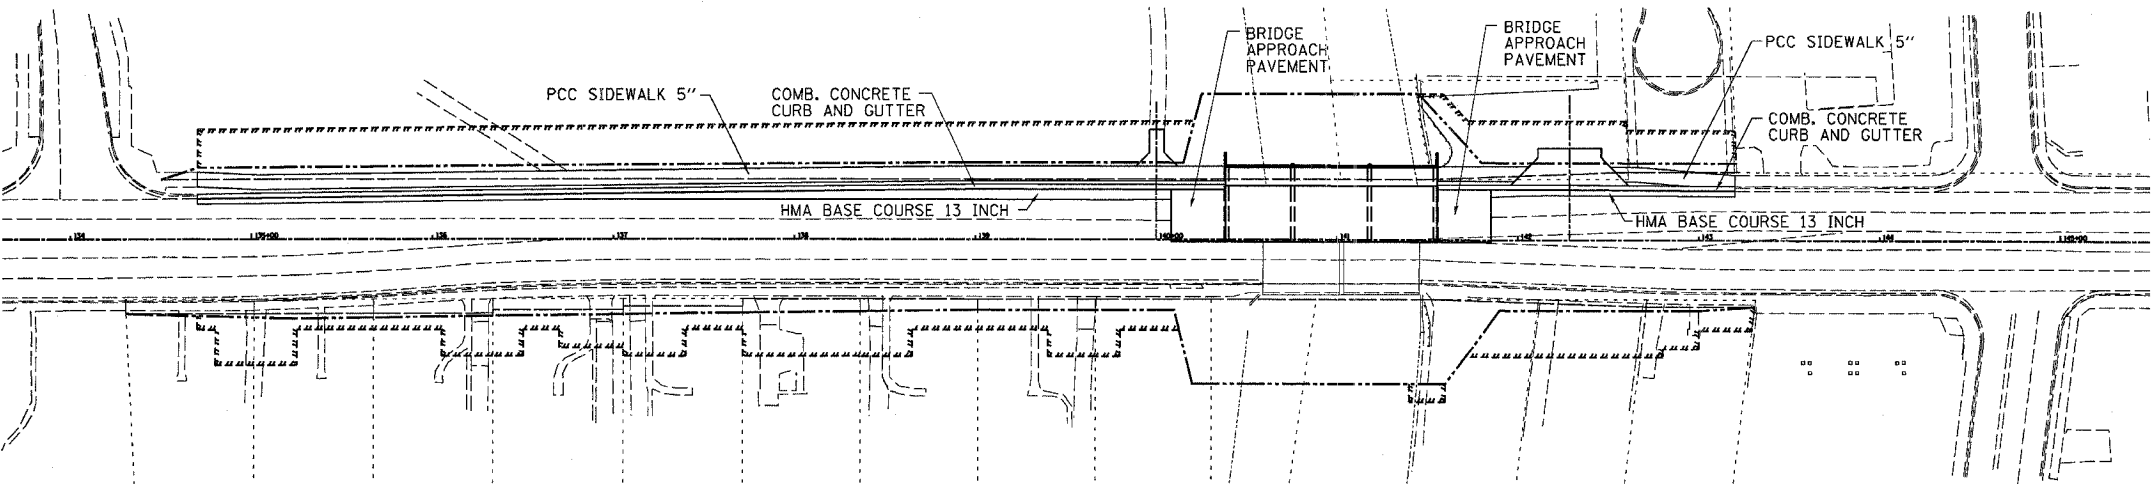

CONSTRUCTION SCHEMATIC

LEGEND

- STRUCTURE REMOVAL
- PAVEMENT REMOVAL
- IMPACT ATTENUATOR
- TYPE III BARRICADE WITH FLASHING LIGHTS
- EDGE DRUMS AT 25' CENTERS WITH STEADY BURNING LIGHTS
- TYPE C BIDIRECTIONAL REFLECTOR
- STEADY BURNING LIGHTS AND DOUBLE VERTICAL PANEL
- PROPOSED R.O.W. LINE
- TEMPORARY CONSTRUCTION EASEMENT
- TEMPORARY CONCRETE BARRIER

REVISIONS	
NAME	DATE
IDOT REVIEW	10/25/06
IDOT REVISIONS	12/13/06

ILLINOIS DEPARTMENT OF TRANSPORTATION
STAGE 1 CONSTRUCTION

FAP RTE 567 (IL RTE 38)
SECTION 34X-BR
DEKALB COUNTY

SCALE: VERT. 8/29/05
HORIZ. 8/29/05
DRAWN BY SUTHEARD
CHECKED BY BOTT

GREENE & BRADFORD, INC.
CONSULTING ENGINEERS
1000 W. WASHINGTON ST., SUITE 200
PROFESSIONAL ENGINEERING FIRM NO. 05198
PROFESSIONAL SURVEYING FIRM NO. 05198
0317-755-8844, 0317-755-2027, 911 E. WALKER
COMPUTER FILE NO. D10800STG
PROJECT 05198
10/25/06-GSJ

STAGE 1 CONSTRUCTION

PLOT DATE: 12/15/2006
FILE NAME: 06111515
PREFERENCE: 06111515
OPERATOR: 06111515