

F.A.P. RTE.	SECTION	COUNTY	TOTAL SHEETS	SHEET NO.
567	34X-BR	DEKALB	90	23
STA. 132+00		TO STA. 138+00		
FED. ROAD DIST. NO.		ILLINOIS FED. AID PROJECT		

DESIGN	INT.	DATE	REASON



PLAN	DATE	BY

PLOTS & CHECKS	INT.	DATE	NO.	REASON

PROFILE	DATE	BY

CHECKS	INT.	DATE	REASON


132+50 133+00 133+50 134+00 134+50 135+00 135+50 136+00 136+50 137+00 137+50 138+00

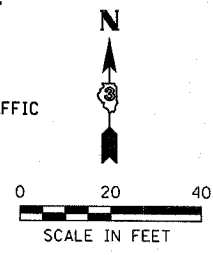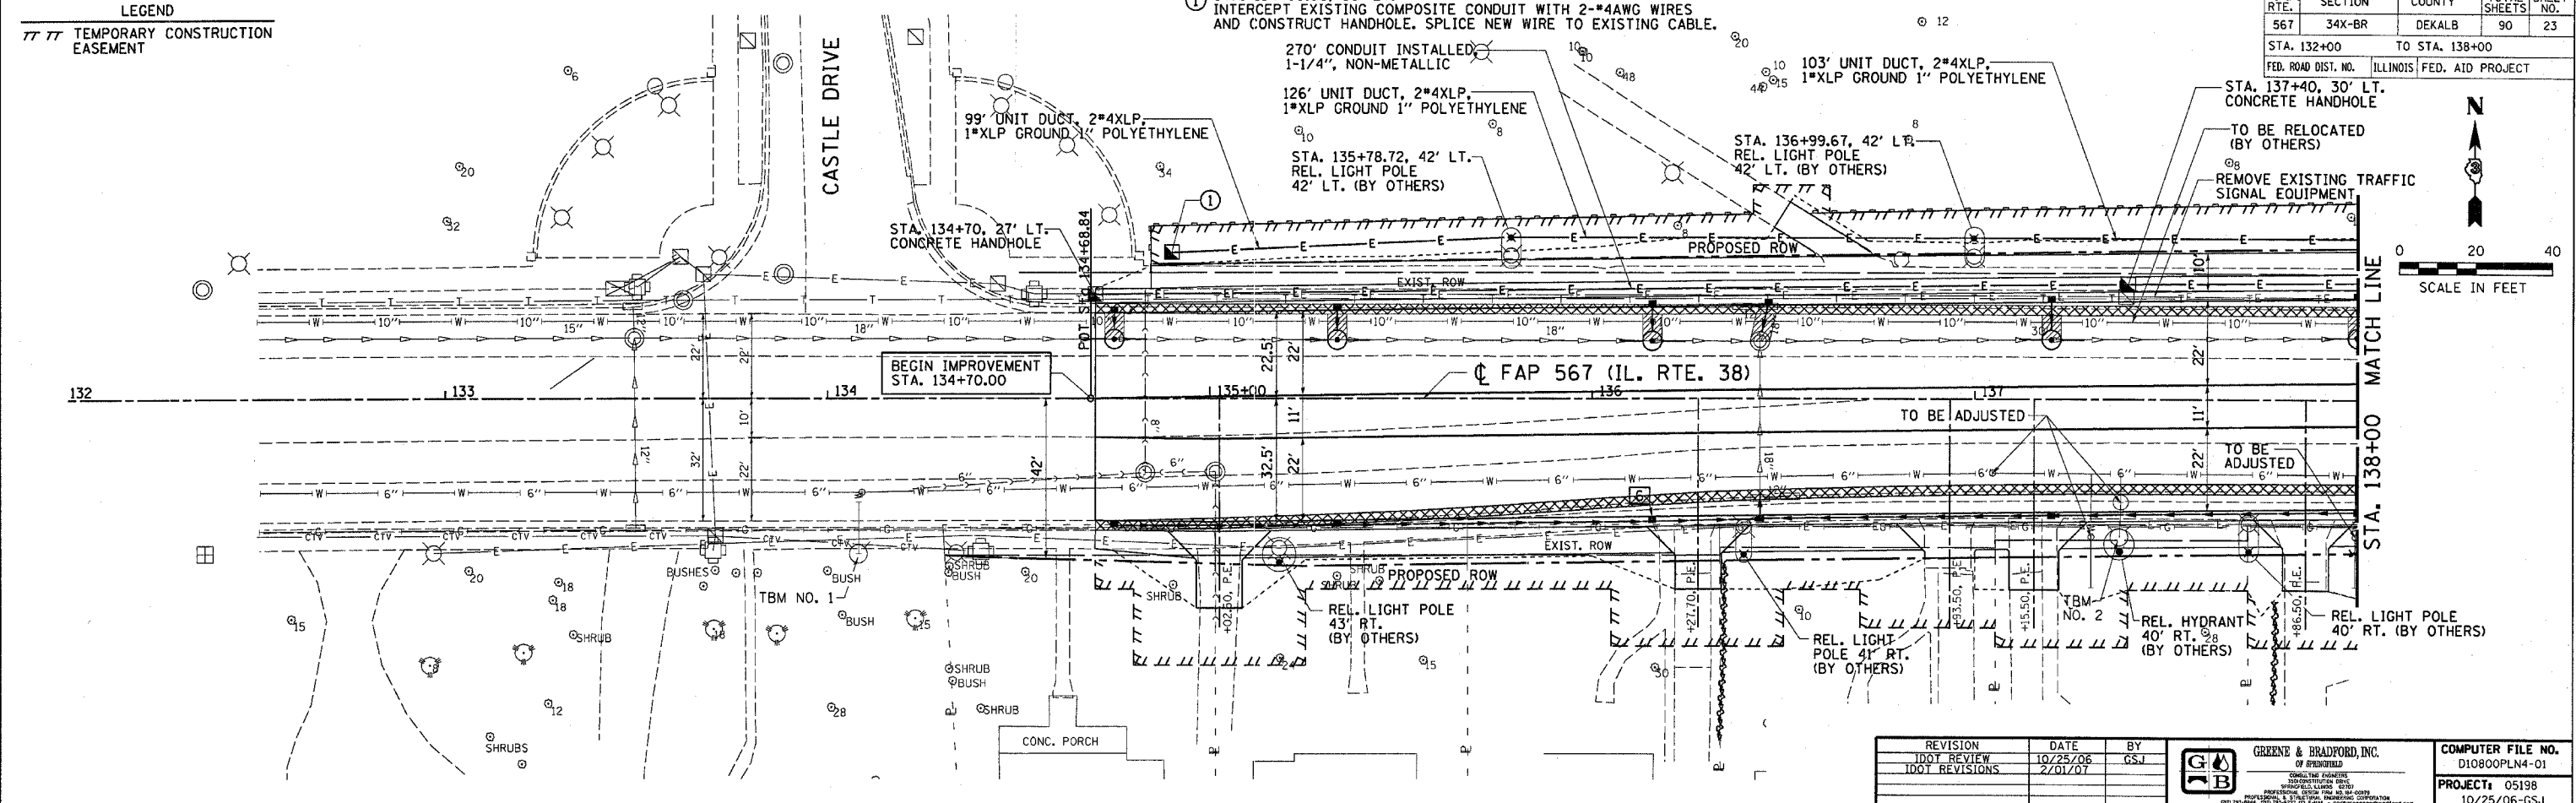

REVISION	DATE	BY

GREENE & BRADFORD, INC.
 CONSULTING ENGINEERS
 1001 N. WASHINGTON ST., SUITE 200
 DEKALB, ILLINOIS 62521

COMPUTER FILE NO. D10800PLN4-01
 PROJECT: 05198
 10/25/06-GSJ

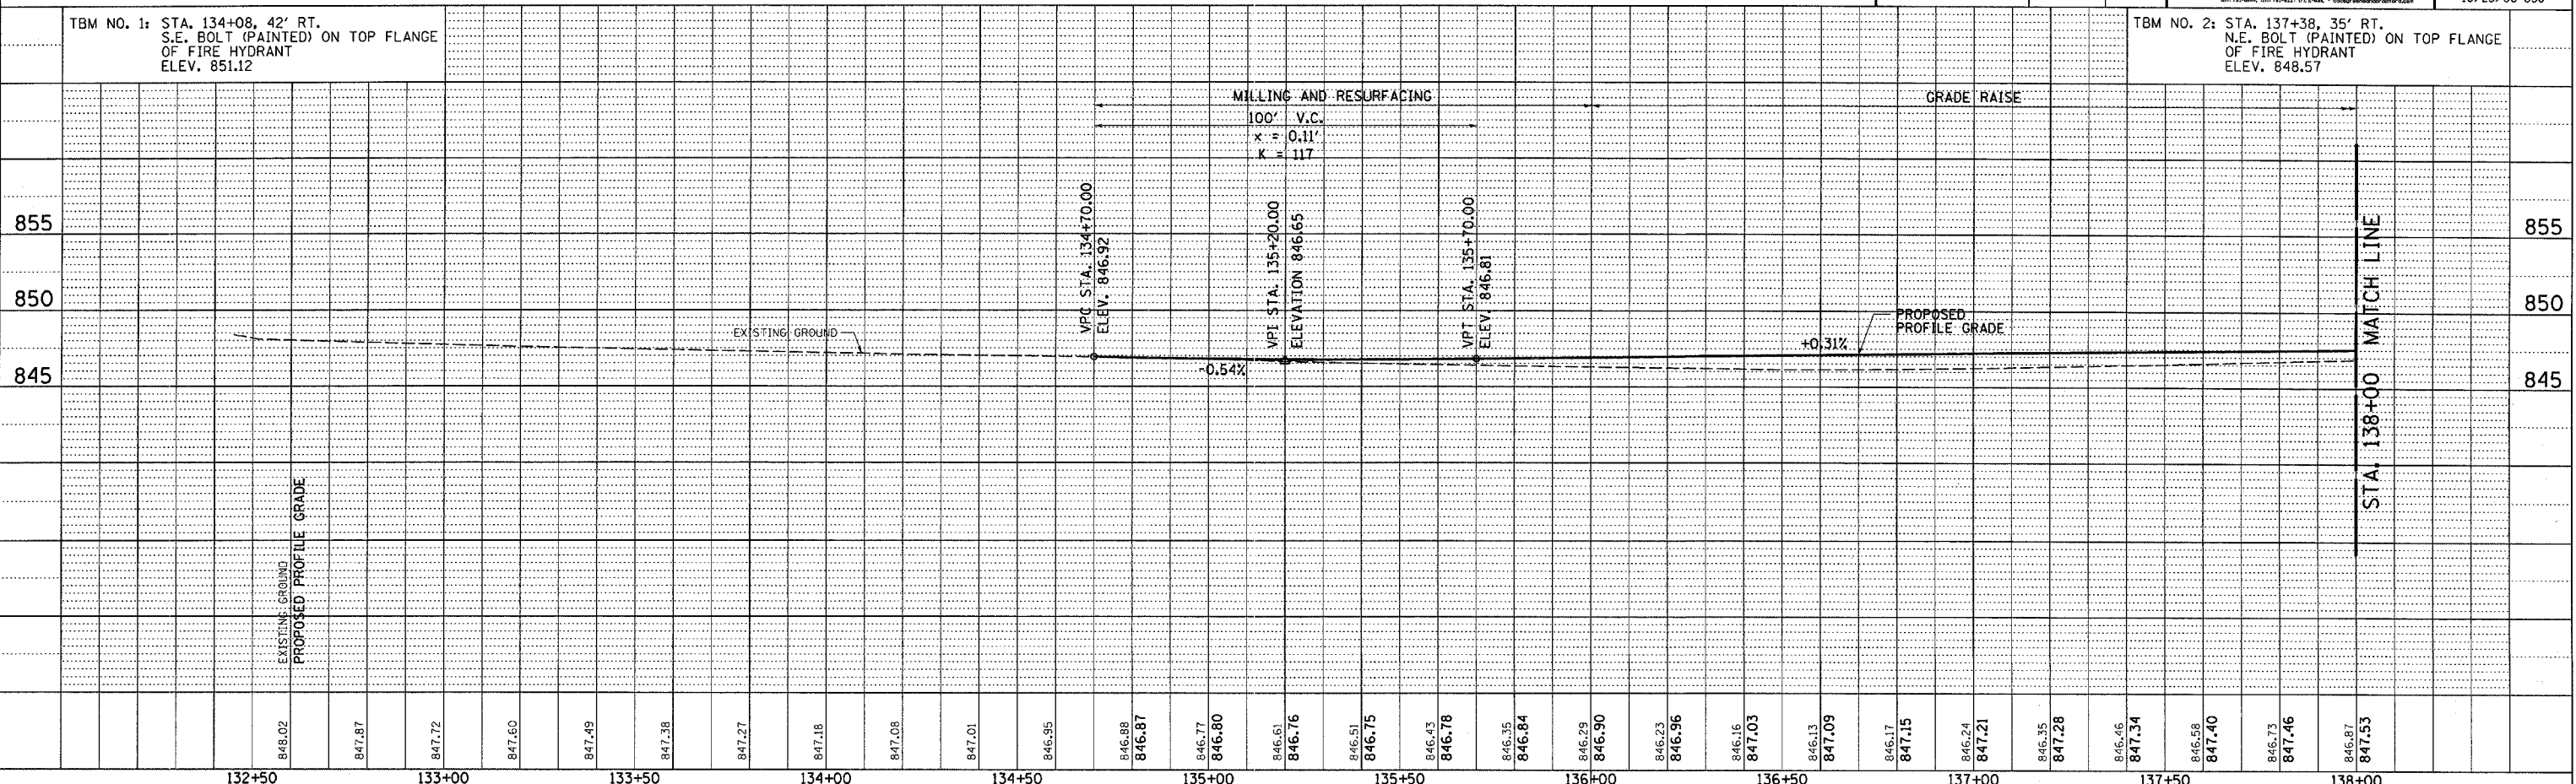

132+50 133+00 133+50 134+00 134+50 135+00 135+50 136+00 136+50 137+00 137+50 138+00

UTILITY ADJUSTMENT PLAN AND PROFILE