


F.A.P. RTE.	SECTION	COUNTY	TOTAL SHEETS	SHEET NO.
753	139B-1	SANGAMON	39	1
FED. ROAD DIST. NO.		ILLINOIS	FED. AID PROJECT	

+3  
-42 sheets

STATE OF ILLINOIS  
DEPARTMENT OF TRANSPORTATION  
DIVISION OF HIGHWAYS  
**PROPOSED  
HIGHWAY PLANS**

F.A.P. ROUTE 753 (IL RTE 104)  
SECTION 139B-1  
PROJECT: F-0753(030)  
BRIDGE REPLACEMENT  
SANGAMON COUNTY  
C - 96-503-08

D-96-558-02

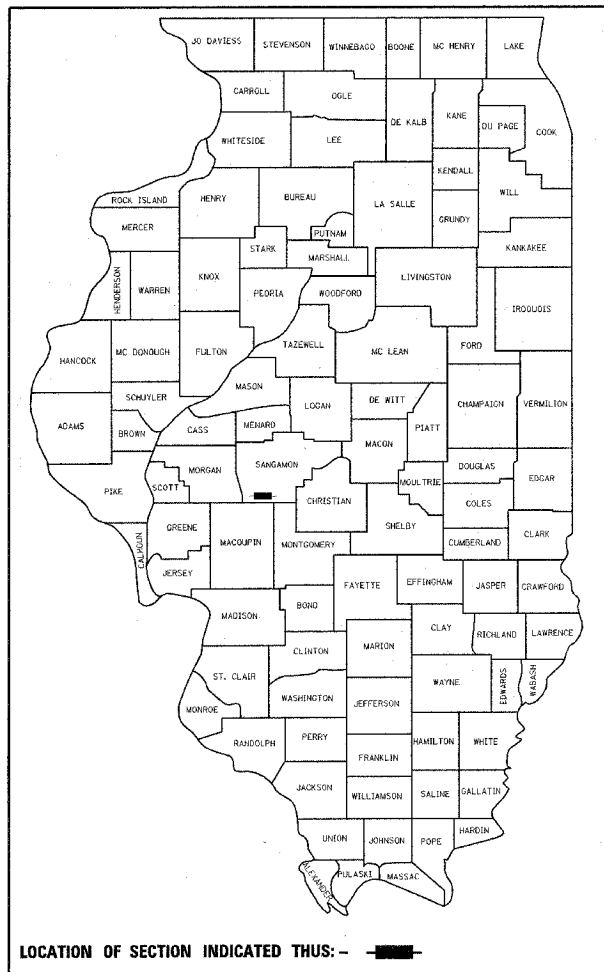


**INDEX OF SHEETS**

- 1 COVER SHEET
- 2 GENERAL NOTES & HIGHWAY STANDARDS
- 3-3C SUMMARY OF QUANTITIES
- 4 EXISTING TYPICAL SECTION
- 5 PROPOSED TYPICAL SECTIONS
- 6 SCHEDULE OF QUANTITIES
- 7 PLAN AND PROFILE SHEET
- 8-9 ~~STAGE CONSTRUCTION PLANS~~
- 9A ~~MAXIMUM WIDTH SIGNING~~
- 10-14 STORM WATER POLLUTION PREVENTION PLAN
- 15-21 PROPOSED CULVERT PLANS
- 22-26 ROADWAY DETAILS
- 27 TEMP. TRAFFIC SIGNAL LOOP DETAILS
- 28-37 ROADWAY CROSS SECTIONS
- 38-39 CHANNEL CROSS SECTIONS

**ROADWAY CLASSIFICATION**


F.A.P. 753 (IL 104) - MINOR ARTERIAL  
ADT 2700 (2001) - MU 7%  
CRS 9.0 - RESURFACED 2002

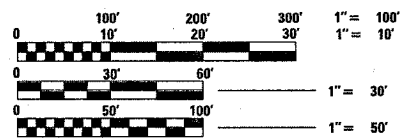

SCALES  
PLAN 1" = 50'  
PROFILE HORIZ. 1" = 50'  
PROFILE VERT. 1" = 5'  
CROSS SECTIONS 1" = 10'  
1" = 5'

FULL SIZE PLANS HAVE BEEN PREPARED USING STANDARD ENGINEERING SCALES, REDUCED SIZED PLANS WILL NOT CONFORM TO STANDARD SCALES, IN MAKING MEASUREMENTS ON REDUCED PLANS, THE ABOVE SCALES MAY BE USED.


FOR UNDERGROUND UTILITY LOCATIONS CALL J.U.L.I.E. TOLL FREE 1-800-892-0123 TALKINGTON TOWNSHIP

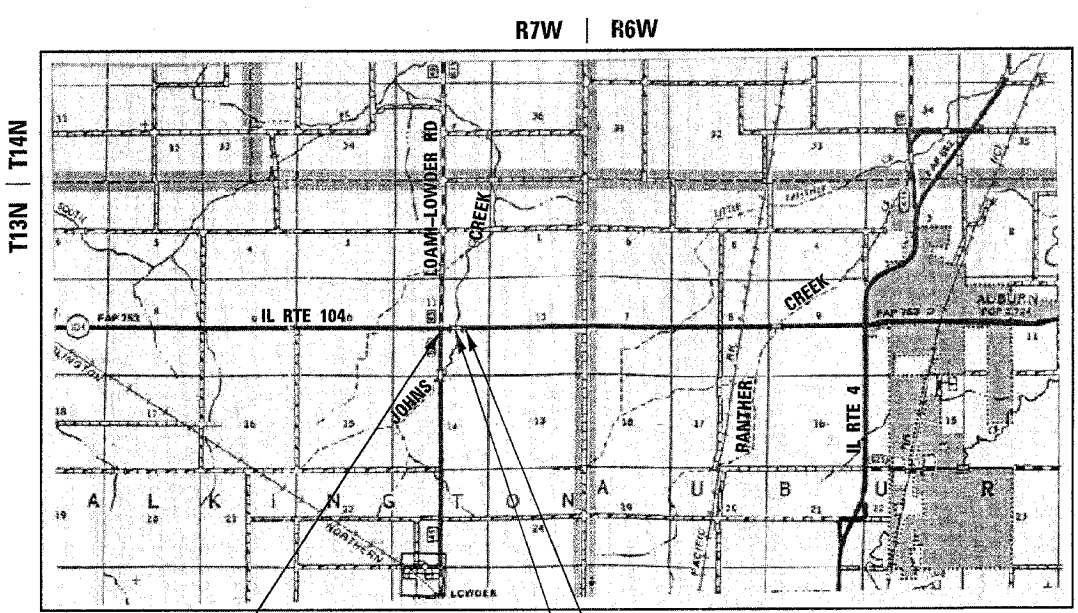

PROJECT BEGINS  
STA. 227 + 50.00

PROJECT ENDS  
STA. 235 + 50.00

 SN 084-2507  
STA. 231 + 81.00  
PCBC TRIPLE  
10' SPAN x 11' RISE



GROSS AND NET LENGTH OF PROJECT = 0.15 MILES

STATE OF ILLINOIS  
DEPARTMENT OF TRANSPORTATION  
DIVISION OF HIGHWAYS

SUBMITTED December 13, 2006  
Chris M. Reed  
DEPUTY DIRECTOR OF HIGHWAYS, REGION ENGINEER

February 2, 2007  
Eric E. Horn  
SENIOR ENGINEER OF DESIGN AND ENVIRONMENT

February 2, 2007  
Milton R. Sees, P.E.  
DIRECTOR, DIVISION OF HIGHWAYS

PROJECT ENGINEER: SAL MADONIA (217) 782-4761  
SQUAD LEADER: MARCUS BRUCE (217) 785-5336

CONTRACT NO. 72689