

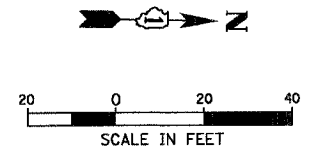


F.A.U. RT#	SECTION	COUNTY	TOTAL SHEETS	SHEET NO.
1389	99-00062-00-PV	DUPAGE	199	92
CONTRACT NO. 83873				
FED. ROAD DIST. NO. ILLINOIS FED. AID PROJECT				

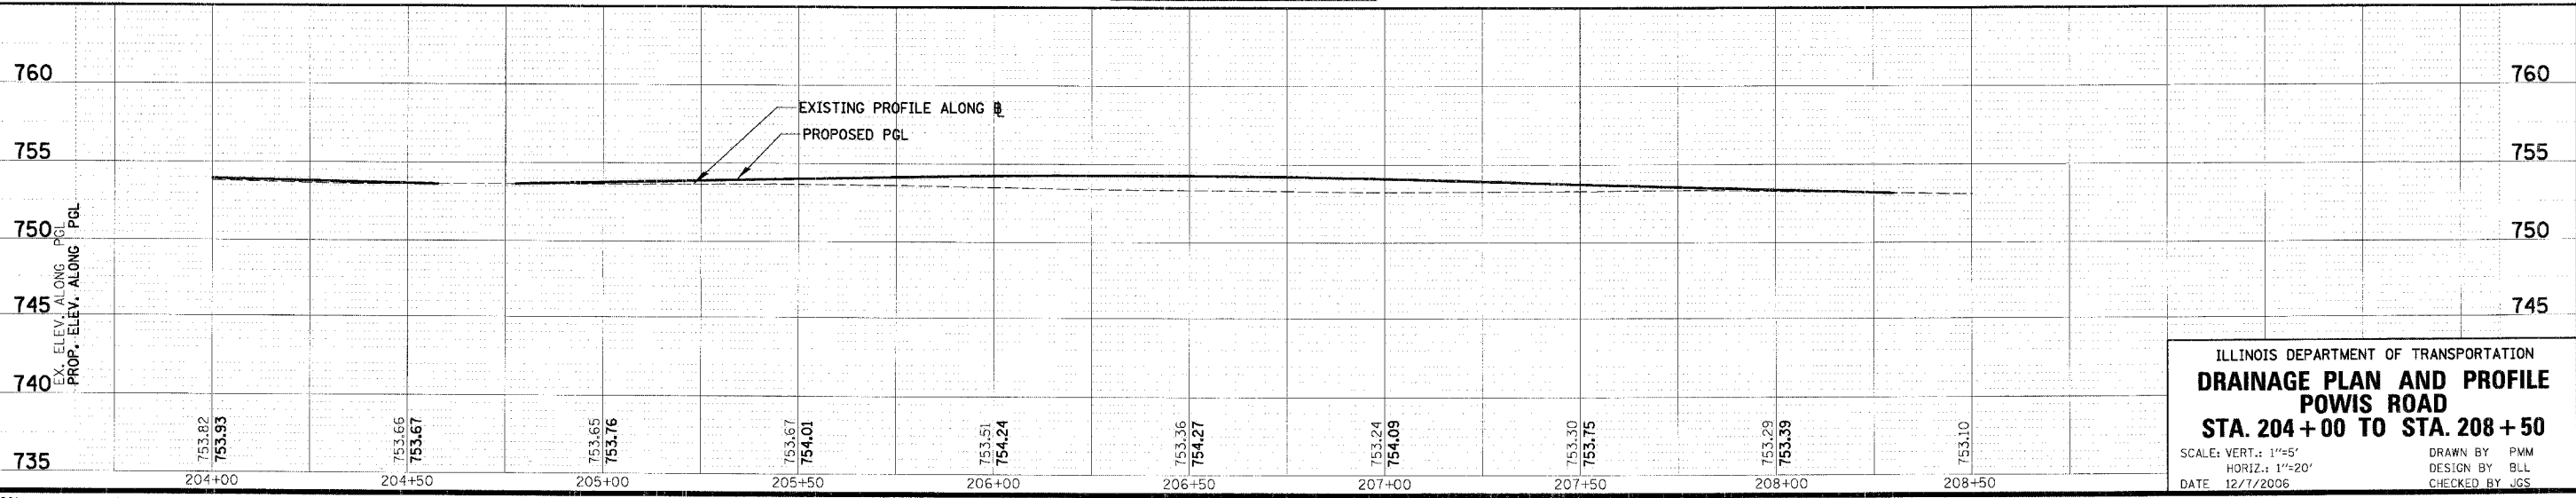

DATE	BY	DATE	BY

DATE	BY	DATE	BY

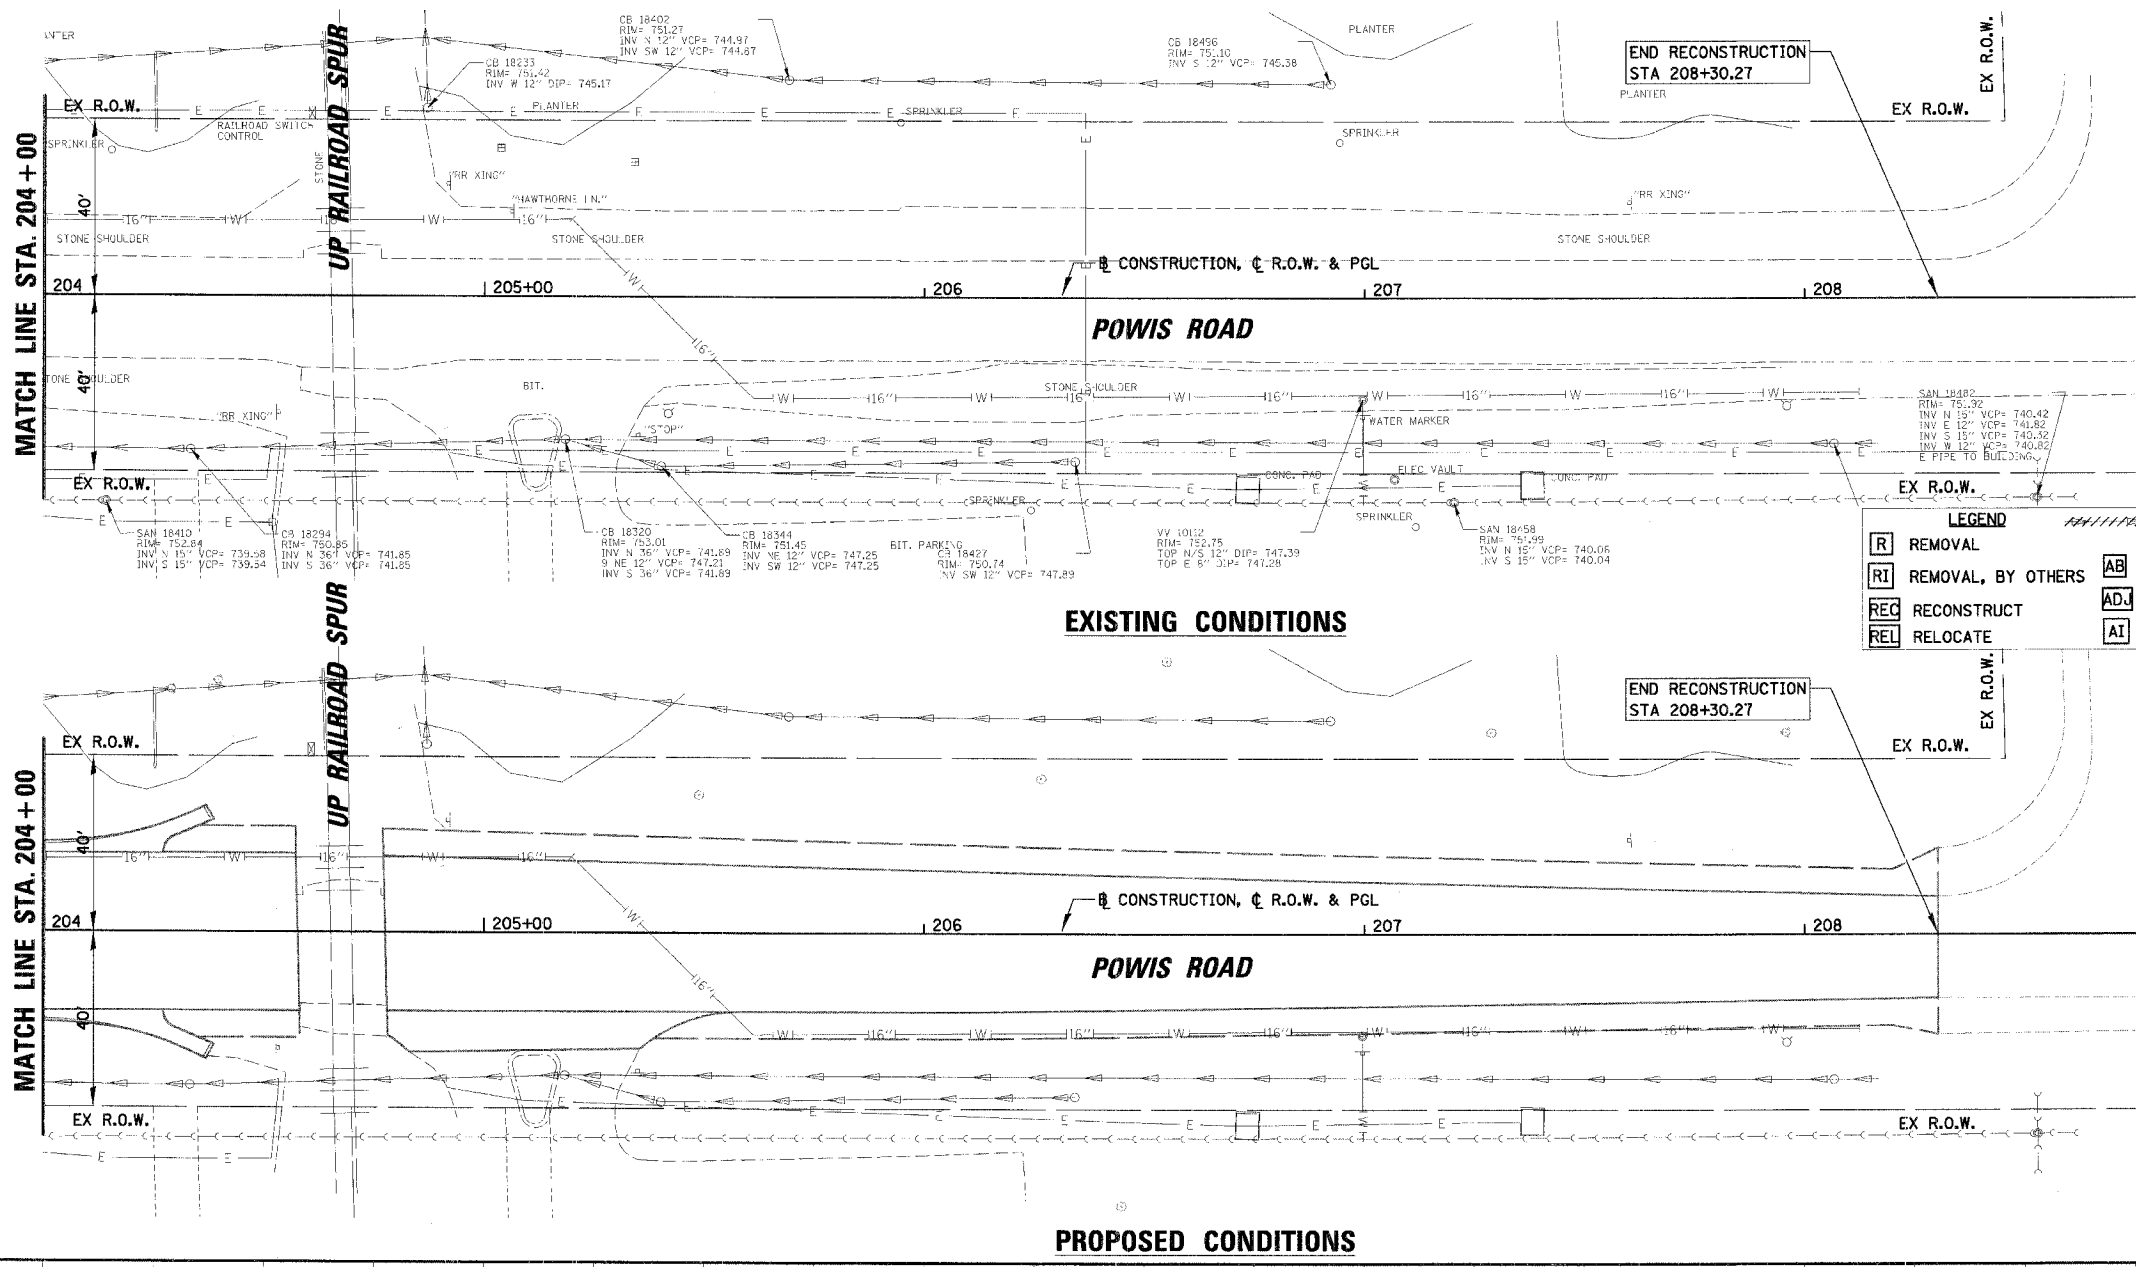

ILLINOIS DEPARTMENT OF TRANSPORTATION
DRAINAGE PLAN AND PROFILE
POWIS ROAD
STA. 204 + 00 TO STA. 208 + 50
 SCALE: VERT.: 1"=5'
 HORIZ.: 1"=20'
 DATE: 12/7/2006
 DRAWN BY: PWM
 DESIGN BY: BLL
 CHECKED BY: JGS

N:\westch\04479\04479.tbl

n:\westch\04479\drain\04479_20_pow.dpp