 



SEE SHEET NO. 45

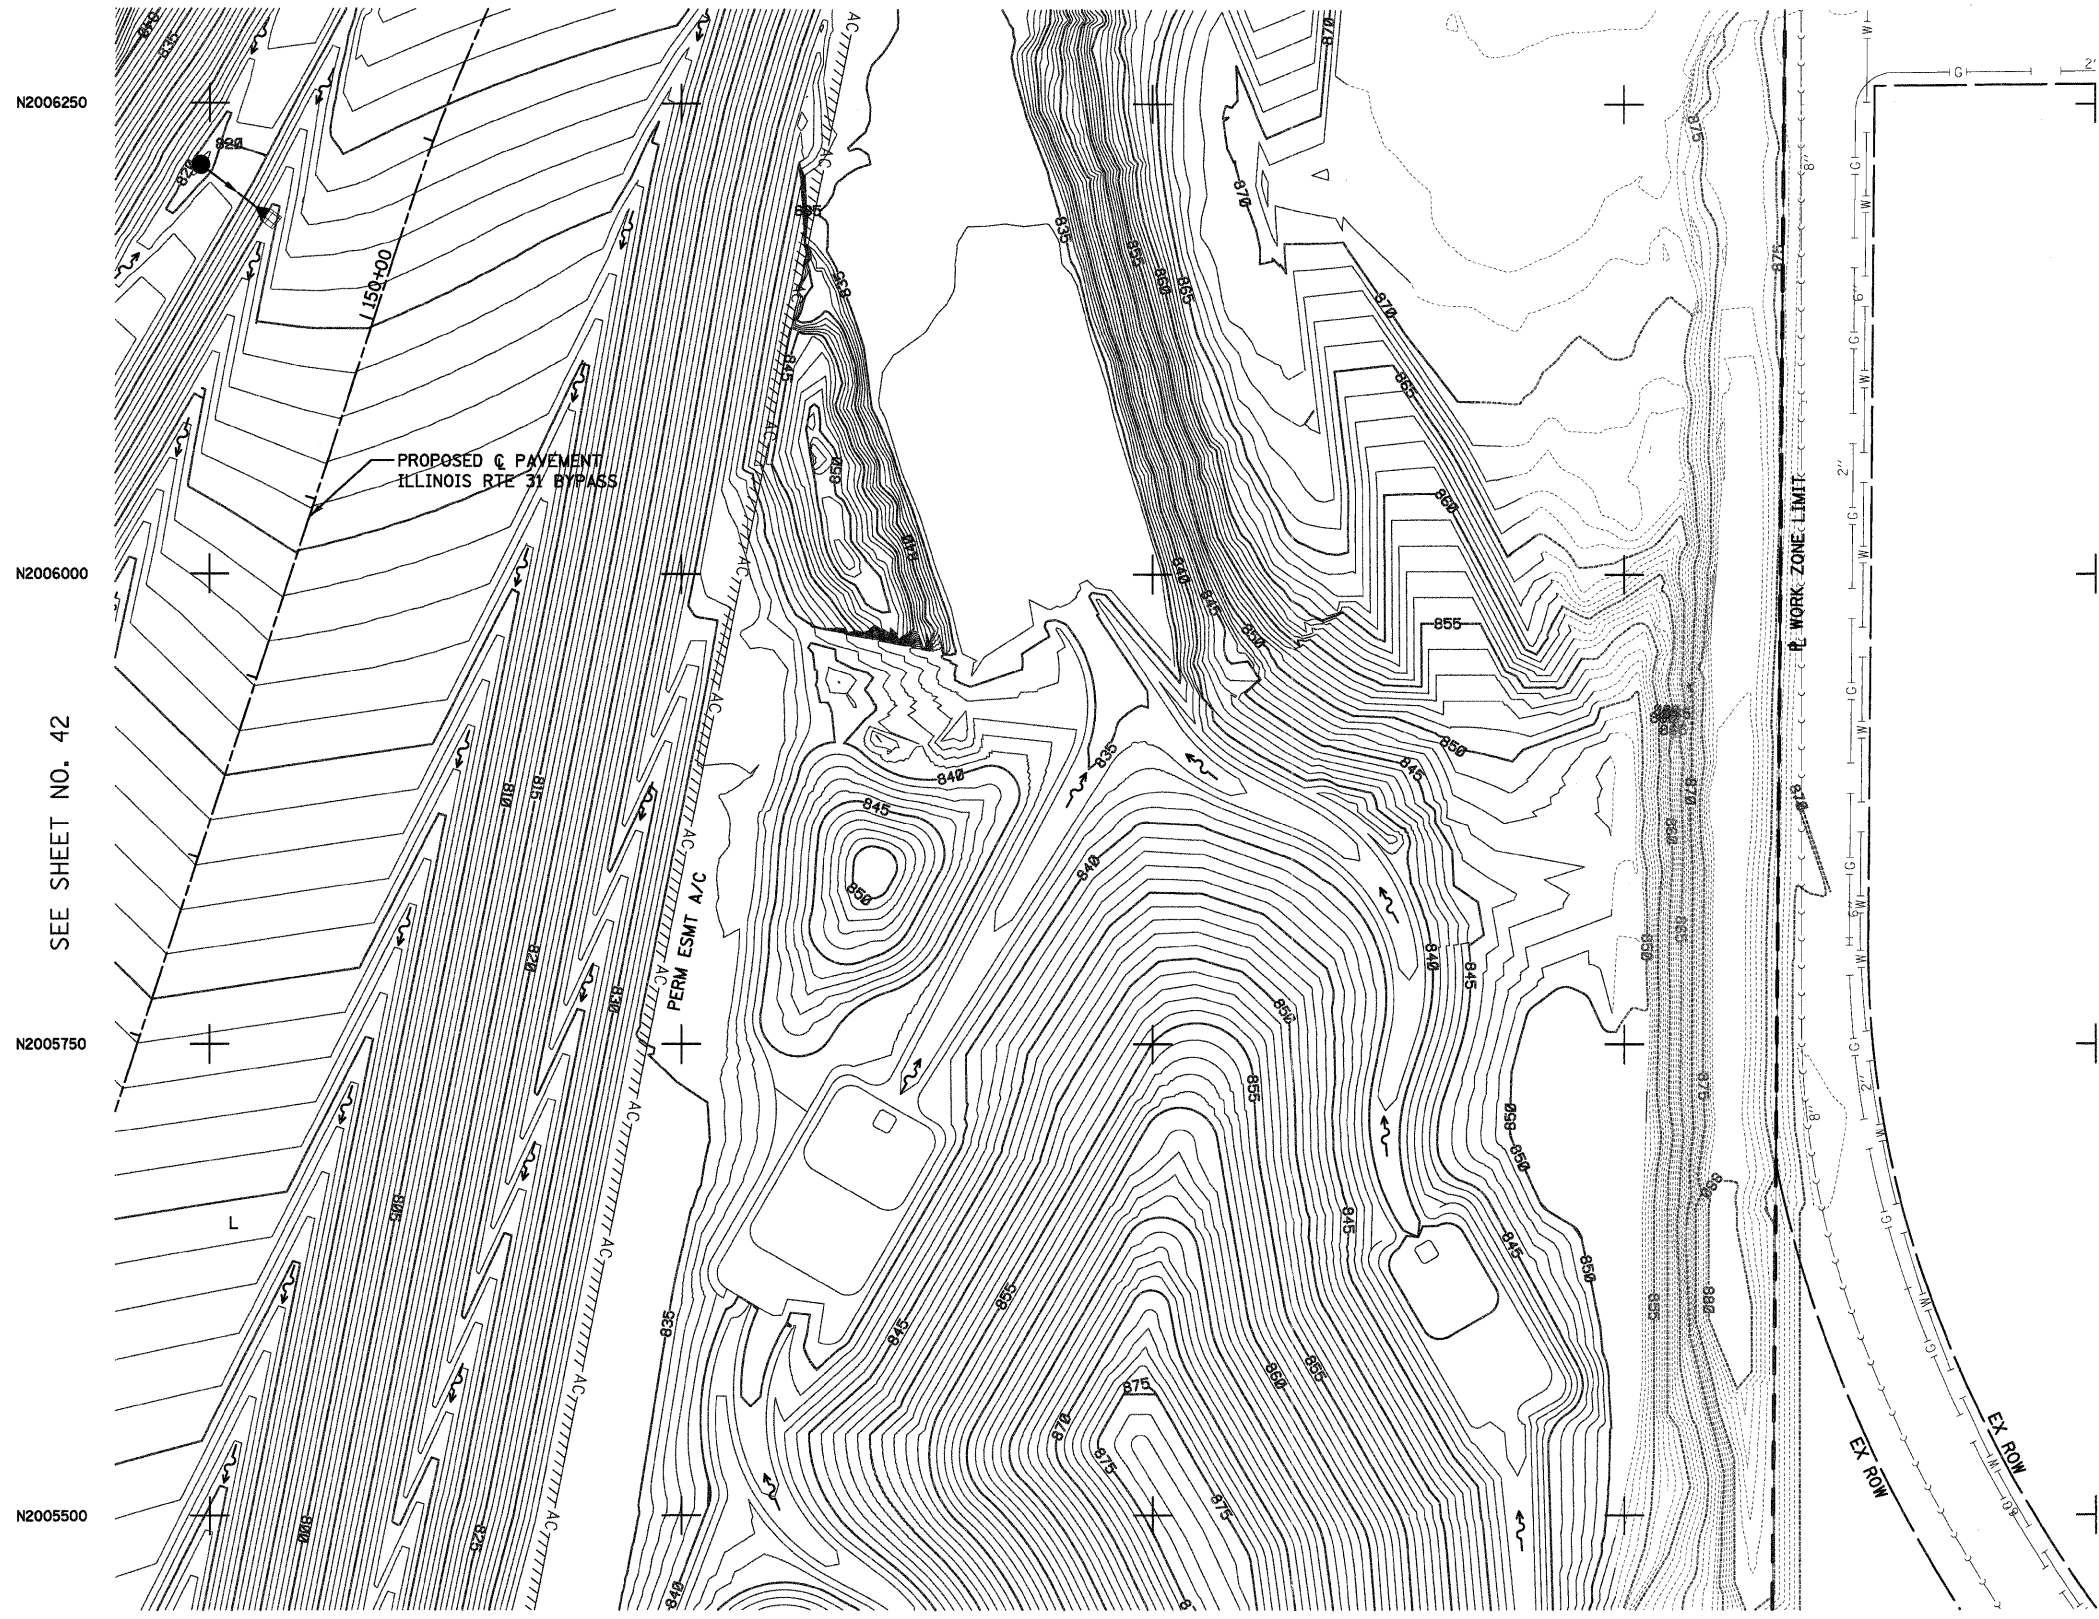

SEE SHEET NO. 41

FILE NAME =
...\\D162F78-sh1-d-esn-26.dgn

USER NAME = ctb
DESIGNED - DTE
DRAWN - DTE
PLOT SCALE = 600.0000' / Ft.
CHECKED - GAB
PLOT DATE = 1/16/2012
DATE - 1/20/2012

REVISED -
REVISED -
REVISED -
REVISED -

**STATE OF ILLINOIS
DEPARTMENT OF TRANSPORTATION**

DRAINAGE PLAN

SCALE: 1" = 50' SHEET NO. 7 OF 13 SHEETS STA. TO STA.

F.A. RTE.	SECTION	COUNTY	TOTAL SHEETS	SHEET NO.
	18A-1	McHENRY	115	43
CONTRACT NO. 60F78			ILLINOIS FED. AID PROJECT	